


Carriage House Studio
 architects
 144 Vaughan Street · Portland, Maine · 207-318-0731
 www.carriagehousestudio.com

FOUNDATION PLAN
 FLOOR PLAN
 ROOF PLAN
 BUILDING SECTIONS


Addition & Site Improvements to
 395 Spring Street
 Portland, Maine

30 MAR 2011


A 2

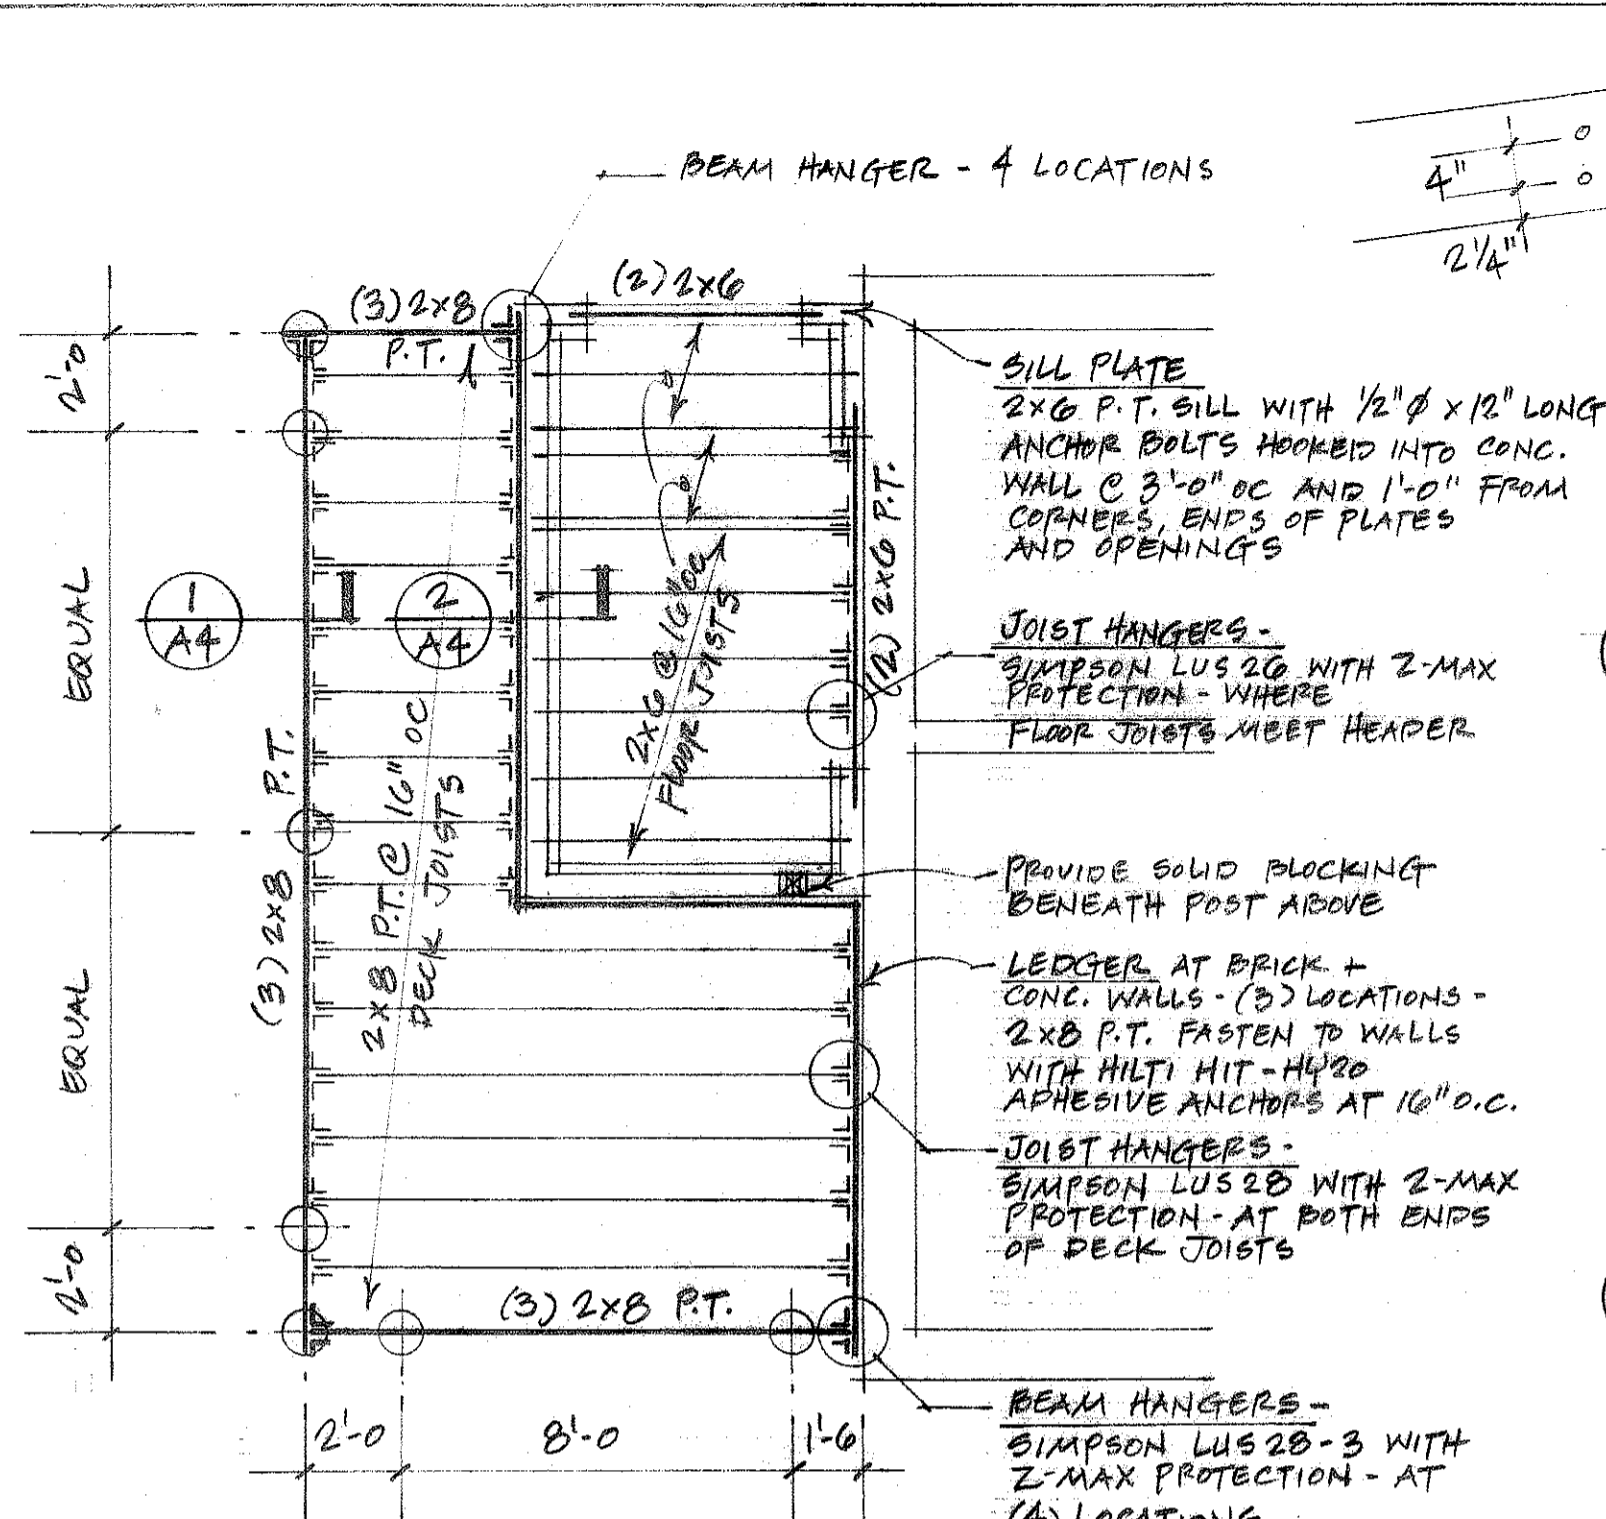

① FIRST FLOOR FRAMING PLAN.
1/4" = 1'-0"

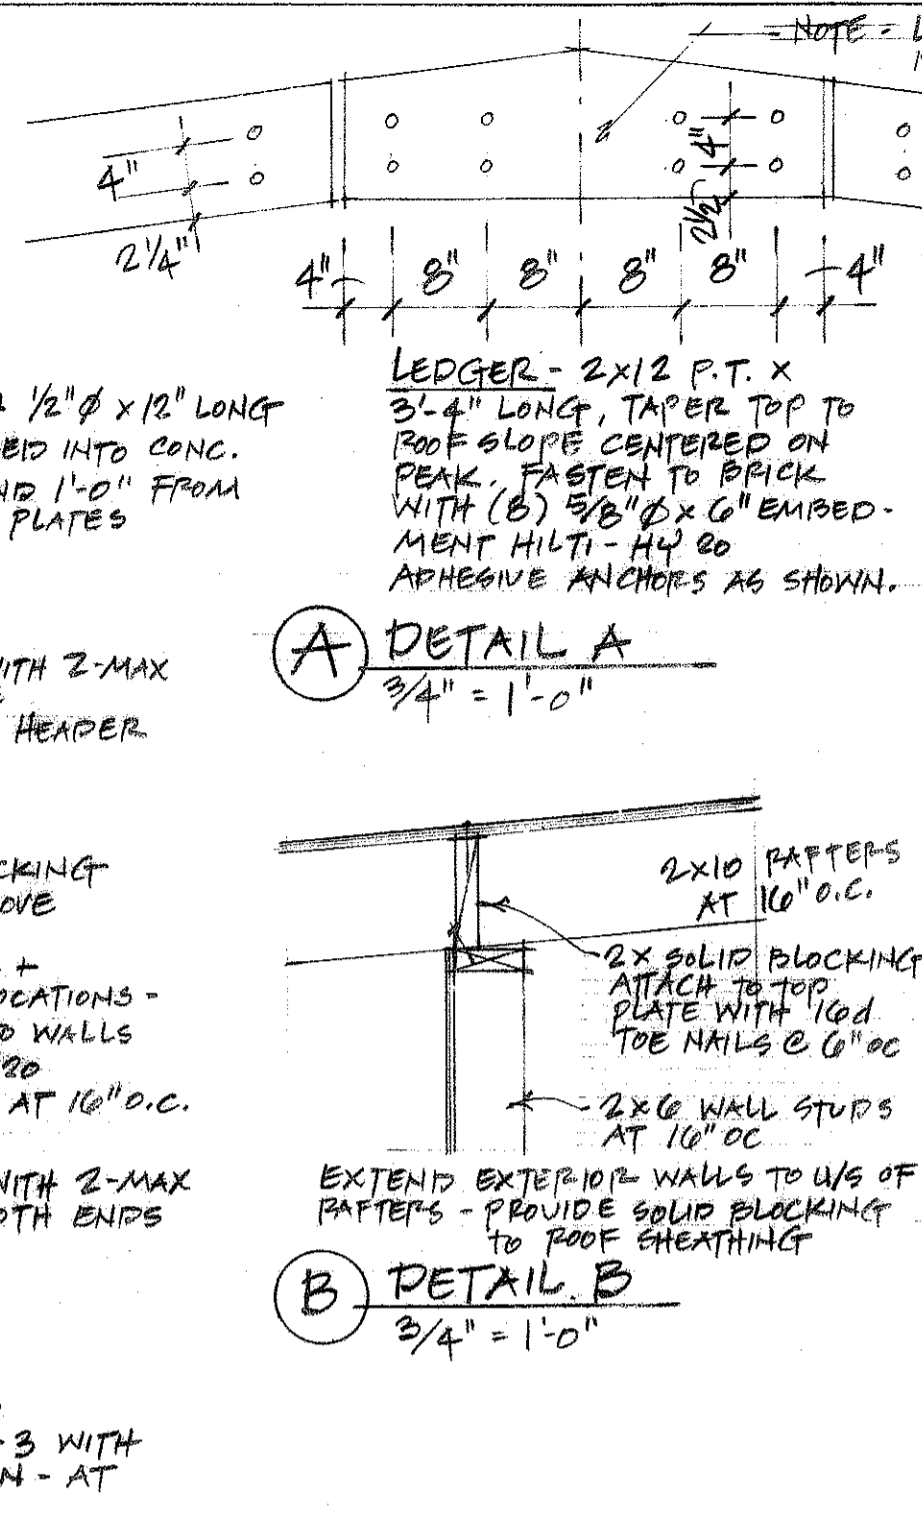


② ROOF FRAMING PLAN.
1/4" = 1'-0"

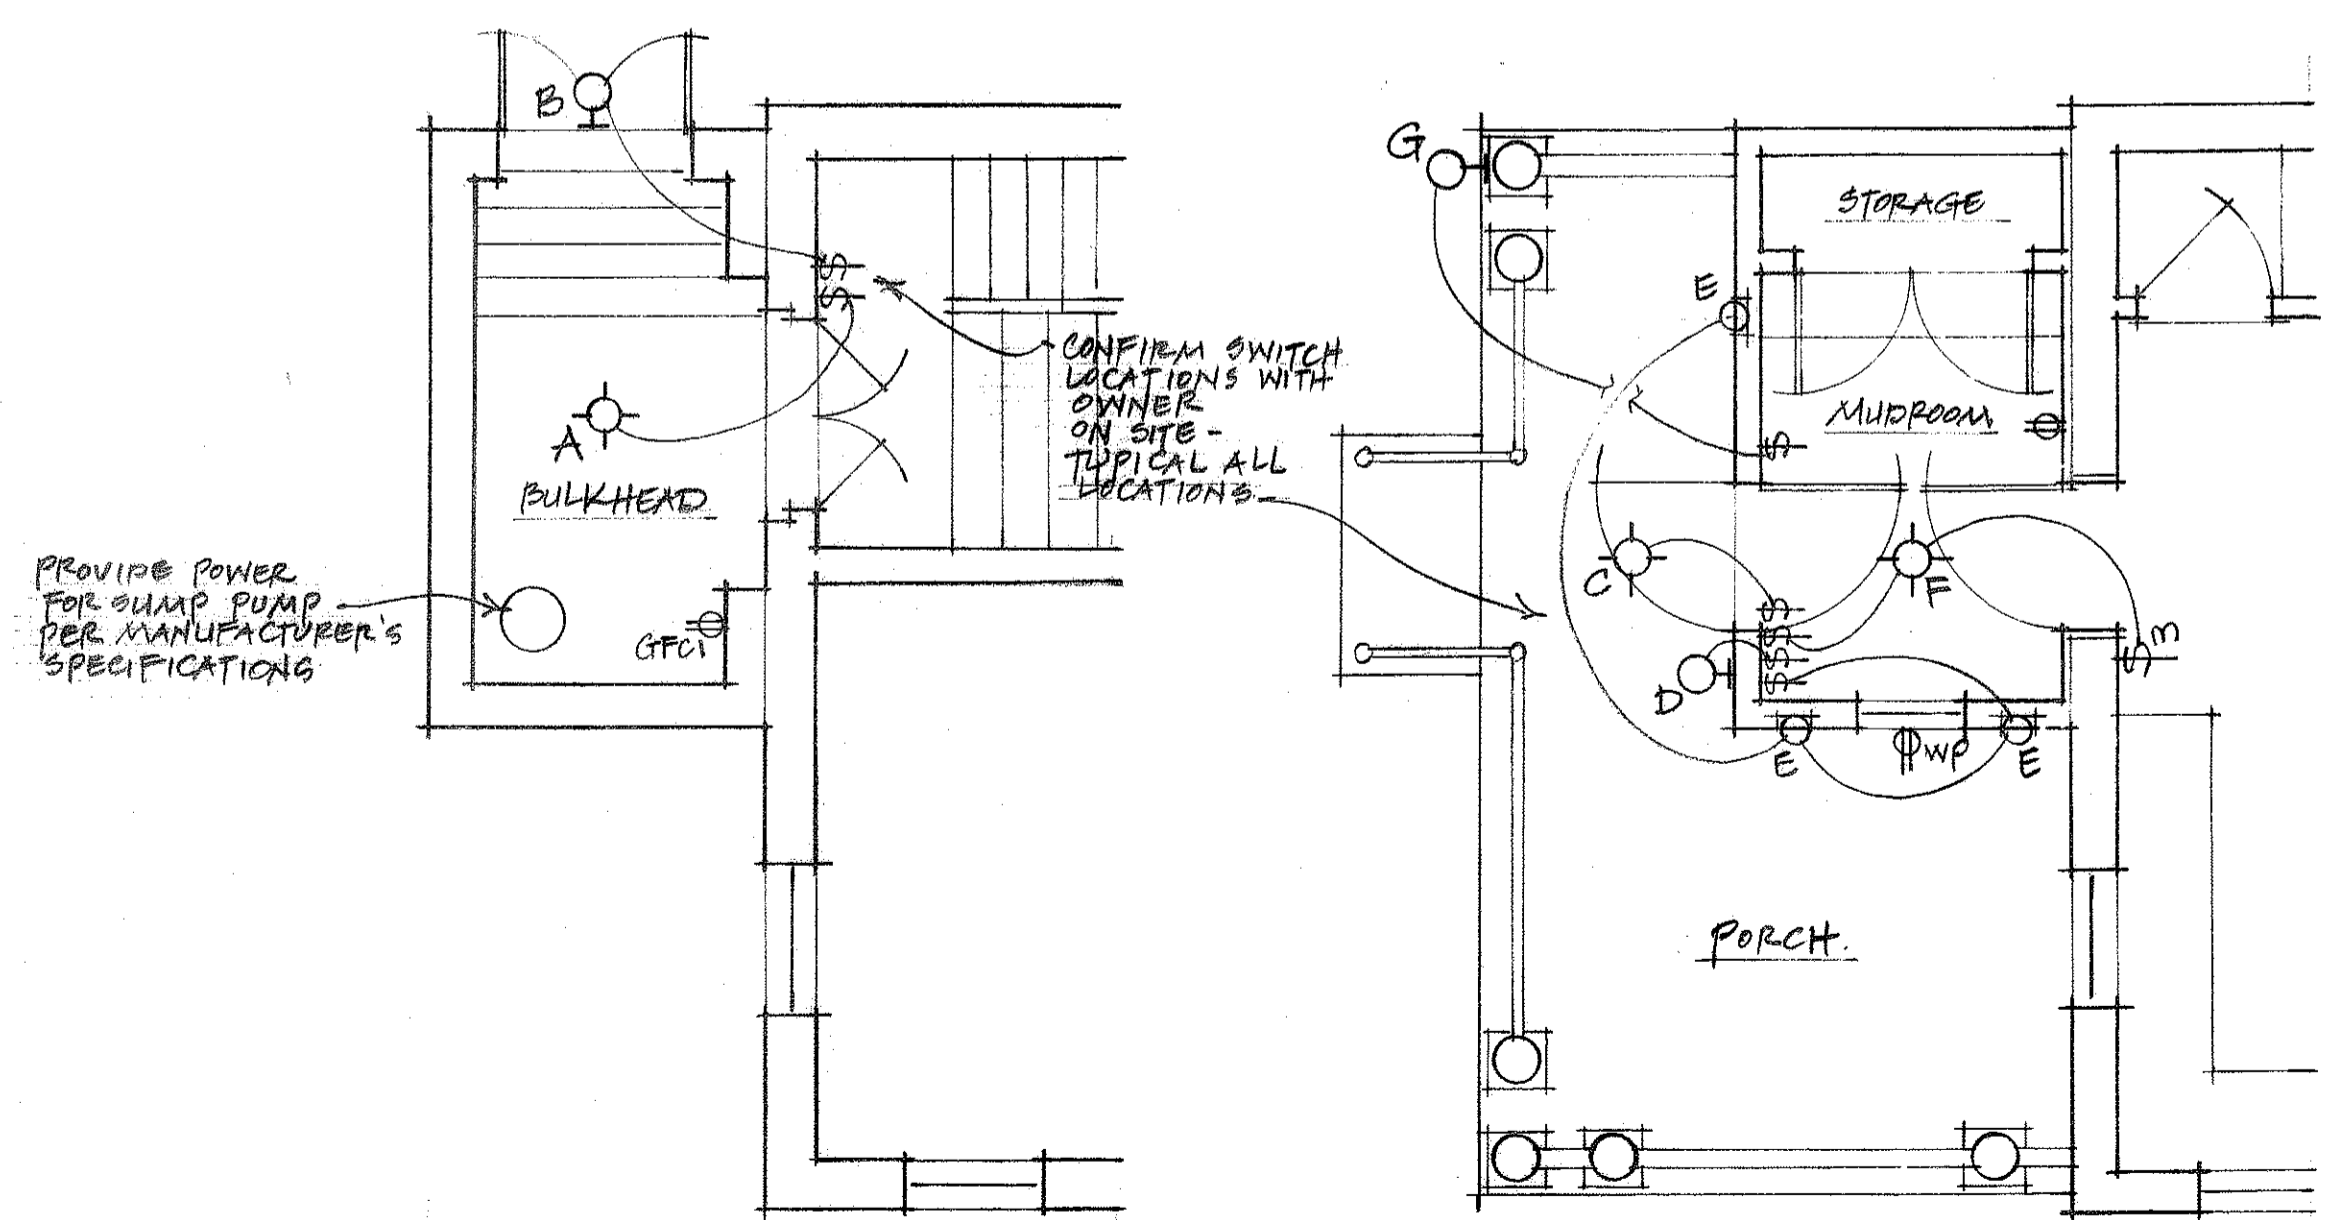

③ BASEMENT ELECTRICAL PLAN
1/4" = 1'-0"

④ FIRST FLOOR ELECTRICAL PLAN
1/4" = 1'-0"

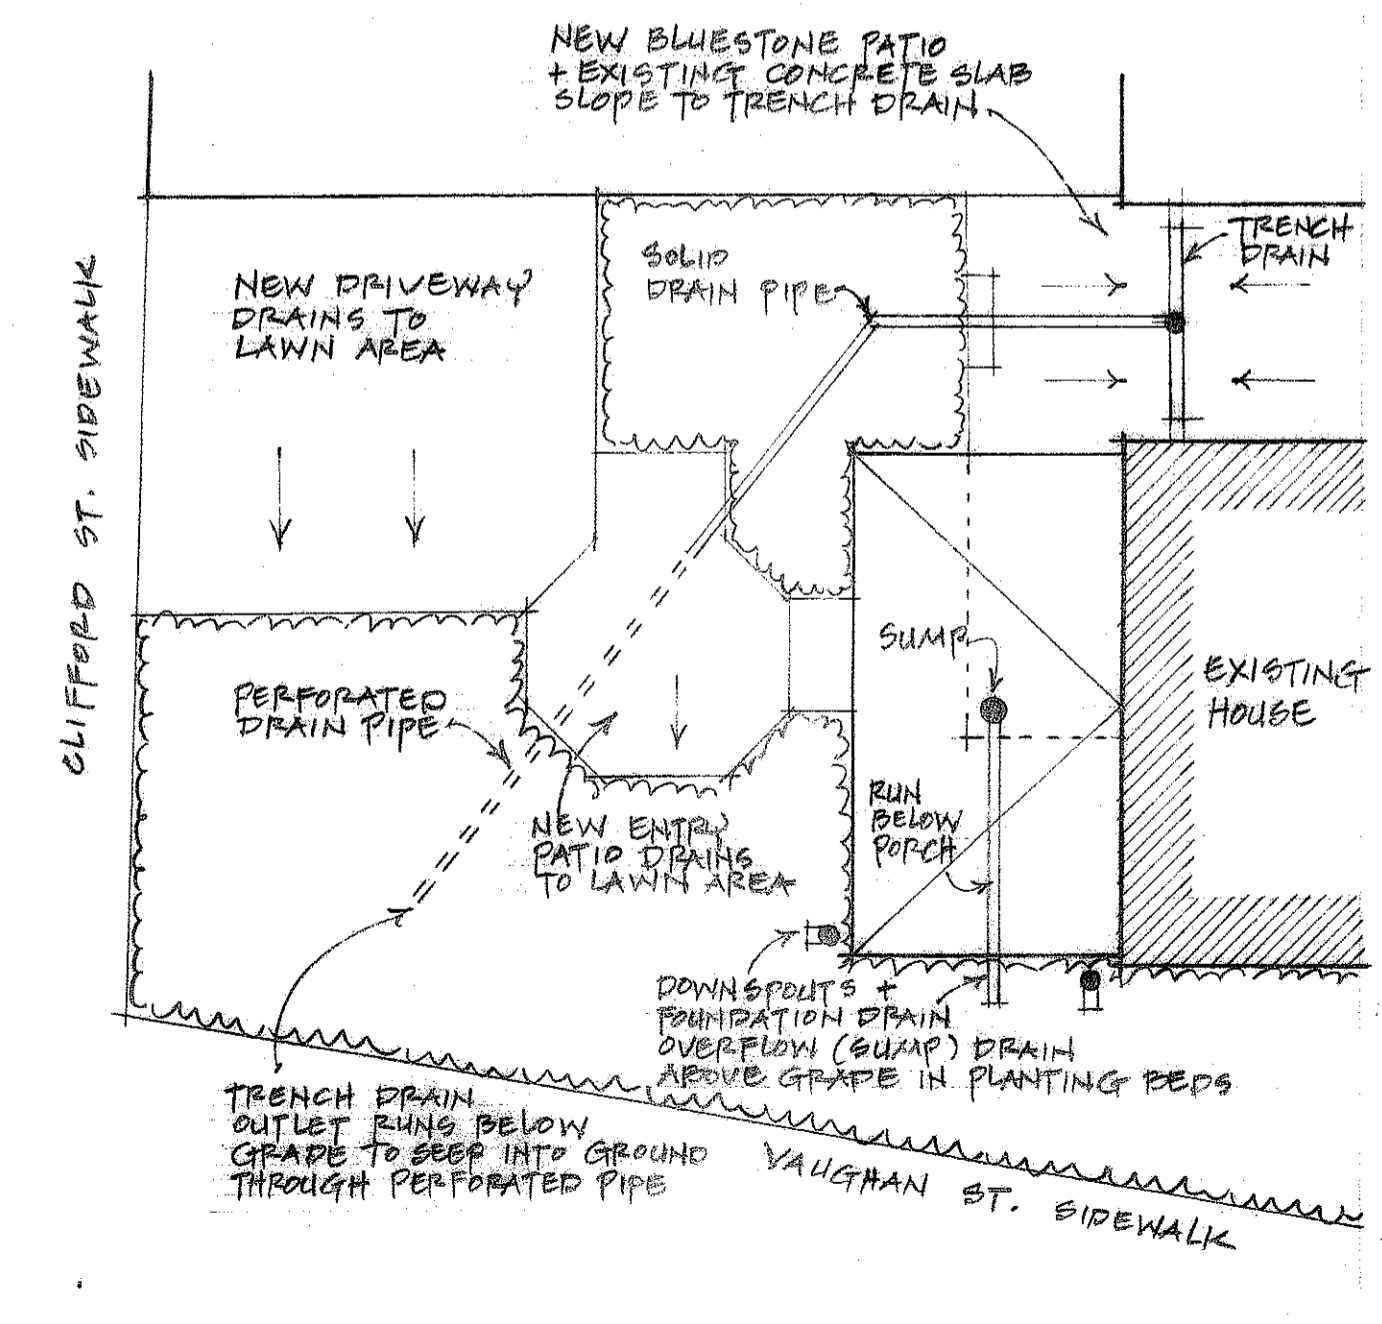

⑤ SITE DRAINAGE PLAN
NO SCALE


Carriage House Studio
architects
144 Vaughan Street, Portland, Maine, 207-318-0731
www.carriagehousestudio.com

STRUCTURAL PLANS
ELECTRICAL PLANS
SITE DRAINAGE PLAN


Addition & Site Improvements to
395 Spring Street
Portland, Maine

30 MAR 2011

A 3

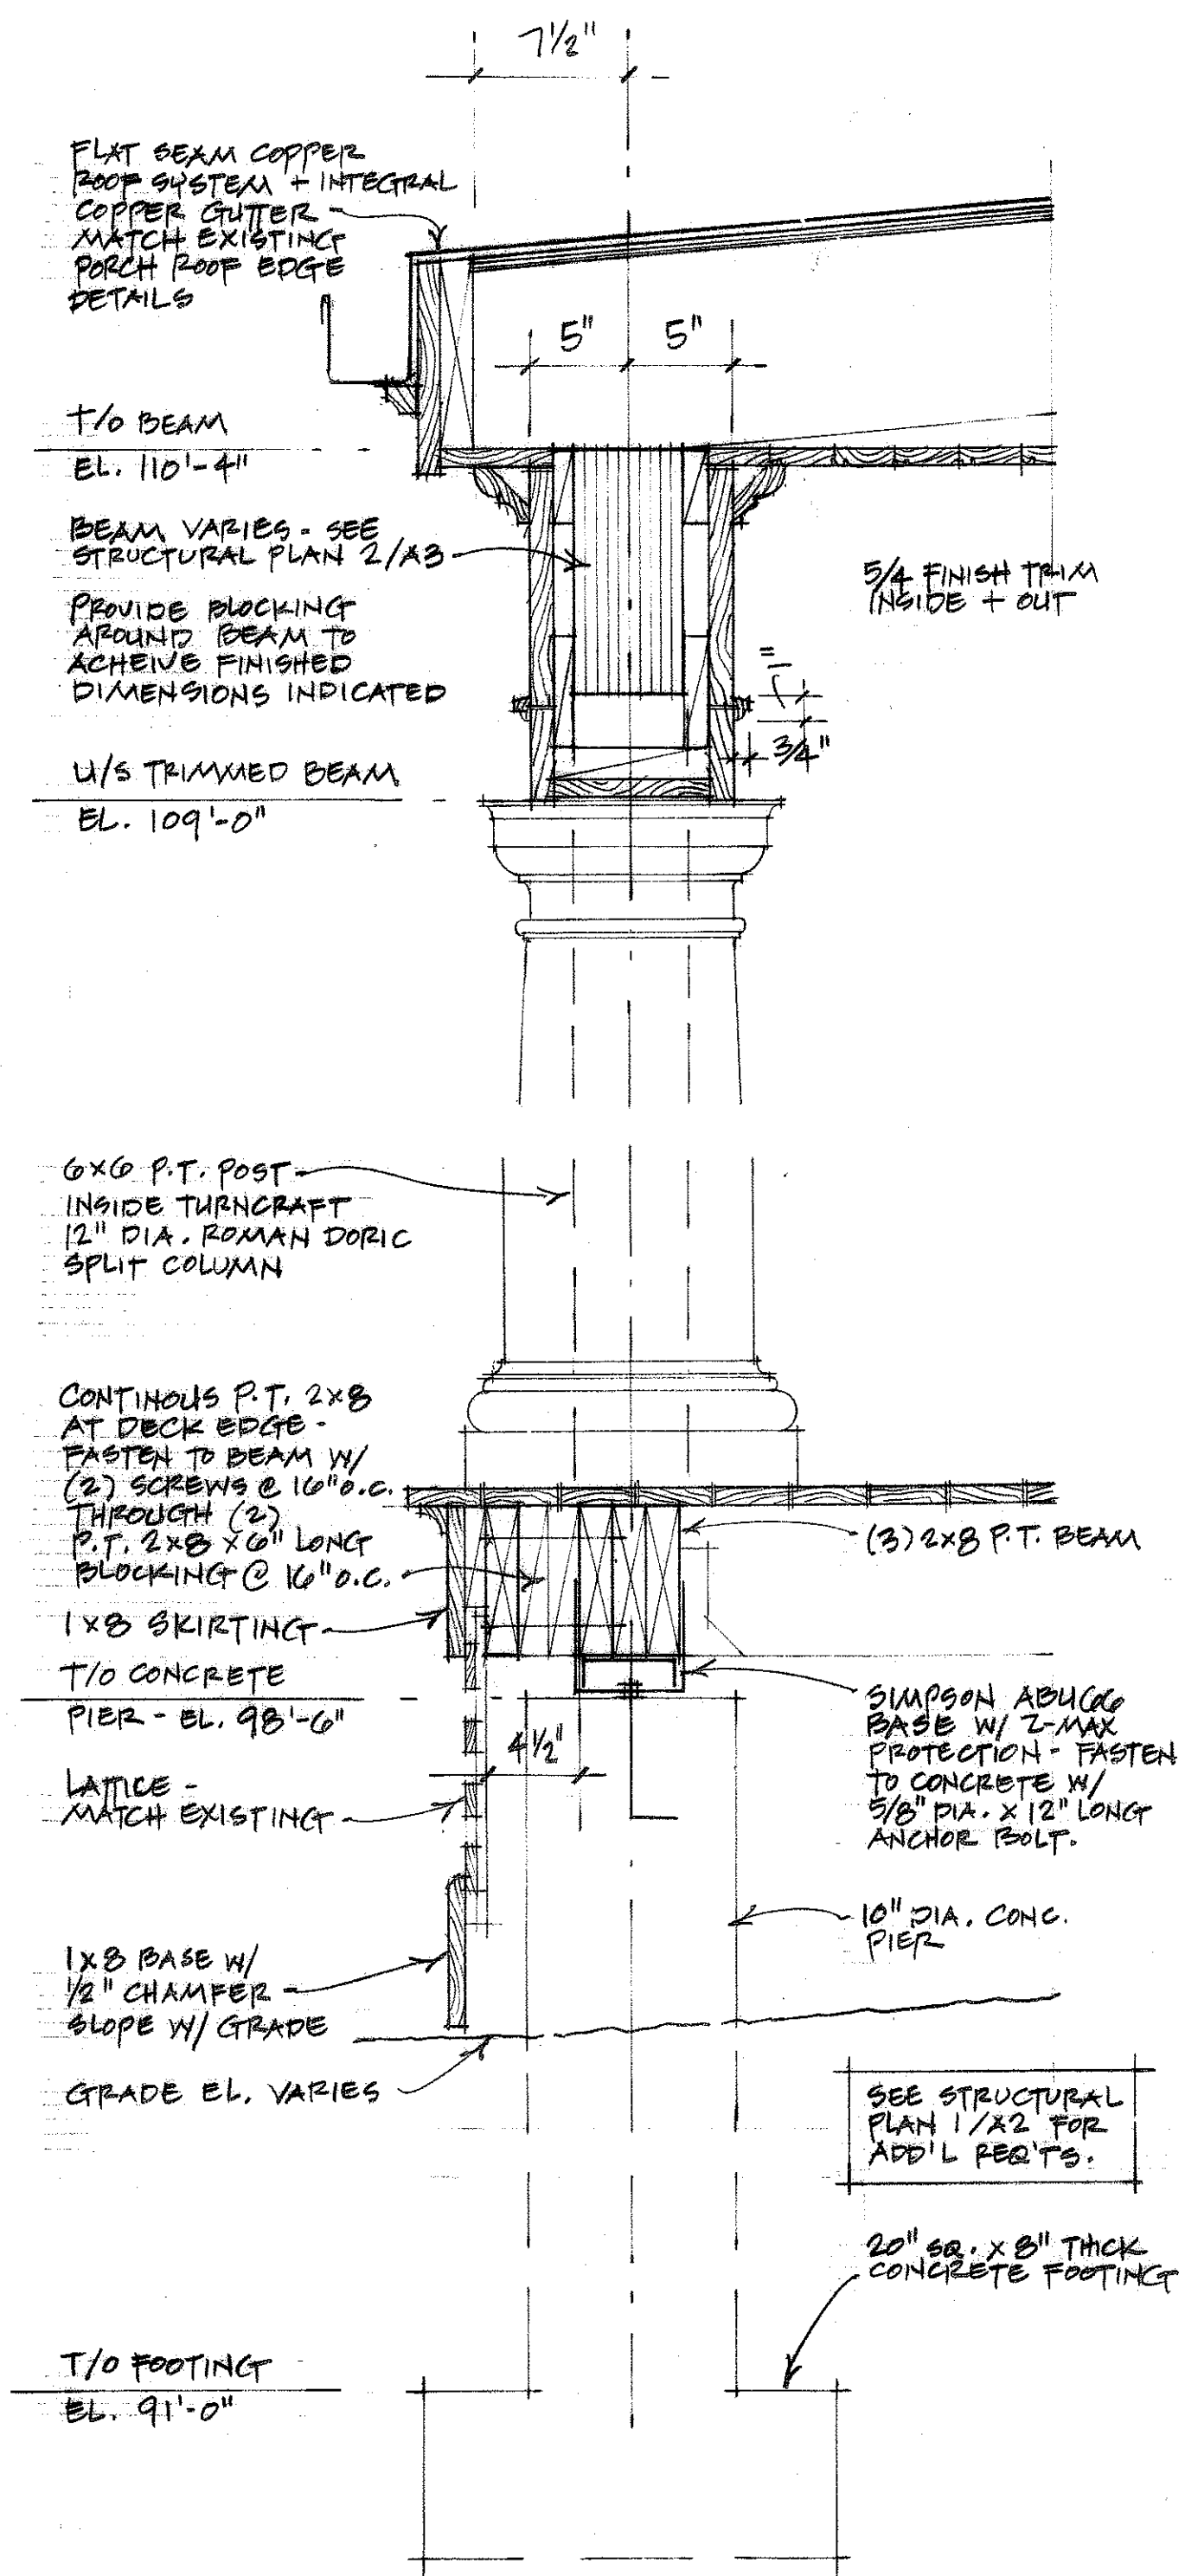

1 SECTION THROUGH PORCH.
1/2" = 1'-0"

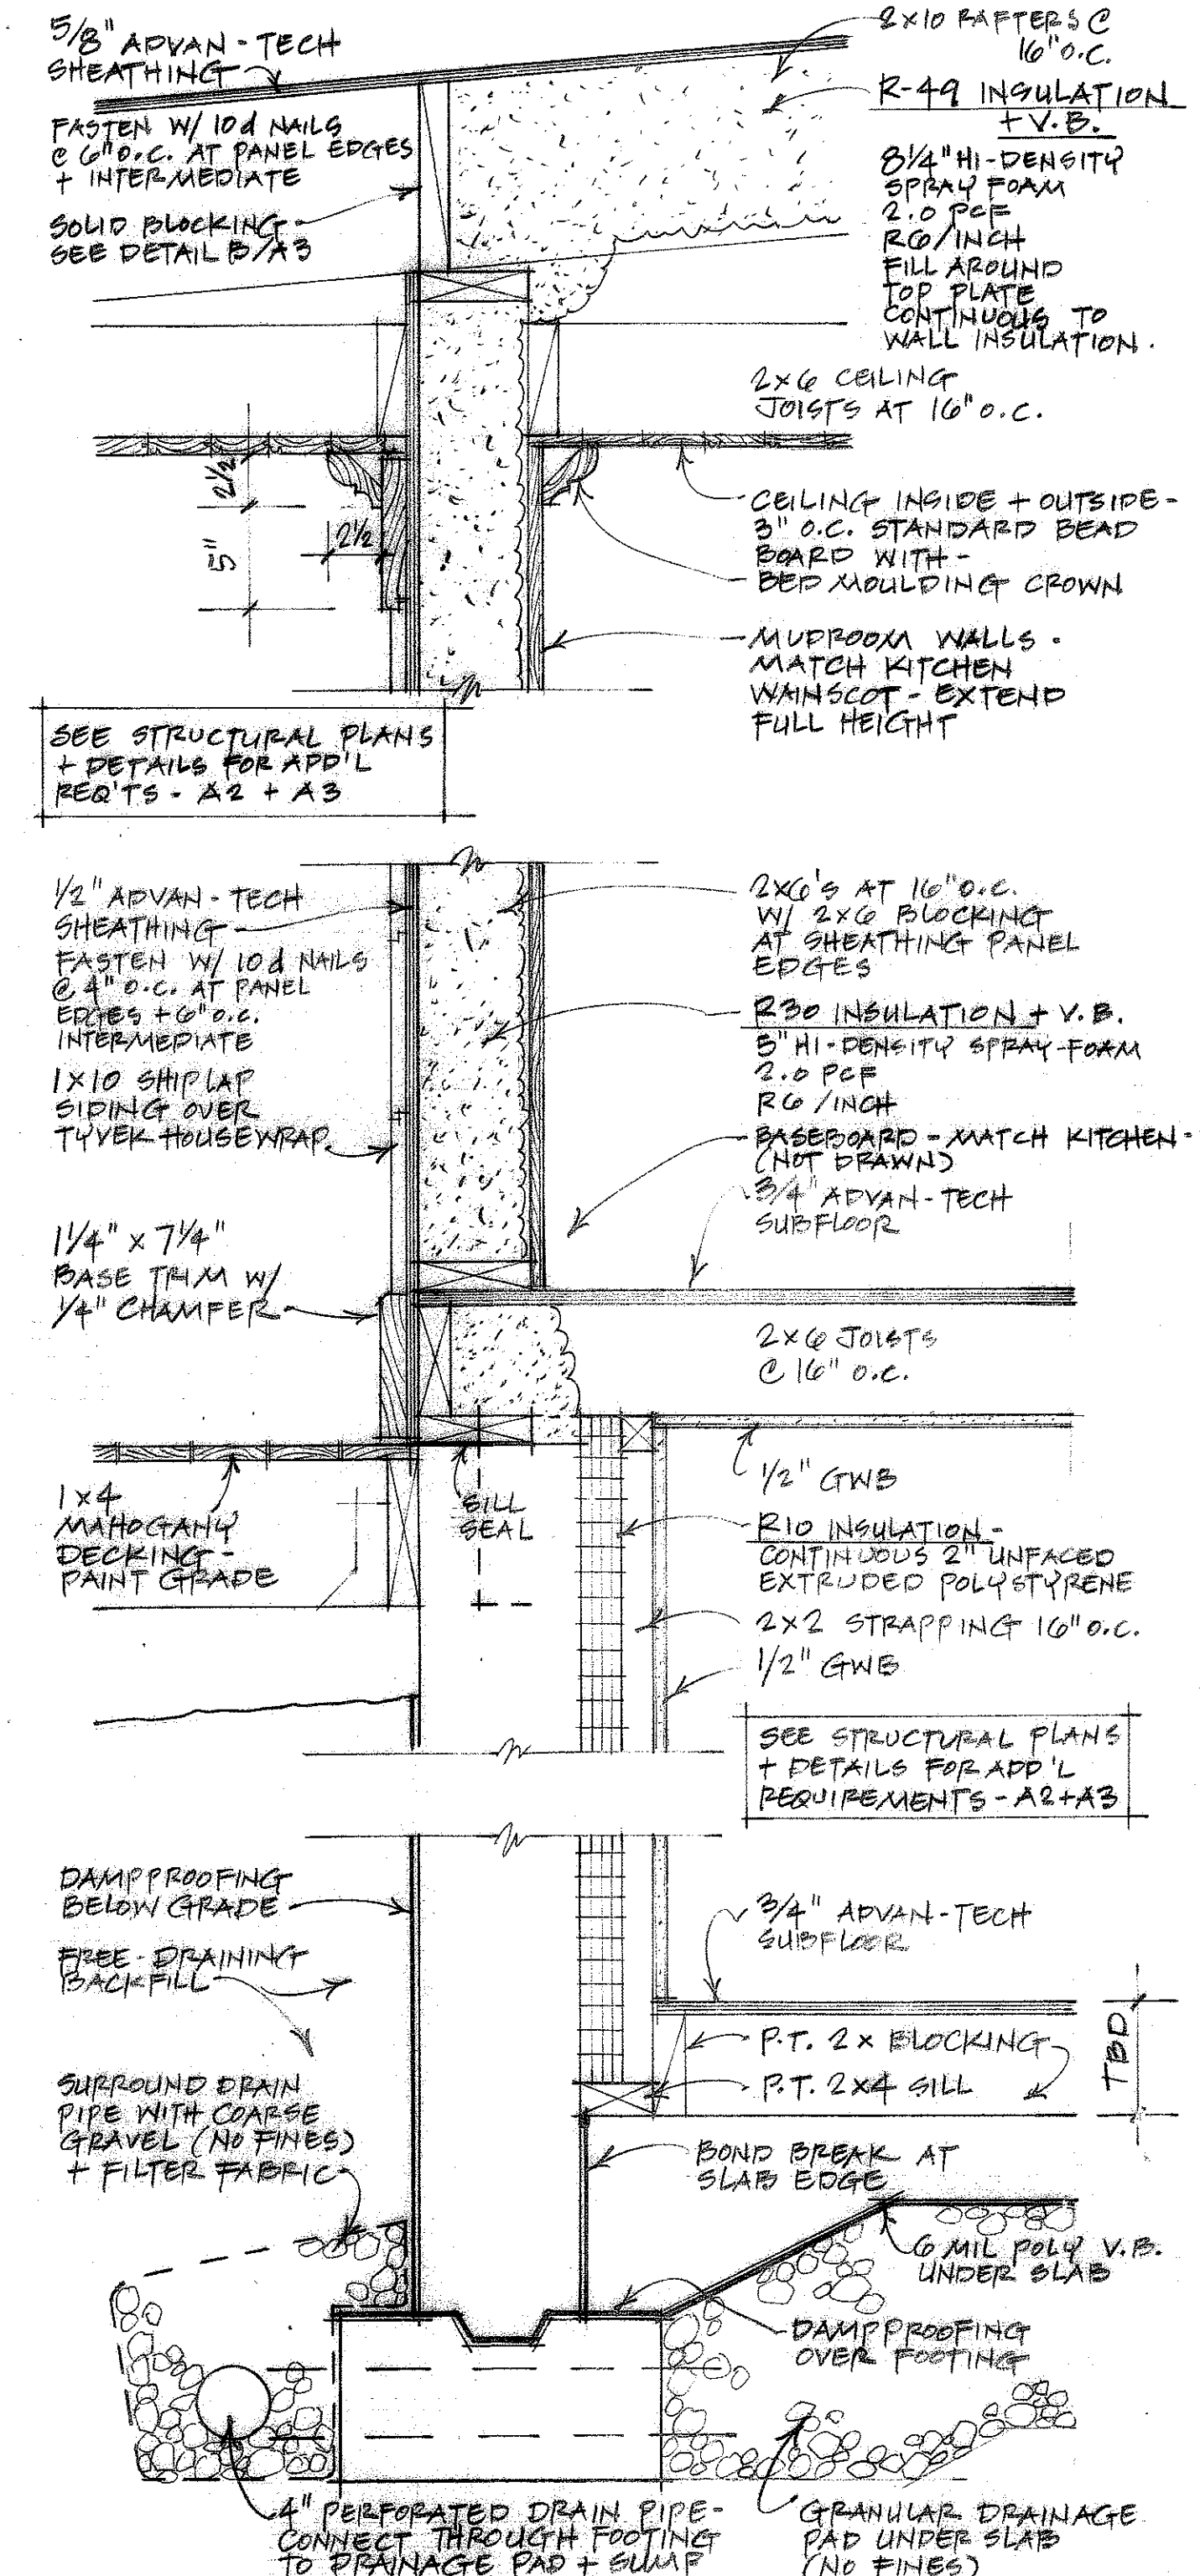

2 SECTION THROUGH MUDROOM.
1/2" = 1'-0"

Carriage House Studio
architects


144 Vaughan Street, Portland, Maine, 207-318-0731
www.carriagehousestudio.com

WALL SECTIONS


Addition & Site Improvements to
395 Spring Street
Portland, Maine

30 MAR 2011

A4


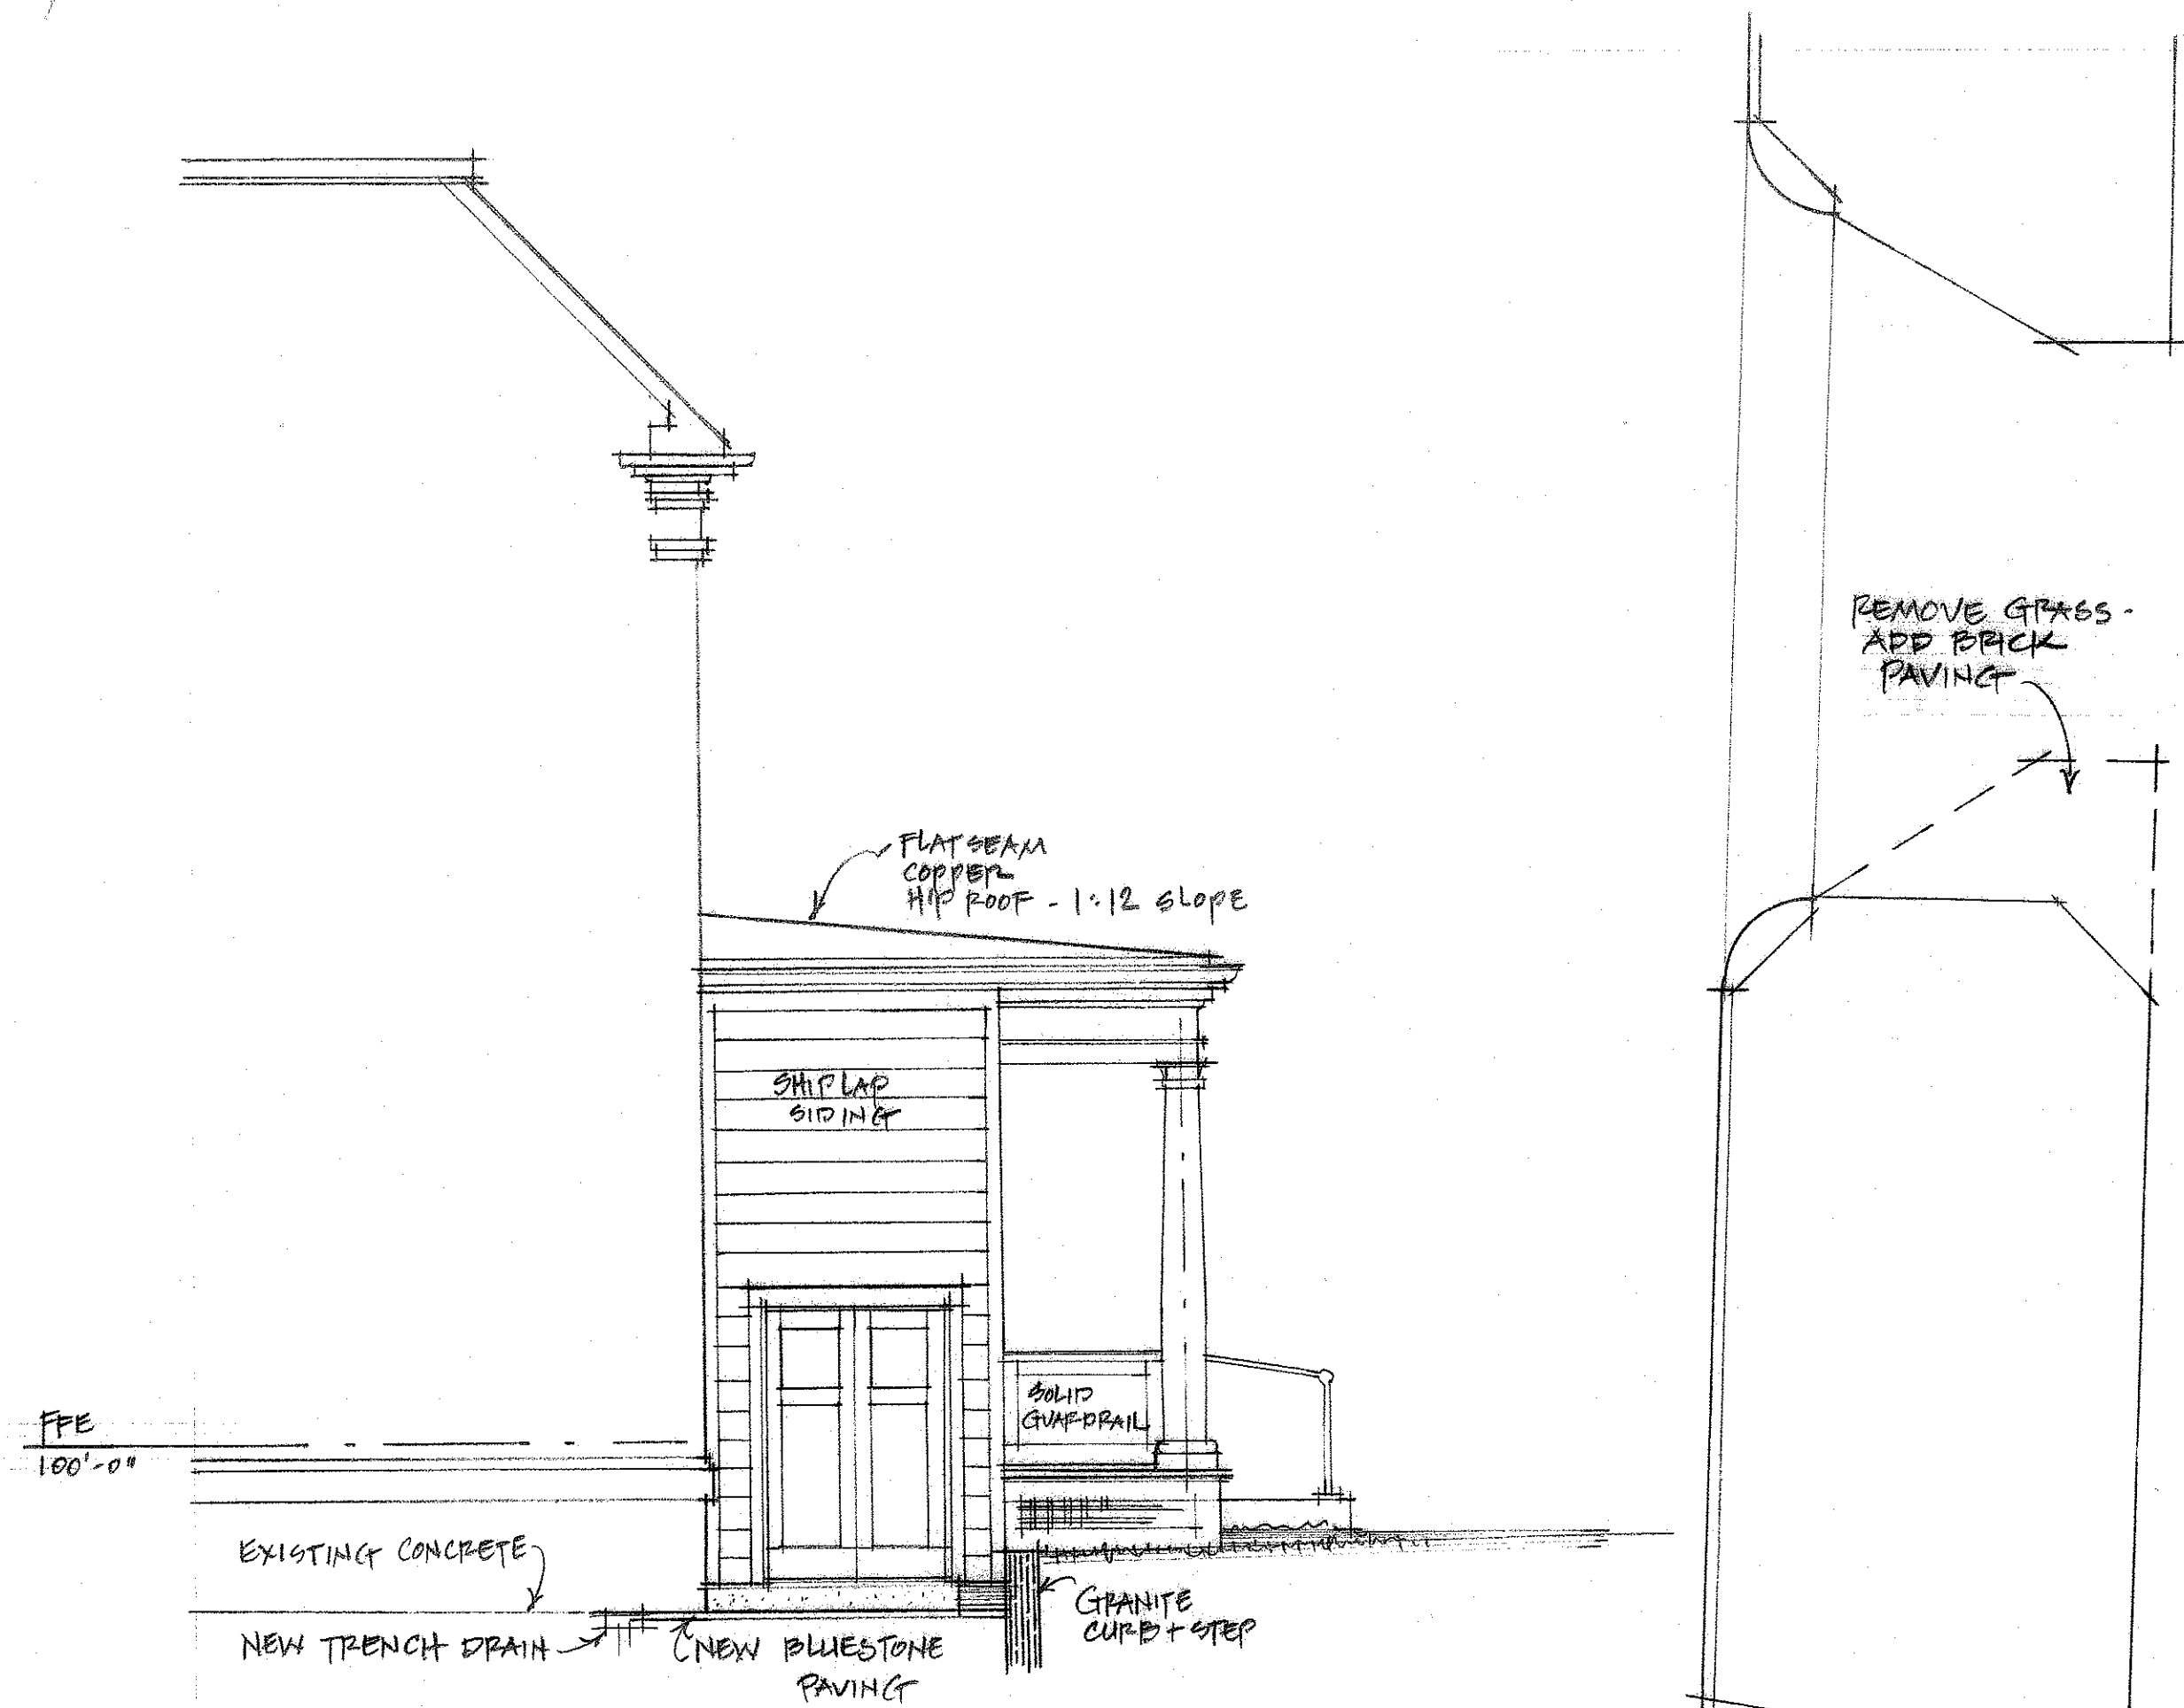


PROPOSED COURTYARD ELEVATION
 EAST - SITE SECTION B-B 1/4" = 1'-0"

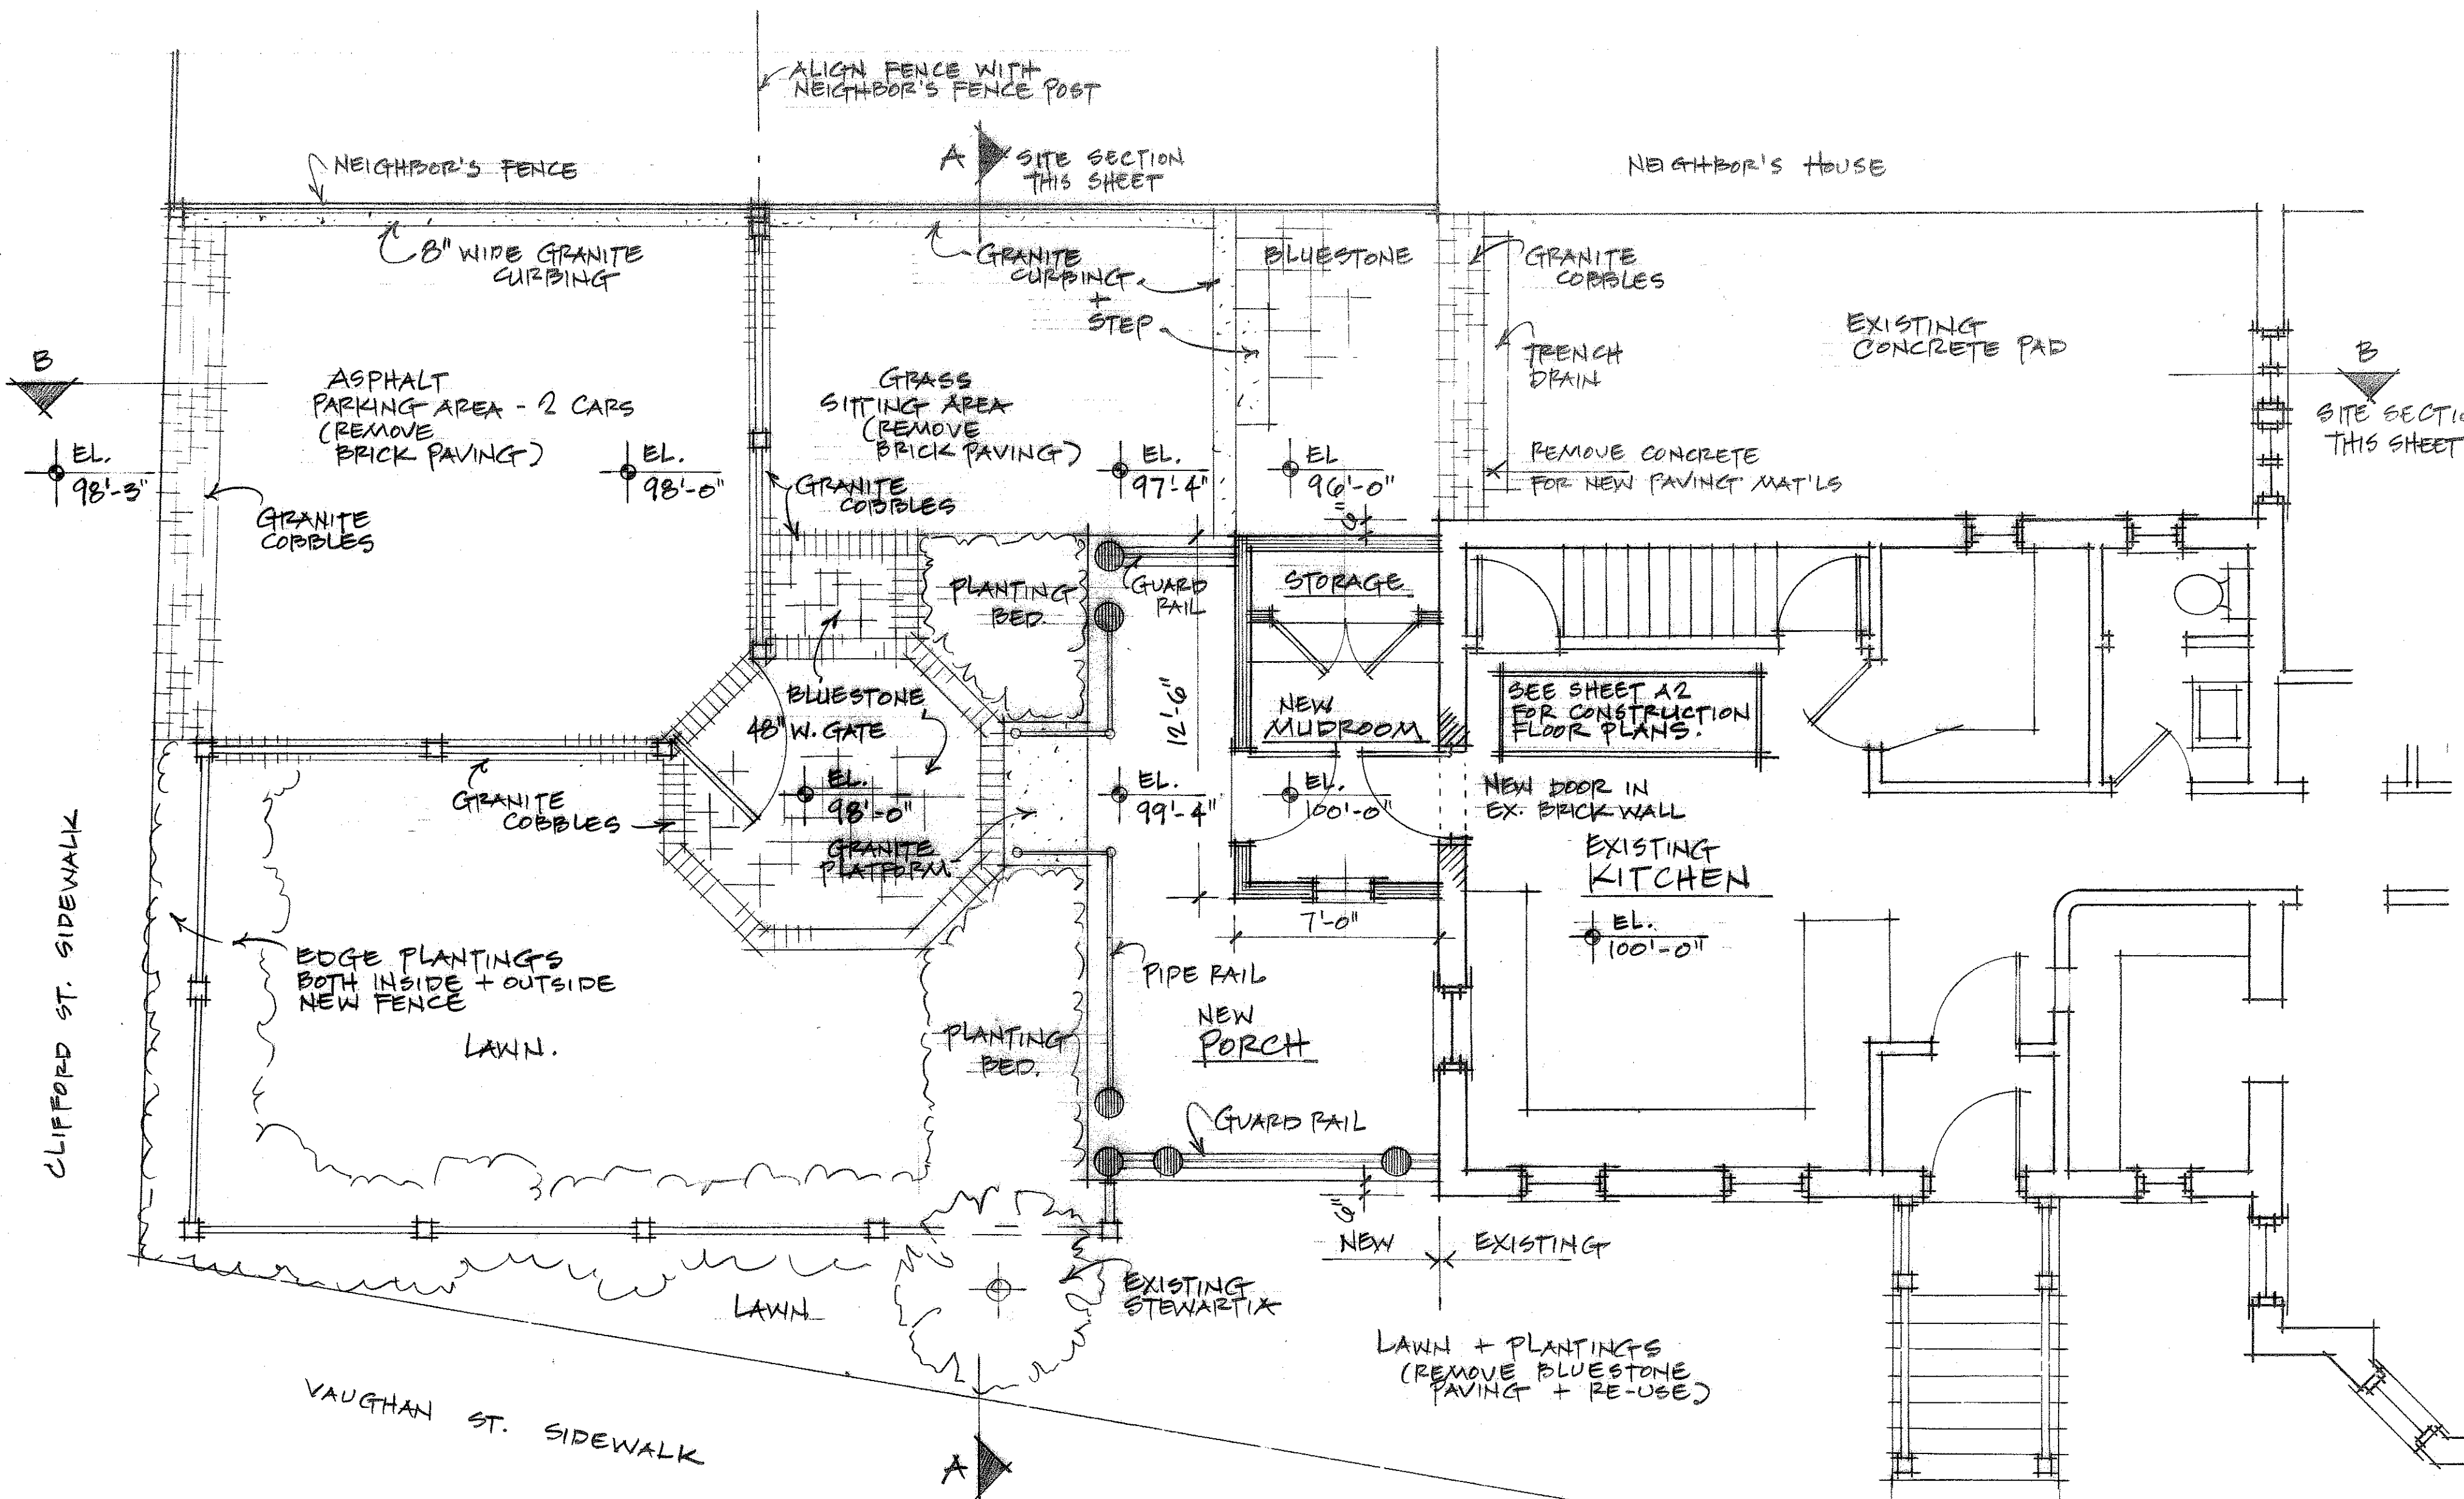

PROPOSED YARD + ADDITION PLAN.

395 SPRING STREET 1/4" = 1'-0"
 CARRIAGE HOUSE STUDIO . architects . 28 JUNE 2010

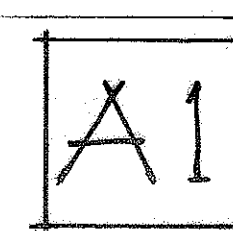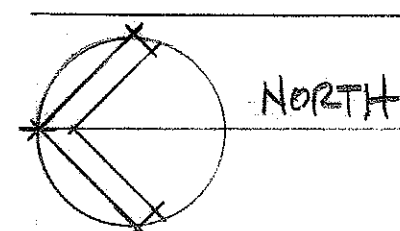


• UPDATED + ISSUED FOR CONSTRUCTION • 30 MAR 2011 •



PROPOSED REAR YARD ELEVATION.

NORTH - CLIFFORD ST. ELEVATION - SITE SECTION A-A

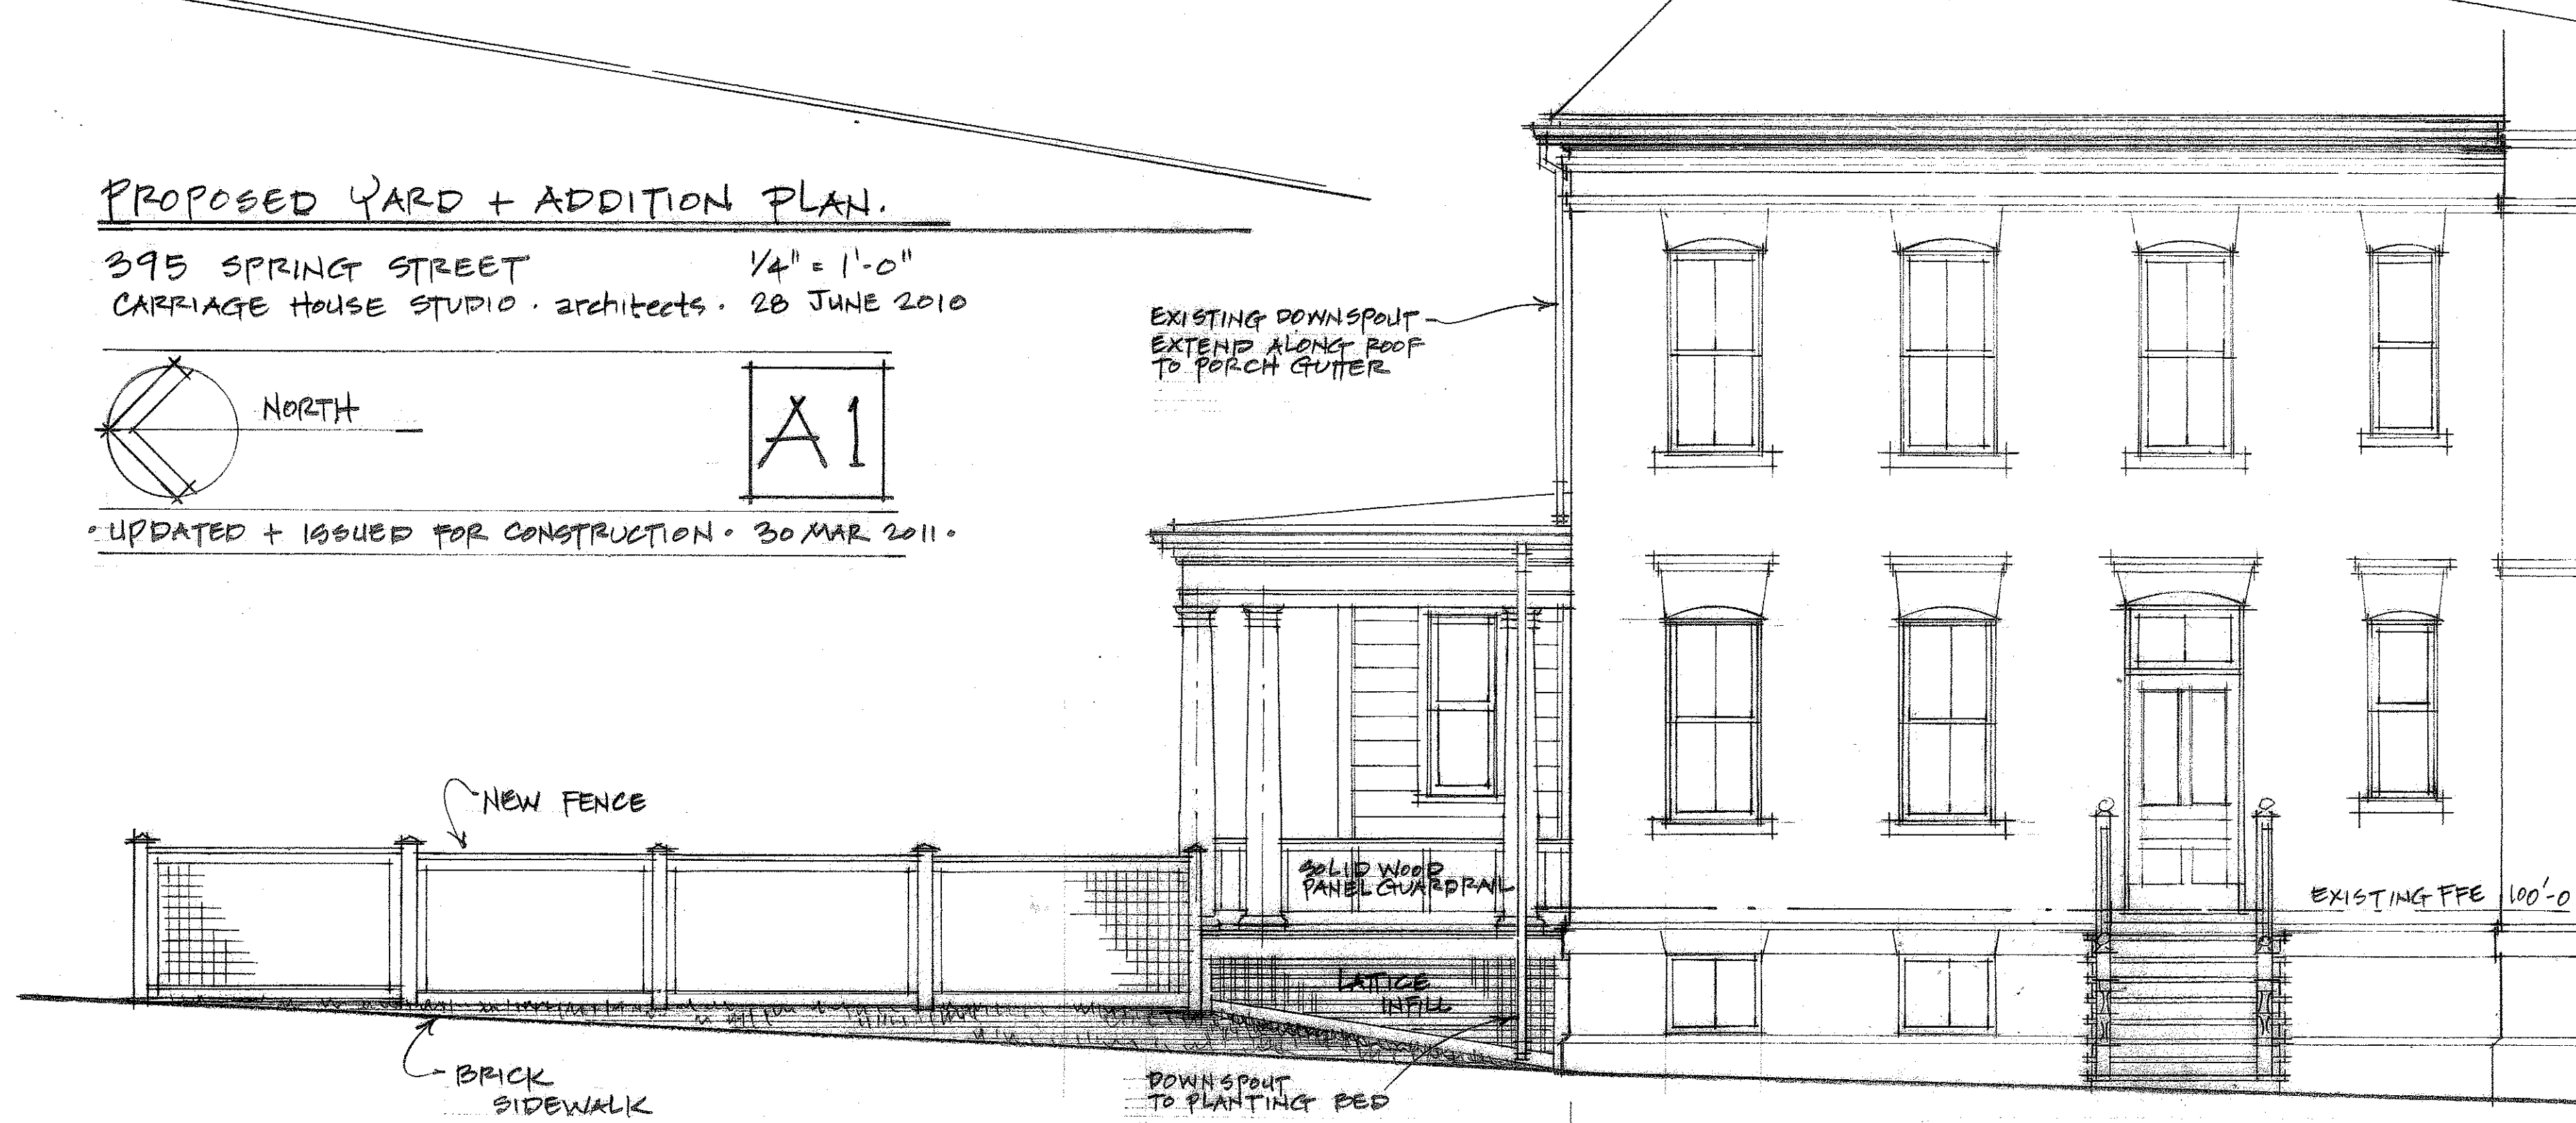

PROPOSED SIDE YARD ELEVATION

WEST - VAUGHAN ST. ELEVATION


Addition & Site Improvements to
 395 Spring Street
 Portland, Maine

Carriage House Studio
 architects


144 Vaughan Street, Portland, Maine, 207-318-0731
 www.carriagehousestudio.com

30 MAR 11

A1

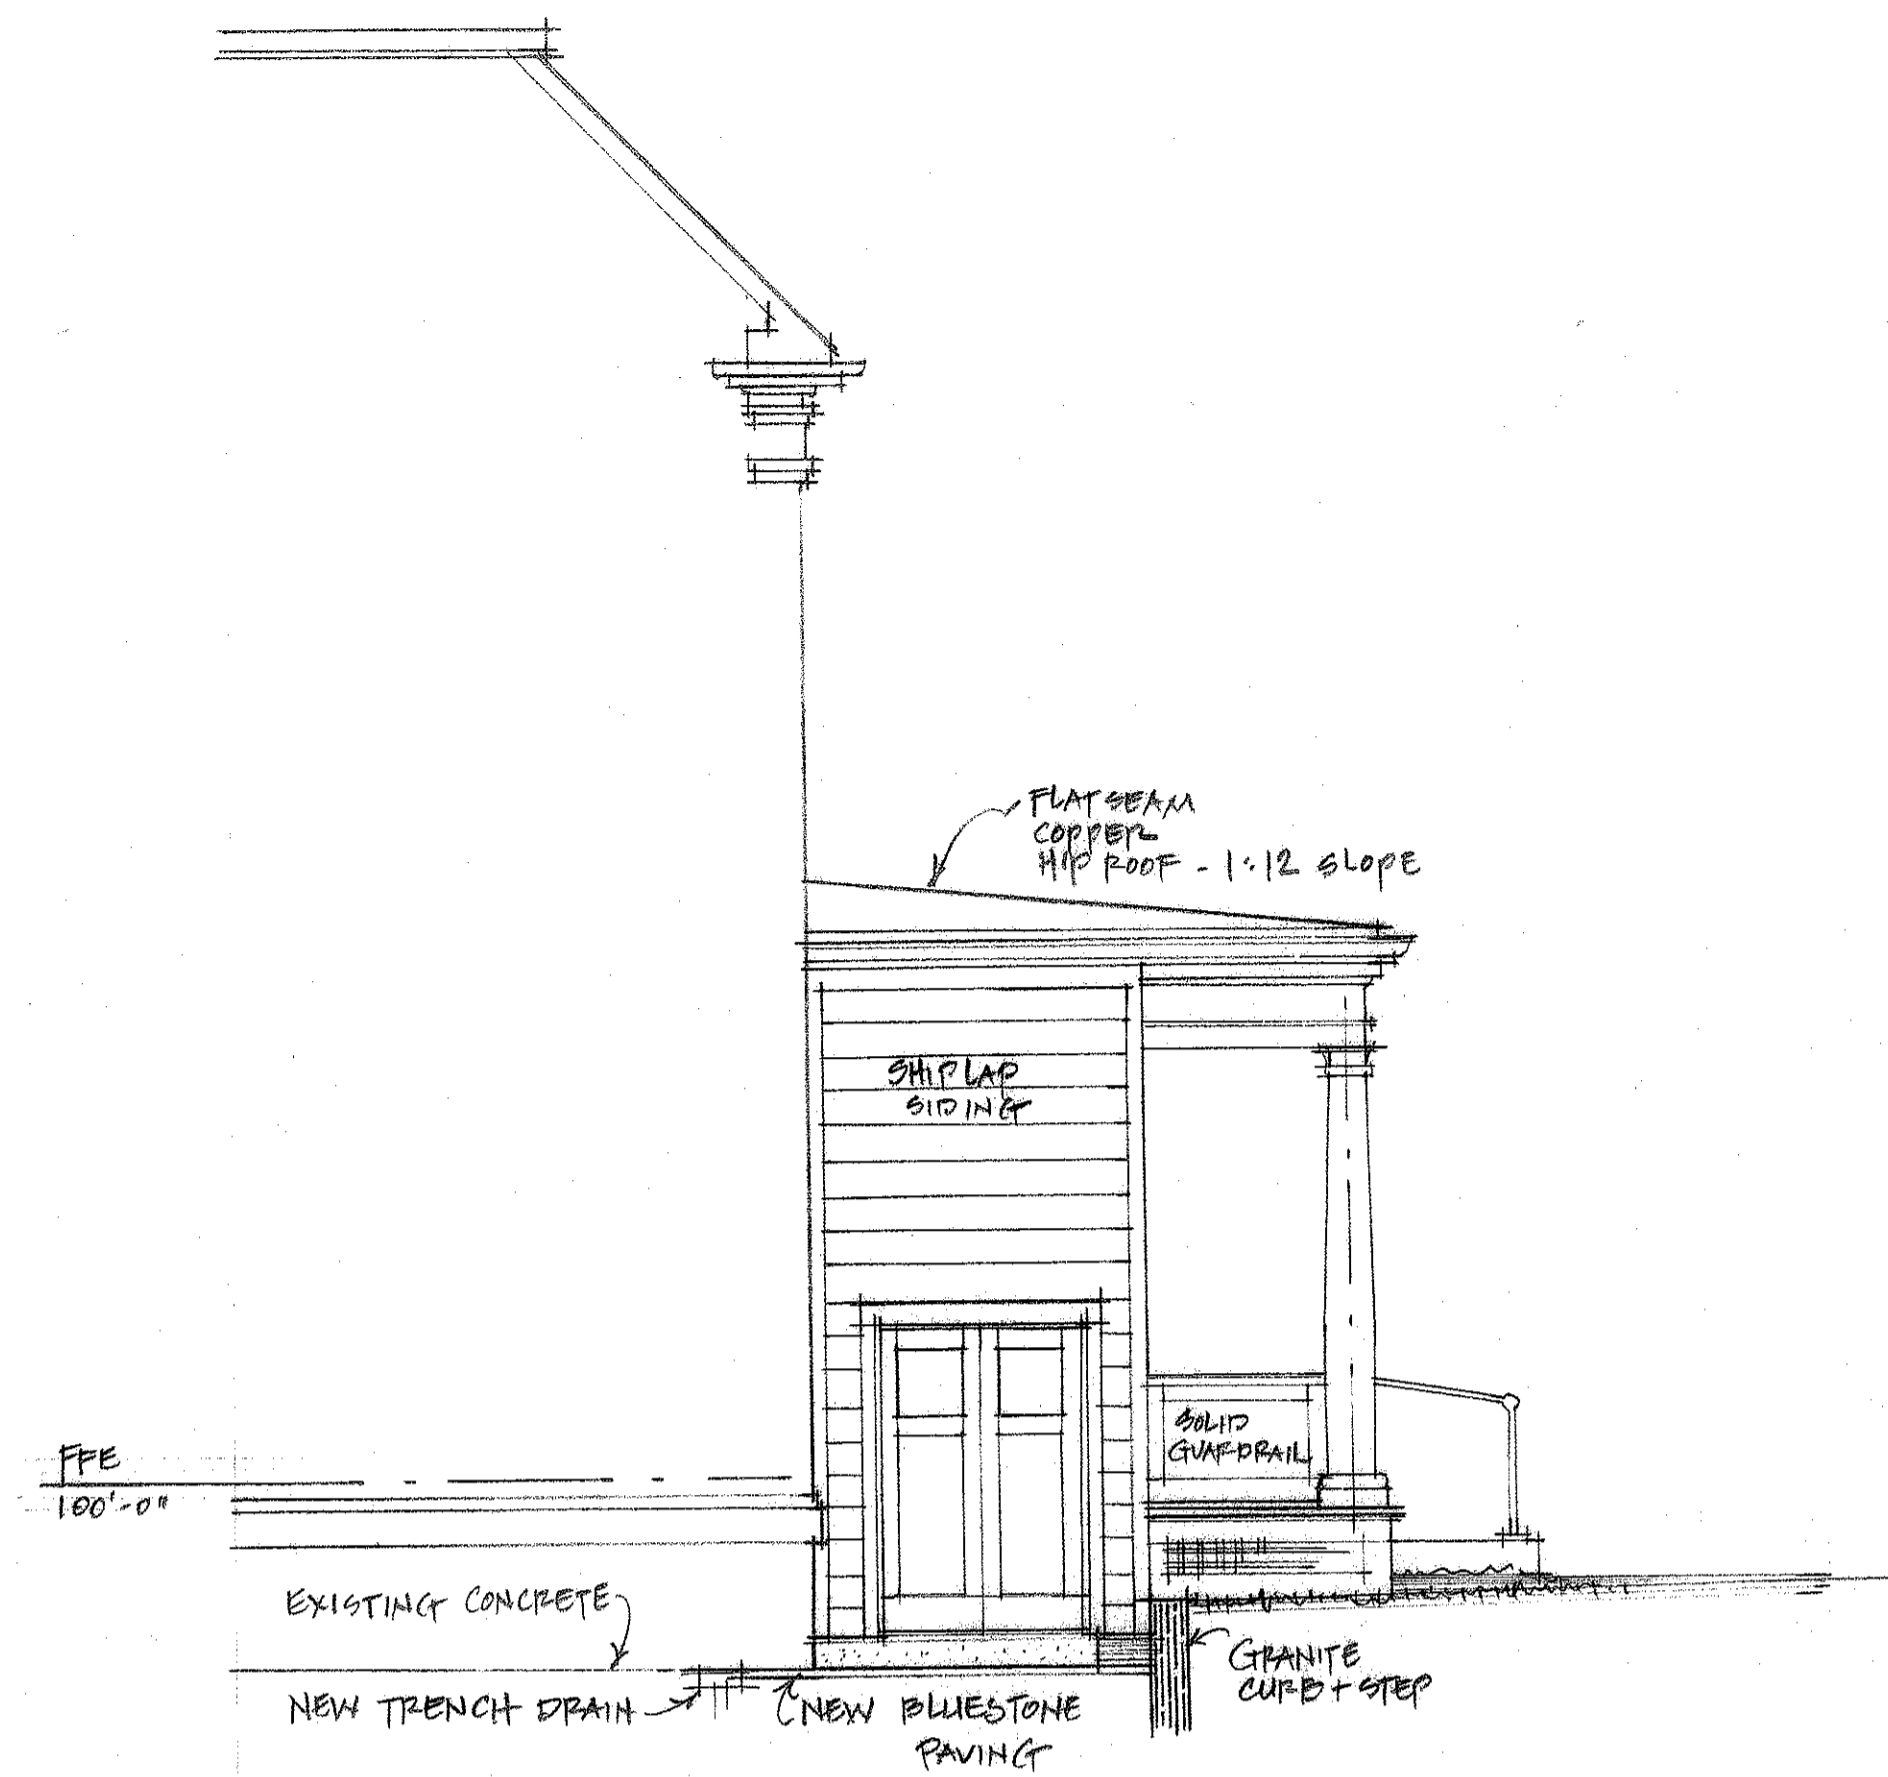


PROPOSED COURTYARD ELEVATION
 EAST - SITE SECTION B-B 1/4" = 1'-0"

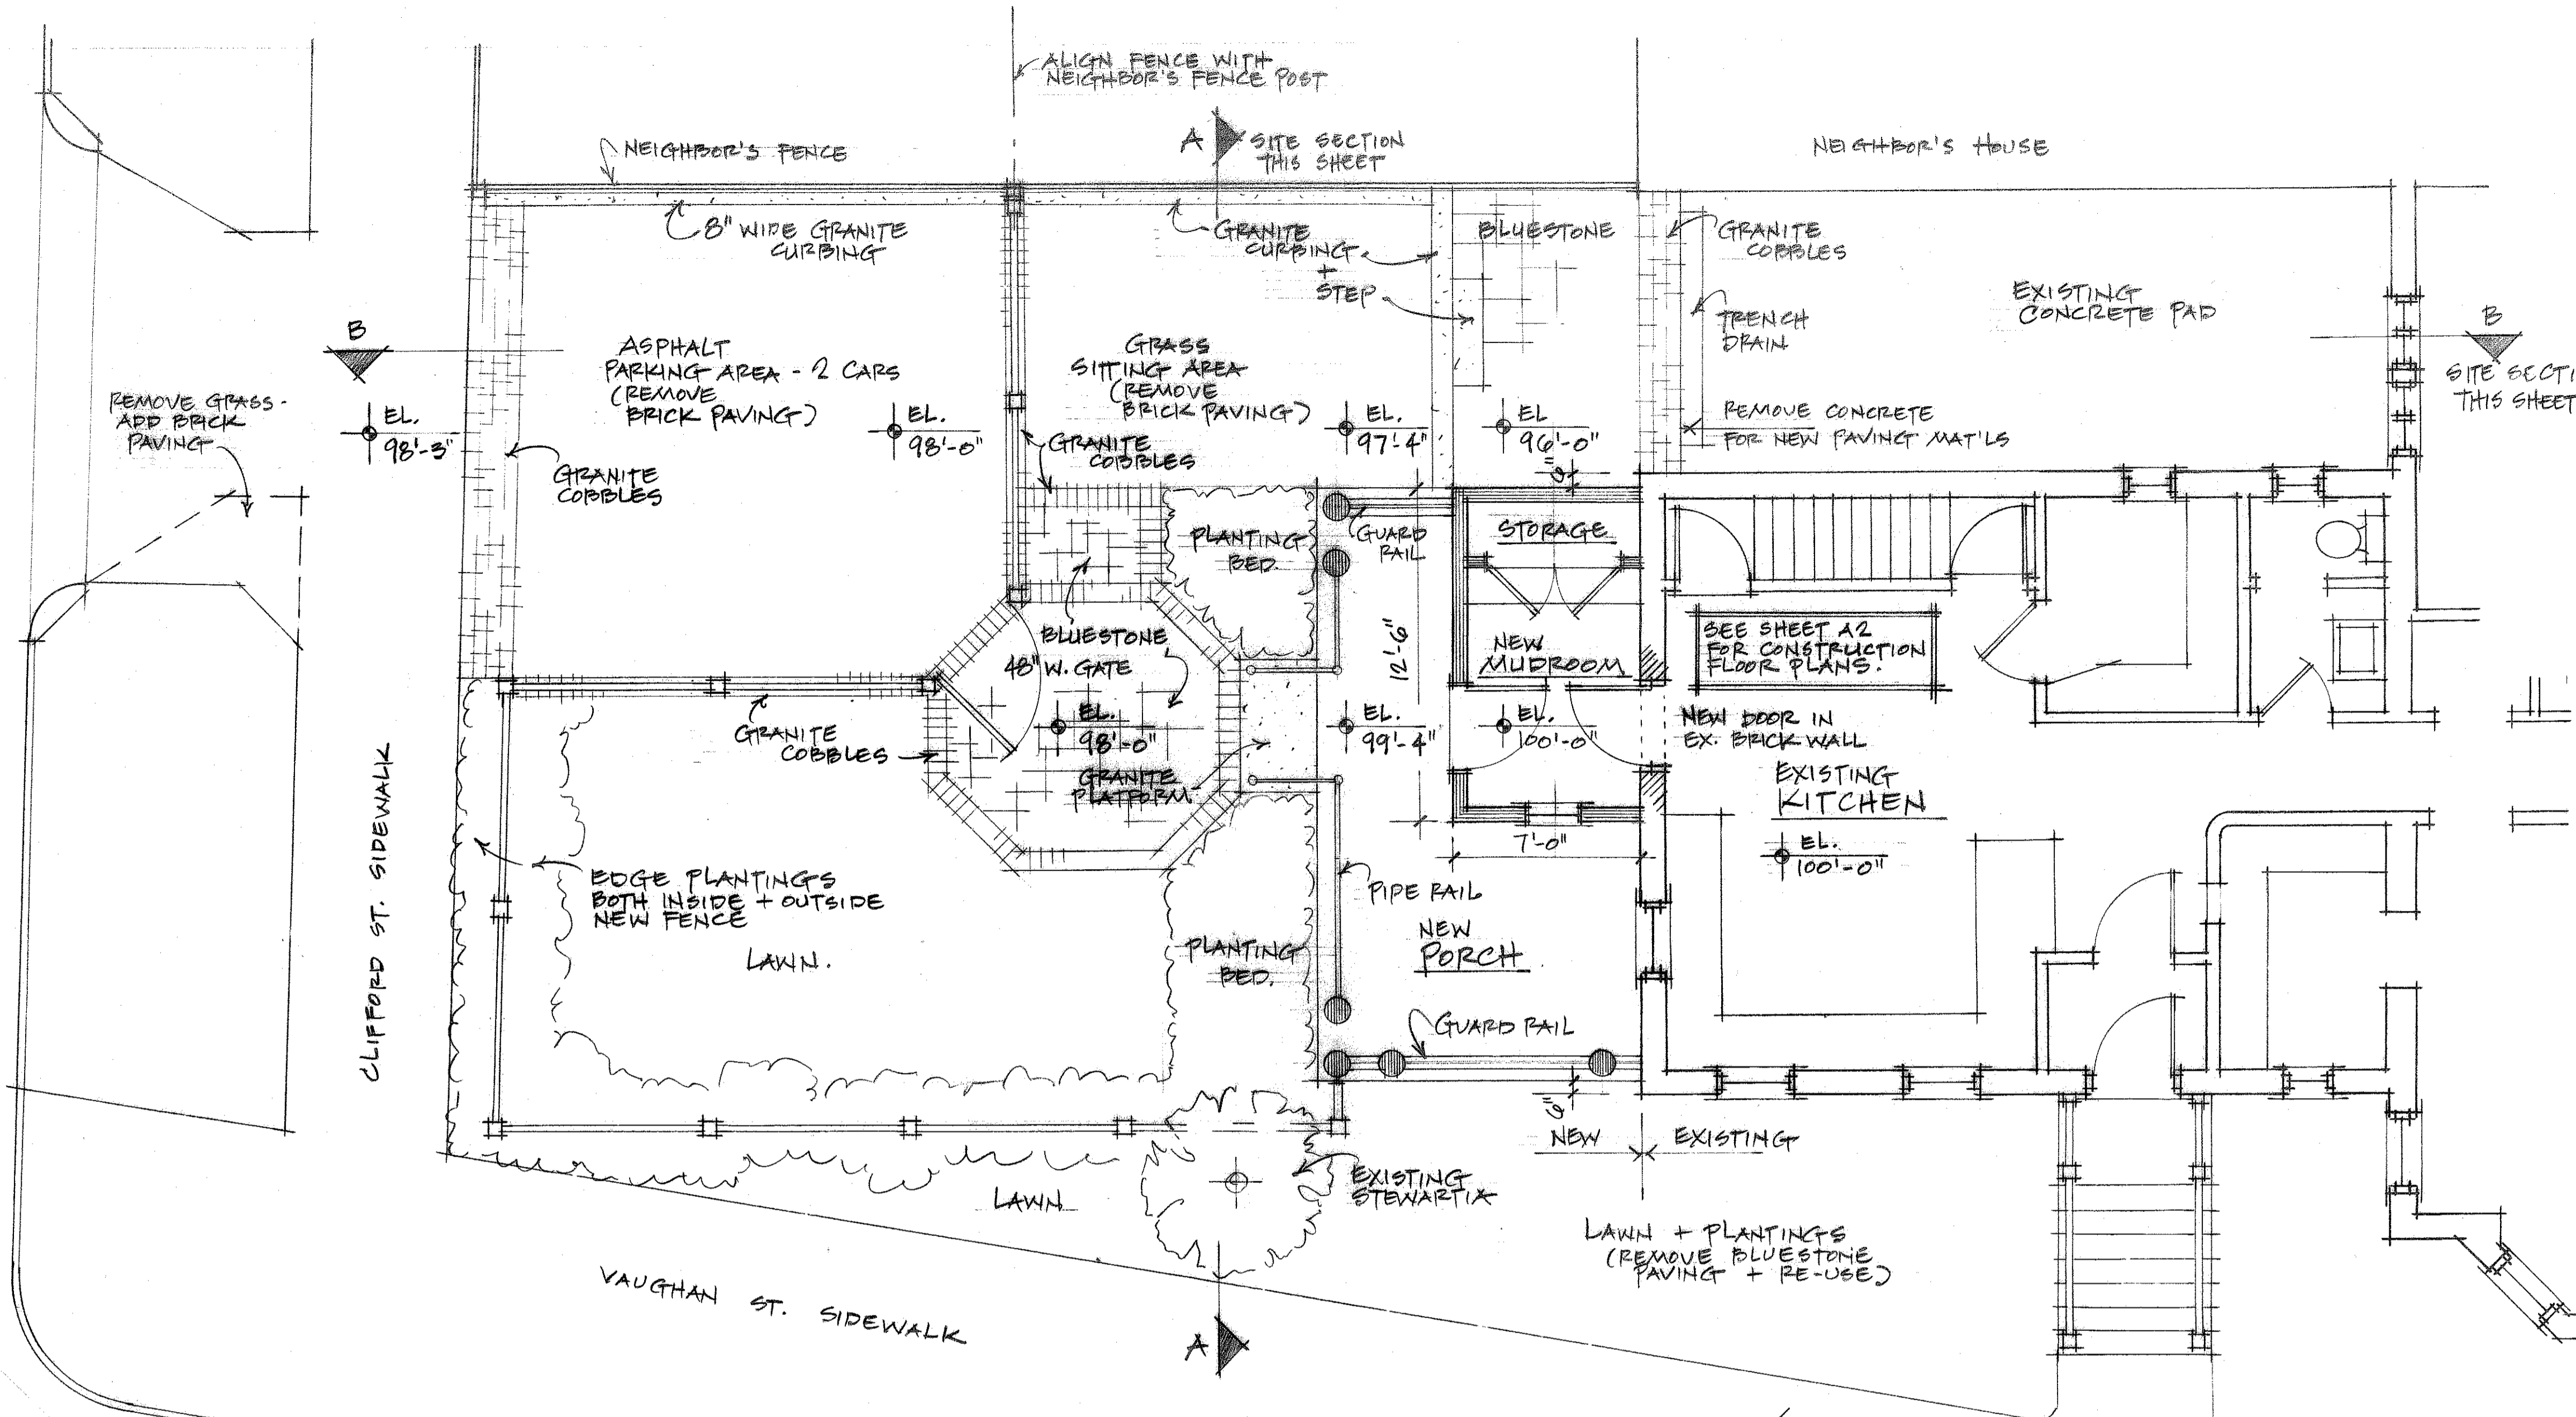

PROPOSED REAR YARD ELEVATION
 NORTH - CLIFFORD ST. ELEVATION - SITE SECTION A-A


PROPOSED YARD + ADDITION PLAN.

395 SPRING STREET 1/4" = 1'-0"
 CARRIAGE HOUSE STUDIO . architects . 28 JUNE 2010

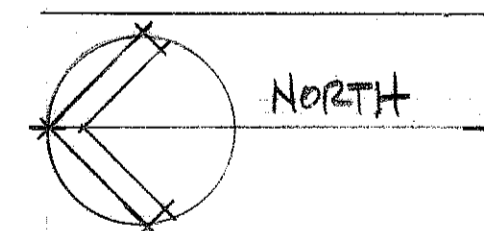

A1

• UPDATED + ISSUED FOR CONSTRUCTION • 30 MAR 2011 •

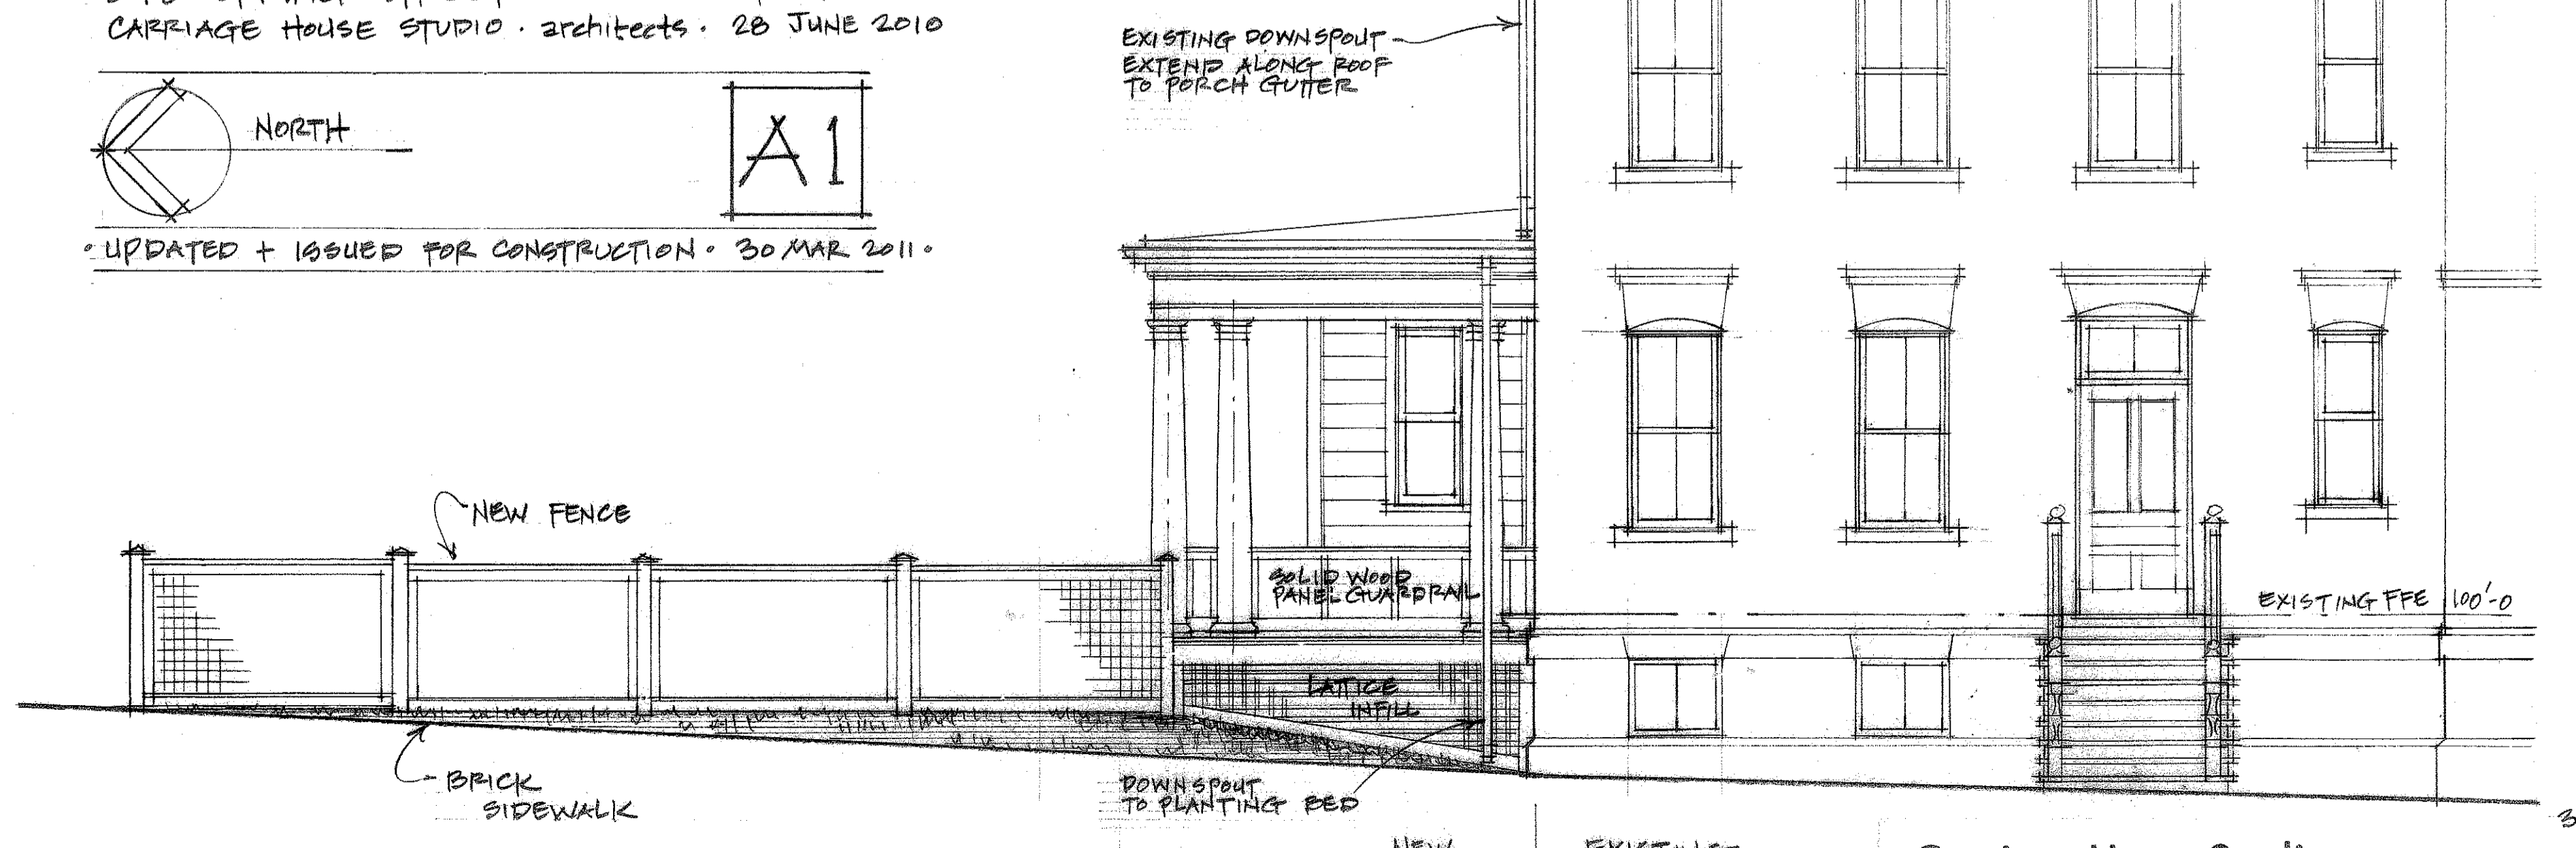

PROPOSED SIDE YARD ELEVATION
 WEST - VAUGHAN ST. ELEVATION

Addition & Site Improvements to
 395 Spring Street
 Portland, Maine

30 MAR 11