


NOTES:
 1. SEE SHEET E-001 FOR LEGEND AND GENERAL NOTES.

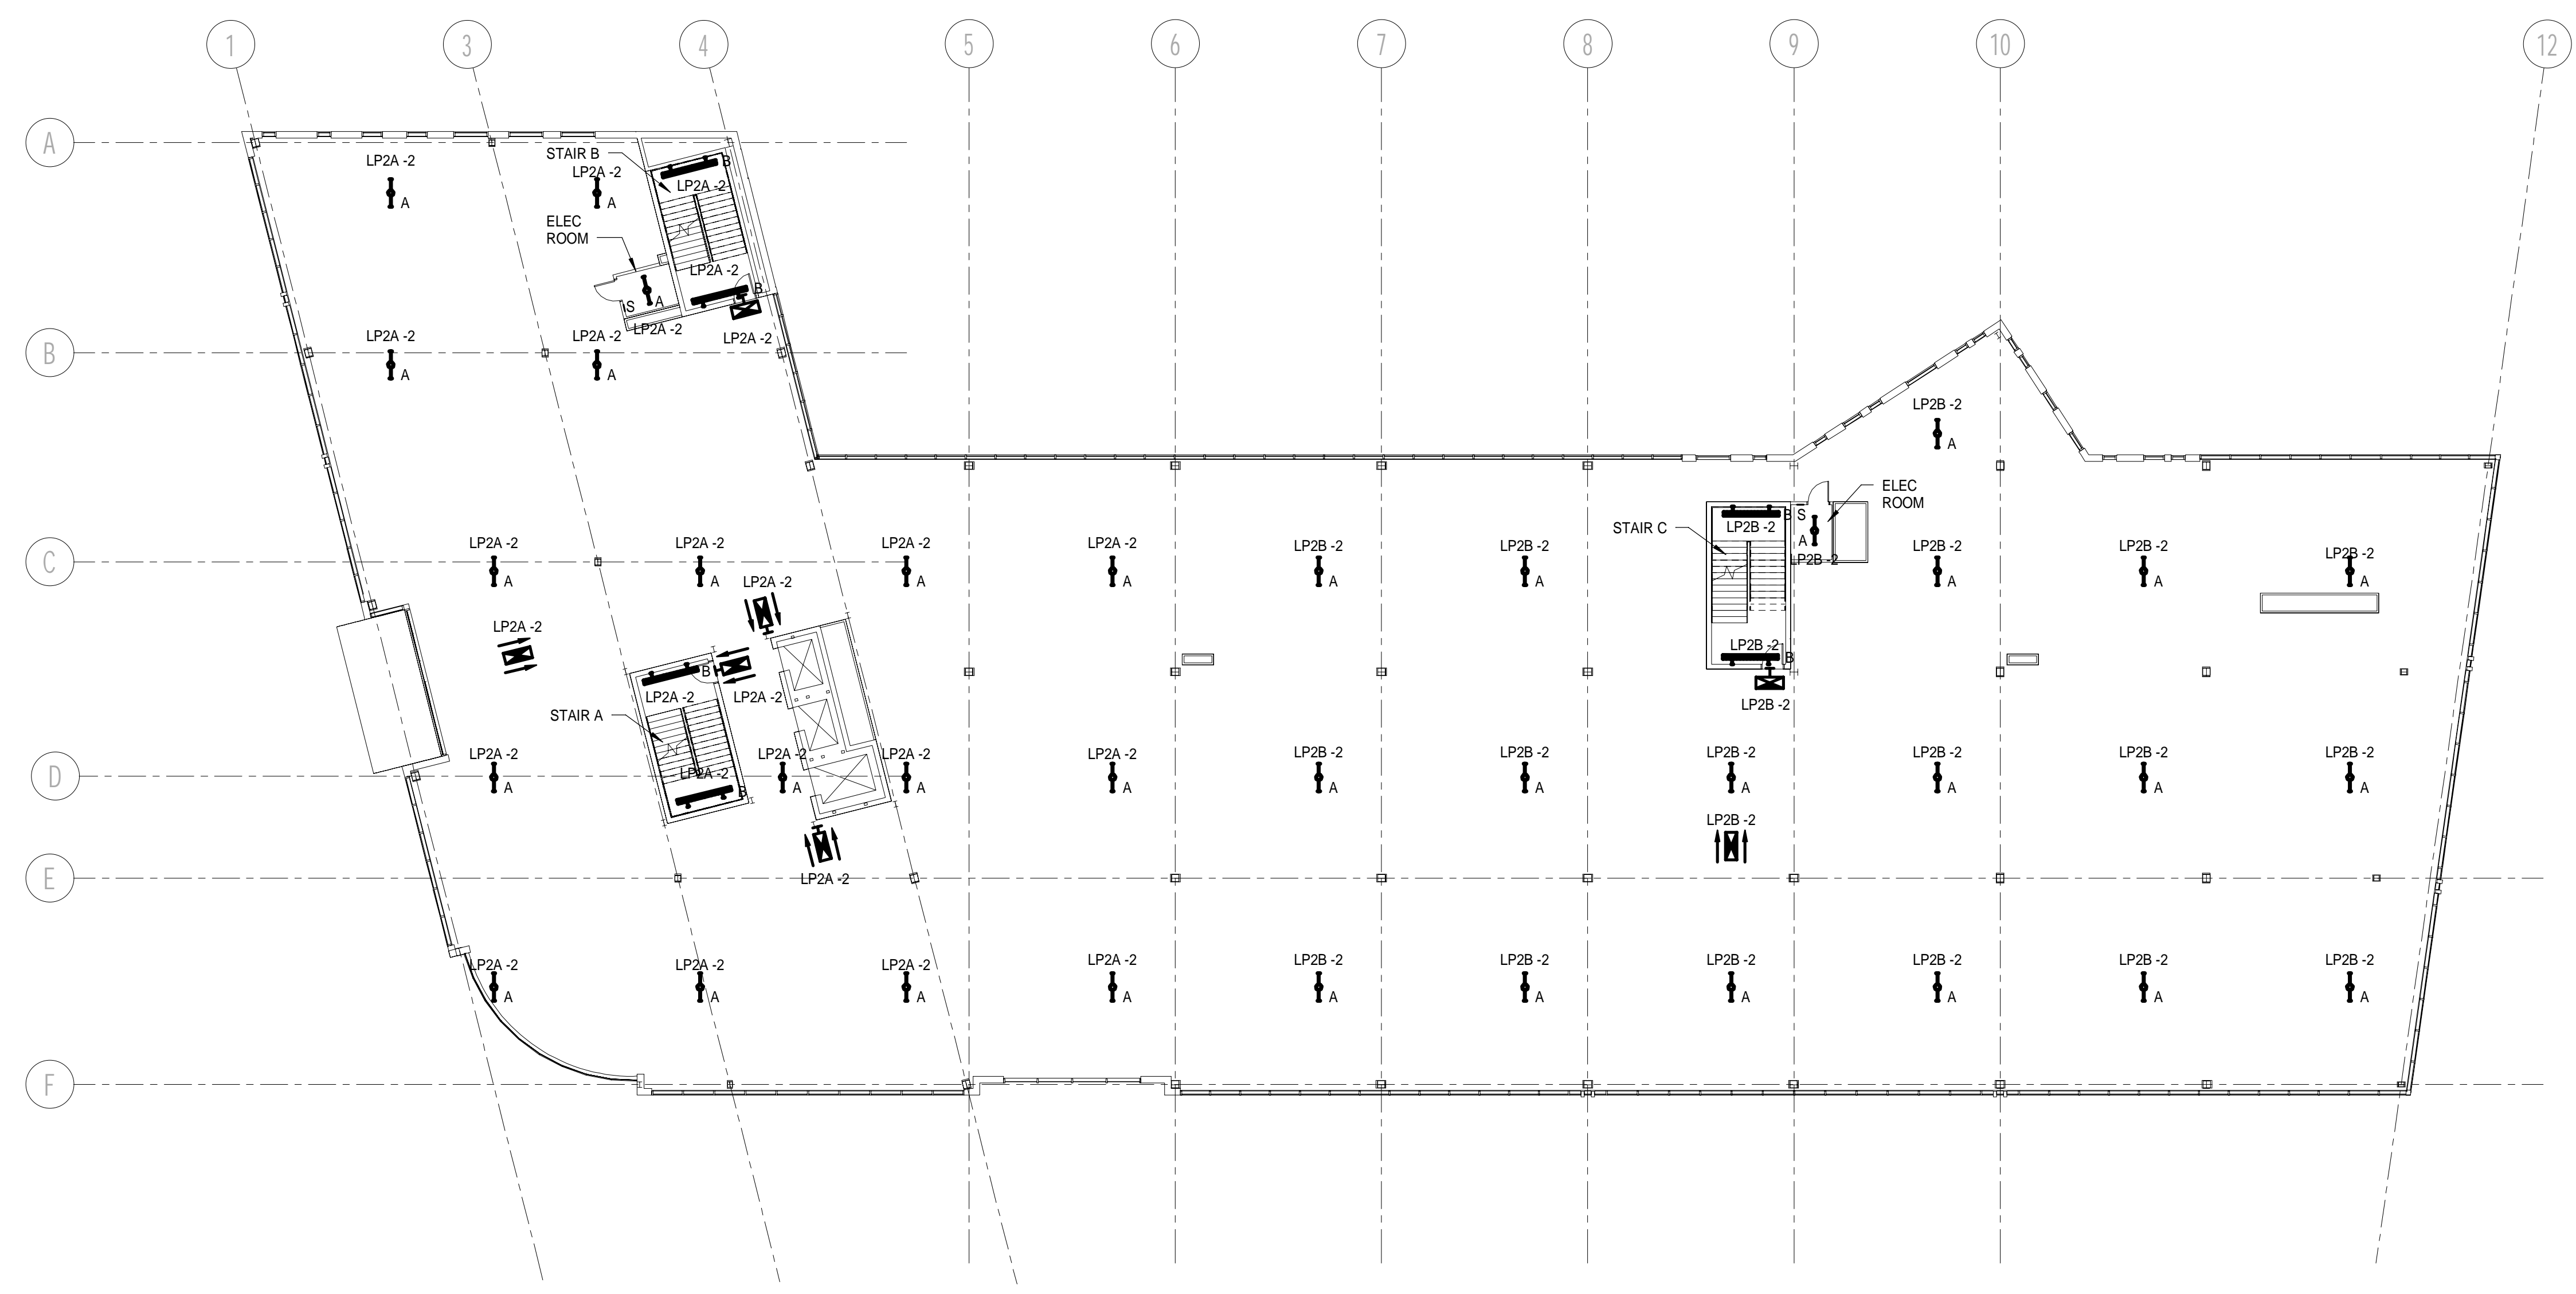

2ND FLOOR LIGHTING PLAN (A1)
 1/16" = 1'-0"

REV	DESCRIPTION	DATE
0	ISSUED FOR PERMIT	10/23/2017

ISSUED FOR PERMIT
 10/23/2017

CURRENT ISSUE STATUS:

PROJECT NORTH:

SMRT Architects and Engineers
 144 Fore Street/P.O. Box 618
 Portland, Maine 04104


ARCHITECTURE | ENGINEERING | PLANNING | INTERIOR DESIGN | ENERGY SERVICES

WEX

0 HANCOCK STREET, PORTLAND MAINE

2ND FLOOR LIGHTING PLAN

SHEET TITLE:

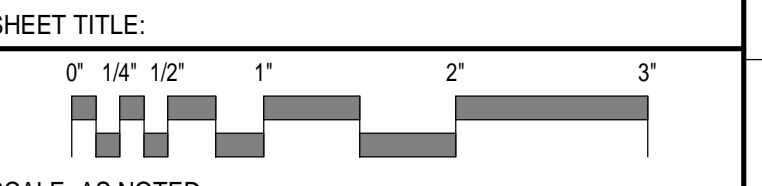

PROJECT MANAGER:	DJT	PROJECT NO.:	17146
A/E OF RECORD:	DJT	EL102	
JOB CAPTAIN:	DTJ		
DRAWN BY:	CDS		
SMRT FILE:	EL102-17146	SHEET No.:	