


NOTES:
 1. SEE SHEET E-001 FOR LEGEND AND GENERAL NOTES.

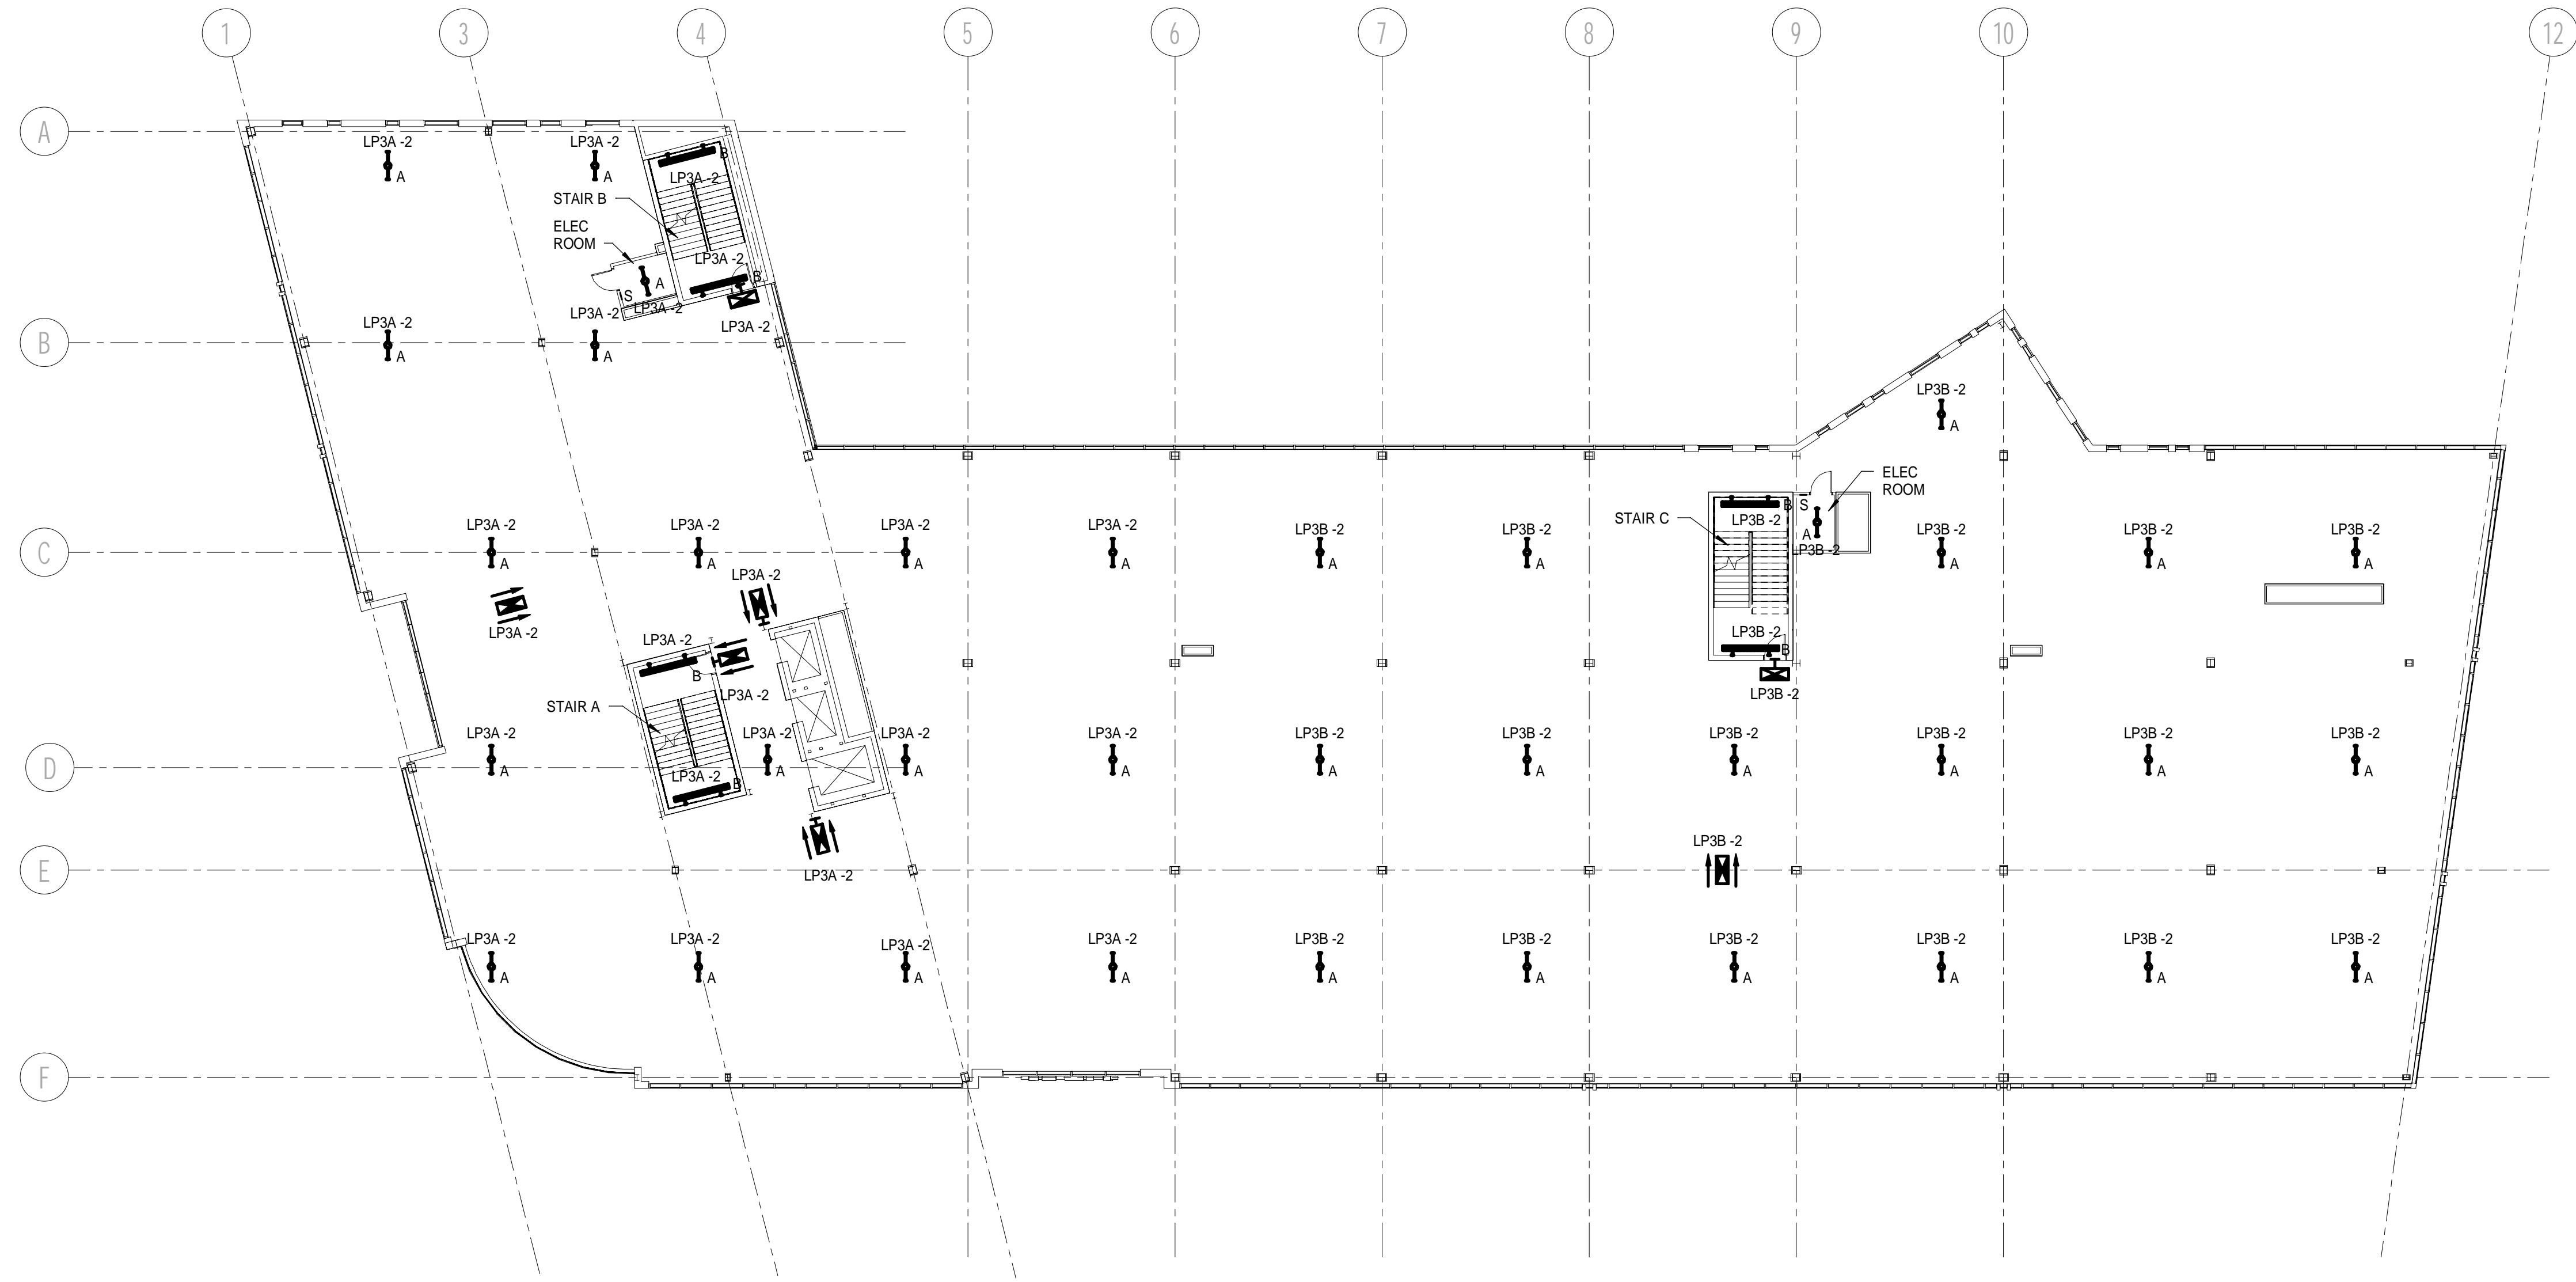

REV	DESCRIPTION	DATE
0	ISSUED FOR PERMIT	10/23/2017


ISSUED FOR PERMIT
 10/23/2017
 CURRENT ISSUE STATUS:

PROJECT NORTH:

SMRT Architects and Engineers
 144 Fore Street/P.O. Box 618
 Portland, Maine 04104

ARCHITECTURE | ENGINEERING | PLANNING | INTERIOR DESIGN | ENERGY
SMRT

WEX
 0 HANCOCK STREET, PORTLAND MAINE
3RD FLOOR LIGHTING PLAN

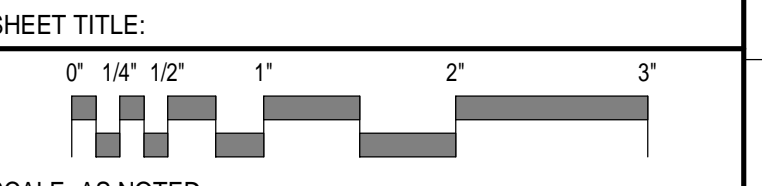

3RD FLOOR LIGHTING PLAN A1
 1/16" = 1'-0"

PROJECT MANAGER:	DJT	PROJECT NO.:	17146
A/E OF RECORD:	DJT		
JOB CAPTAIN:	DTJ		
DRAWN BY:	CDS		
SMRT FILE:	EL103-17146	SHEET No.:	EL103