


**NOTES:**  
 1. SEE SHEET E-001 FOR LEGEND AND GENERAL NOTES.

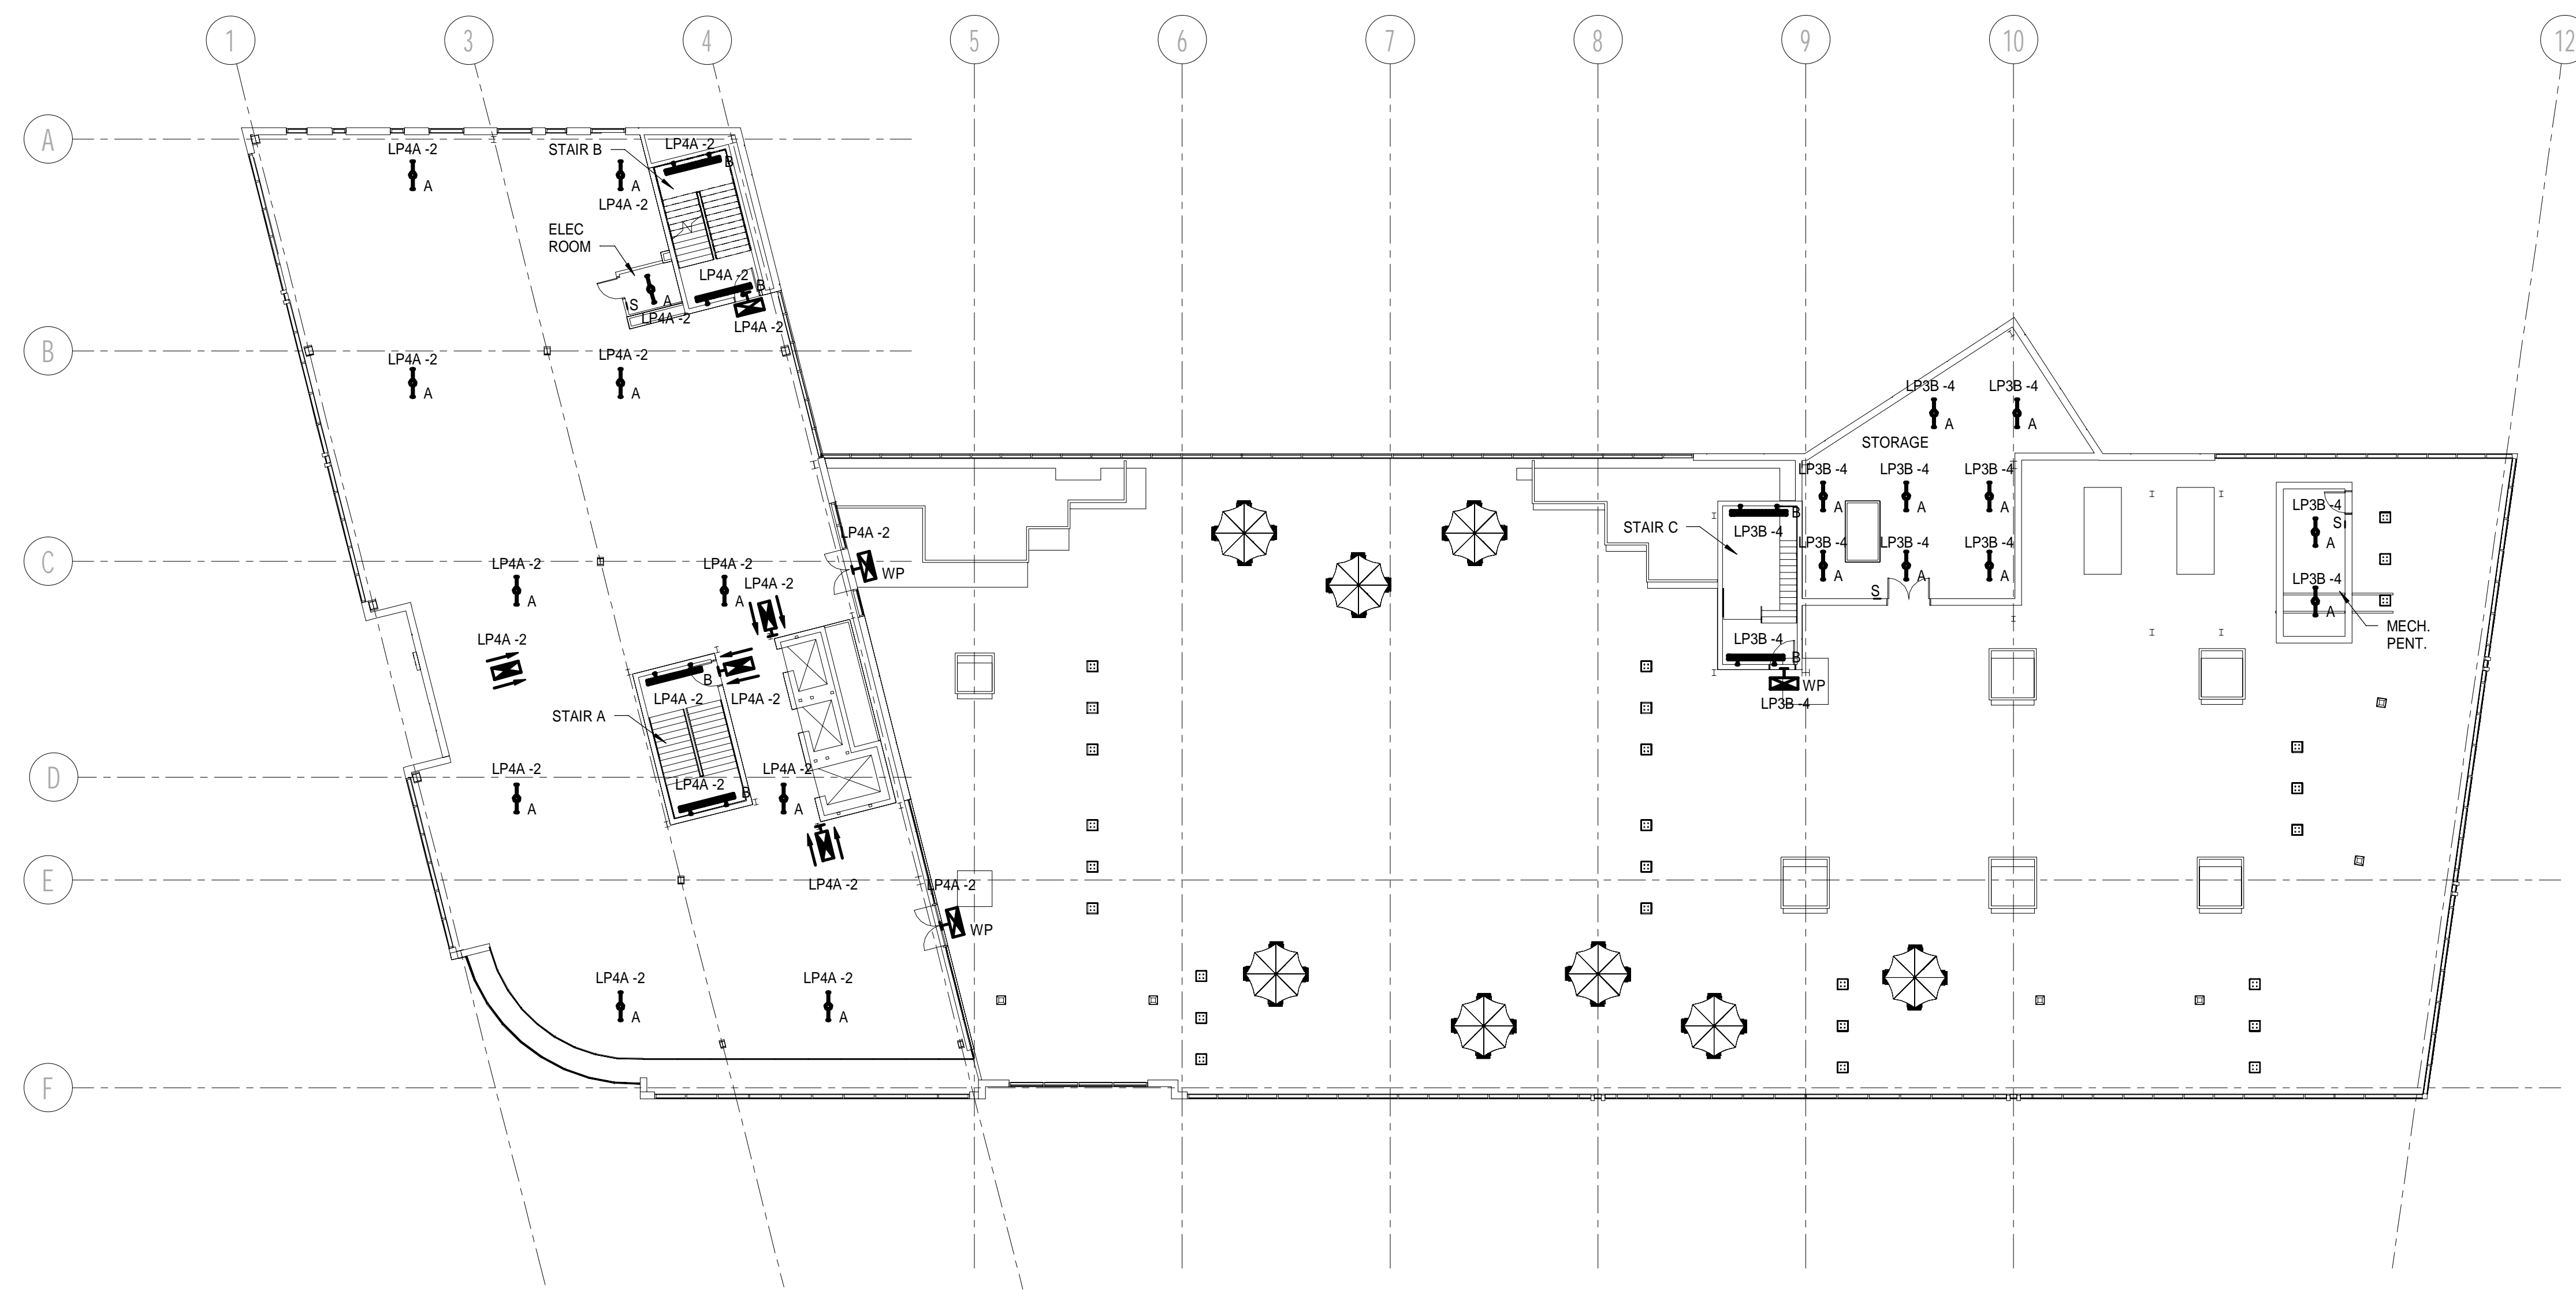

REV	DESCRIPTION	DATE
0	ISSUED FOR PERMIT	10/23/2017

**ISSUED FOR PERMIT**  
 10/23/2017  
 CURRENT ISSUE STATUS:

PROJECT NORTH:

SMRT Architects and Engineers  
 144 Fore Street/P.O. Box 618  
 Portland, Maine 04104


ARCHITECTURE | ENGINEERING | PLANNING | INTERIOR DESIGN | ENERGY SERVICES | **SMRT**

**WEX**

0 HANCOCK STREET, PORTLAND MAINE

**4TH FLOOR LIGHTING PLAN**

SHEET TITLE:

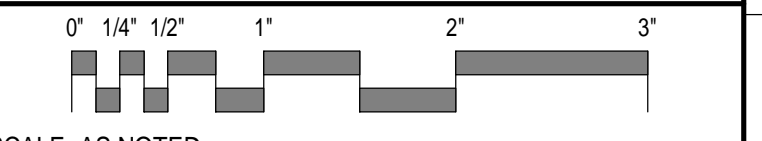

SCALE: AS NOTED

PROJECT MANAGER:	DJT	PROJECT NO.:	17146
A/E OF RECORD:	DJT		
JOB CAPTAIN:	DTJ		
DRAWN BY:	CDS		
SMRT FILE:	EL104-17146	SHEET No.:	<b>EL104</b>

**4TH FLOOR LIGHTING PLAN** (A1)  
 1/16" = 1'-0"