




NOTES:
 1. SEE SHEET E-001 FOR LEGEND AND GENERAL NOTES.

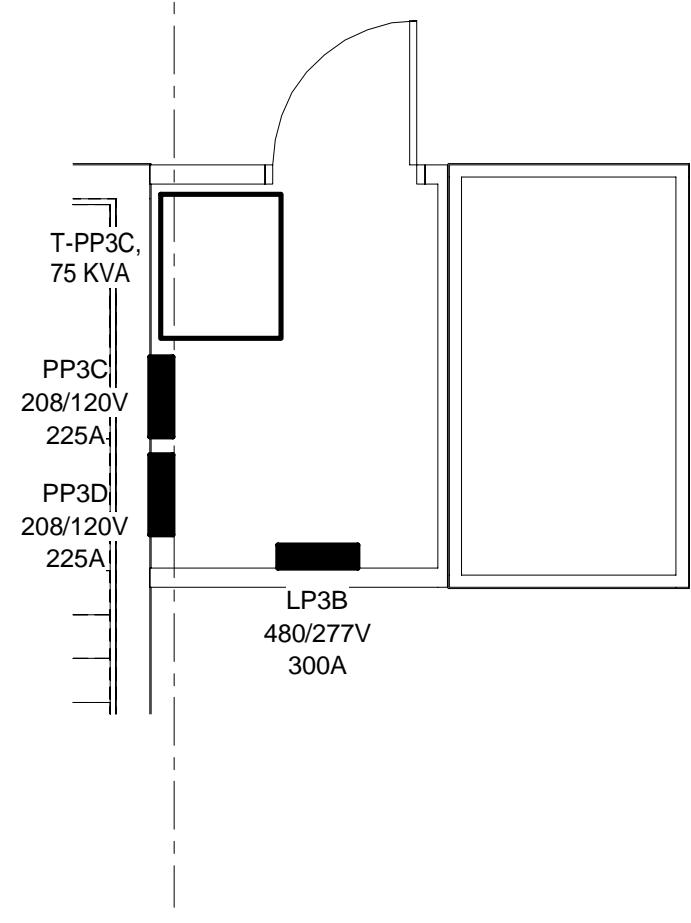

3RD FLOOR ELEC ROOM 2 POWER PLAN (H4)
 1/4" = 1'-0"

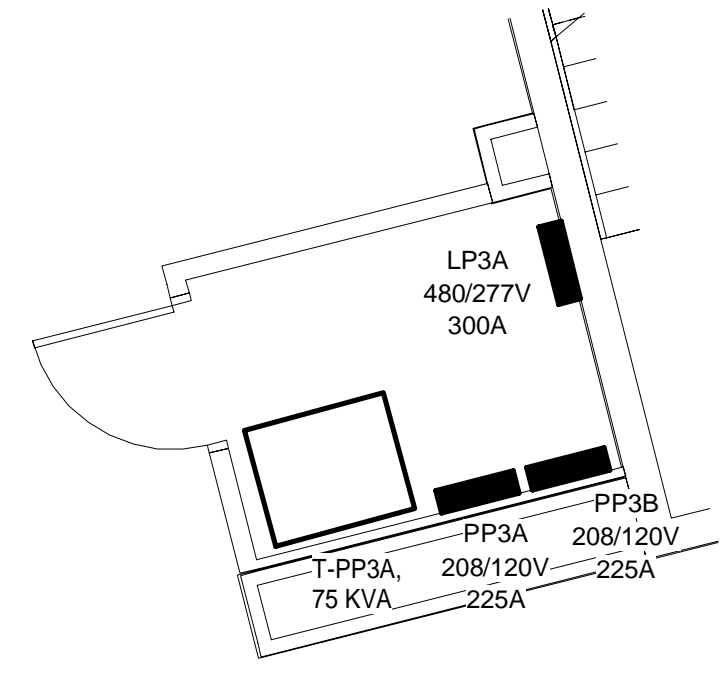

3RD FLOOR ELEC ROOM 1 POWER PLAN (H1)
 1/4" = 1'-0"

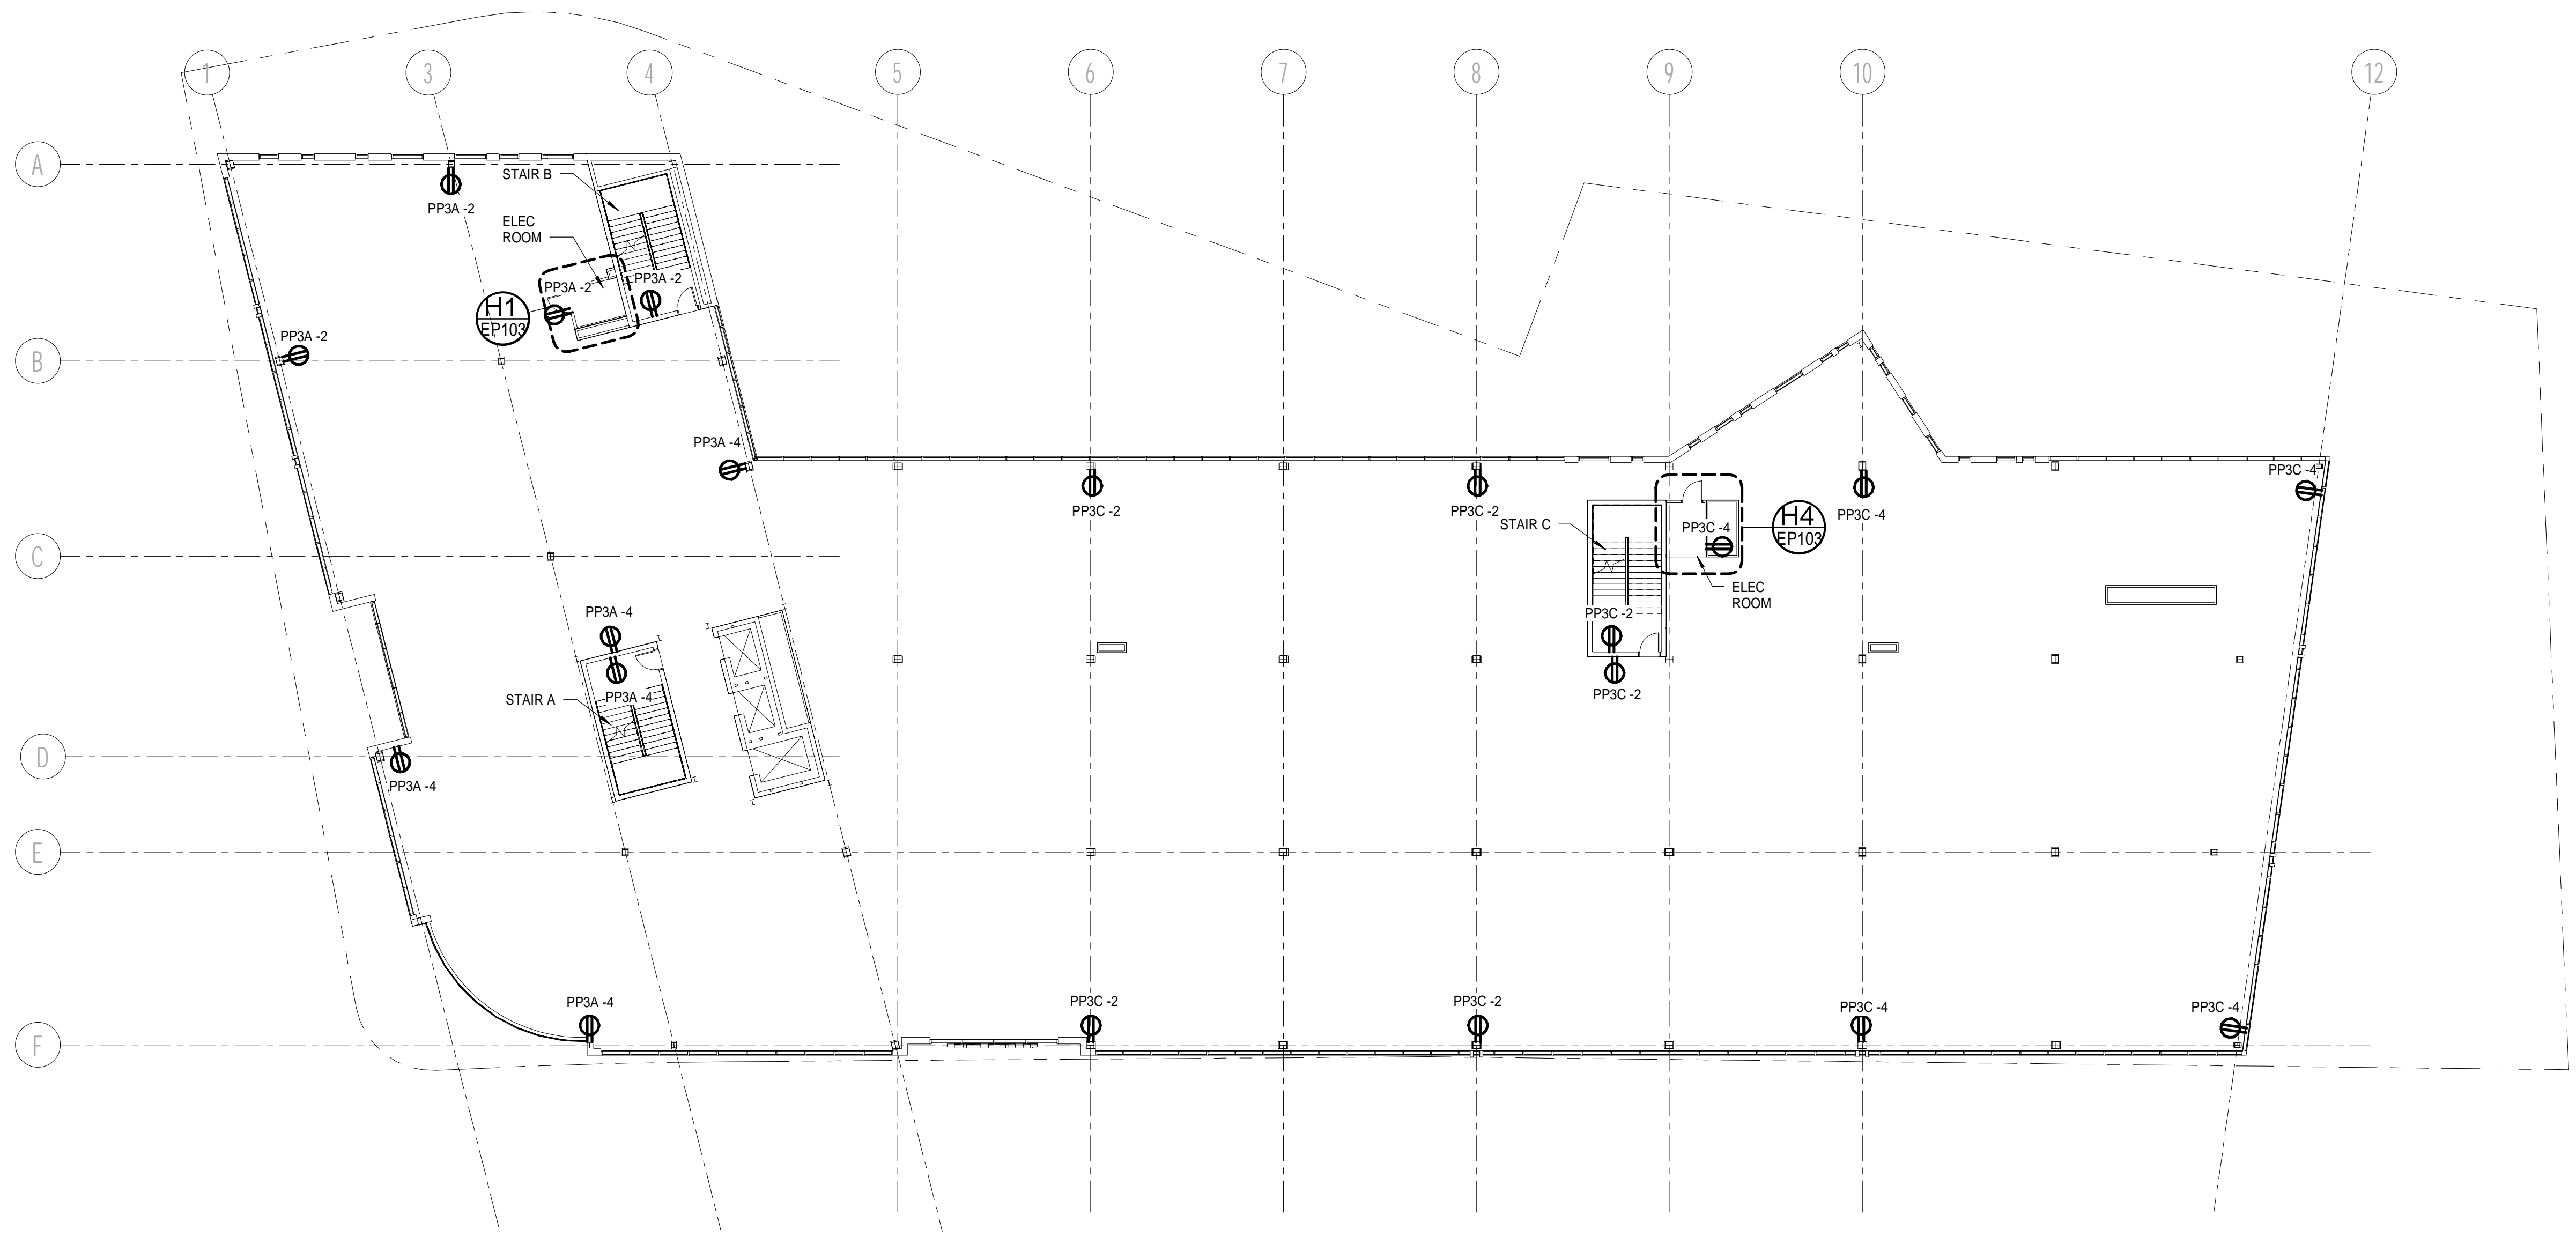

3RD FLOOR POWER PLAN (A1)
 1/16" = 1'-0"

REV	DESCRIPTION	DATE
0	ISSUED FOR PERMIT	10/23/2017

ISSUED FOR PERMIT
 10/23/2017
 CURRENT ISSUE STATUS:

PROJECT NORTH:

SMRT Architects and Engineers
 144 Fore Street/P.O. Box 618
 Portland, Maine 04104

ARCHITECTURE | ENGINEERING | PLANNING | INTERIOR DESIGN | ENERGY SERVICES | **SMRT**

WEX
 0 HANCOCK STREET, PORTLAND MAINE

3RD FLOOR POWER PLAN

SHEET TITLE:
 SCALE: AS NOTED
 0" 1/4" 1/2" 1' 2' 3'

PROJECT MANAGER: DJT PROJECT NO: 17146
 A/E OF RECORD: DJT
 JOB CAPTAIN: DTJ
 DRAWN BY: CDS
 SMRT FILE: EP103-17146 SHEET No. EP103