


CABLE SCHEDULE:

- 8#500 KCML/Ø (24 CONDUCTORS) & 6#500 KCML NEUTRALS, 8-4"C
- 4#350 KCML& #4 GND, 3"C
- 3#2 AWG & #8 GND
- 4#600 KCML & #3 GND, 3 1/2"C
- 3#8 AWG & #10 GND, 3/4"C
- 4#2 AWG & #8 GND, 1 1/4"C
- 4#4/0 AWG & #2 GND, 2 1/2"C

0	ISSUED FOR PERMIT	10/23/2017
REV	DESCRIPTION	DATE

ISSUED FOR PERMIT
10/23/2017

CURRENT ISSUE STATUS:

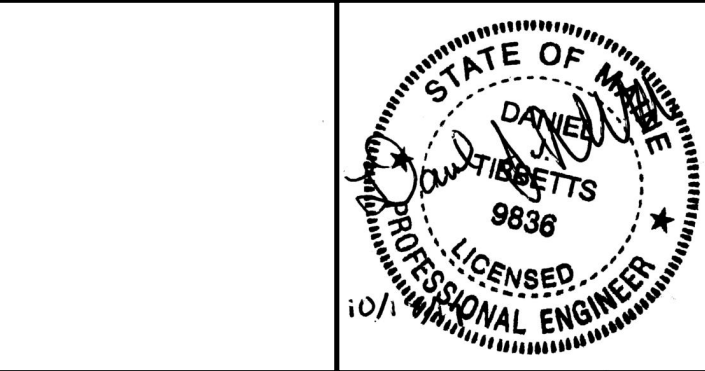

SMRT Architects and Engineers
144 Fore Street/P.O. Box 618
Portland, Maine 04104


ARCHITECTURE | ENGINEERING | PLANNING | INTERIOR DESIGN | ENERGY

WEX

0 HANCOCK STREET, PORTLAND MAINE

ONE-LINE DIAGRAM

 SHEET TITLE:



SCALE: AS NOTED

PROJECT MANAGER: DJT PROJECT NO: 17146

A/E OF RECORD: DJT

JOB CAPTAIN: DTJ

DRAWN BY: CDS

SMRT FILE: EP651-17146 SHEET No. 17146

EP651

© COPYRIGHT 2015 SMRT INC