



1 5TH FLOOR DWV
1/8" = 1'-0"

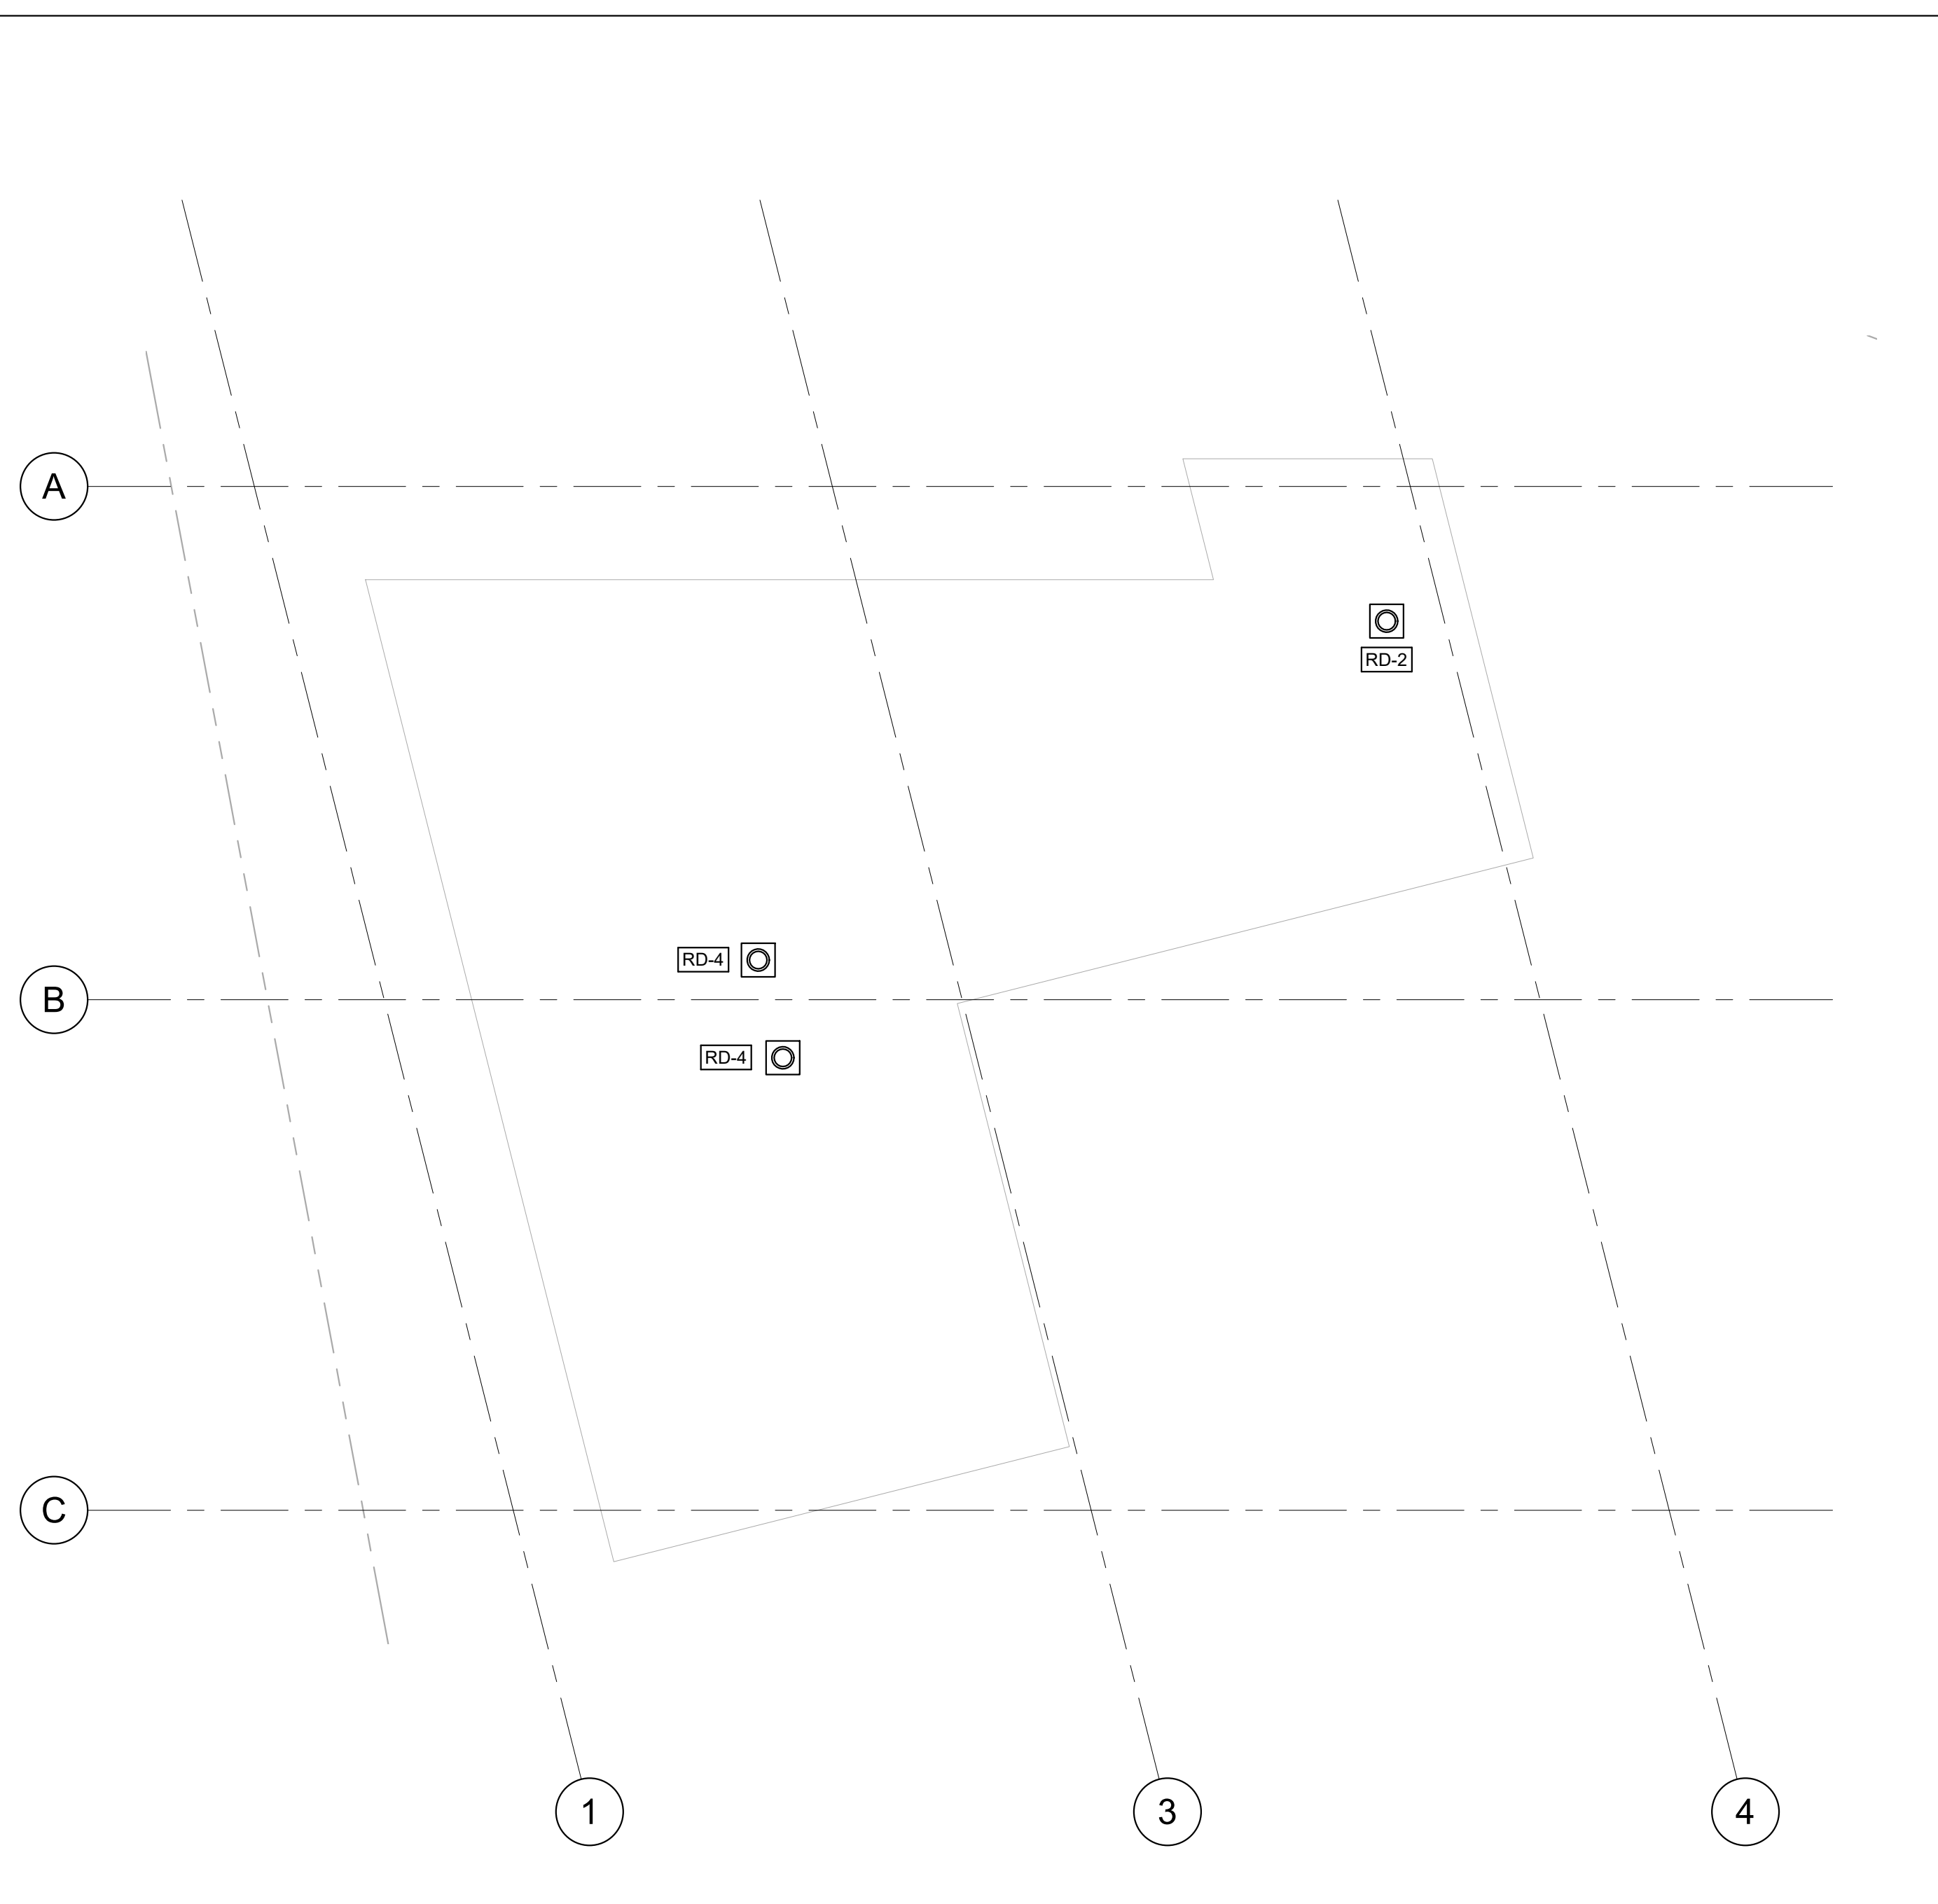

2 PENTHOUSE ROOF PLAN
1/8" = 1'-0"

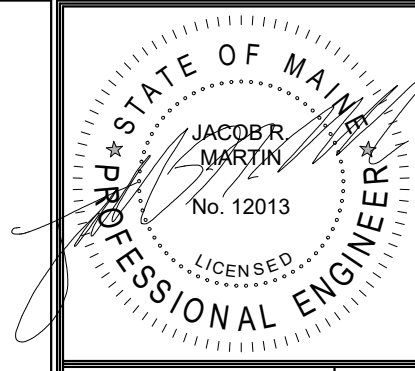

Prepared For:

Consultant:
JOHNSON & JORDAN
MECHANICAL CONTRACTORS
18 FAIRBURY ROAD, PORTLAND, ME 04101
SCADAISEY ROAD, PORTLAND, ME 04107
TEL: (207) 883-8345

Architect:
ARCHETYPE
architects
48 Union Wharf, Portland, Maine 04101
(207) 772-6022, ARCHETYPE@ARCHETYPEPEPACOM

Project:
0 HANCOCK STREET
HANCOCK STREET, PORTLAND, MAINE

Revisions:
ISSUED FOR PERMIT
10/20/17

Date: Oct 20 2017
Scale: 1/8" = 1'-0"
PENTHOUSE DWV PLAN

PL105