

MH101B

FIRST FLOOR HVAC DUCTWORK PLAN

Date: JAN. 3, 2018


 


Scale: 1/8" = 1'-0"

FO Phase
Design Development
03/10/2018

Project: 0 HANCOCK STREET
Architect: ARCHITECTS
48 Union Wharf, Portland, Maine 04101
(207) 772-6022 ARCHTYPE@ARCHTYPEPA.COM

Consultant: JOHNSON & JORDAN
MECHANICAL CONTRACTORS
18 MUSSEY AVENUE
SCARBOROUGH, ME 04074
TEL: (207) 883-8345

Prepared For:

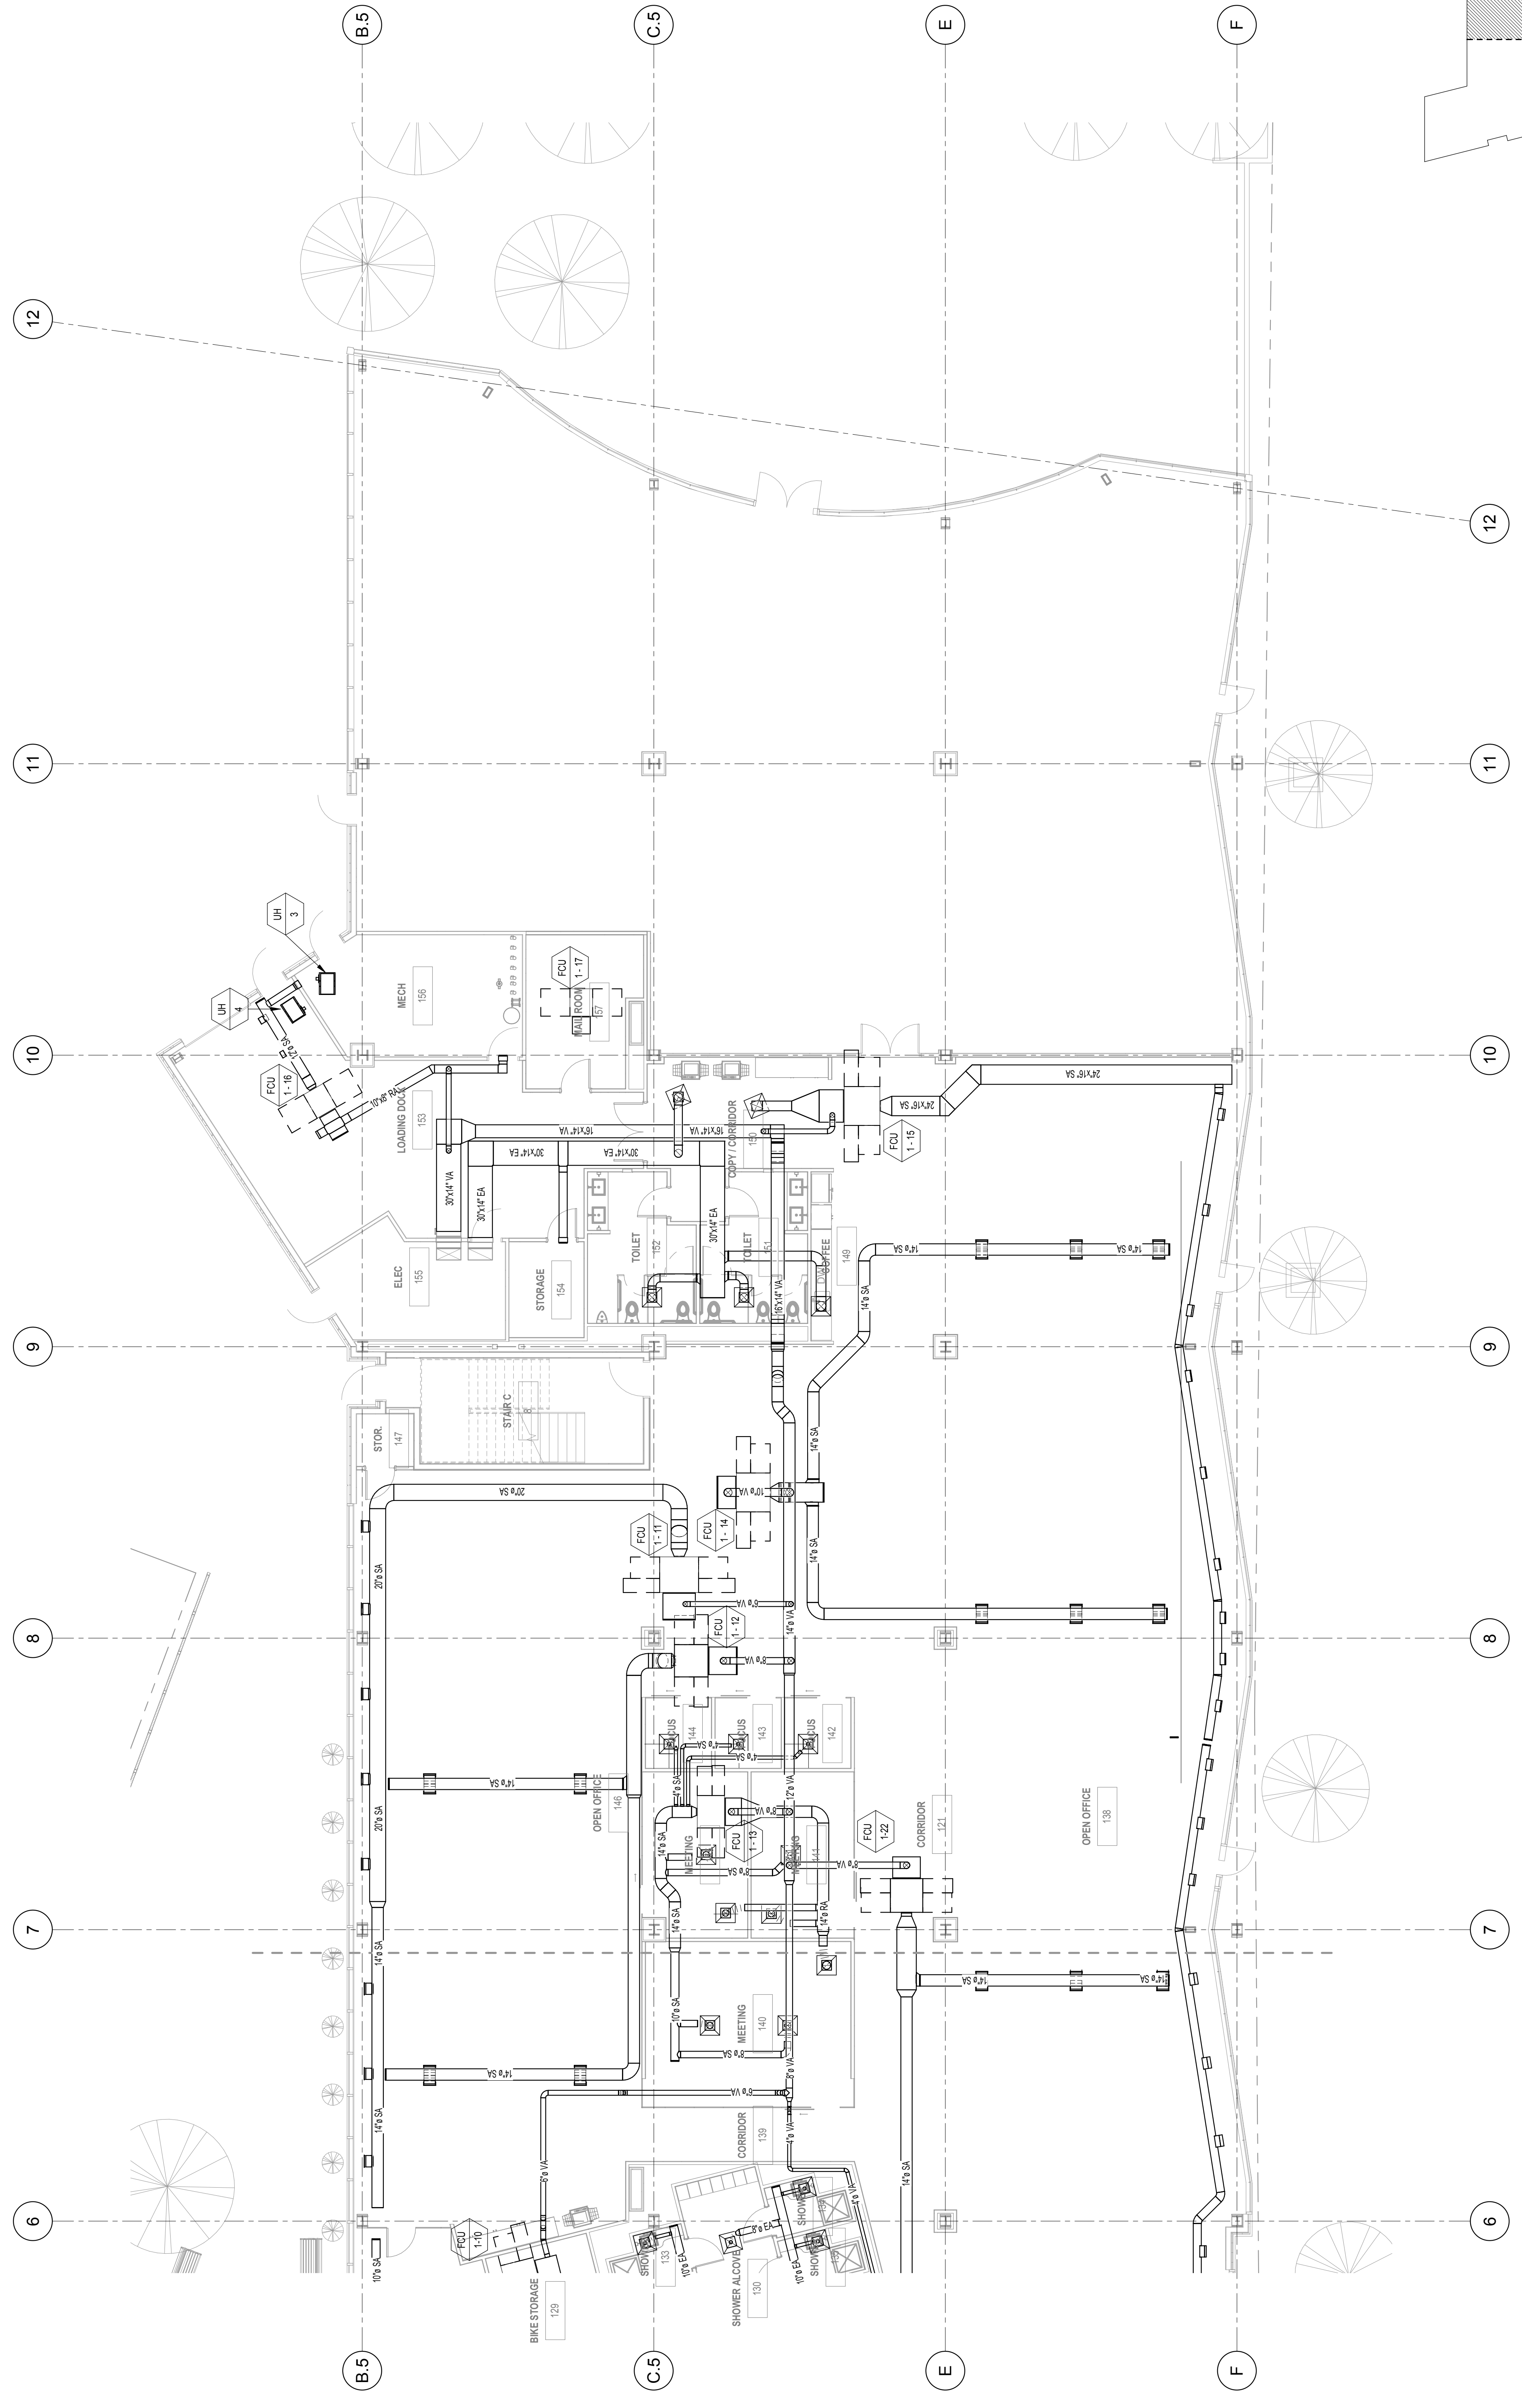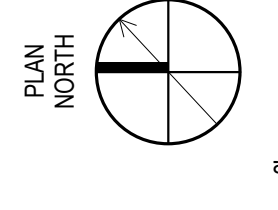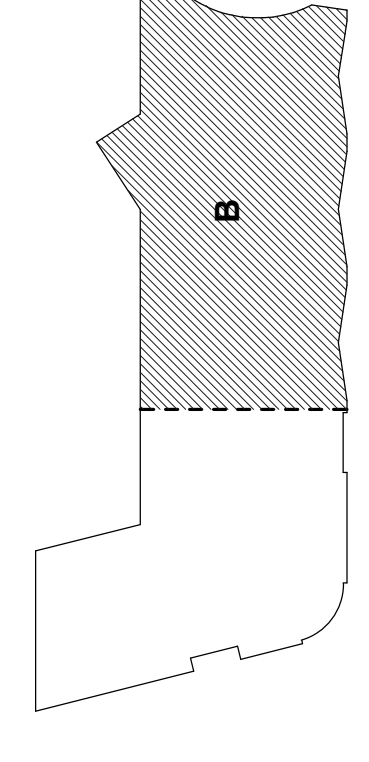

1 1ST FLOOR HVAC DUCTWORK PLAN B
1/8" = 1'-0"