


MH102B

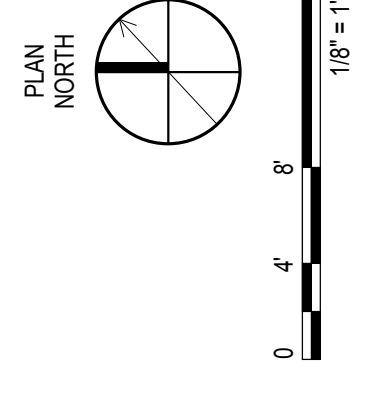

SECOND FLOOR HVAC
DUCTWORK PLAN

Date: JAN. 3, 2018
Scale: 1/8" = 1'-0"


Revisions:
FO Phase
Design Development
03/10/2018

Project: 0 HANCOCK STREET
0 HANCOCK STREET, PORTLAND, MAINE

Architect: ARCHETYPE
48 Union Wharf, Portland, Maine 04101
(207) 772-6022 ARCHETYPE@ARCHETYPEPA.COM

Consultant: JOHNSON & JORDAN
MECHANICAL CONTRACTORS
18 MUSSEY ROAD
SCARBOROUGH, ME 04074
TEL: (207) 883-8345

Prepared For:

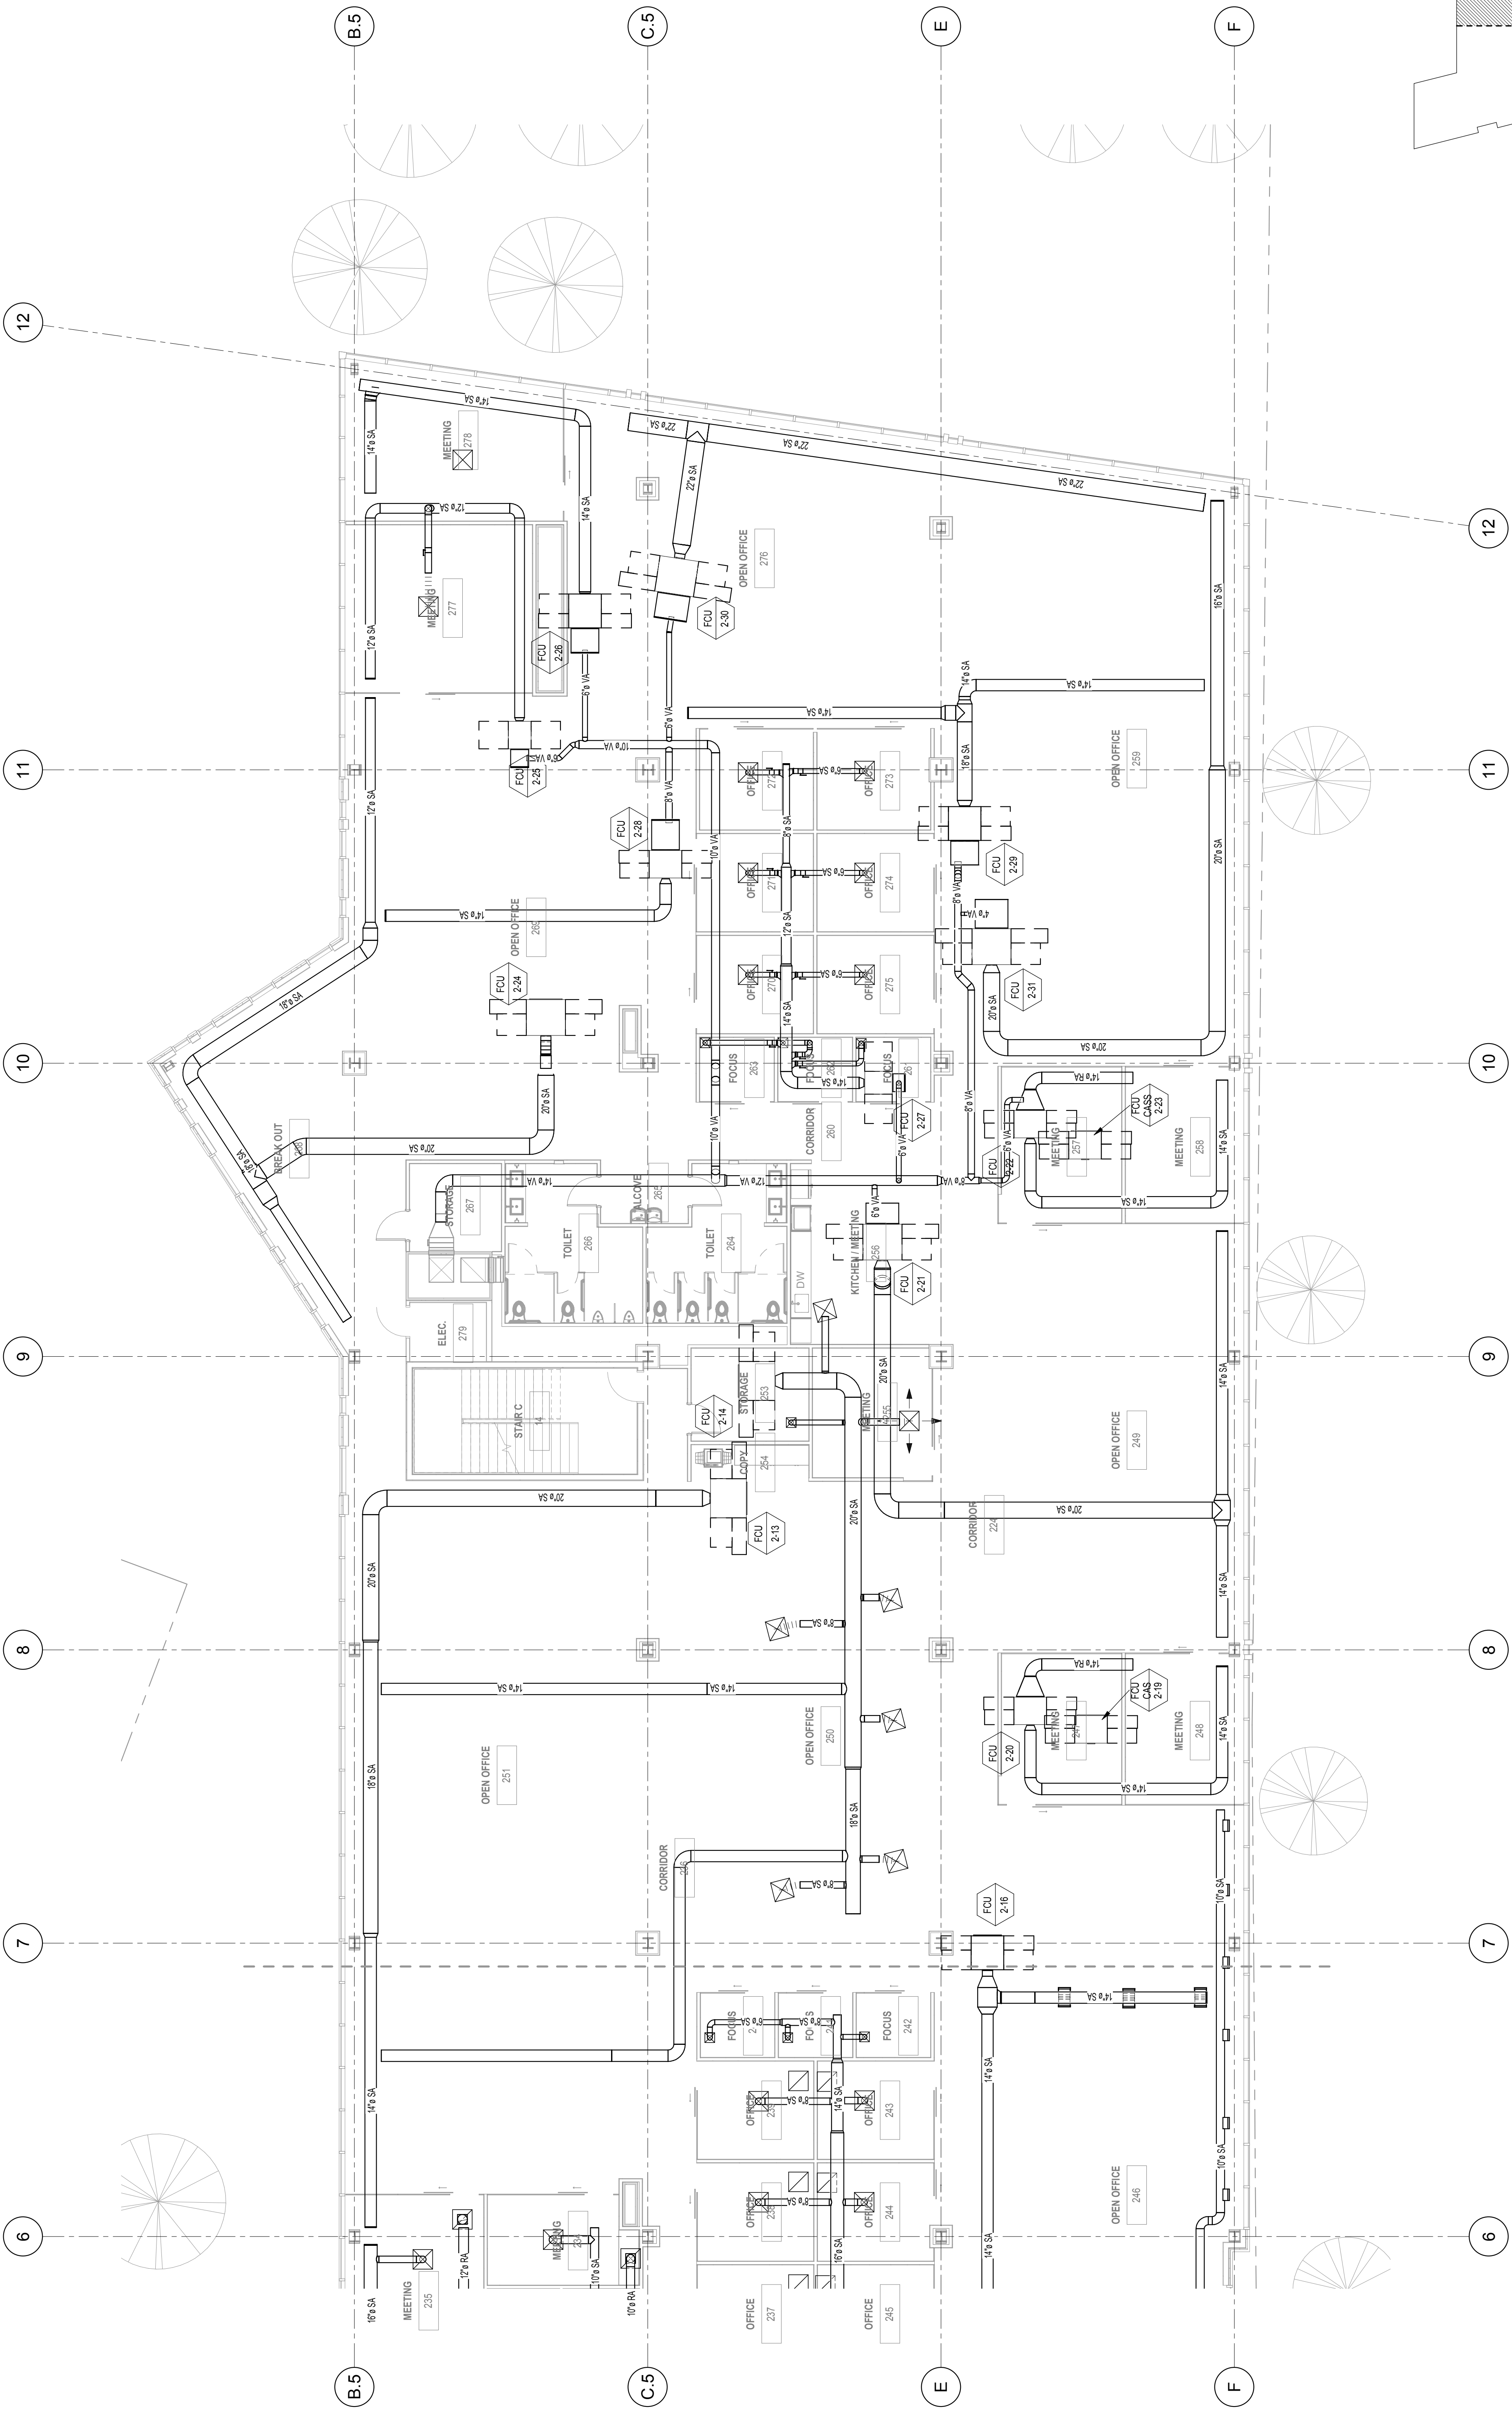

1 2ND FLOOR HVAC DUCTWORK PLAN B
1/8" = 1'-0"