

MH104B

FOURTH FLOOR HVAC DUCTWORK PLAN

Date: JAN. 3, 2018

Scale: 1/8" = 1'-0"


FO Phase
Design Development
03/10/2018

Project: 0 HANCOCK STREET
0 HANCOCK STREET
PORTLAND, MAINE

Architect: ARCHETYPE
48 Union Wharf, Portland, Maine 04101
(207) 772-6022 ARCHETYPE@ARCHETYPEPA.COM


Consultant: JOHNSON & JORDAN
MECHANICAL CONTRACTORS
18 MUSSEY AVENUE
SCARBOROUGH, ME 04074
TEL: (207) 883-8345

Prepared For:

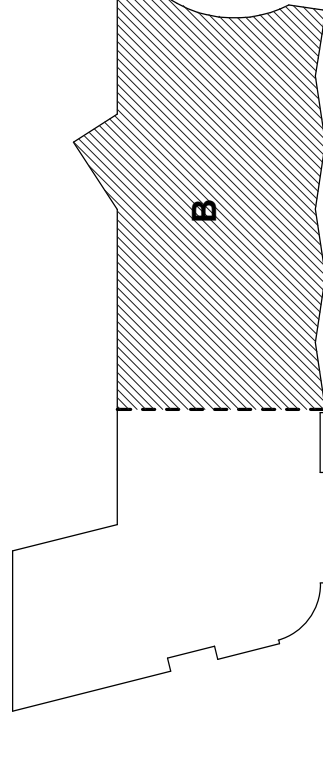


KEY PLAN

PLAN NORTH

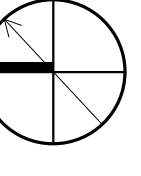

0 4 8 16
1/8" = 1'-0"

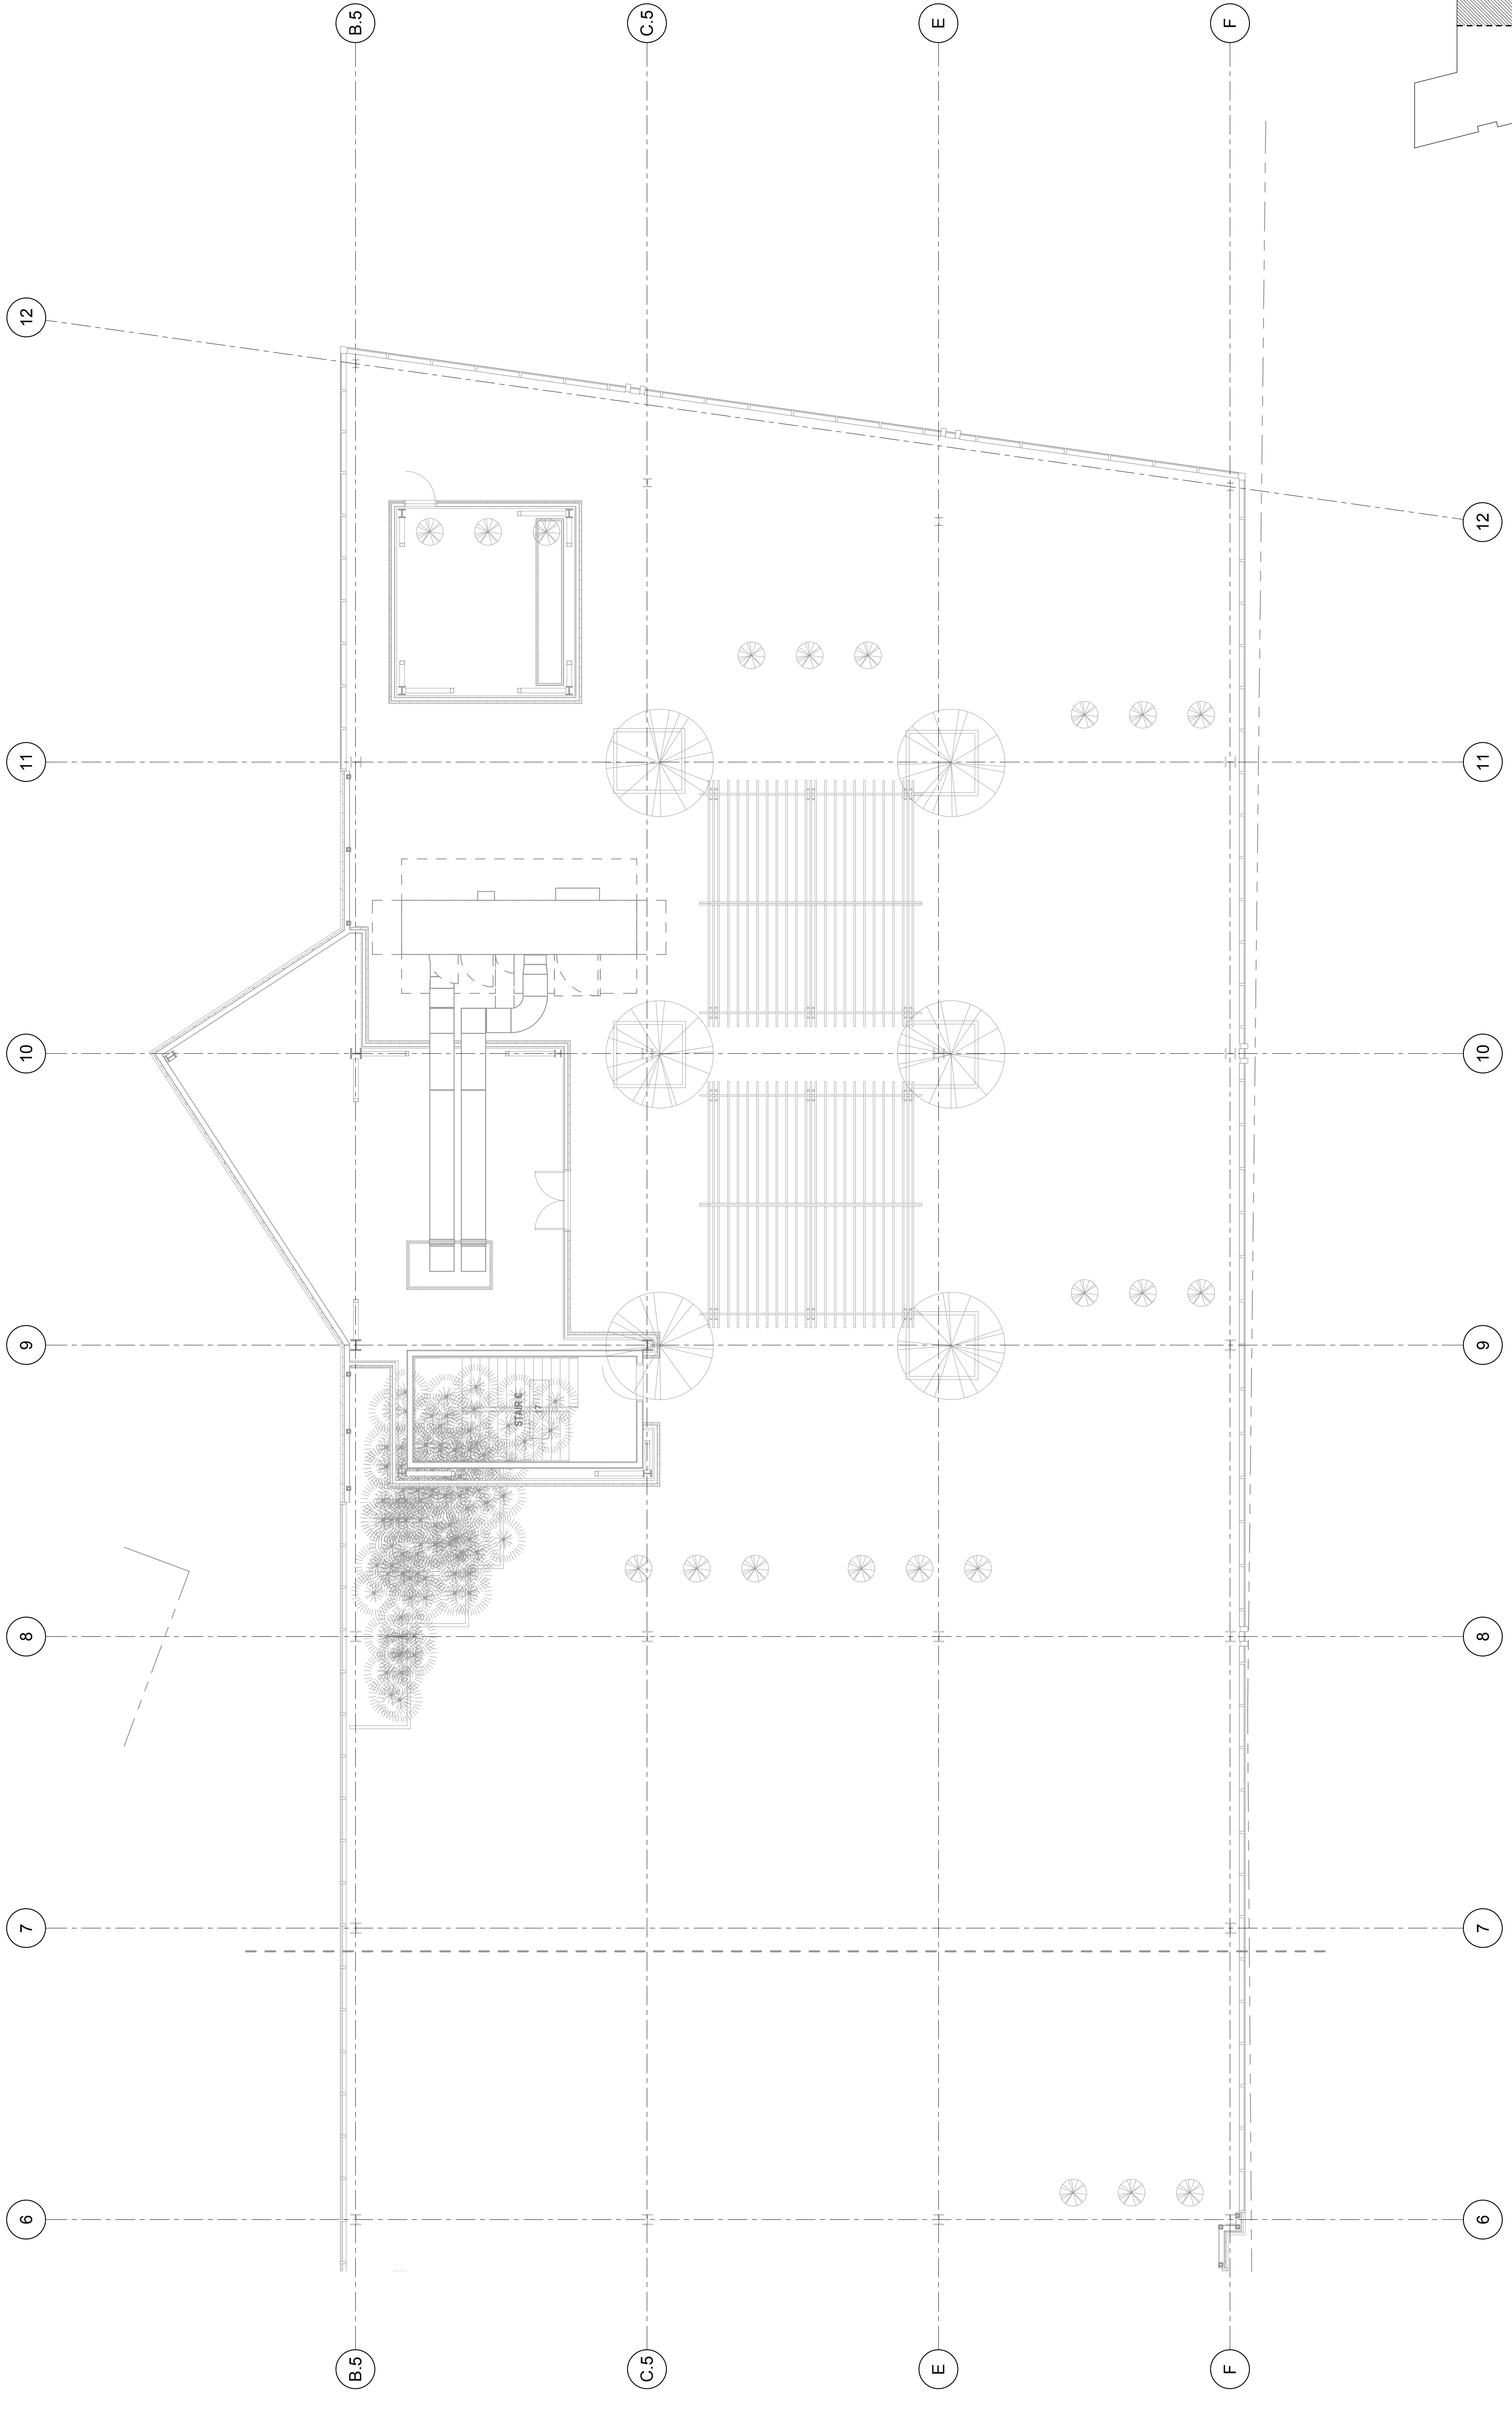

① 4TH FLOOR HVAC DUCTWORK PLAN B
1/8" = 1'-0"