

MP104B

FOURTH FLOOR HVAC
PIPING PLAN




Date: JAN. 3, 2018
Scale: 1/8" = 1'-0"

FO Phase
Design Development
03/10/2018

Project: 0 HANCOCK STREET
Architect: ARCHETYPE
48 Union Wharf, Portland, Maine 04101
(207) 772-6022 ARCHETYPE@ARCHETYPEPA.COM

Consultant: JOHNSON & JORDAN
MECHANICAL CONTRACTORS
18 MUSSEY ROAD
SCARBOROUGH, ME 04074
TEL: (207) 883-8345

Prepared For:

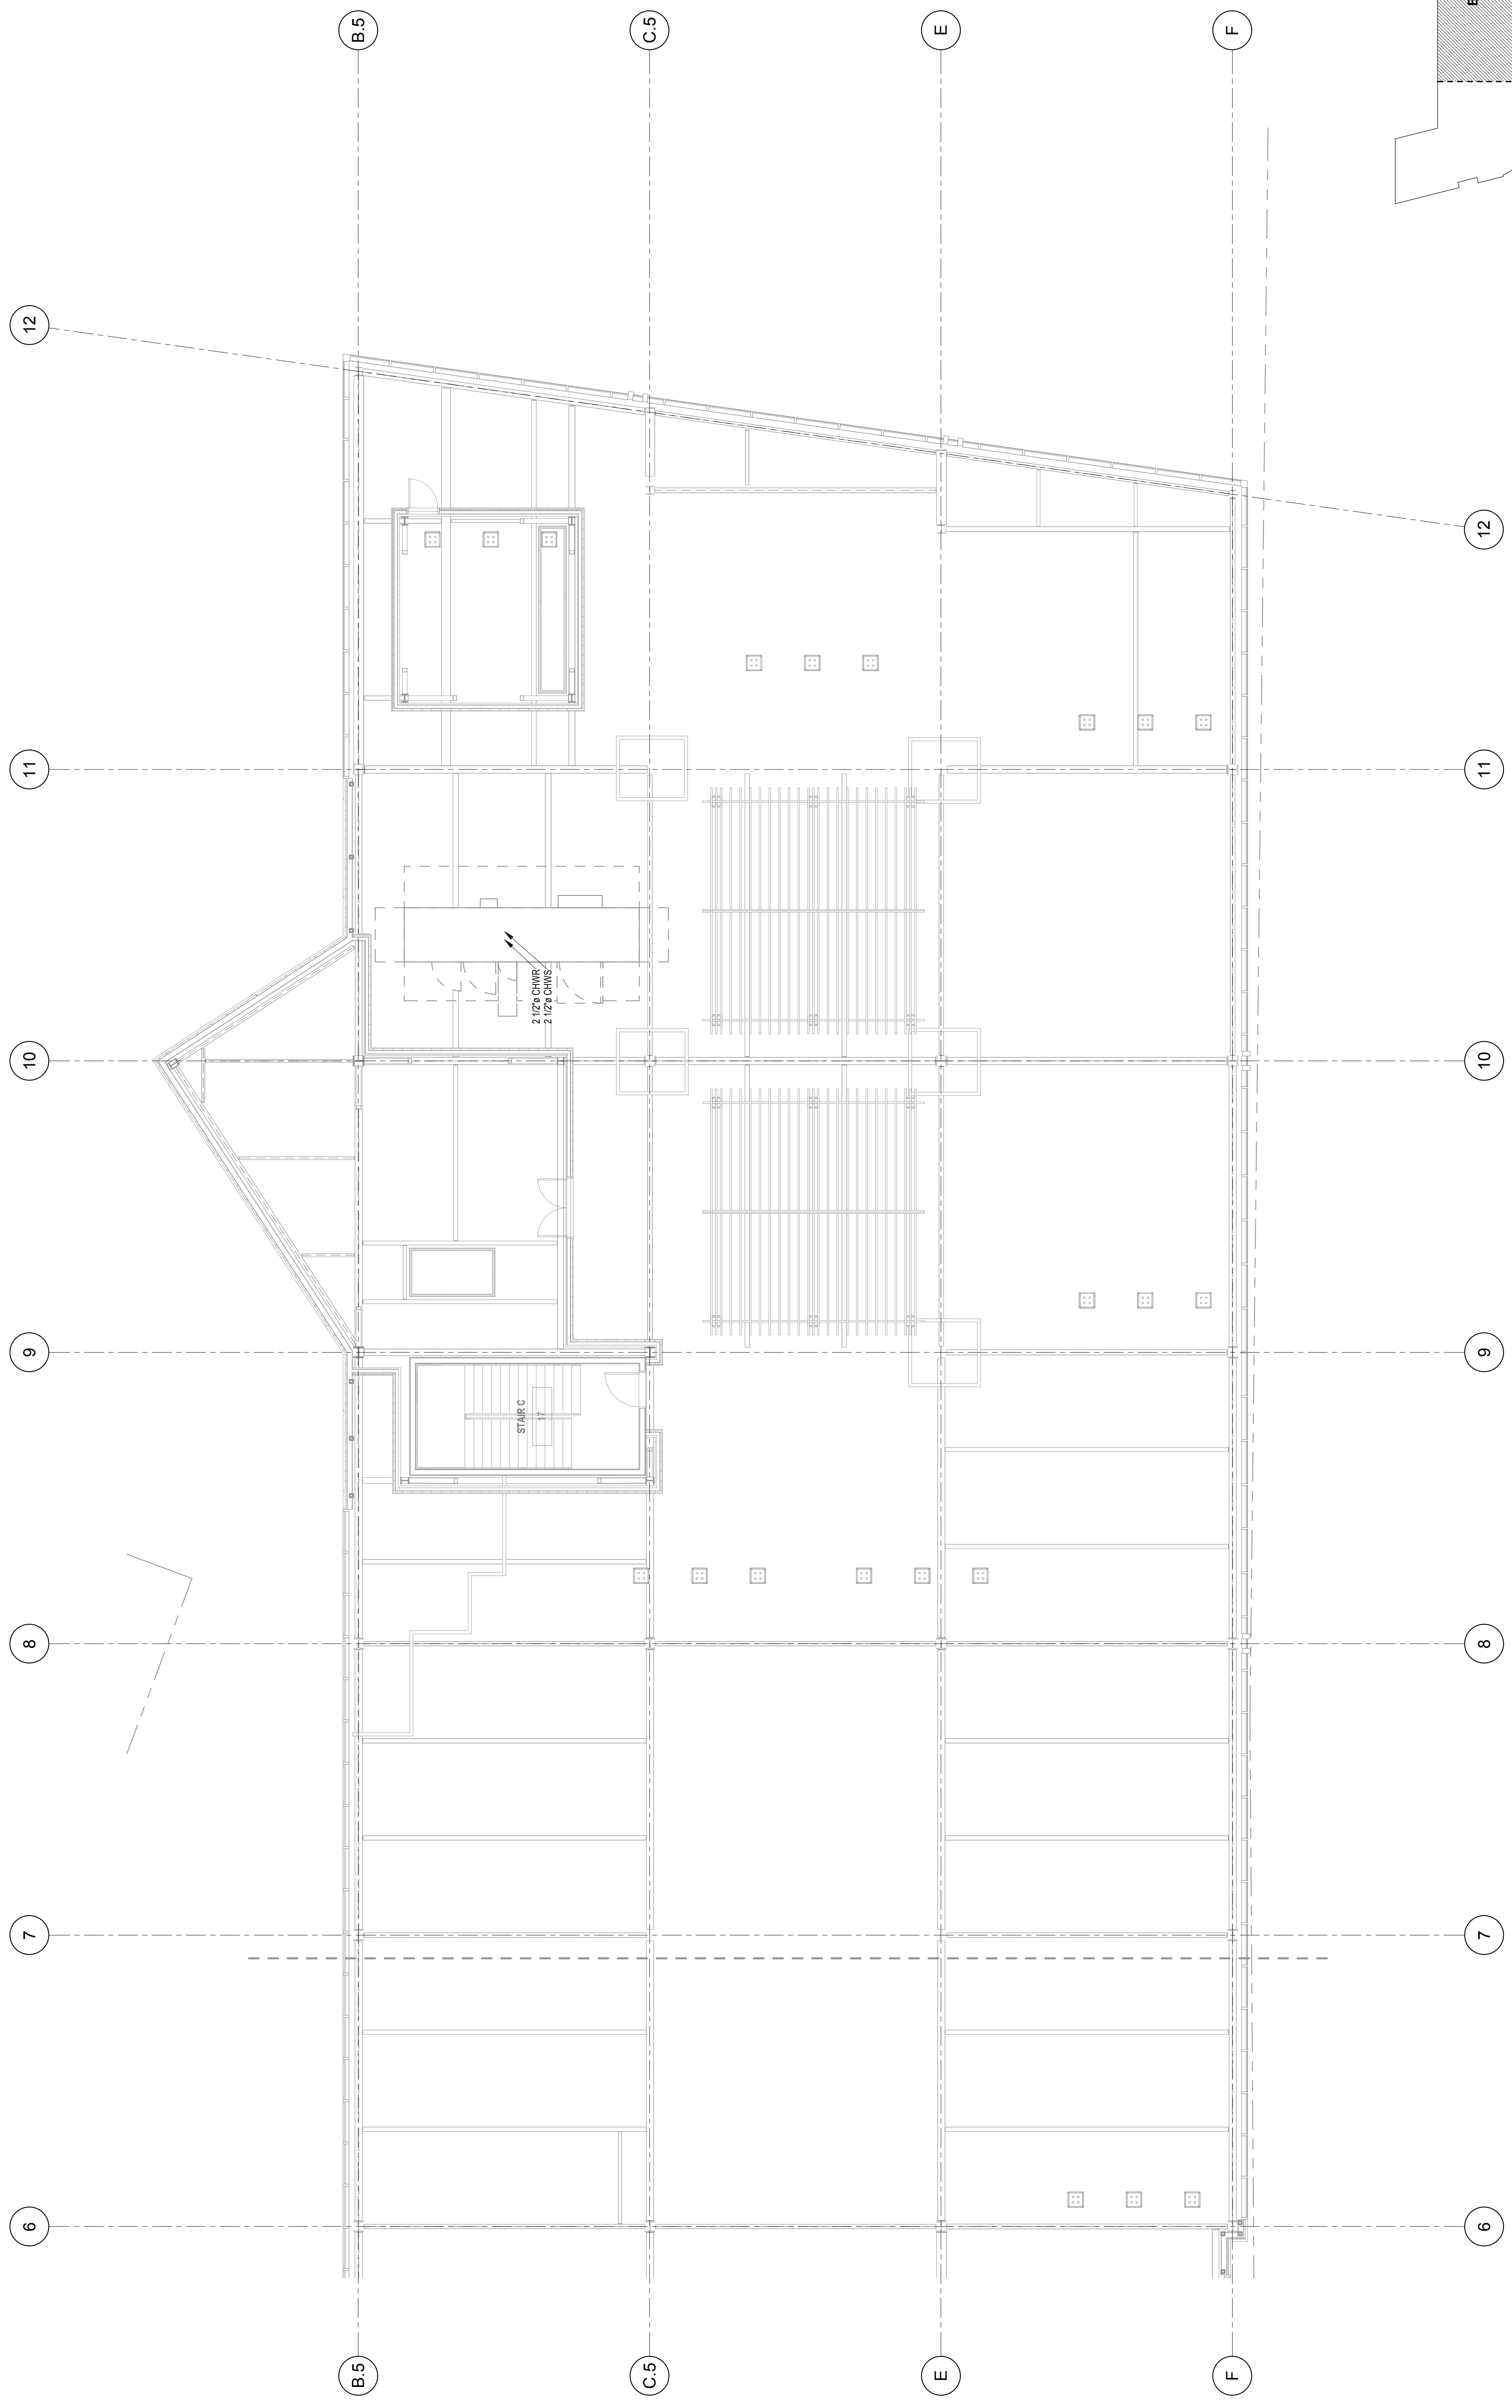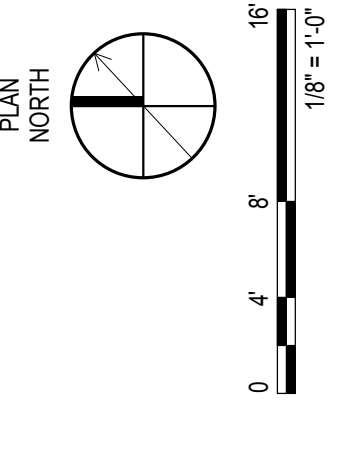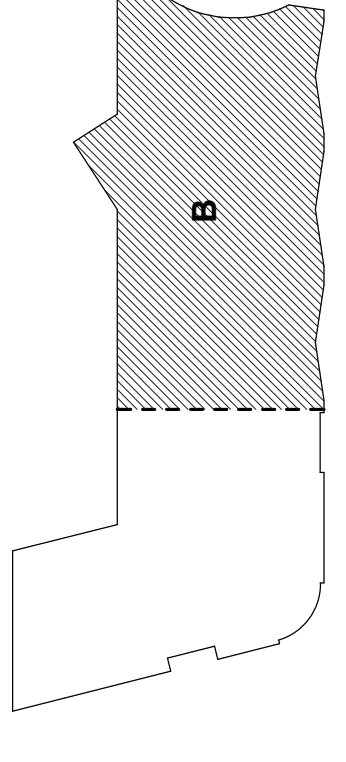

① 4TH FLOOR HVAC PIPING PLAN B
1/8" = 1'-0"