

DATE of APPROVAL October 4, 2017
 PLANNER Caitlin Cameron
 PROJECT NO. 2017-180
 Scarborough, Maine 04074-8929
 Tel. 207.883.3355
 www.stantec.com


Copyright Reserved
 The Contractor shall verify and be responsible for all dimensions. DO NOT scale the drawing - any errors or omissions shall be reported to Stantec without delay.
 The Copyrights to all designs and drawings are the property of Stantec. Reproduction or use for any purpose other than that authorized by Stantec is forbidden.

Consultants
 ARCHITECT ARCHETYPE
 LANDSCAPE ARCHITECT MOHR & SEREDIN
 SURVEYOR OWEN HASKELL
 CONTRACTOR CIANBRO


Notes

REVISION	DATE	BY	APPROVED
1	17.07.17	SRB	YTW/MD
2	17.07.17	SRB	
3	17.07.17	SRB	
4	17.07.17	SRB	


1 - ISSUED FOR CONSTRUCTION/UTILITY PLANS
 2 - REVISED PER CONDITIONS OF APPROVAL RELEASED FOR BIDDING
 3 - REVISED PER CONSTRUCTION/UTILITY PLAN REVIEW PREP TO OCT. 4, 2017 PUBLIC HEARING
 4 - FINAL SITE PLAN REVIEW

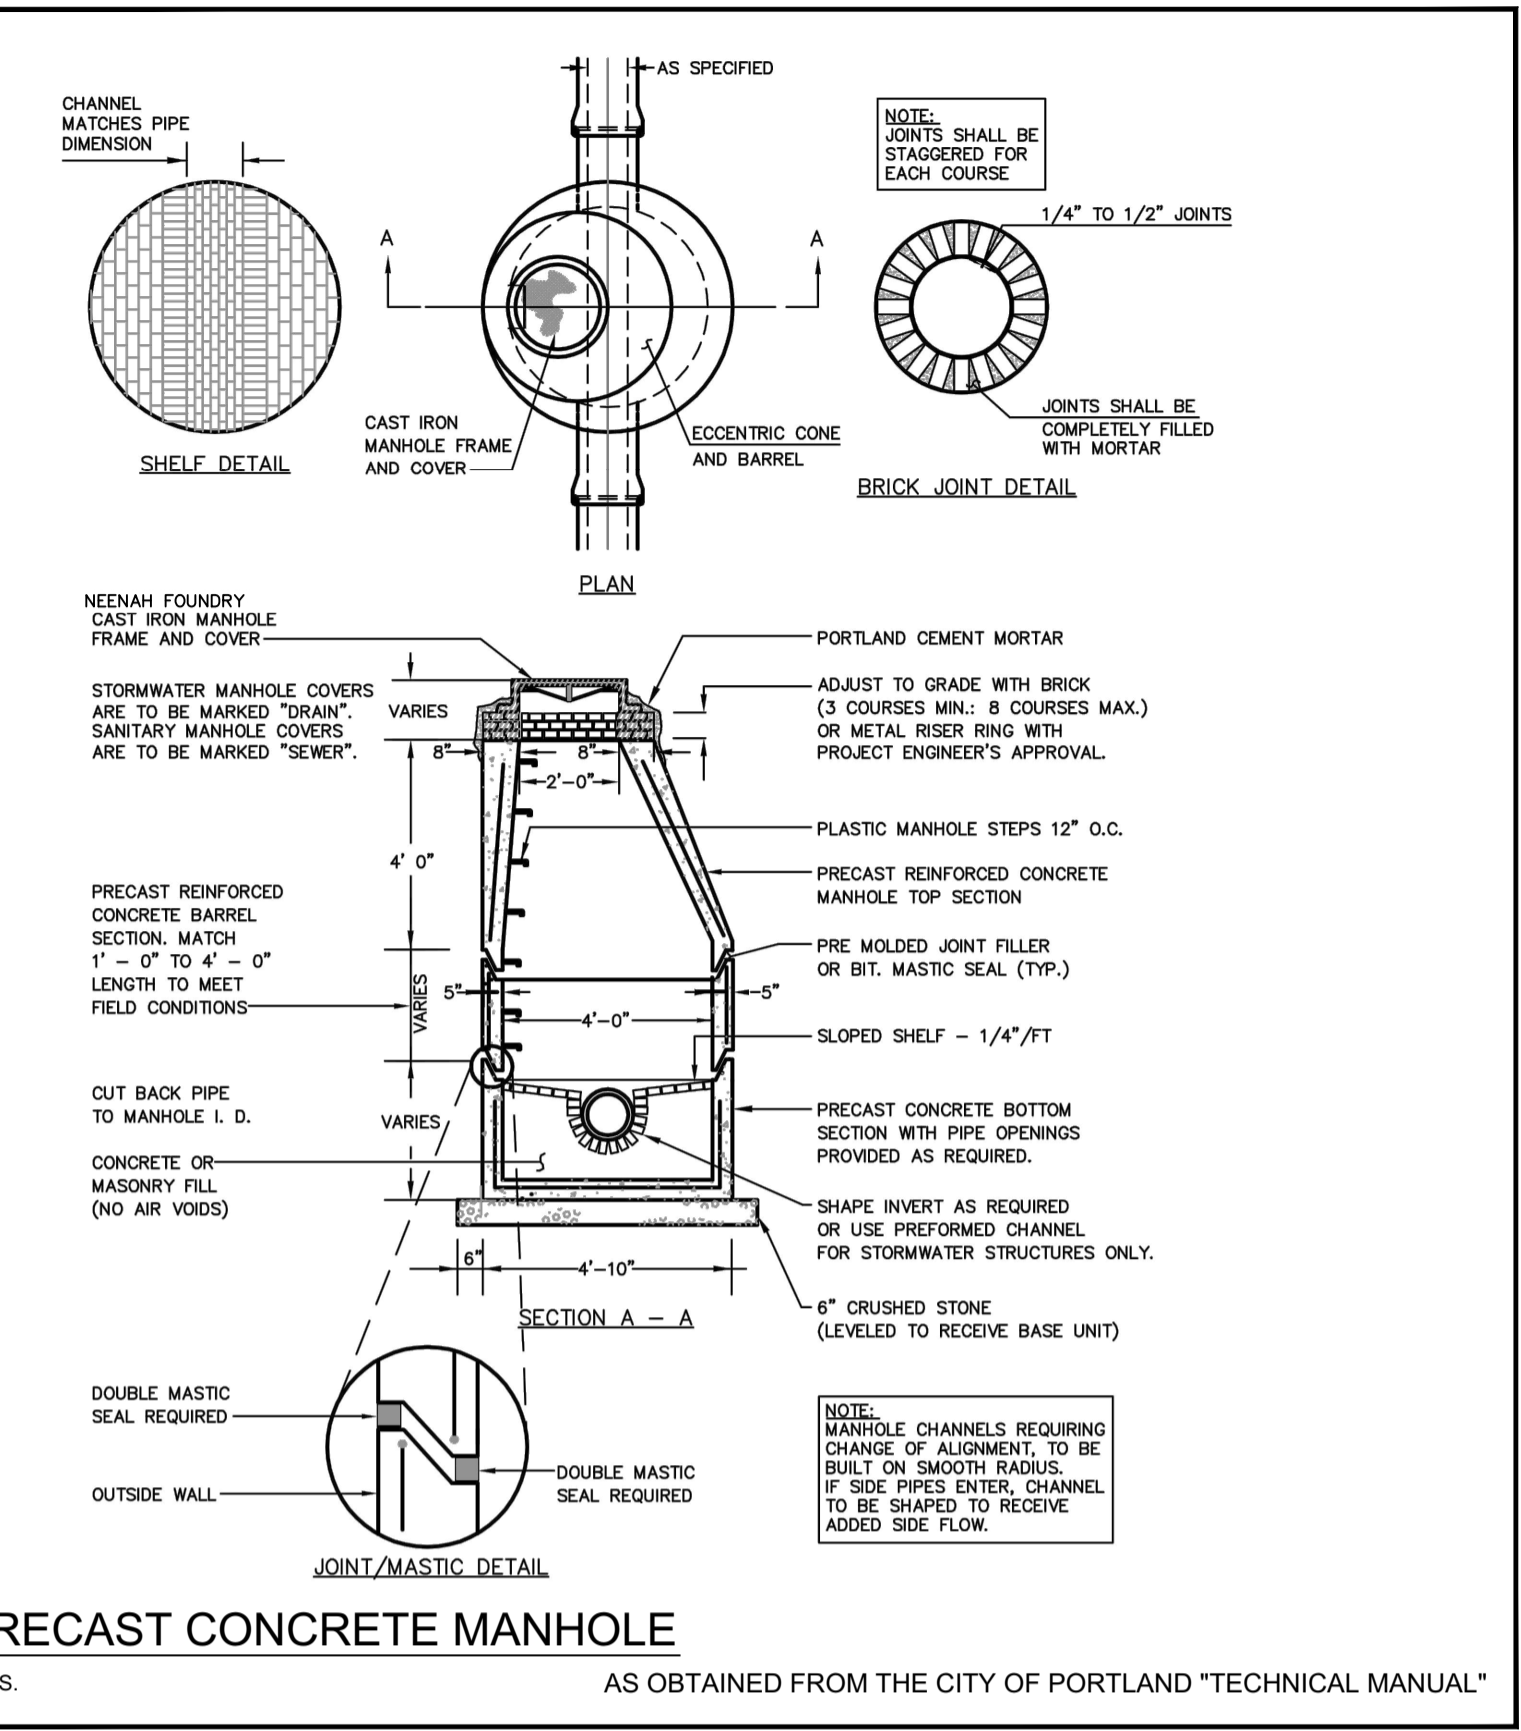


A PRECAST CONCRETE MANHOLE
 N.T.S. AS OBTAINED FROM THE CITY OF PORTLAND "TECHNICAL MANUAL"

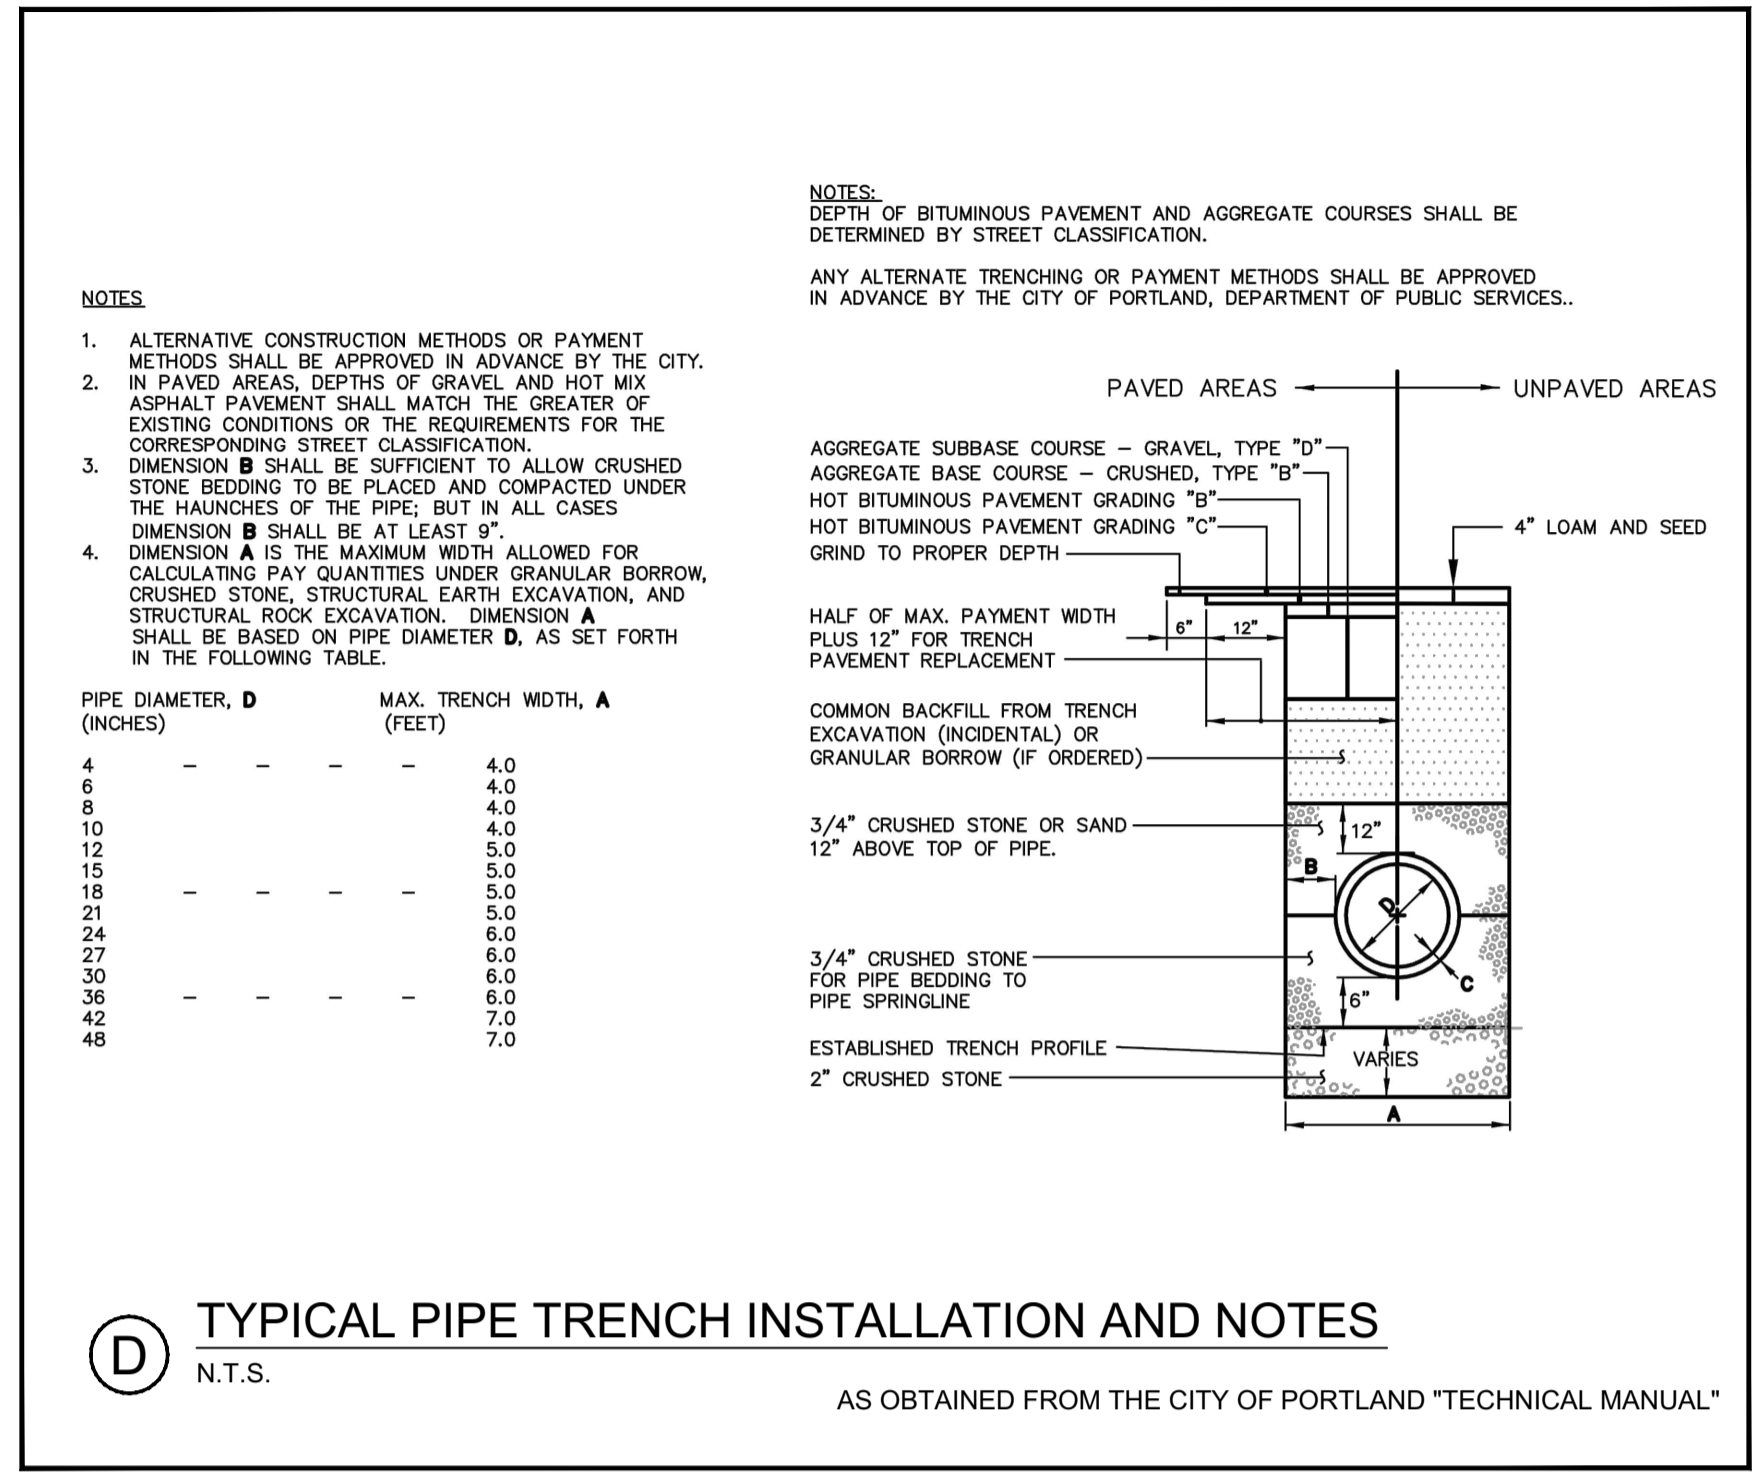


D TYPICAL PIPE TRENCH INSTALLATION AND NOTES
 N.T.S. AS OBTAINED FROM THE CITY OF PORTLAND "TECHNICAL MANUAL"

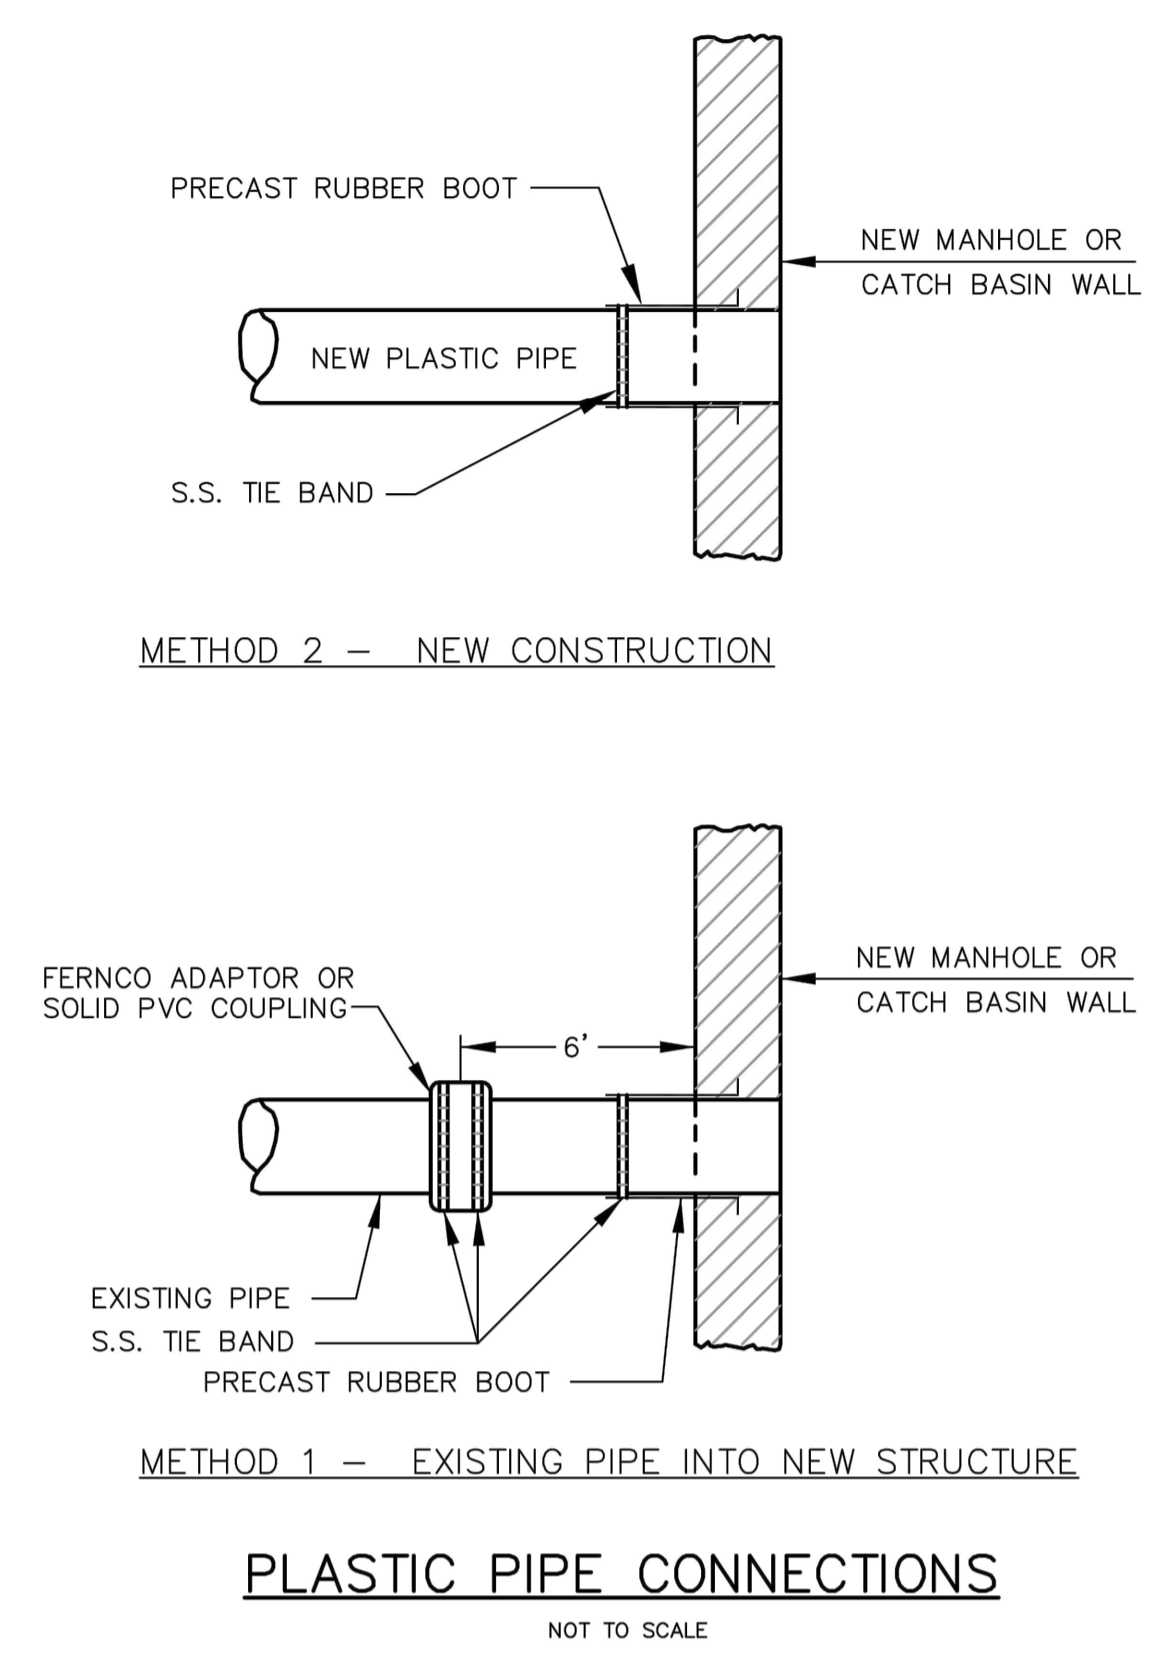


H PLASTIC PIPE CONNECTION METHODS 1 & 2
 N.T.S. AS OBTAINED FROM THE CITY OF PORTLAND "TECHNICAL MANUAL"

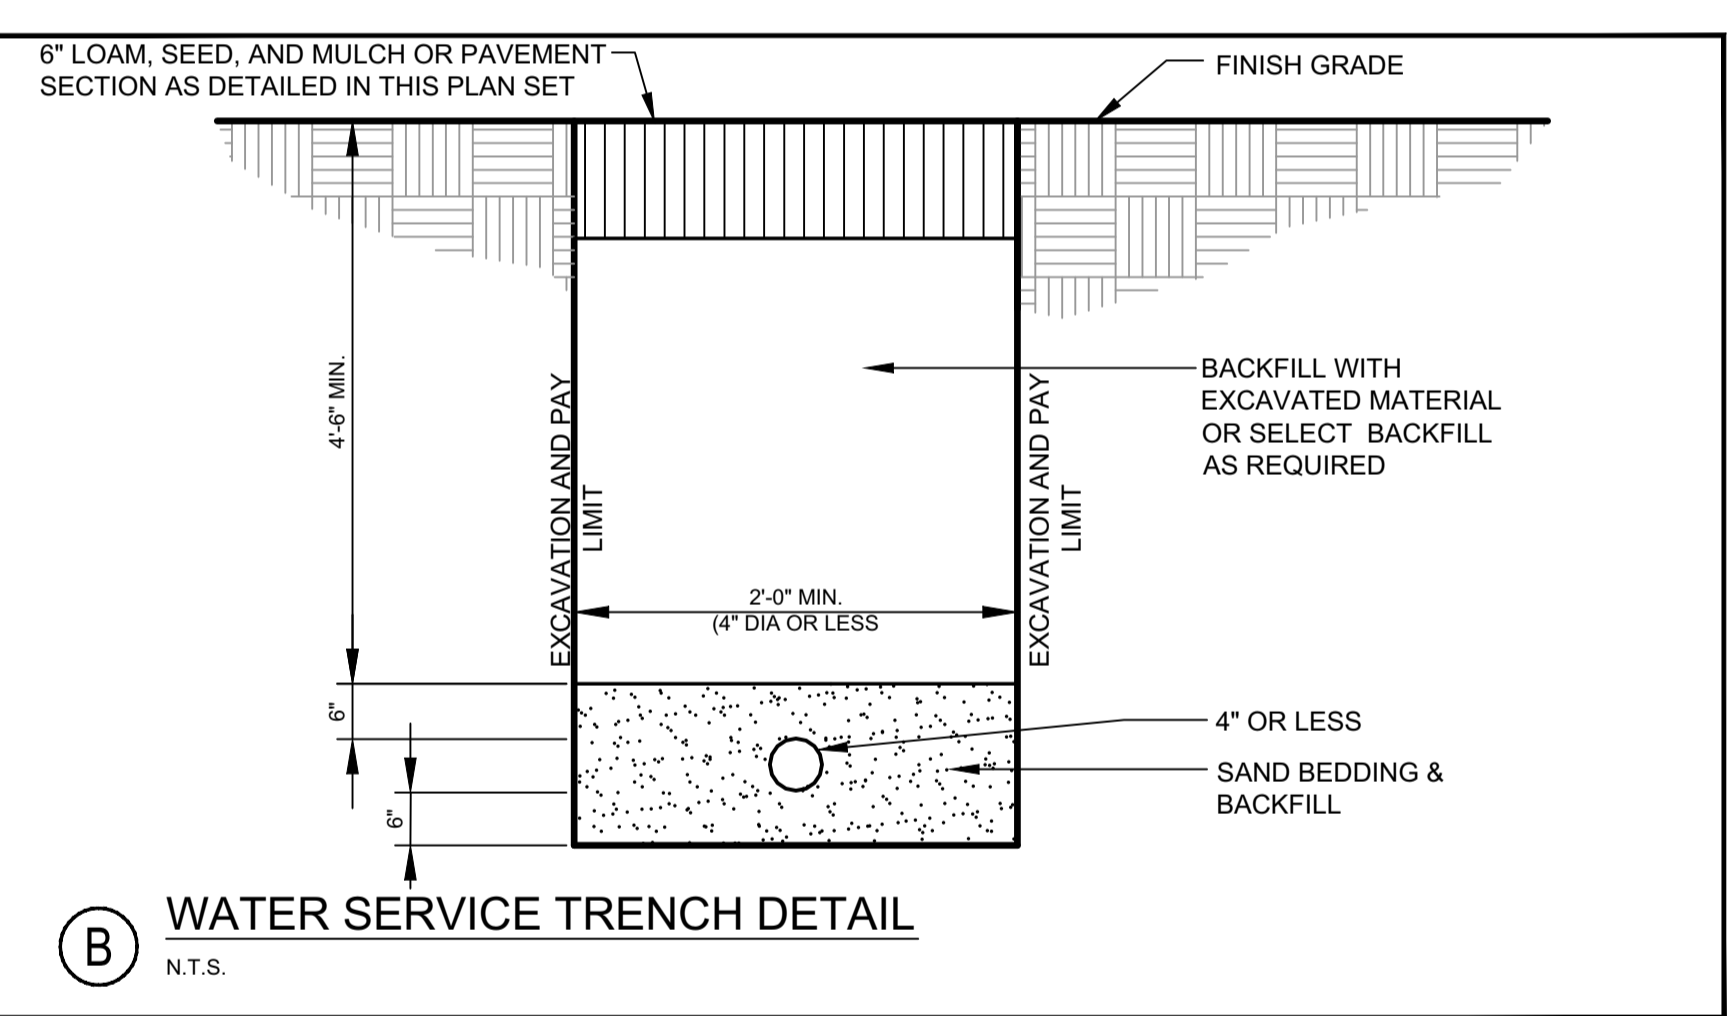


B WATER SERVICE TRENCH DETAIL
 N.T.S.

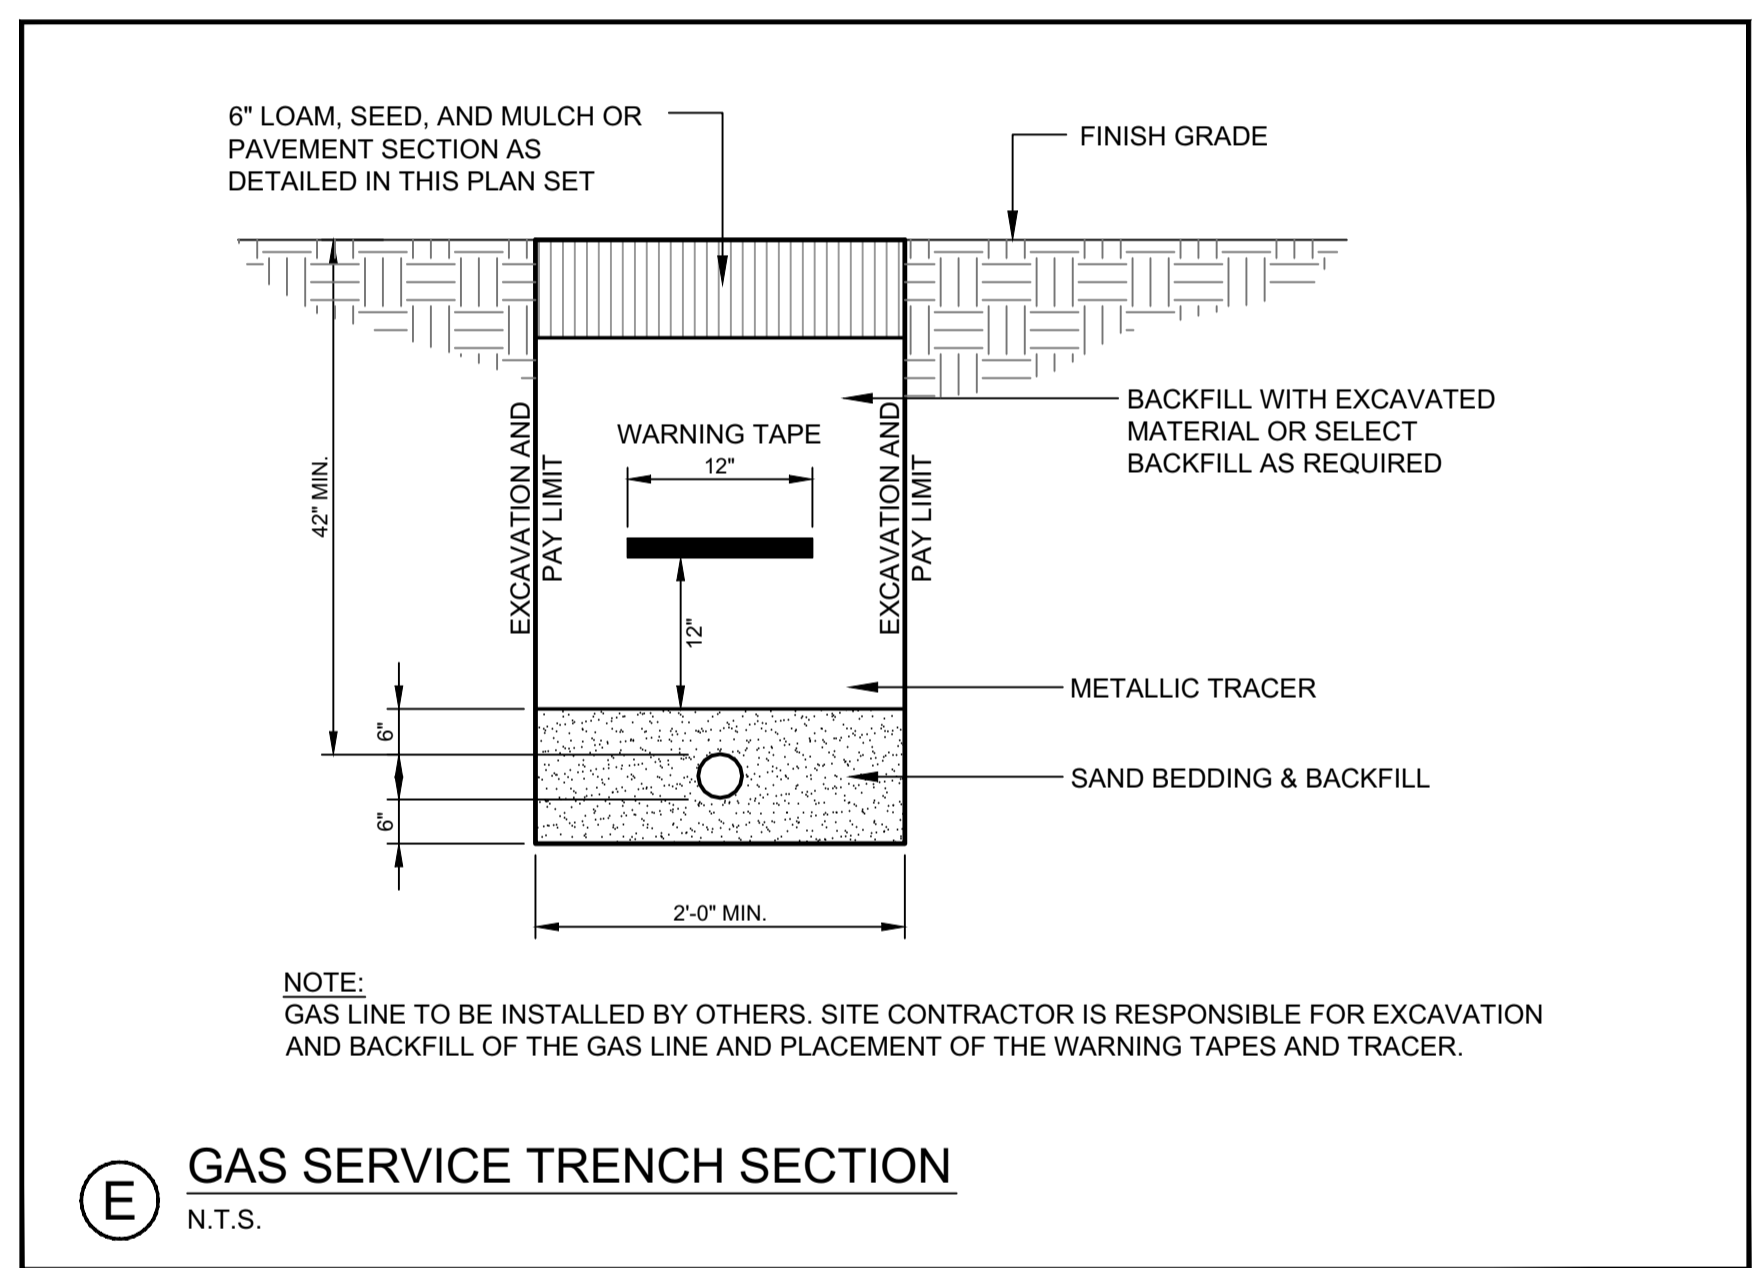


E GAS SERVICE TRENCH SECTION
 N.T.S.

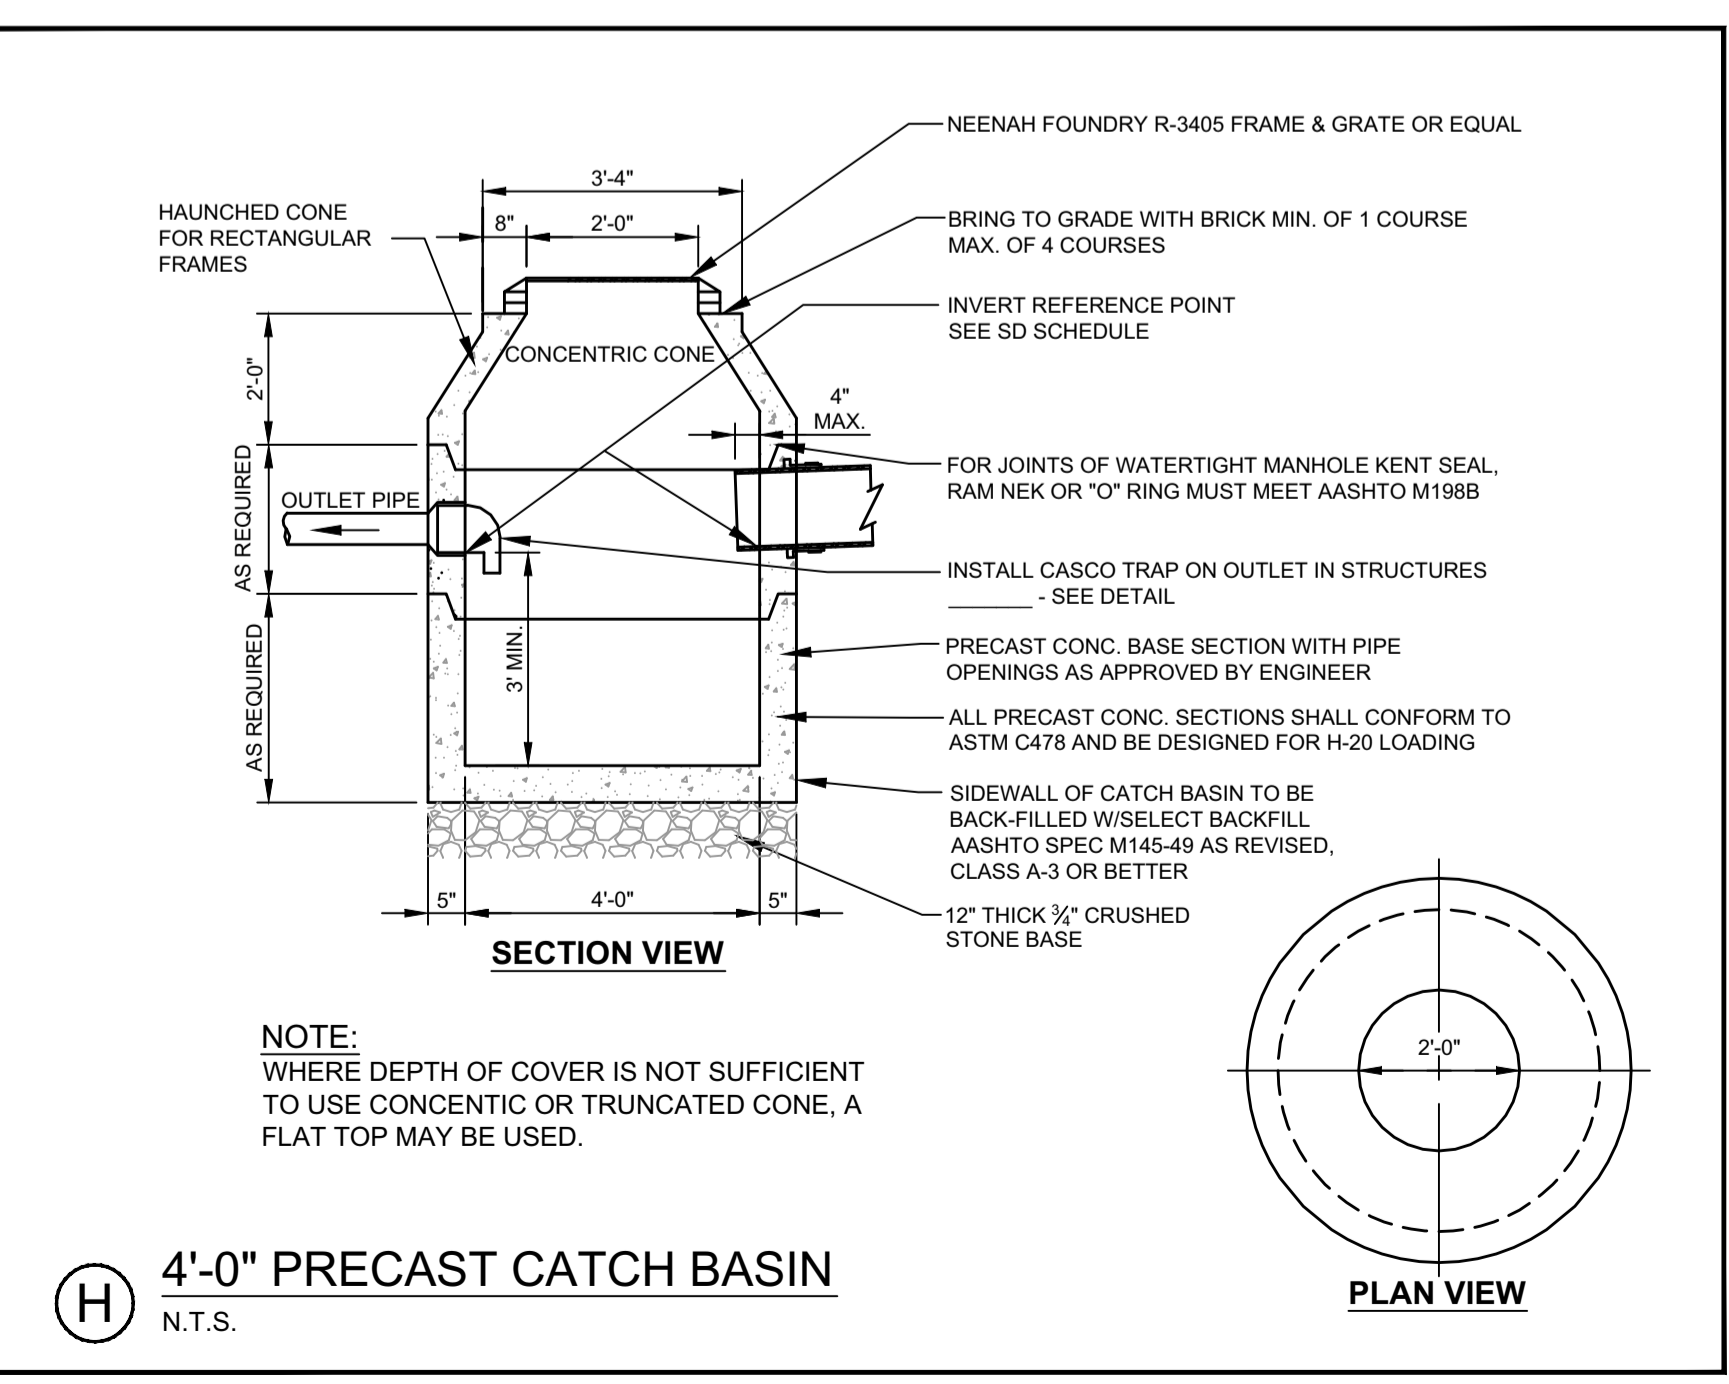

H 4'-0" PRECAST CATCH BASIN
 N.T.S.

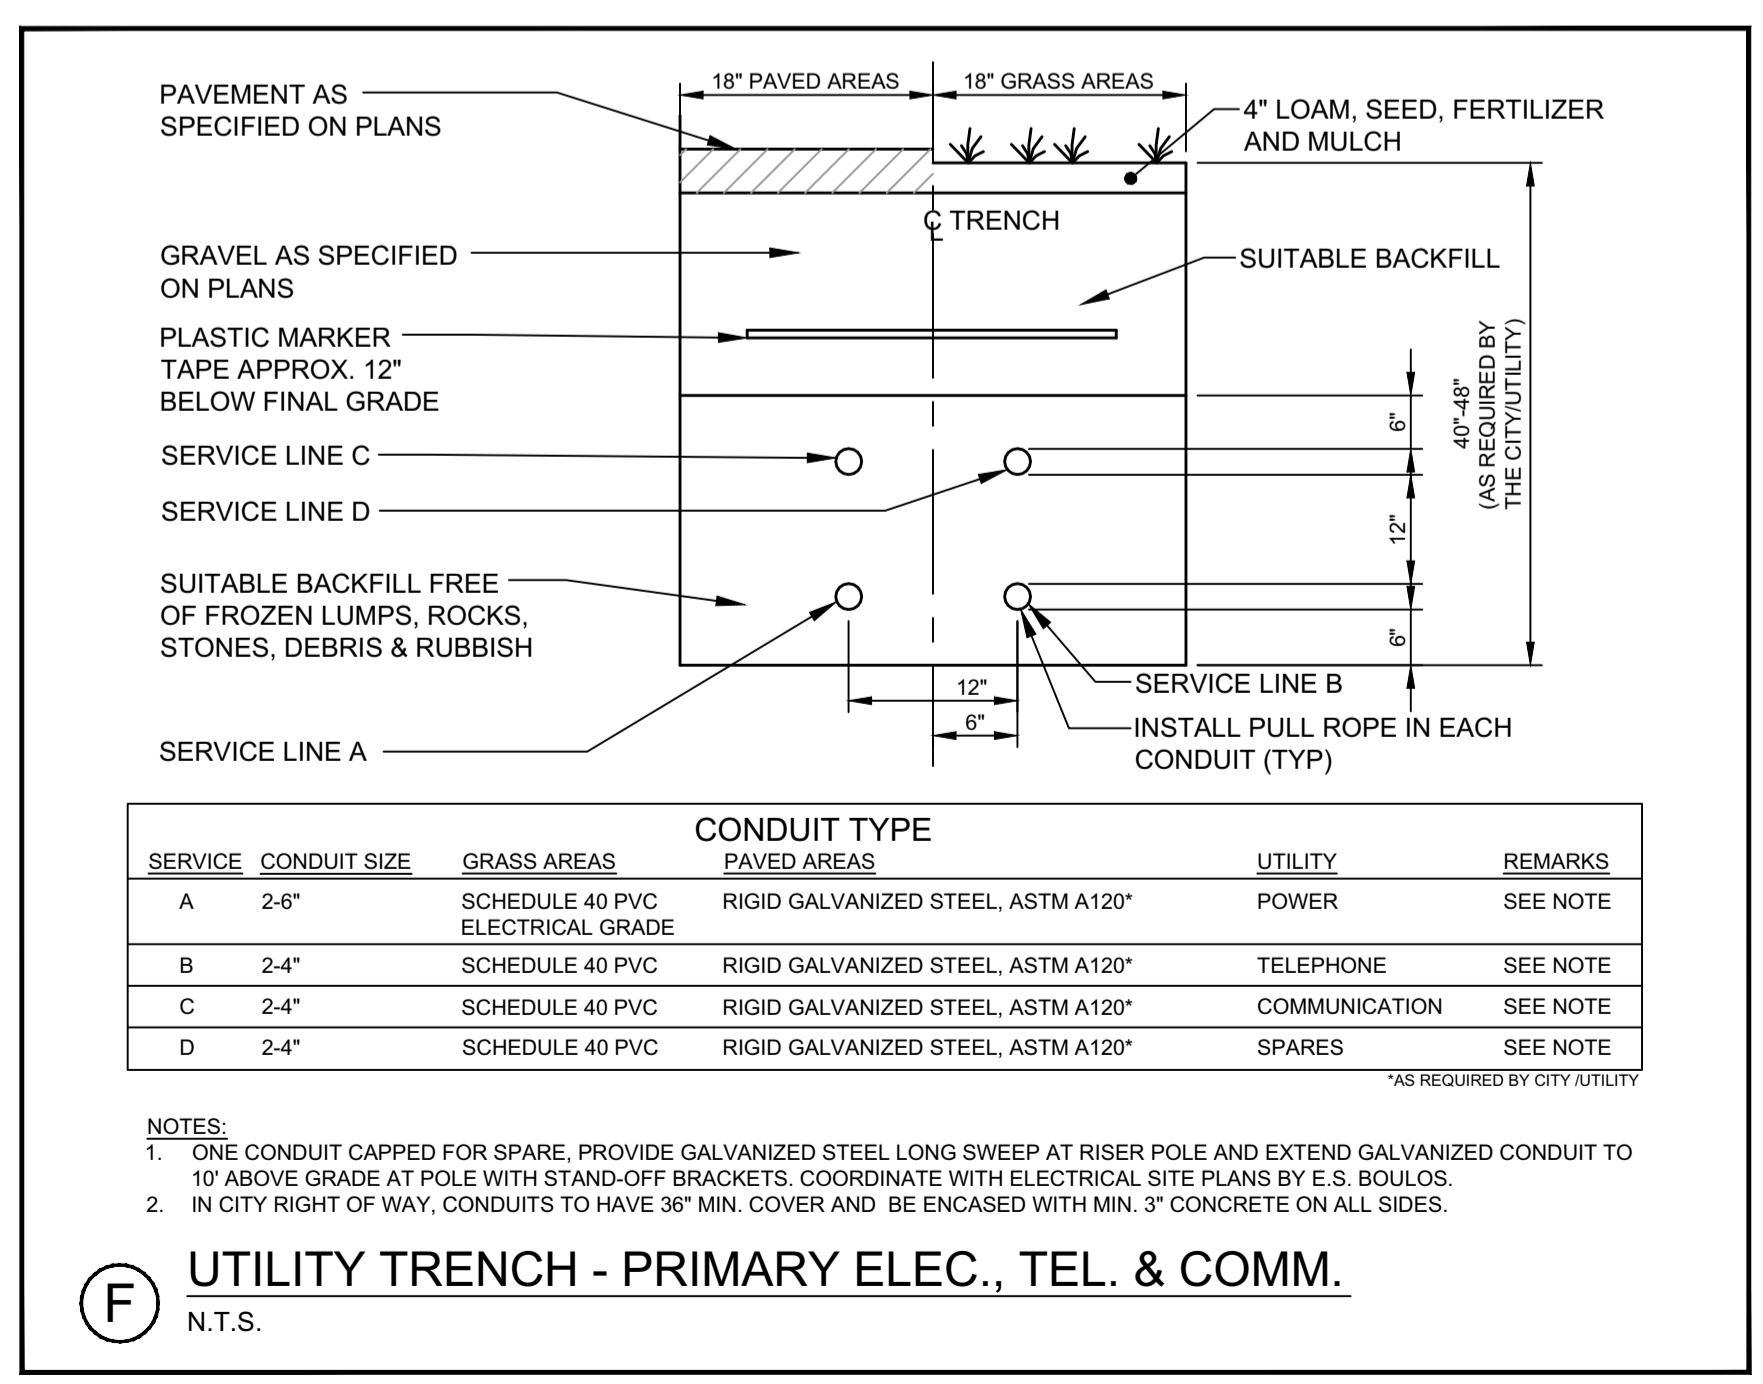


F UTILITY TRENCH - PRIMARY ELEC., TEL. & COMM.
 N.T.S.

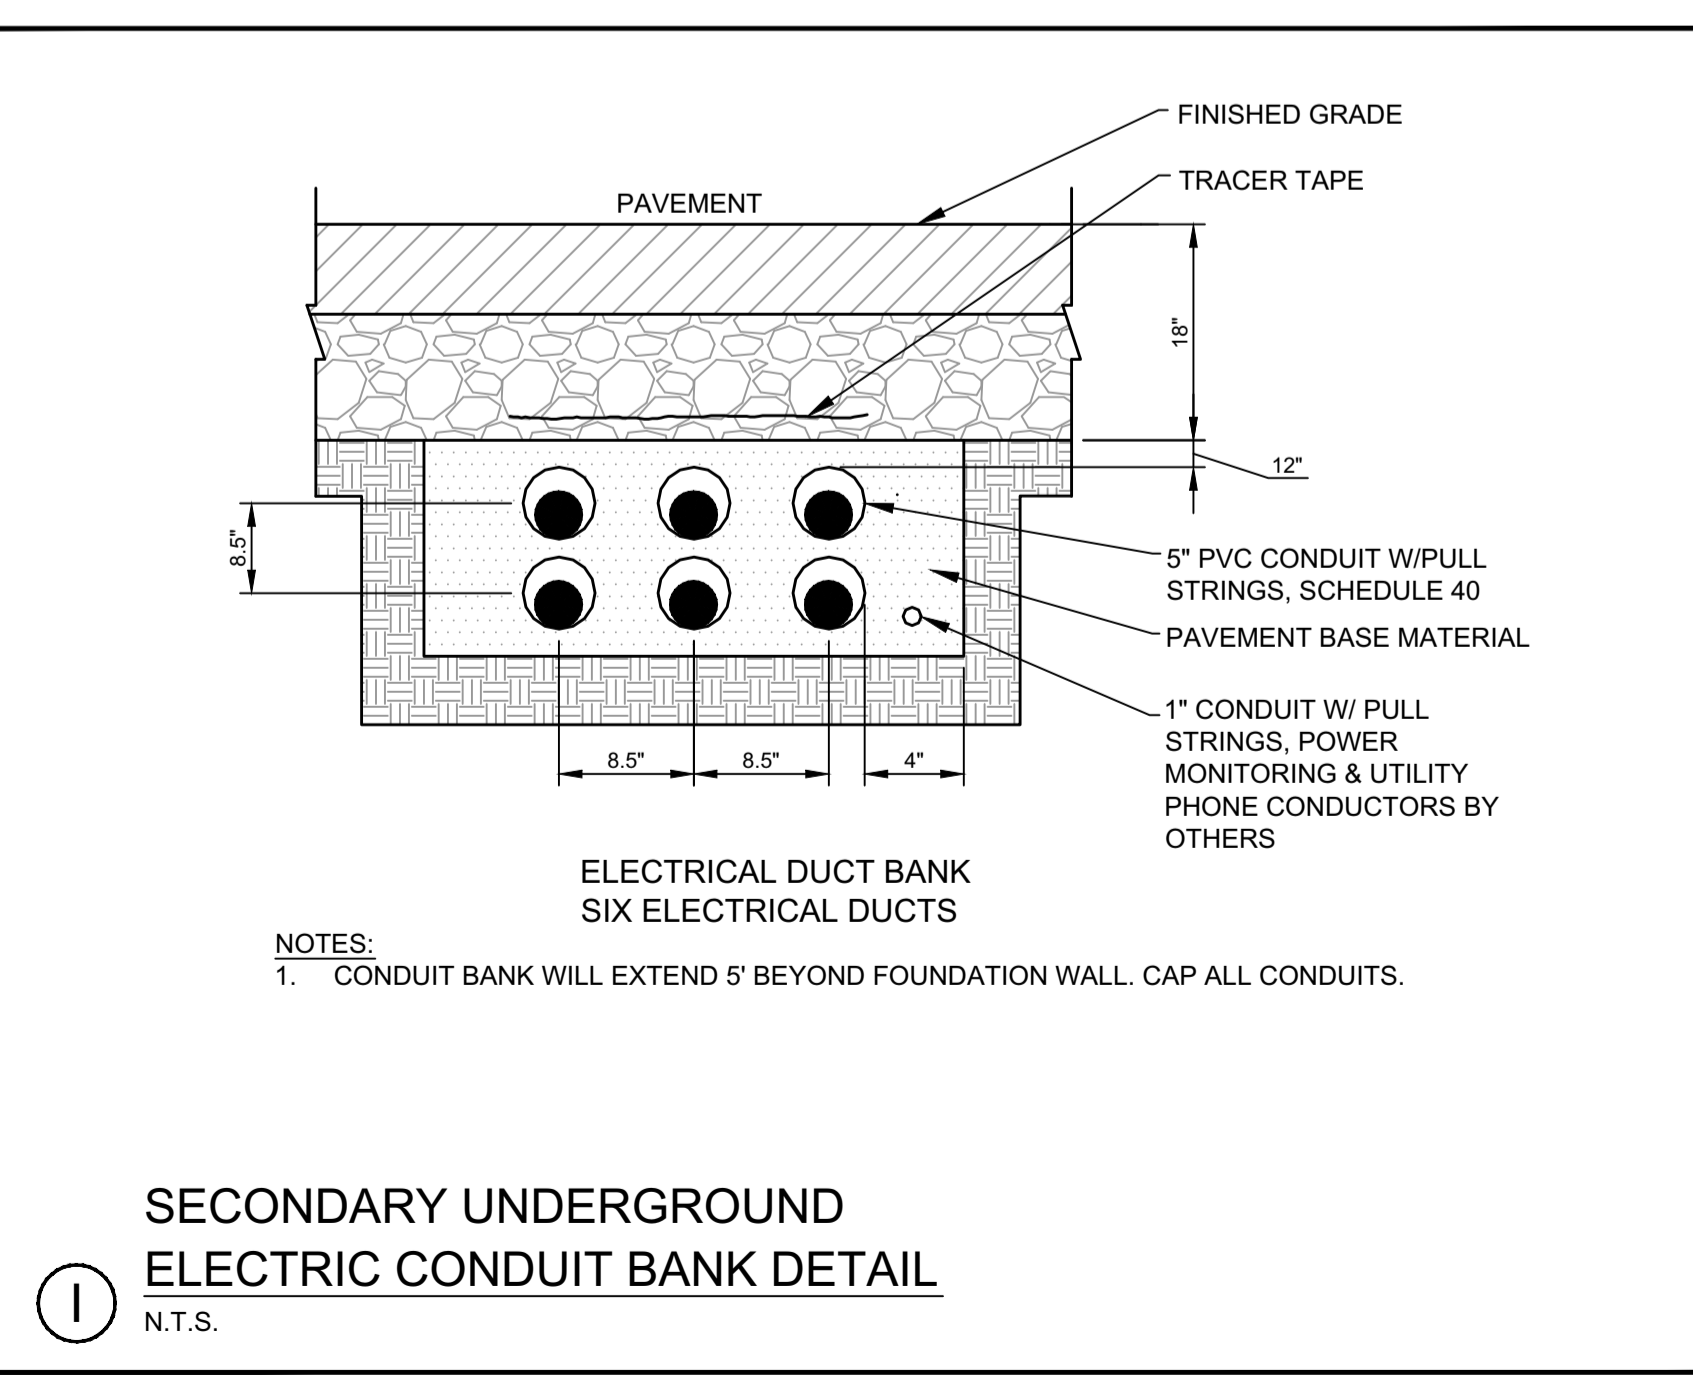

I SECONDARY UNDERGROUND ELECTRIC CONDUIT BANK DETAIL
 N.T.S.

File Name: 195350450_dwt
 P.E. STEPHEN R. BUSHEY
 Permit-Seal

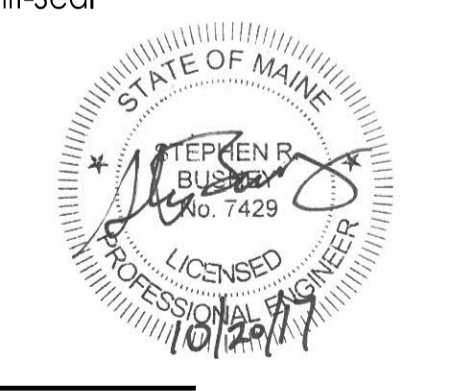

Client/Project
 0 HANCOCK STREET LLC

THAMES STREET SITE
 PORTLAND, MAINE

Title
 STORMDRAIN AND UTILITY DETAILS

Project No. 195350450
 Scale N.T.S.
 Sheet

V:\195350450\dwg\195350450.dwg:plm112.dwg: 10/20/2017 3:07 PM