

REVISION	DESCRIPTION	DATE
0	ISSUED FOR REVIEW & APPROVAL	8/19/2016


RESERVED FOR CITY STAMP

CUNNINGHAM
 Security Systems
 10 Princes Point Road, Yarmouth, Maine 04096
 Office: 207.846.3350 • Fax: 207.846.6080

**GRAND TRUCK BUILDING
 1 INDIA STREET
 PORTLAND, MAINE 04101
 SECOND FLOOR FIRE ALARM PLAN**

DRAWN	JPB UNICAD JOB #16672
CHECKED	WAYNE B. HAWES NCET # 90496
DATE	8/19/2016
REVISION	0
SCALE	1/4" = 1'-0"

FA-3

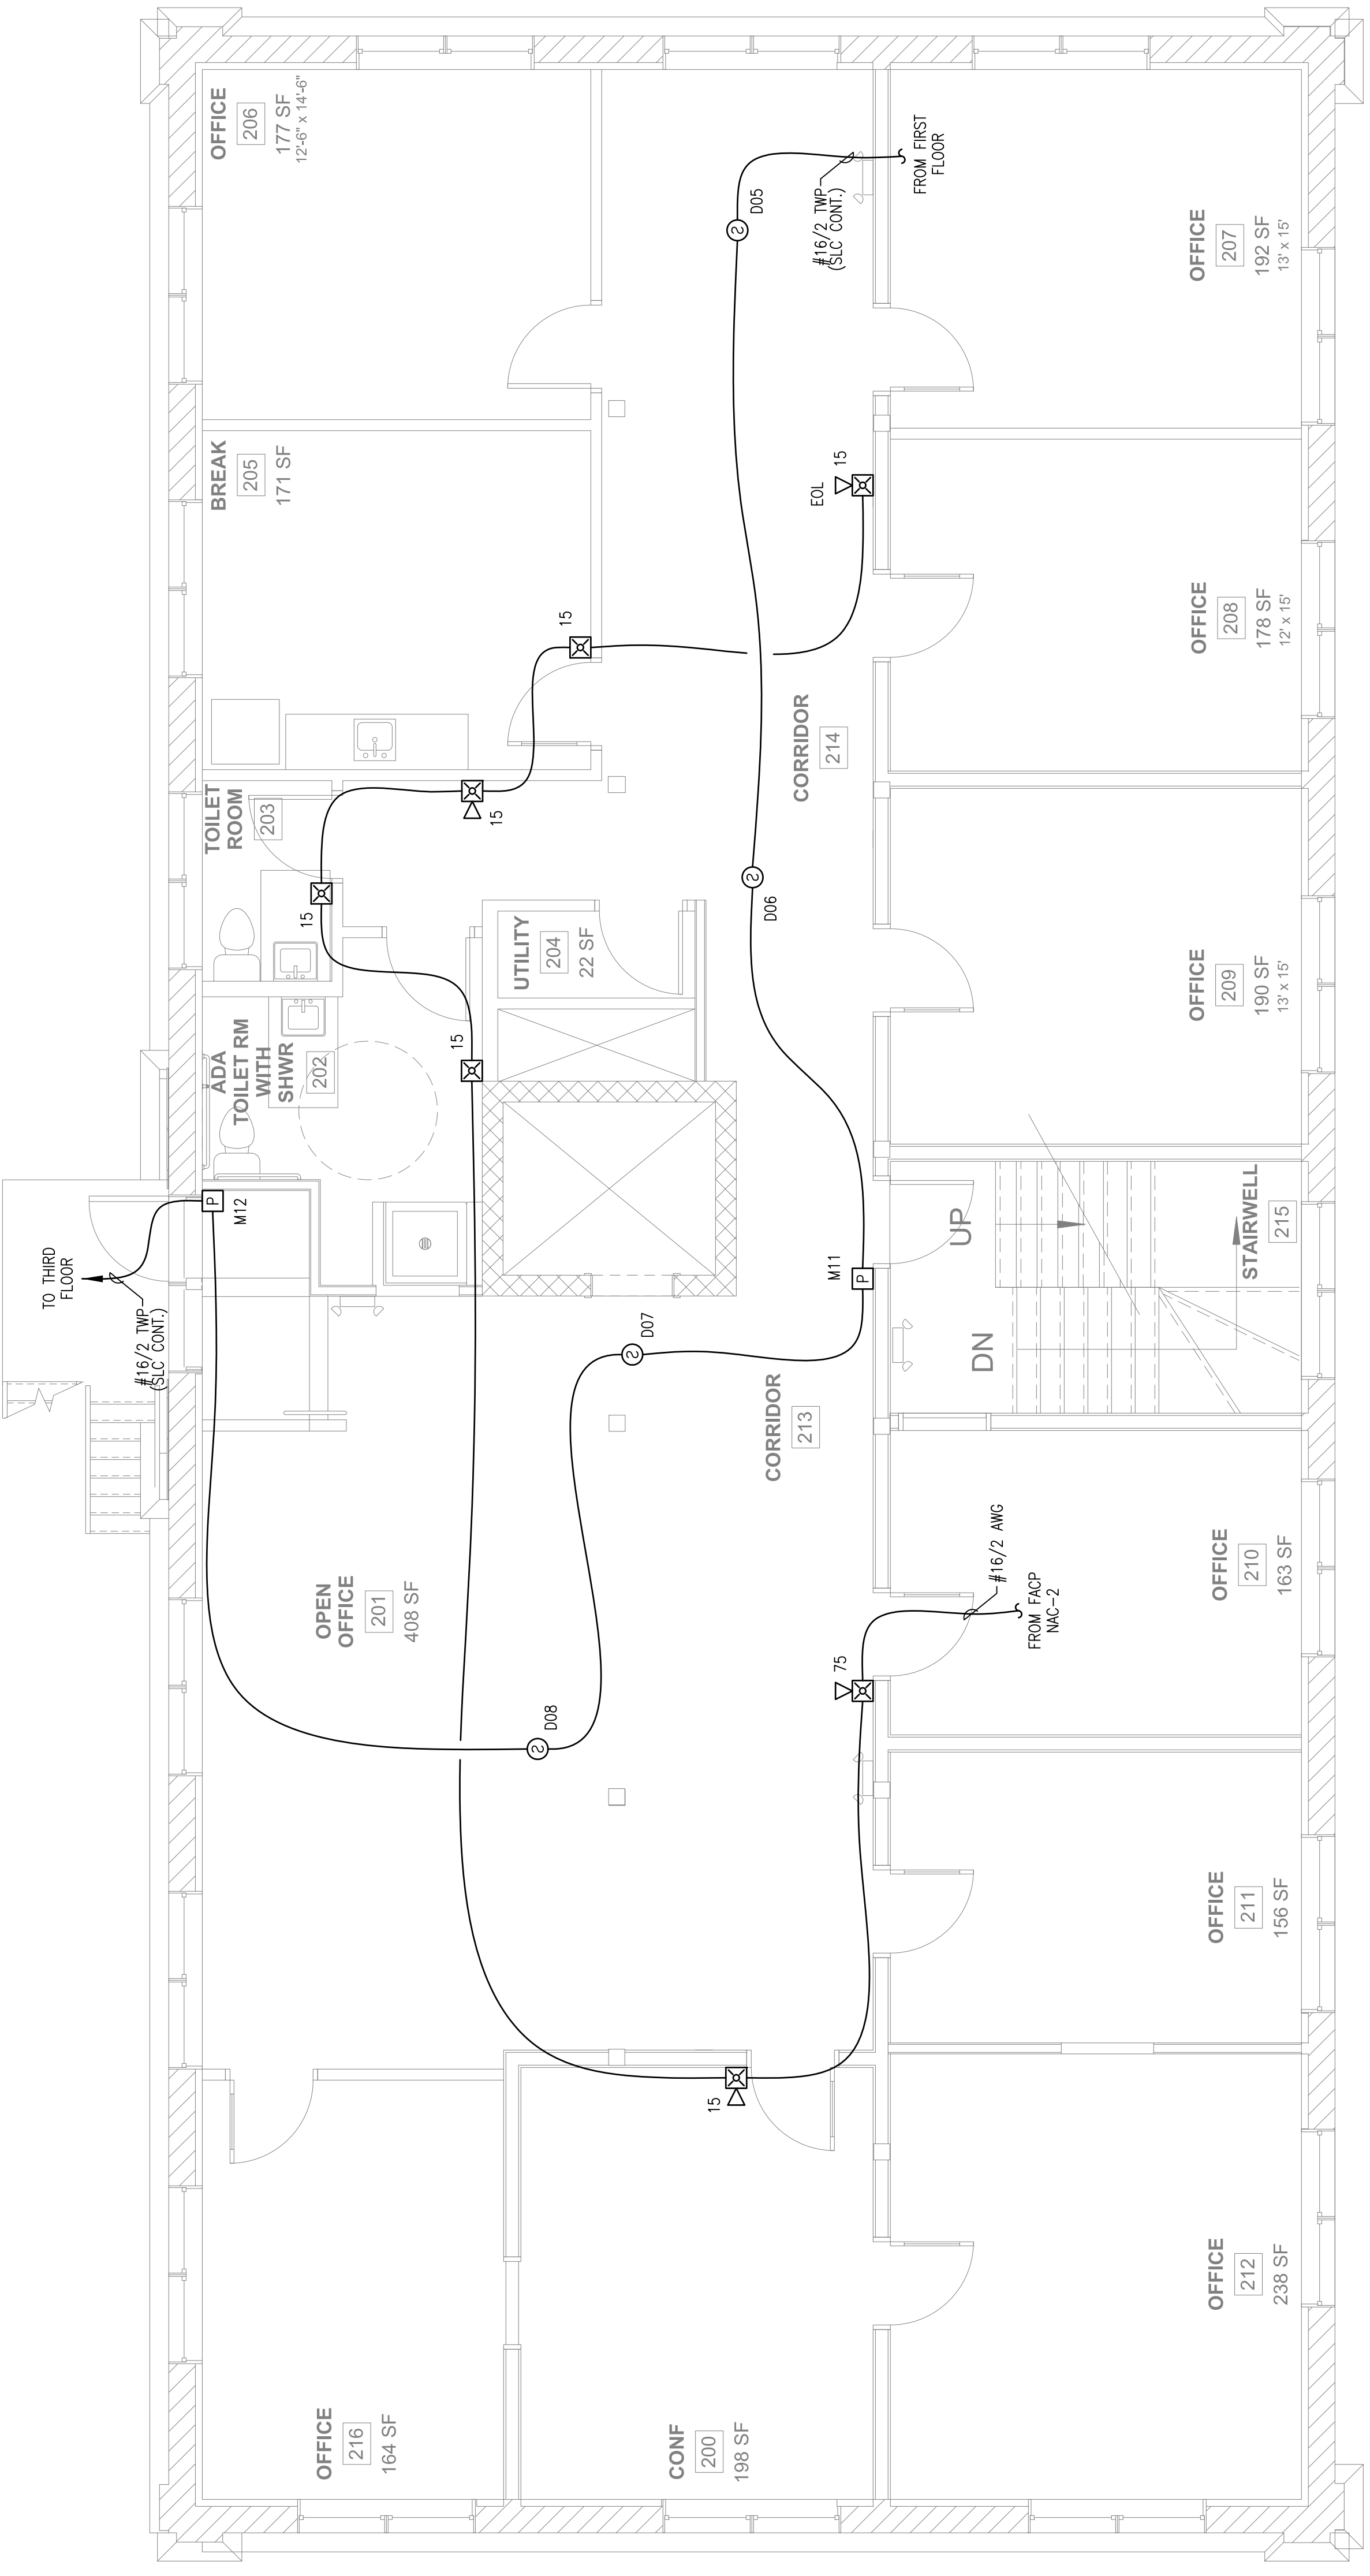

SECOND FLOOR FIRE ALARM PLAN
 SCALE: 1/4" = 1'-0"