

REVISION	DESCRIPTION	DATE
0	ISSUED FOR REVIEW & APPROVAL	8/19/2016

RESERVED FOR CITY STAMP


CUNNINGHAM
Security Systems
10 Princes Point Road, Yarmouth, Maine 04096
Office: 207.846.3350 • Fax: 207.846.6080

GRAND TRUCK BUILDING
1 INDIA STREET
PORTLAND, MAINE 04101
THIRD FLOOR FIRE ALARM PLAN

DRAWN	JPB UNICAD JOB #16672
CHECKED	WAYNE B. HAWES NICET # 90496
DATE	8/19/2016
REVISION	0
SCALE	1/4" = 1'-0"

FA-4

UNICAD Inc.
Fire Alarm Design & Drafting Services
www.unicad.net
579A W. 40th St.
Portland, ME 04102
Office: 603.865.6410

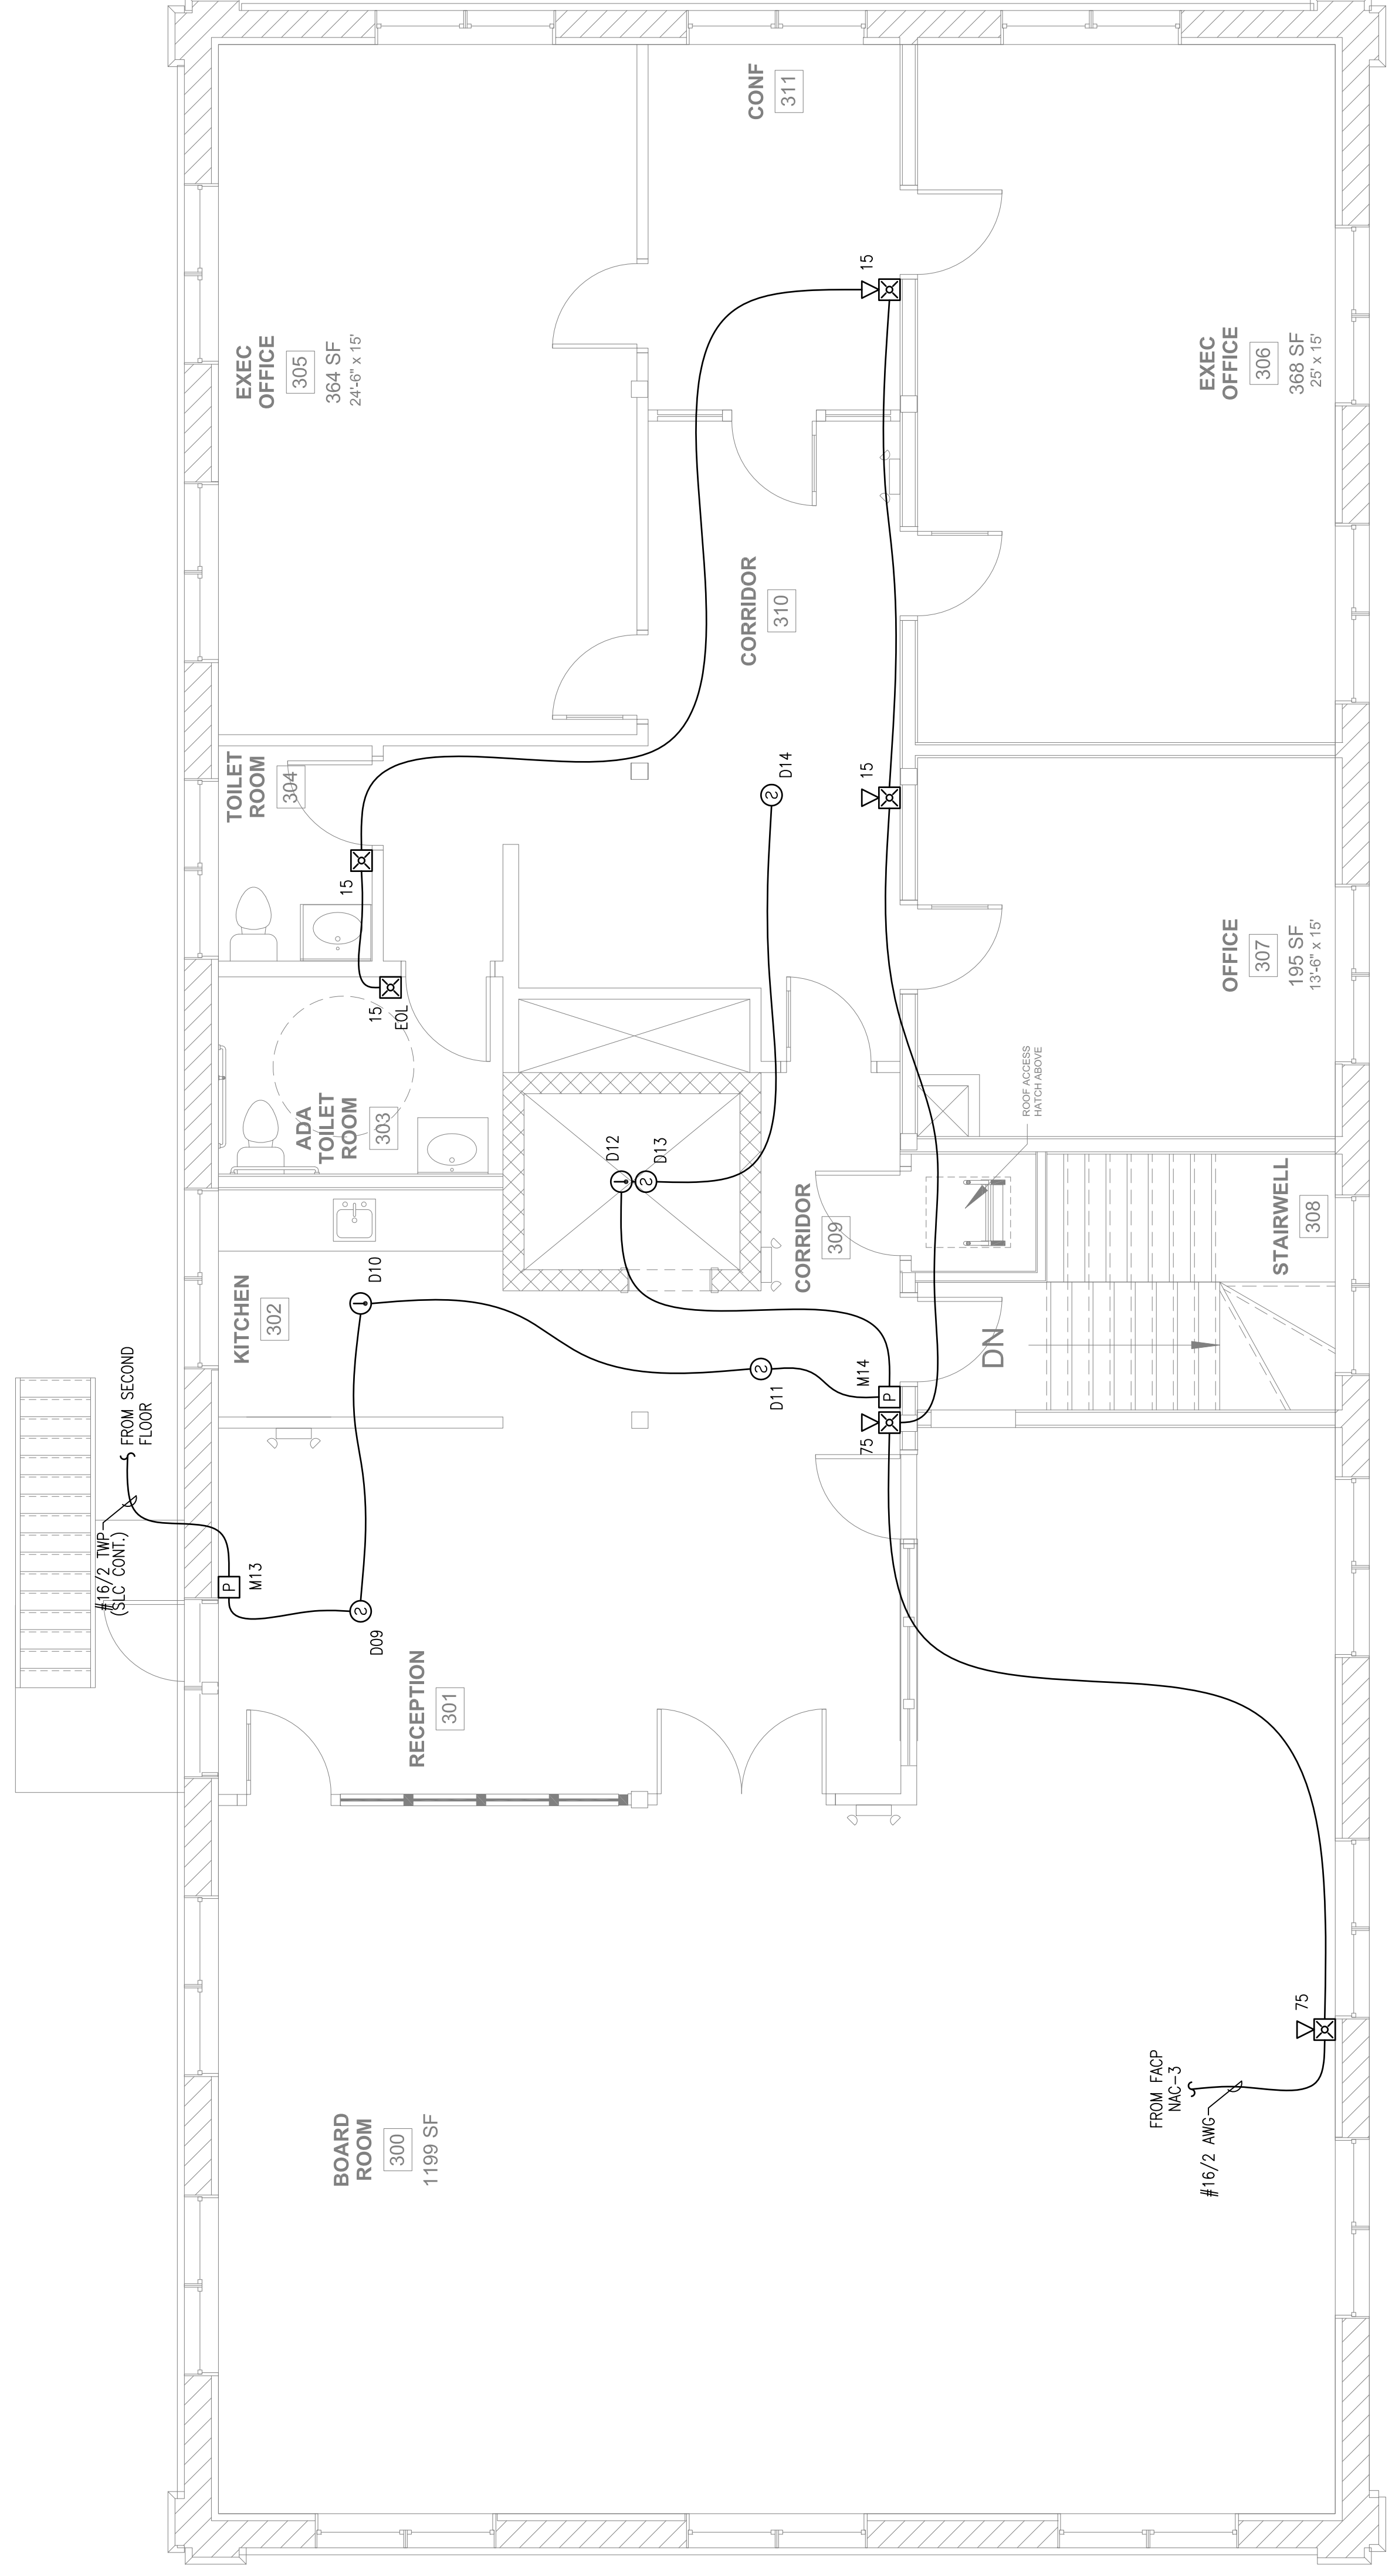

THIRD FLOOR FIRE ALARM PLAN
SCALE: 1/4"=1'-0"

SHEET NOTES:
◇ LOCATE DETECTOR AT TOP OF ELEVATOR HOISTWAY.