


FORE STREET

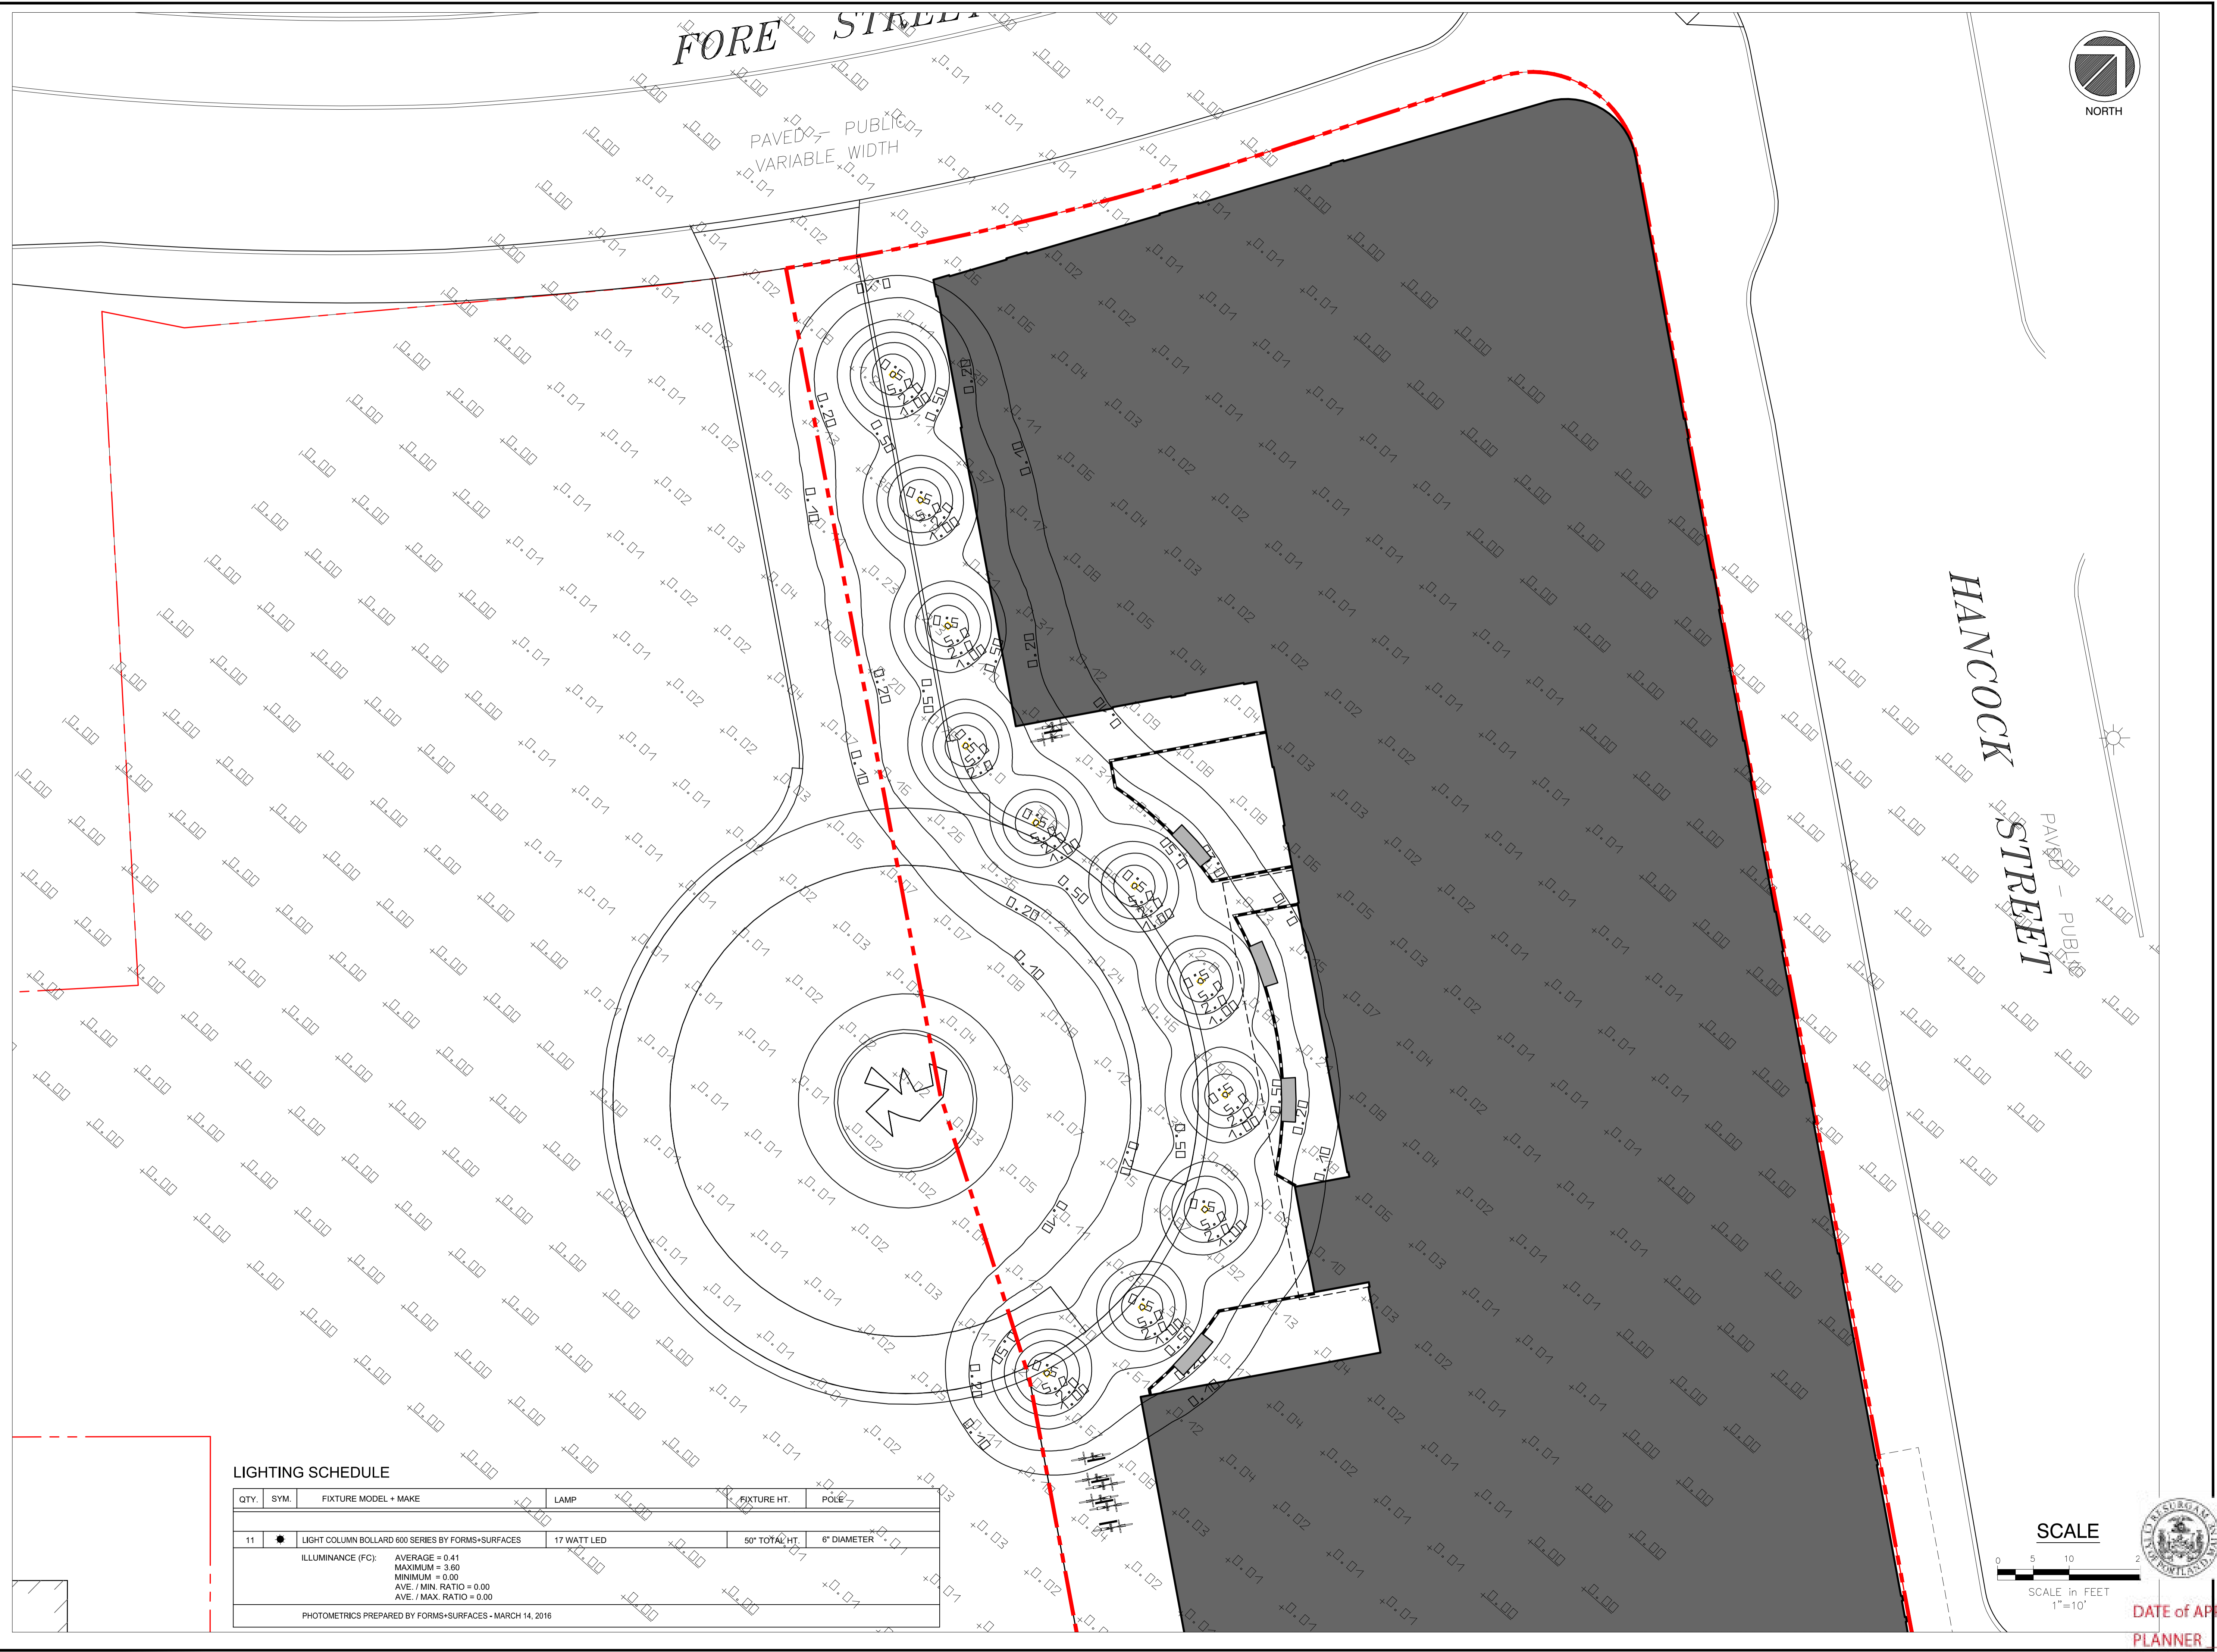

PAVED - PUBLIC VARIABLE WIDTH

HANCOCK STREET
PAVED - PUBLIC



LIGHTING SCHEDULE

QTY.	SYM.	FIXTURE MODEL + MAKE	LAMP	FIXTURE HT.	POLE
11	●	LIGHT COLUMN BOLLARD 600 SERIES BY FORMS+SURFACES	17 WATT LED	50" TOTAL HT.	6" DIAMETER
ILLUMINANCE (FC): AVERAGE = 0.41 MAXIMUM = 3.60 MINIMUM = 0.00 AVE. / MIN. RATIO = 0.00 AVE. / MAX. RATIO = 0.00					
PHOTOMETRICS PREPARED BY FORMS+SURFACES - MARCH 14, 2016					

Site: **PROPOSED AC HOTEL PORTLAND**
THAMES STREET
PORTLAND, MAINE


Prepared for:
PORTLAND NORWICH GROUP, LLC
2330 PALM RIDGE ROAD
#305
SANIBEL, FL 33957



**PHOTOMETRIC PLAN
(COURTYARD / DRIVE)**

No.	Revision/Issue	Date
D	APPROVED CITY PLANS	02/15/17
C	STAFF REVIEW COMMENTS	05/10/16
B	FINAL SITE PLAN REVIEW	03/15/16
A	PRELIMINARY REVIEW	09/29/15

Design by:	Checked by:
MAP/PC	PC
Drawn by:	Approved by:
	CITY OF PORTLAND
	APPROVED SITE PLAN
Subject to Conditions of Approval and Standard Conditions	
150.0609	FEBRUARY 2016

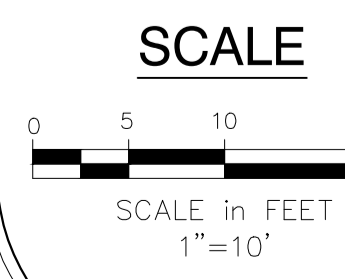

DATE of APPROVAL **1/3/16**
PLANNER **Nell Donaldson**
PROJECT NO. **2015-169**