




1 FIRST FLOOR DUCTWORK PLAN
 SCALE: 1/8" = 1'-0"

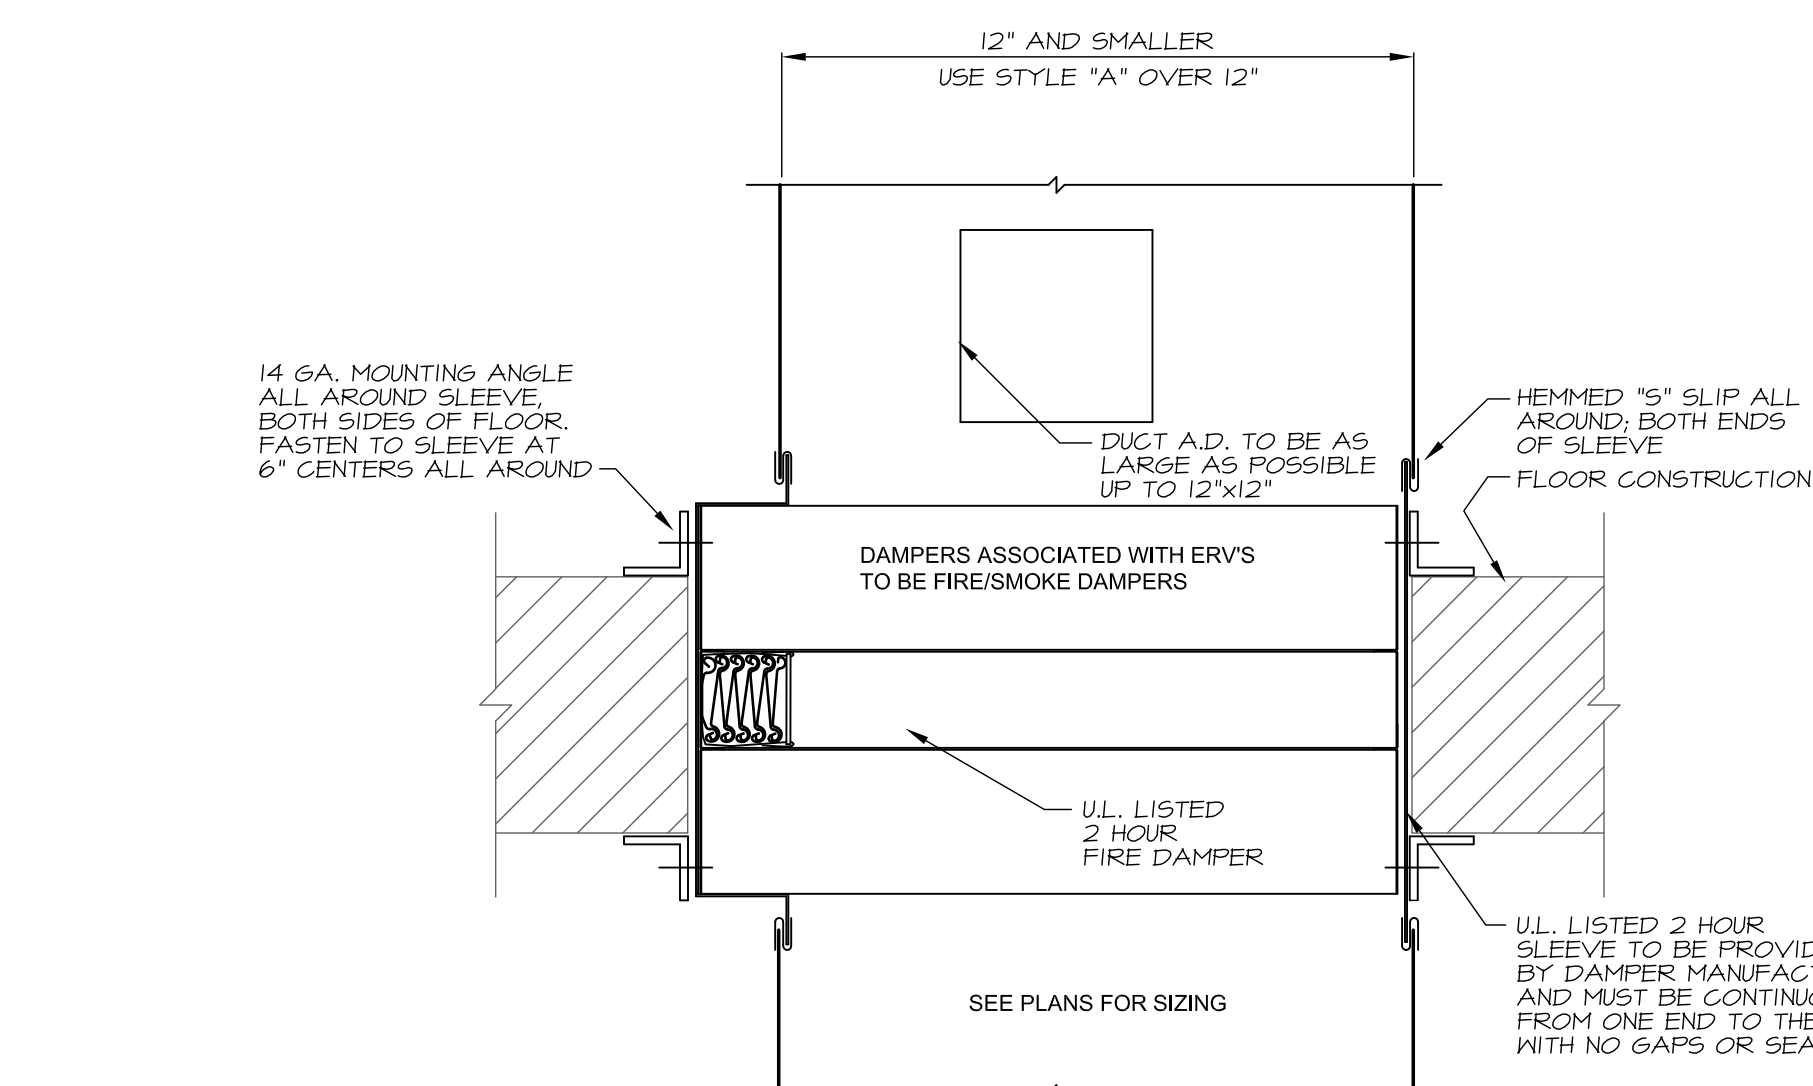


2 FLOOR FIRE DAMPER STYLE "B"
 NO SCALE

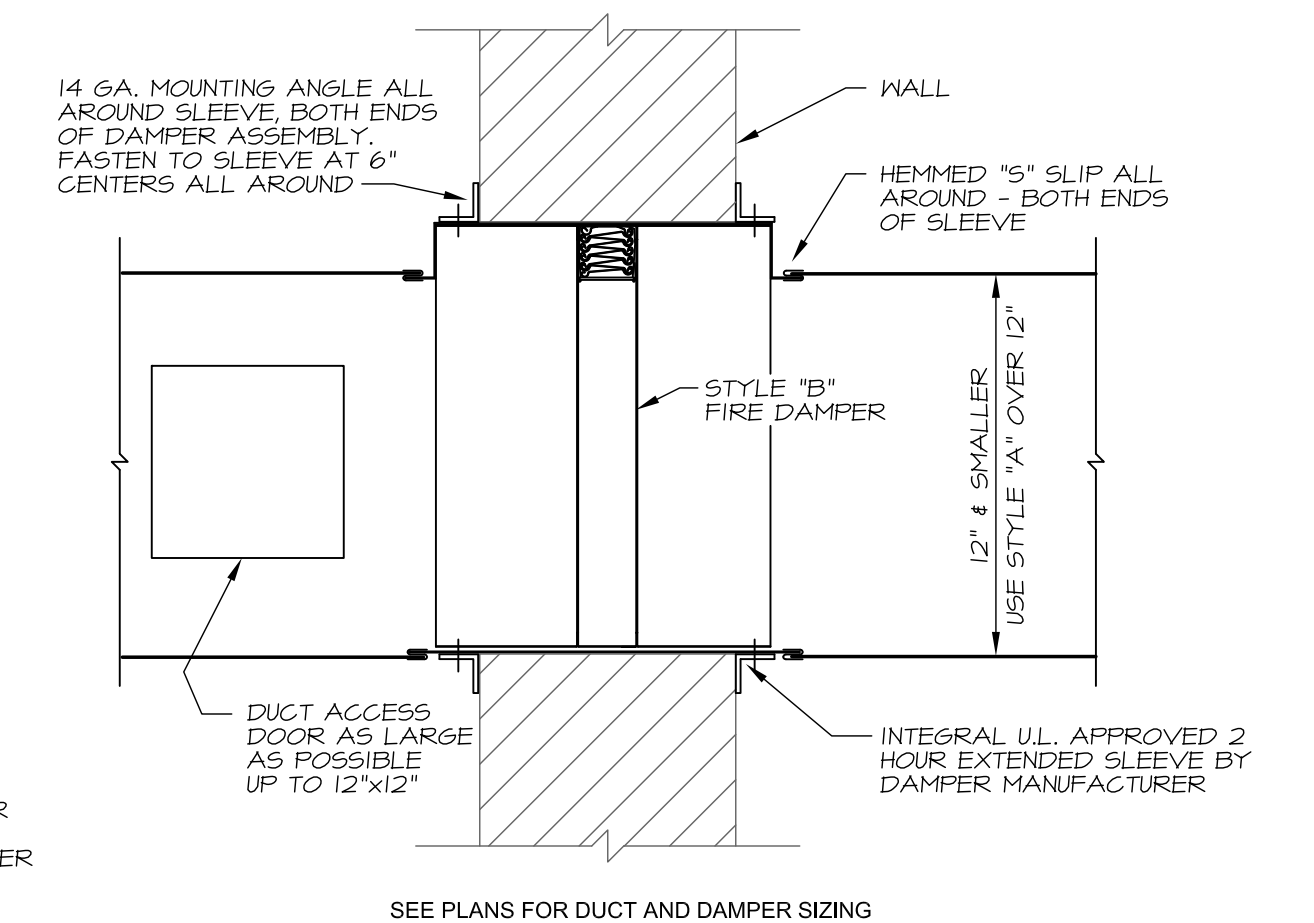

3 WALL FIRE DAMPER STYLE "B"
 NO SCALE

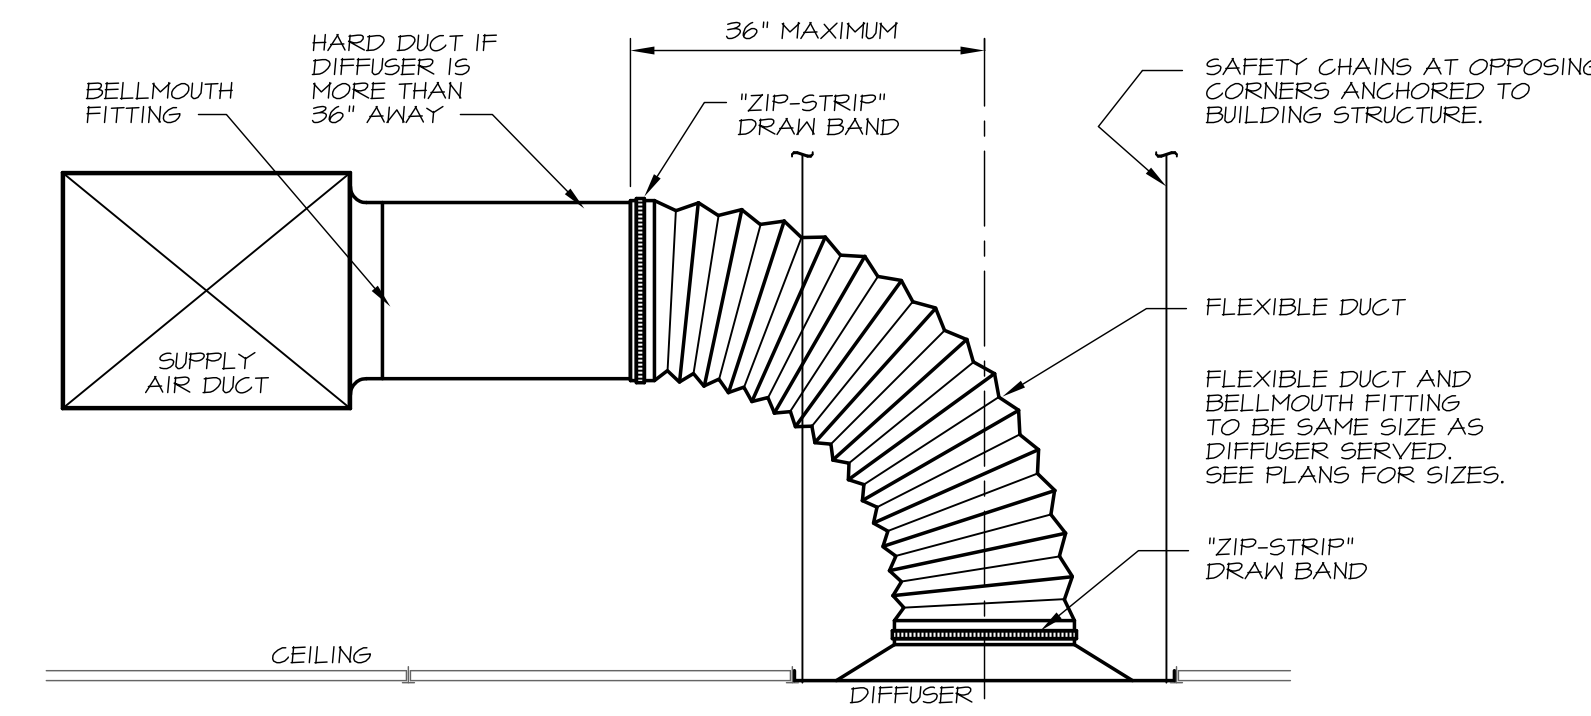


4 FLEXIBLE DUCT & DIFFUSER CONNECTION DETAIL
 NO SCALE

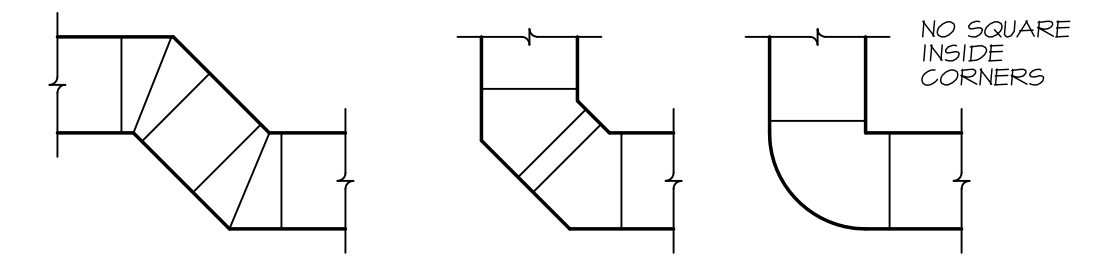

5 UNACCEPTABLE DUCT FITTINGS
 NO SCALE

MECHANICAL SYSTEMS ENGINEERS
 ROYAL RIVER CENTER, UNIT 108
 10 FOREST FALLS DRIVE, YARMOUTH, MAINE 04096
 (207) 846-1441
 FACEBOOK: MECHANICAL SYSTEMS ENGINEERS
 © COPYRIGHT 2016
 M.S.E. Proj. 1632

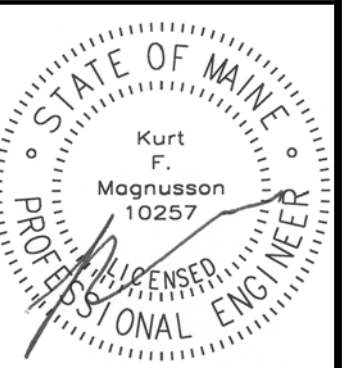

AC HOTELS by MARRIOTT
 Fore Street / Hancock Street / Thames Street
 Portland, Maine

REVISION:

ISSUED:
 RELEASED FOR PRICING 12/21/2016

project architect: KAK
 drawn by: REM

FIRST FLOOR MECHANICAL DUCTWORK

sheet number:
M1