



**LIGHTING FIXTURE SCHEDULE**


MARK	TYPE	BASIS OF DESIGN (FOCAL POINT)
A	RECESSED 2' x 2' FLOURESCENT	"EQUATION"
B	4" RECESSED SLOT	"SEEM 4"
C	LINEAR PENDANT	"METRO"
D	4.5"x4.5" SQUARE LED	DOWNLIGHT
E	8" ROUND PENDANT CFL	"GROOVE C"

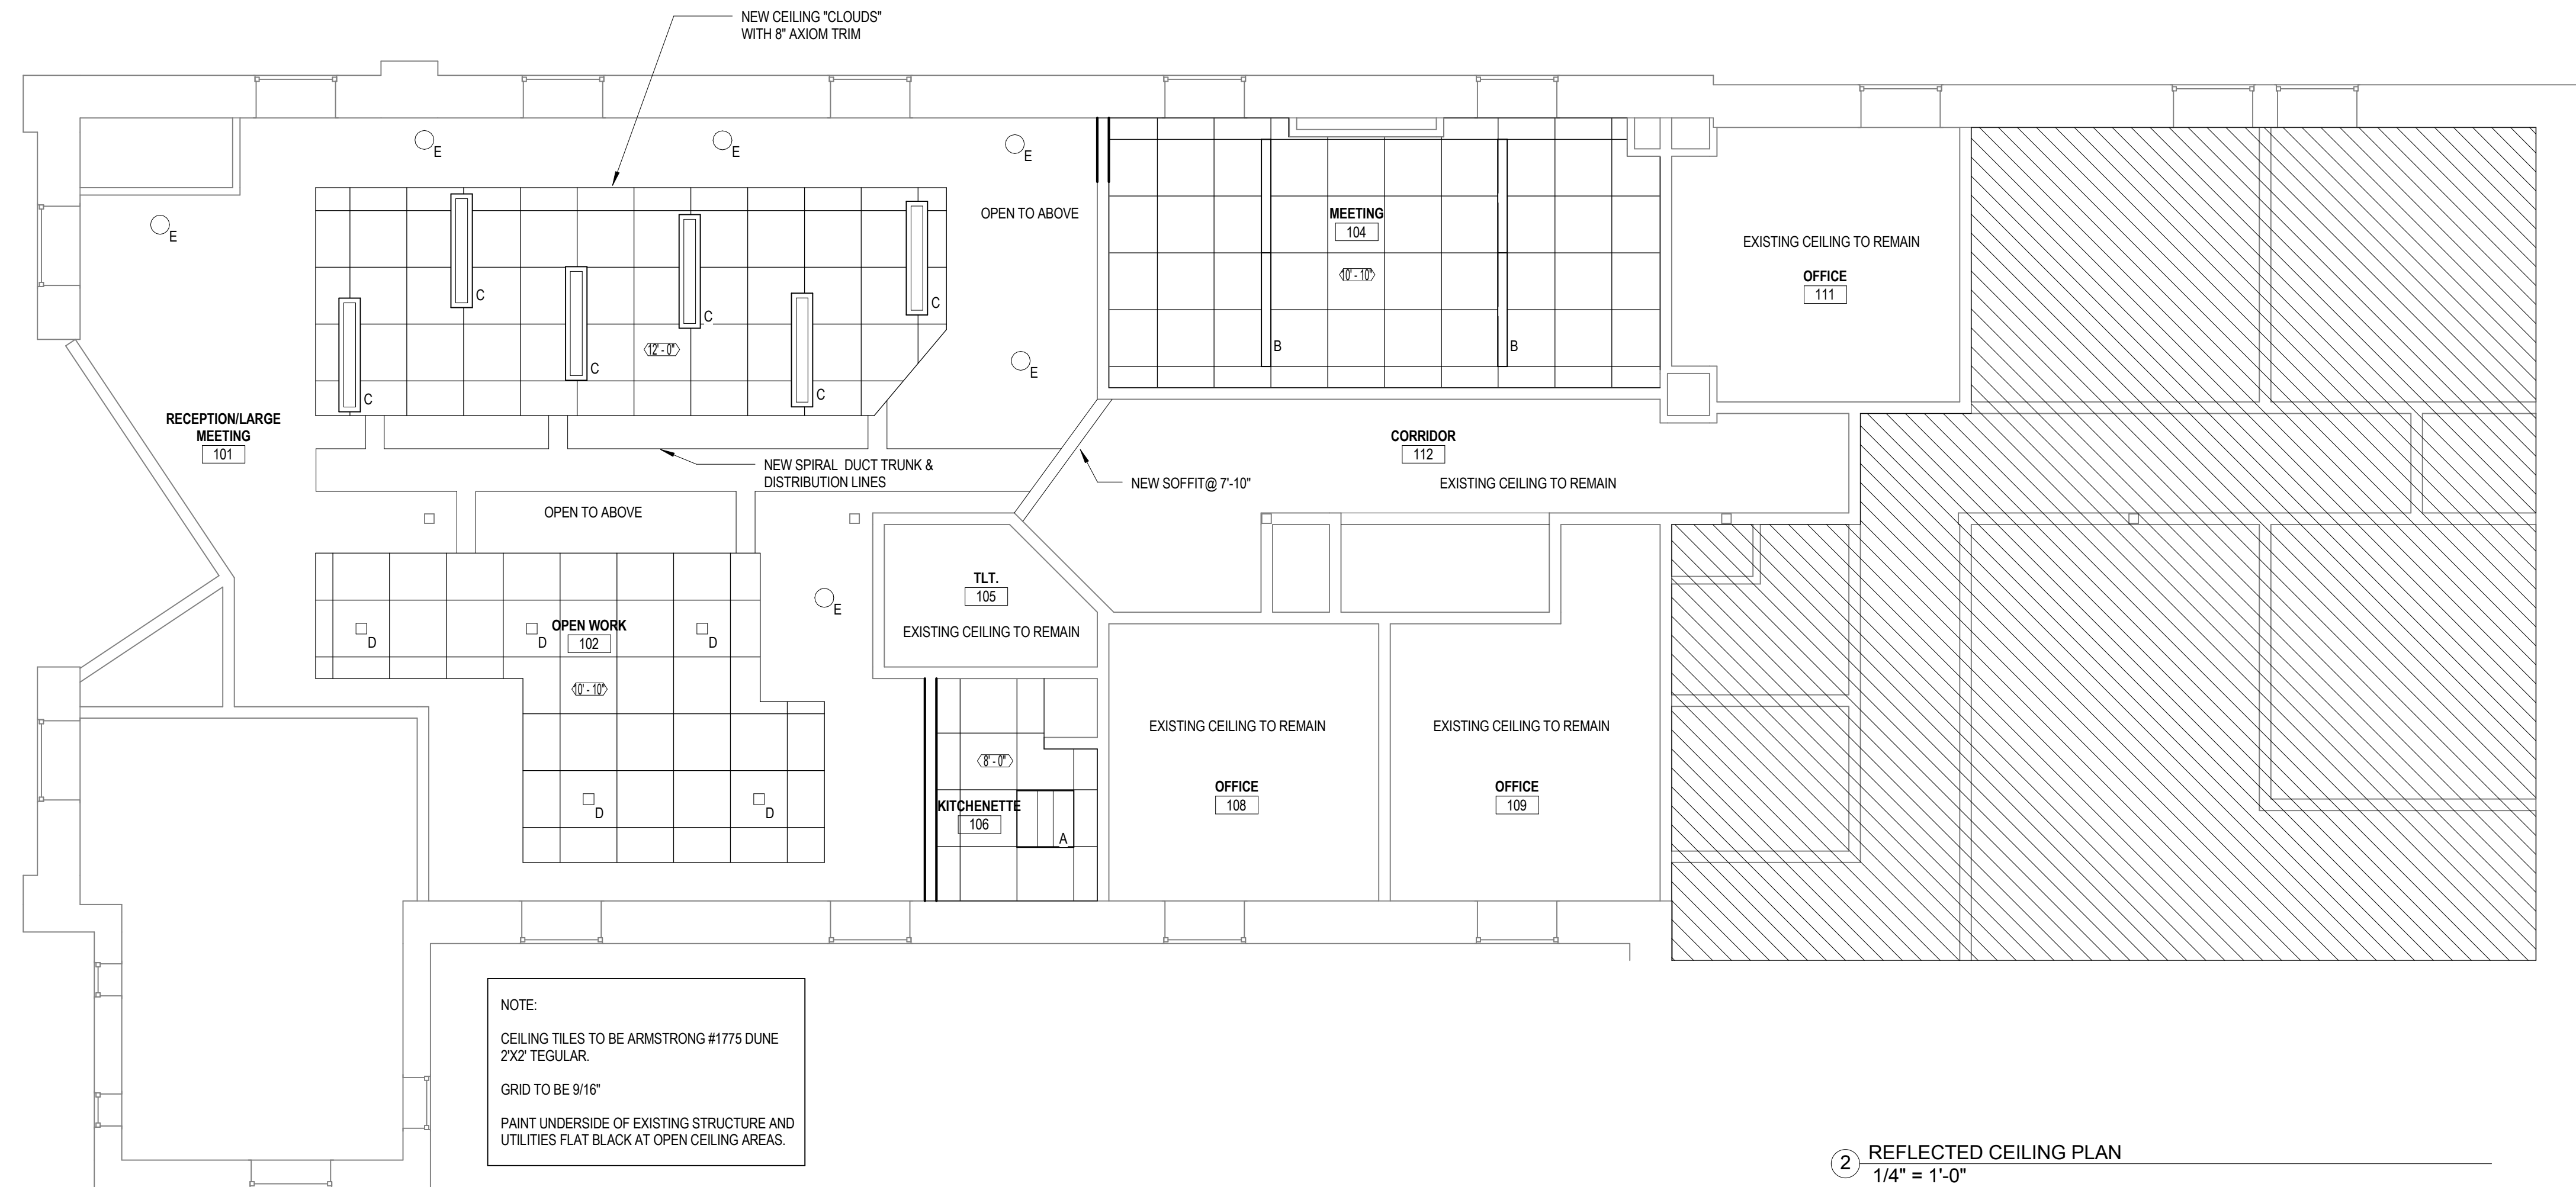

2 REFLECTED CEILING PLAN  
 1/4" = 1'-0"

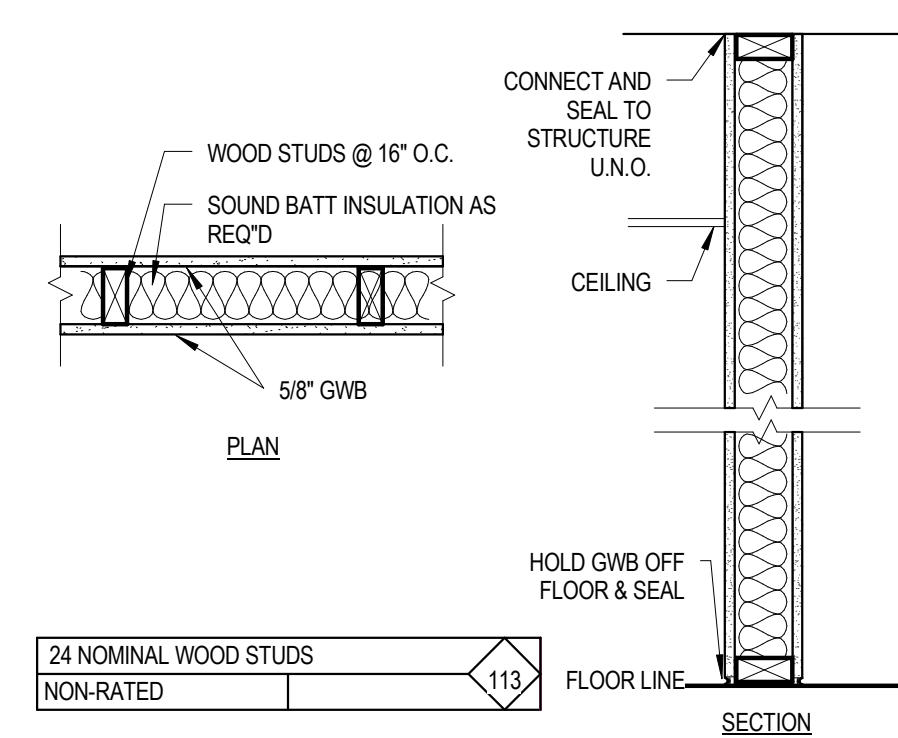

3 WALL TYPES INTERIOR  
 1" = 1'-0"

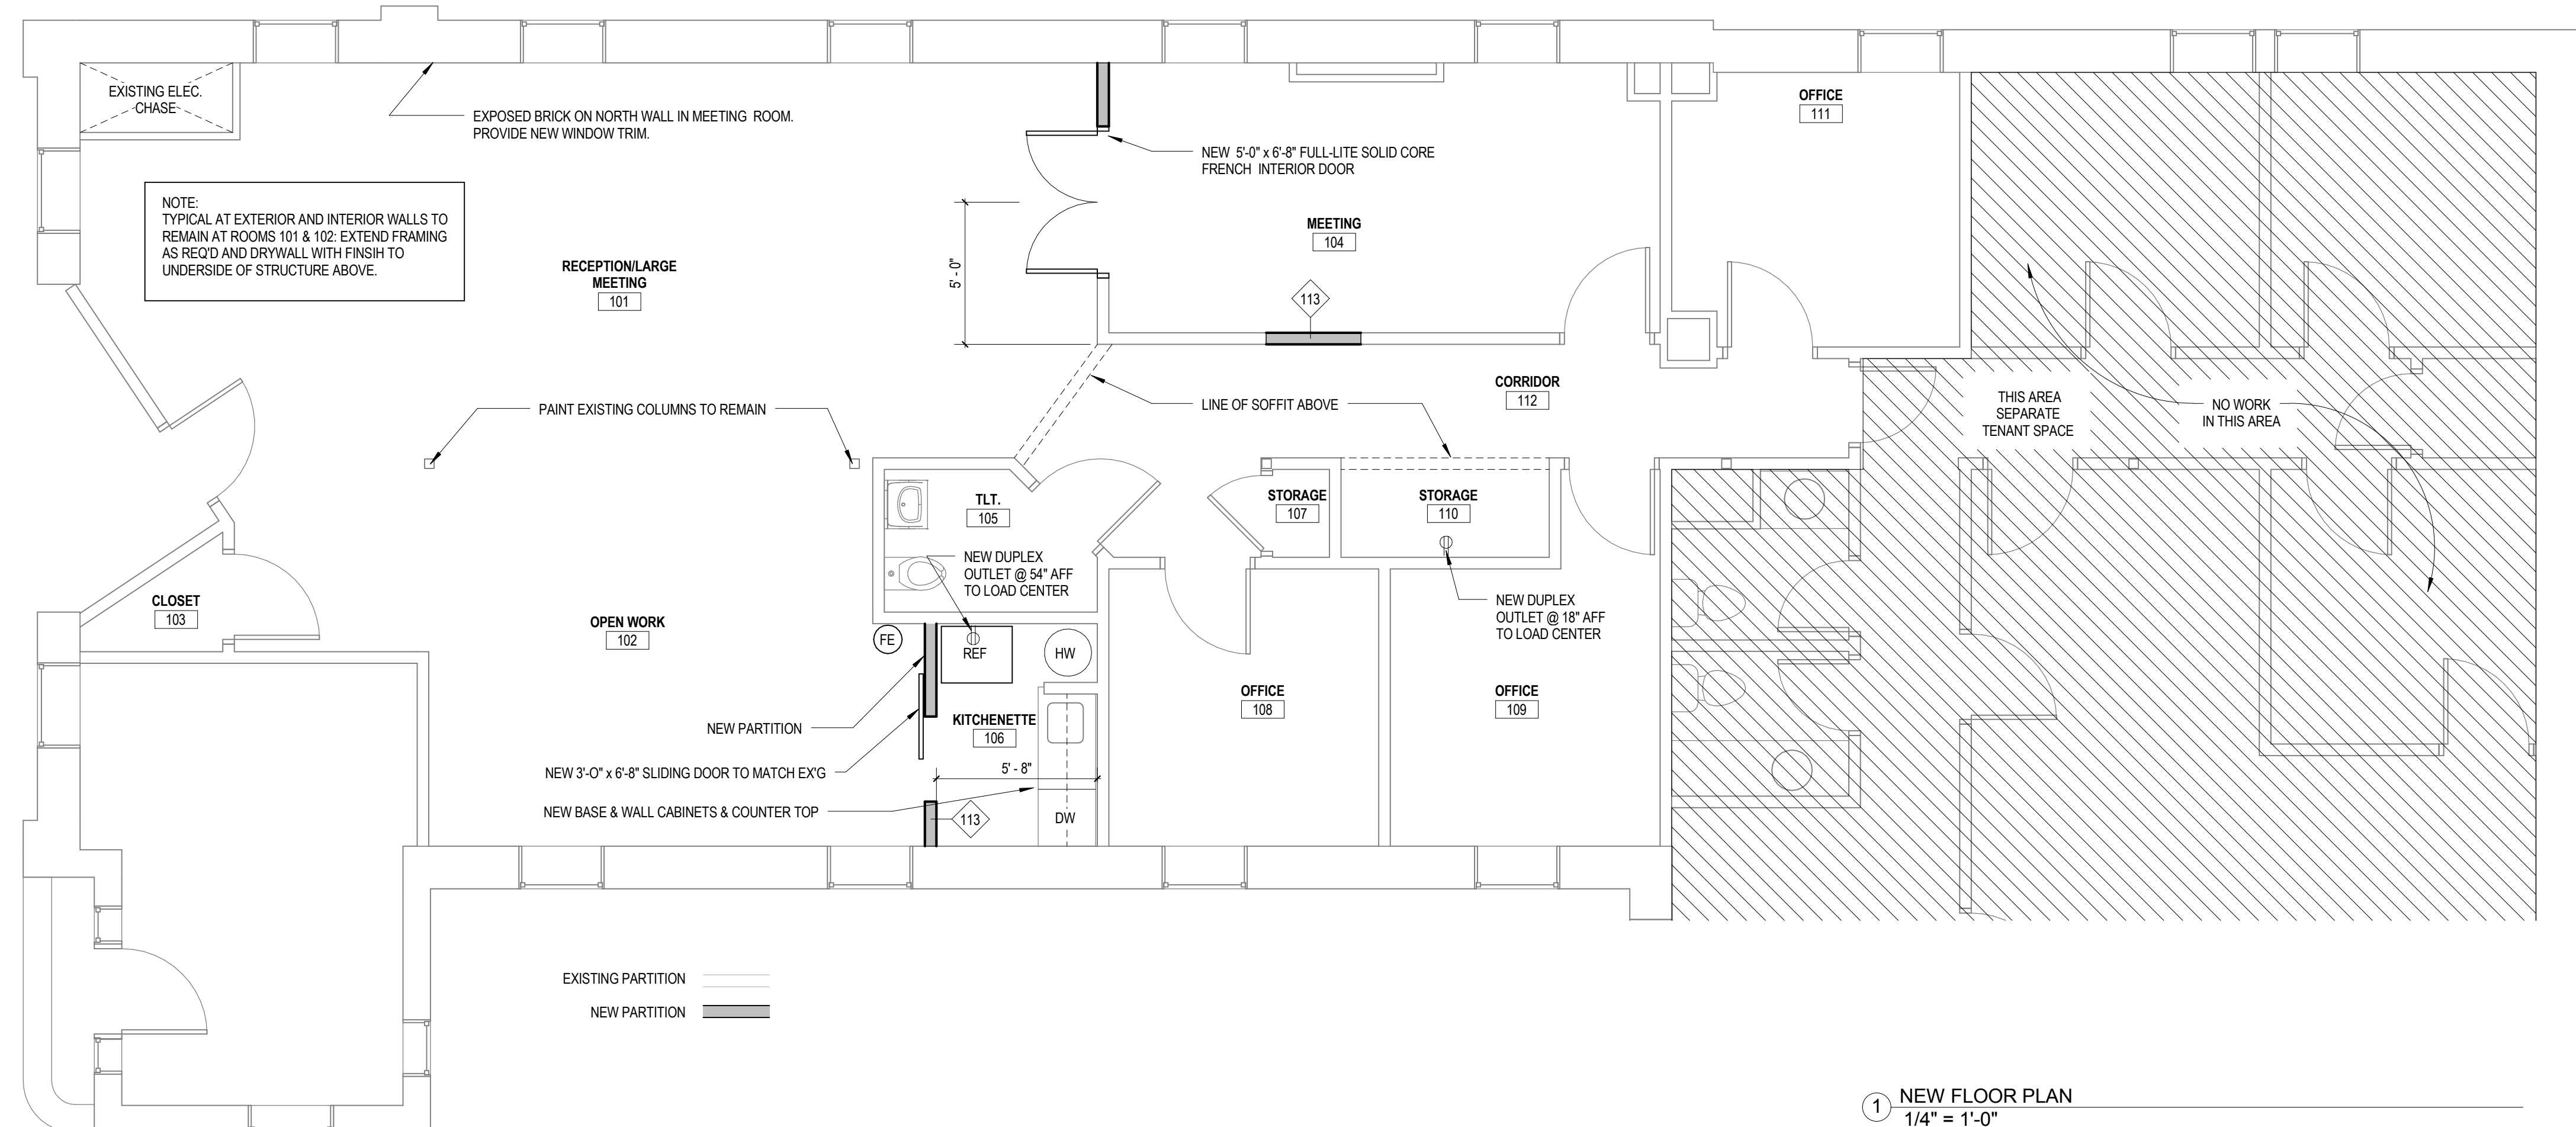

1 NEW FLOOR PLAN  
 1/4" = 1'-0"

Mark	Date	Description
Project Status		
<b>PERMIT</b>		
09/10/13		
Drawing Title		
<b>FLOOR PLAN &amp; RCP</b>		
Scale: As indicated		
Drawing Number		
<b>A10.1</b>		