

© 2016 RYAN SENATORE ARCHITECTURE

RESIDENCES
107 INDIA STREET
PORTLAND, MAINE



RYAN SENATORE ARCHITECTURE
565 CONGRESS STREET
PORTLAND, MAINE 04101
207-747-5159
senatorearchitecture.com

CONSULTANTS:
STRUCTURAL:
Structural Integrity
77 Oak Street
Portland, ME 04101
207-774-4614

REVISIONS:

DATE: FEBRUARY 5, 2016

PROJECT No.

DRAWN BY: RRT

CHECKED BY: RJS



SCALE: AS NOTED

SHEET TITLE:
BASEMENT - REFLECTED CEILING PLAN

A1-7

REFLECTED CEILING PLAN AND LIGHTING LEGEND		
SYMBOL	TAG	DESCRIPTION
⊕	A	4" RECESSED CAN
⊕	B	4" RECESSED CAN - WET LOCATION
⊕	C	4" SURFACE MOUNT
⊕	D	4" SURFACE MOUNT - WET LOCATION
⊕	E	SURFACE MOUNTED ON WALL ABOVE DOOR
⊕	F	WALL SCONCE
⊕	G	PENDANT LIGHTING
⊕	H	CABLE LIGHTING
⊕	J	SURFACE MOUNT "CUSTOM"
⊕	K	1X4 SURFACE MOUNTED FIXTURE
⊕	L	WALL WASHER
⊕	M	EXTERIOR CUT-OFF WALL MOUNTED DN. LIGHT
⊕	N	EXTERIOR RECESSED DOWN LIGHT
⊕	P	SURFACE MOUNT WITH LENS
⊕		CEILING GRILLE

NOTES:
1.) ALL LIGHTING TO BE LED LAMPS
2.) ALL LIGHTING TO BE ON DIMMERS

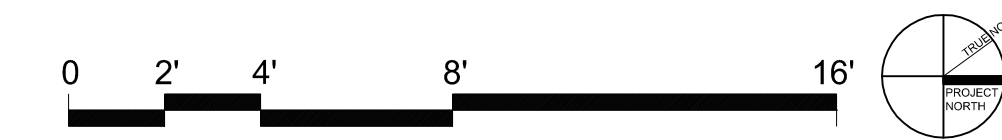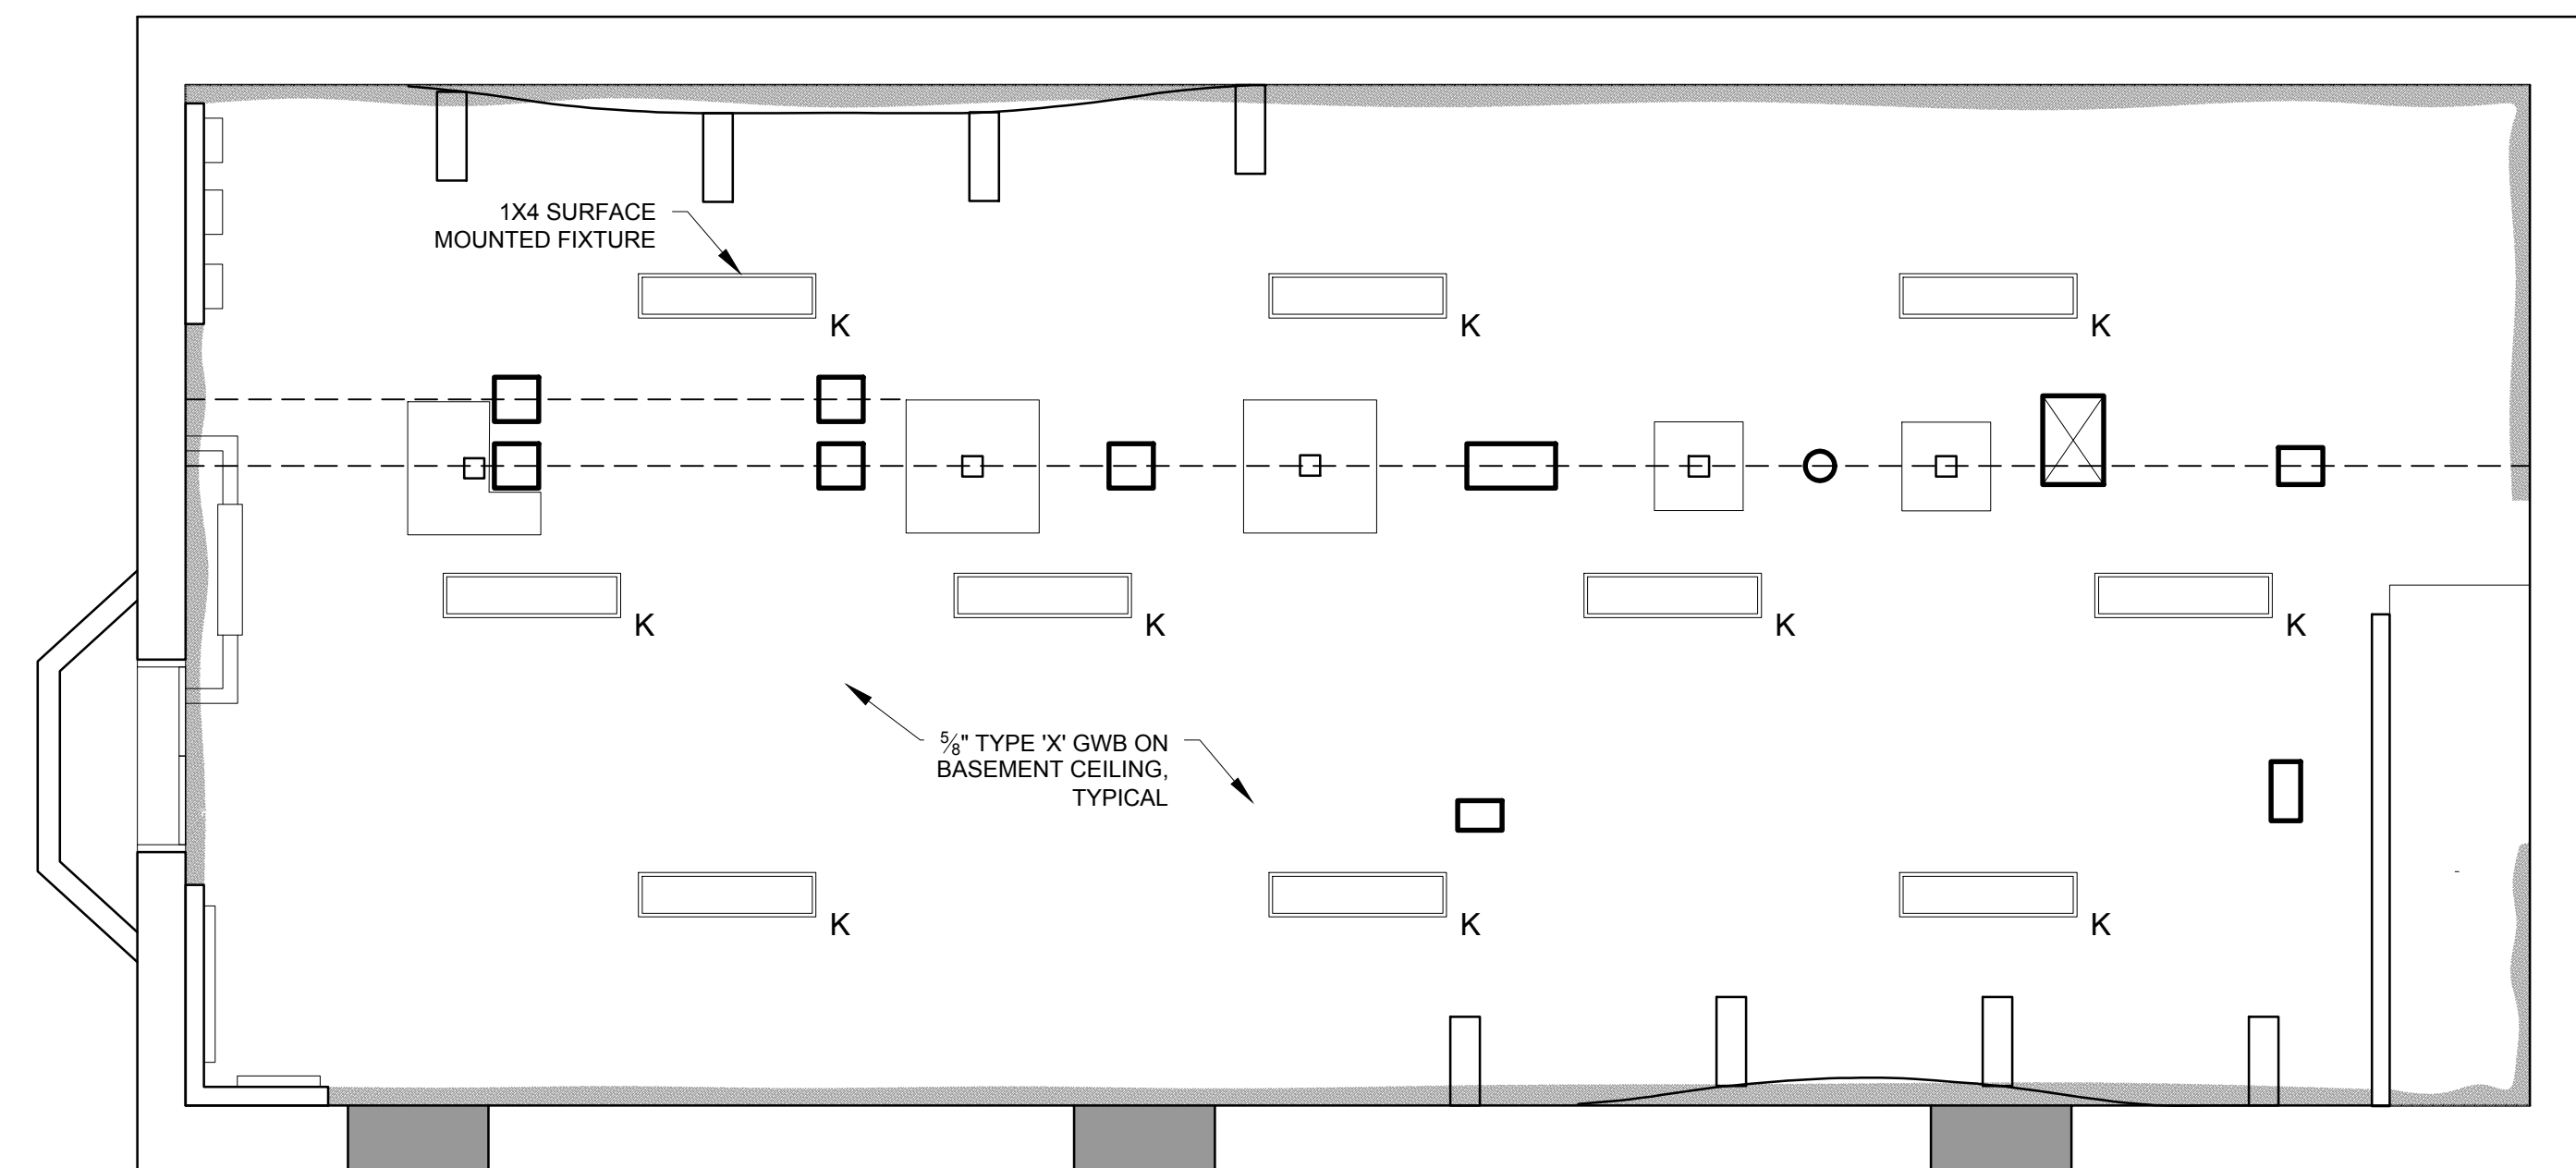

1 BASEMENT - REFLECTED CEILING PLAN
1/4" = 1'-0"