


**1 ELECTRICAL PLAN**  
SCALE: 1/4" = 1'-0"

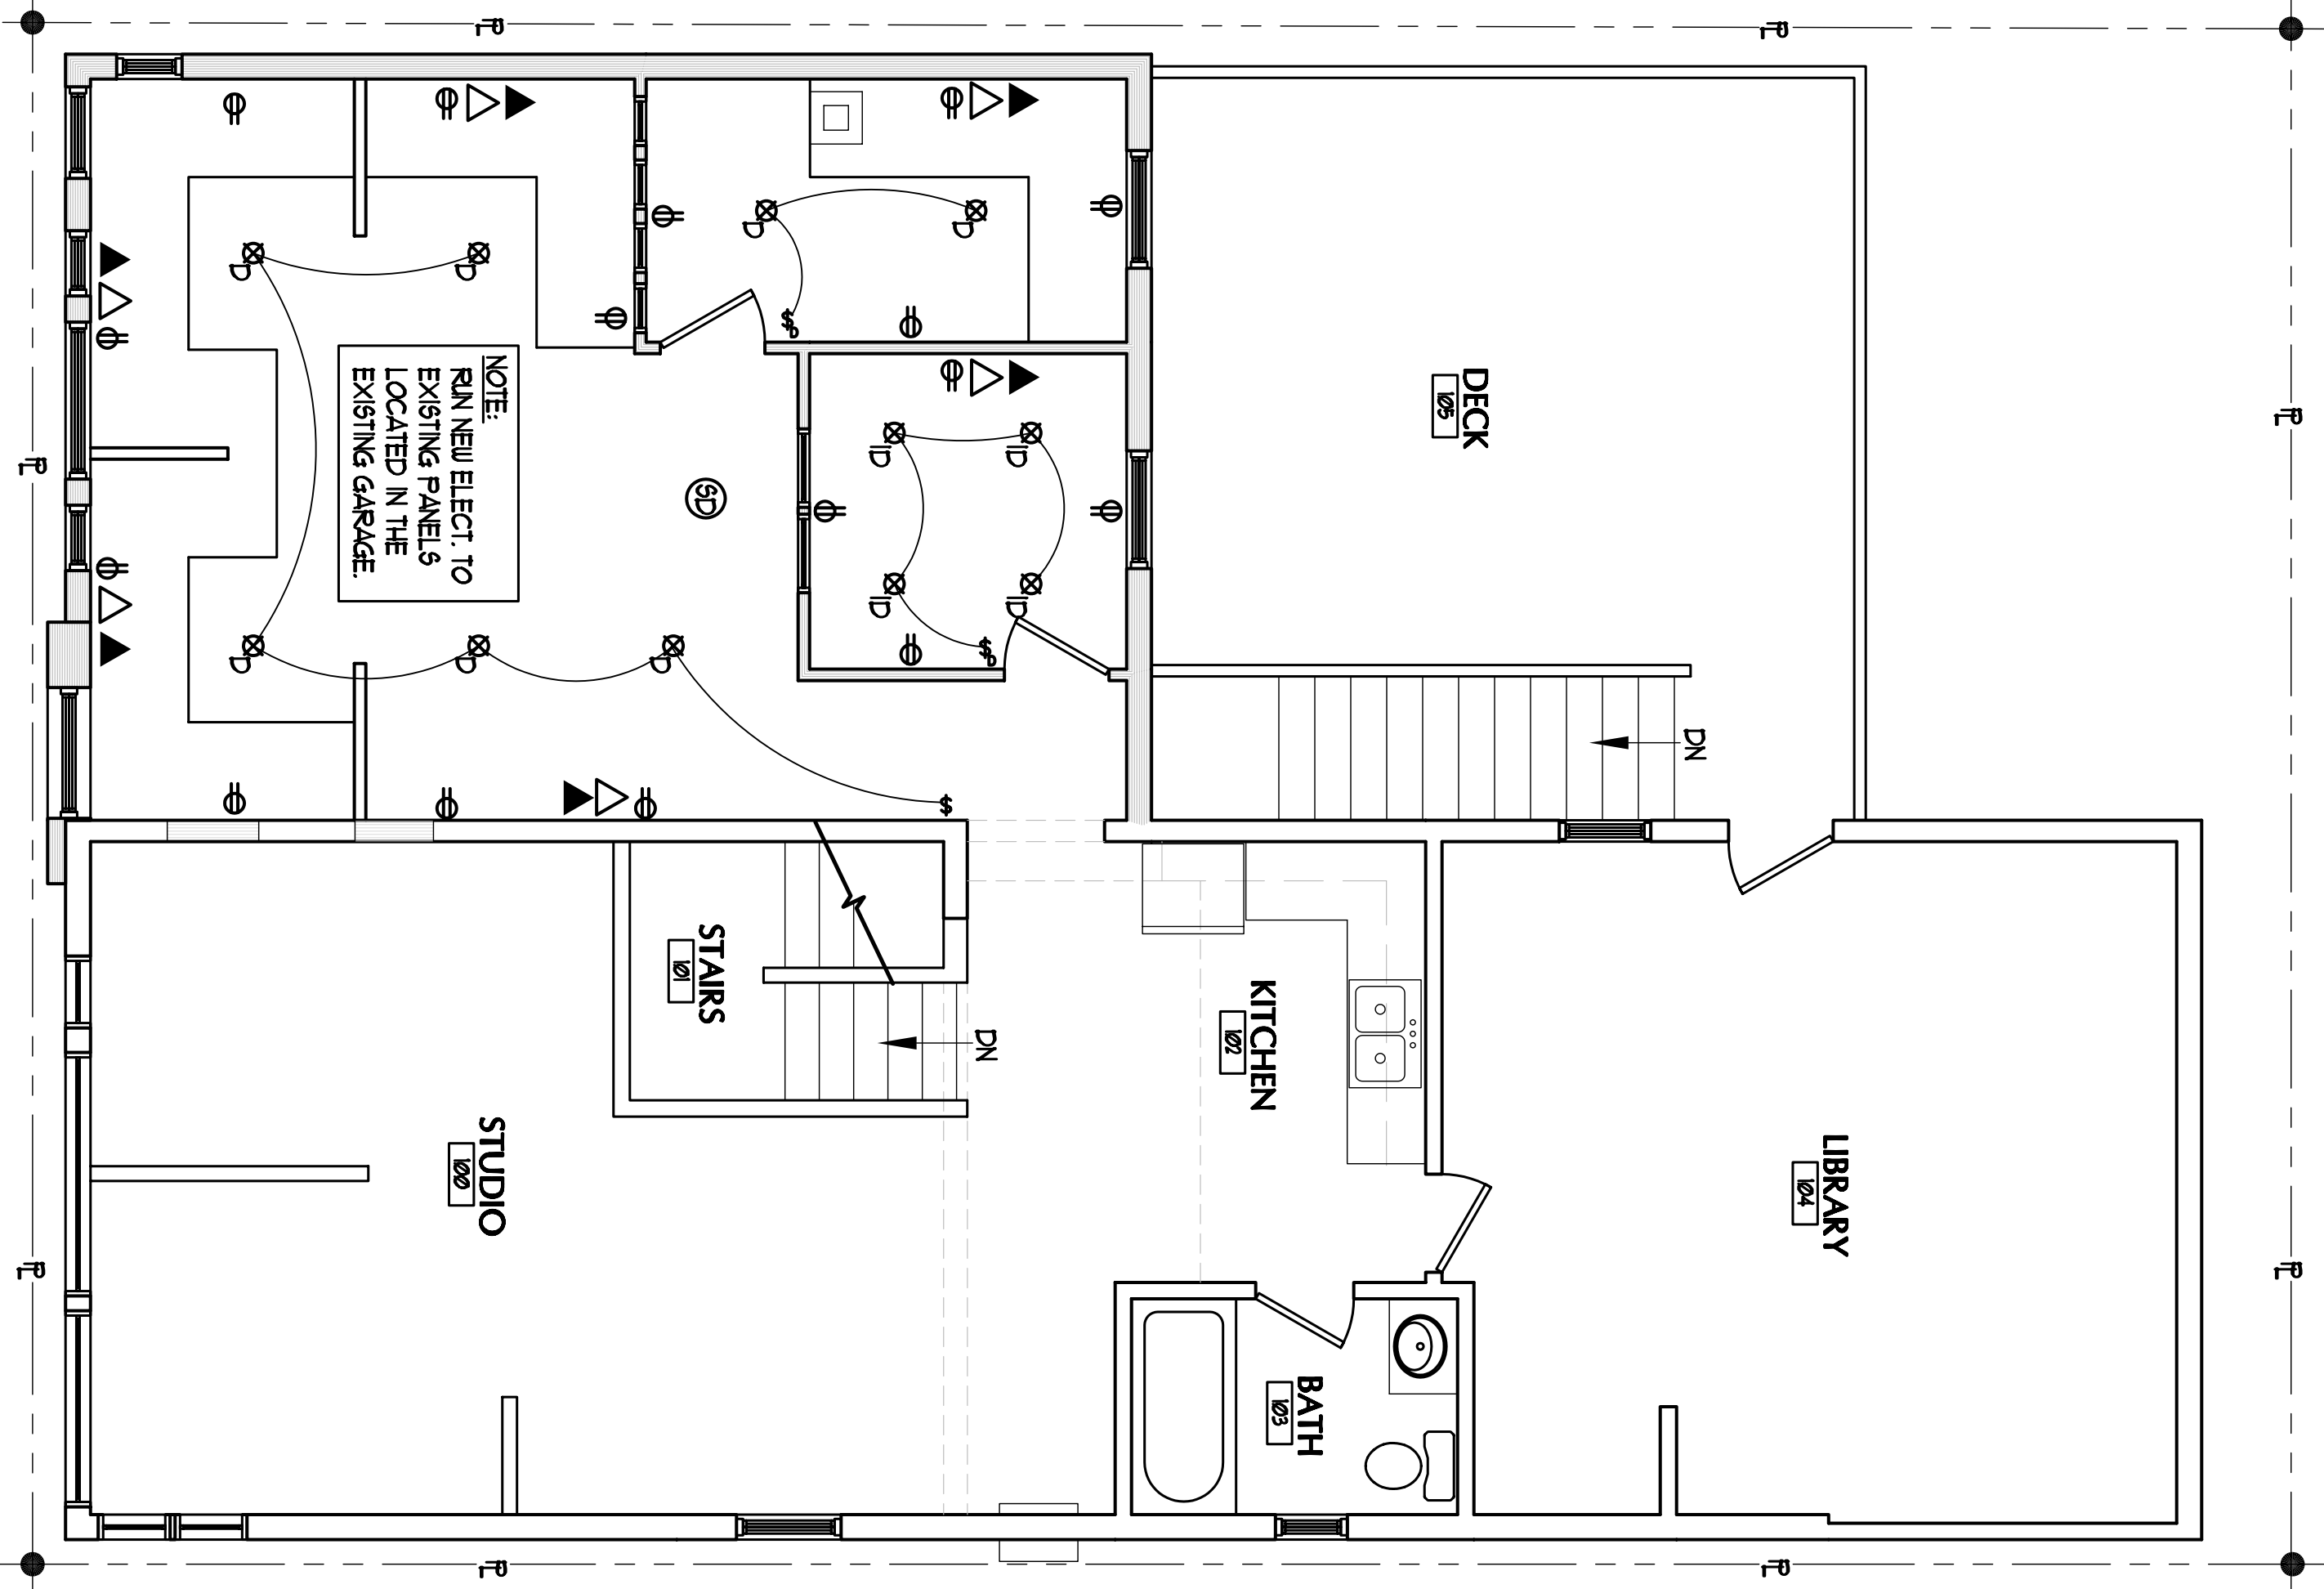


NOTE:  
RUN NEW ELECT TO  
EXISTING PANELS  
LOCATED IN THE  
EXISTING GARAGE.


**ELECTRICAL KEY**

- ⊕ POWER OUTLET
- ▲ DATA OUTLET
- ▽ TELEPHONE OUTLET
- ⊙ SMOKE DETECTOR
- ⊕ SINGLE SWITCH
- ⊕ DIMMER SWITCH
- ⊕ RECESSED DOWNLIGHT (C)
- ⊕ R19 RECESSED DOWNLIGHT (C)

**2 UTILITIES PLAN**  
SCALE: 1/4" = 1'-0"

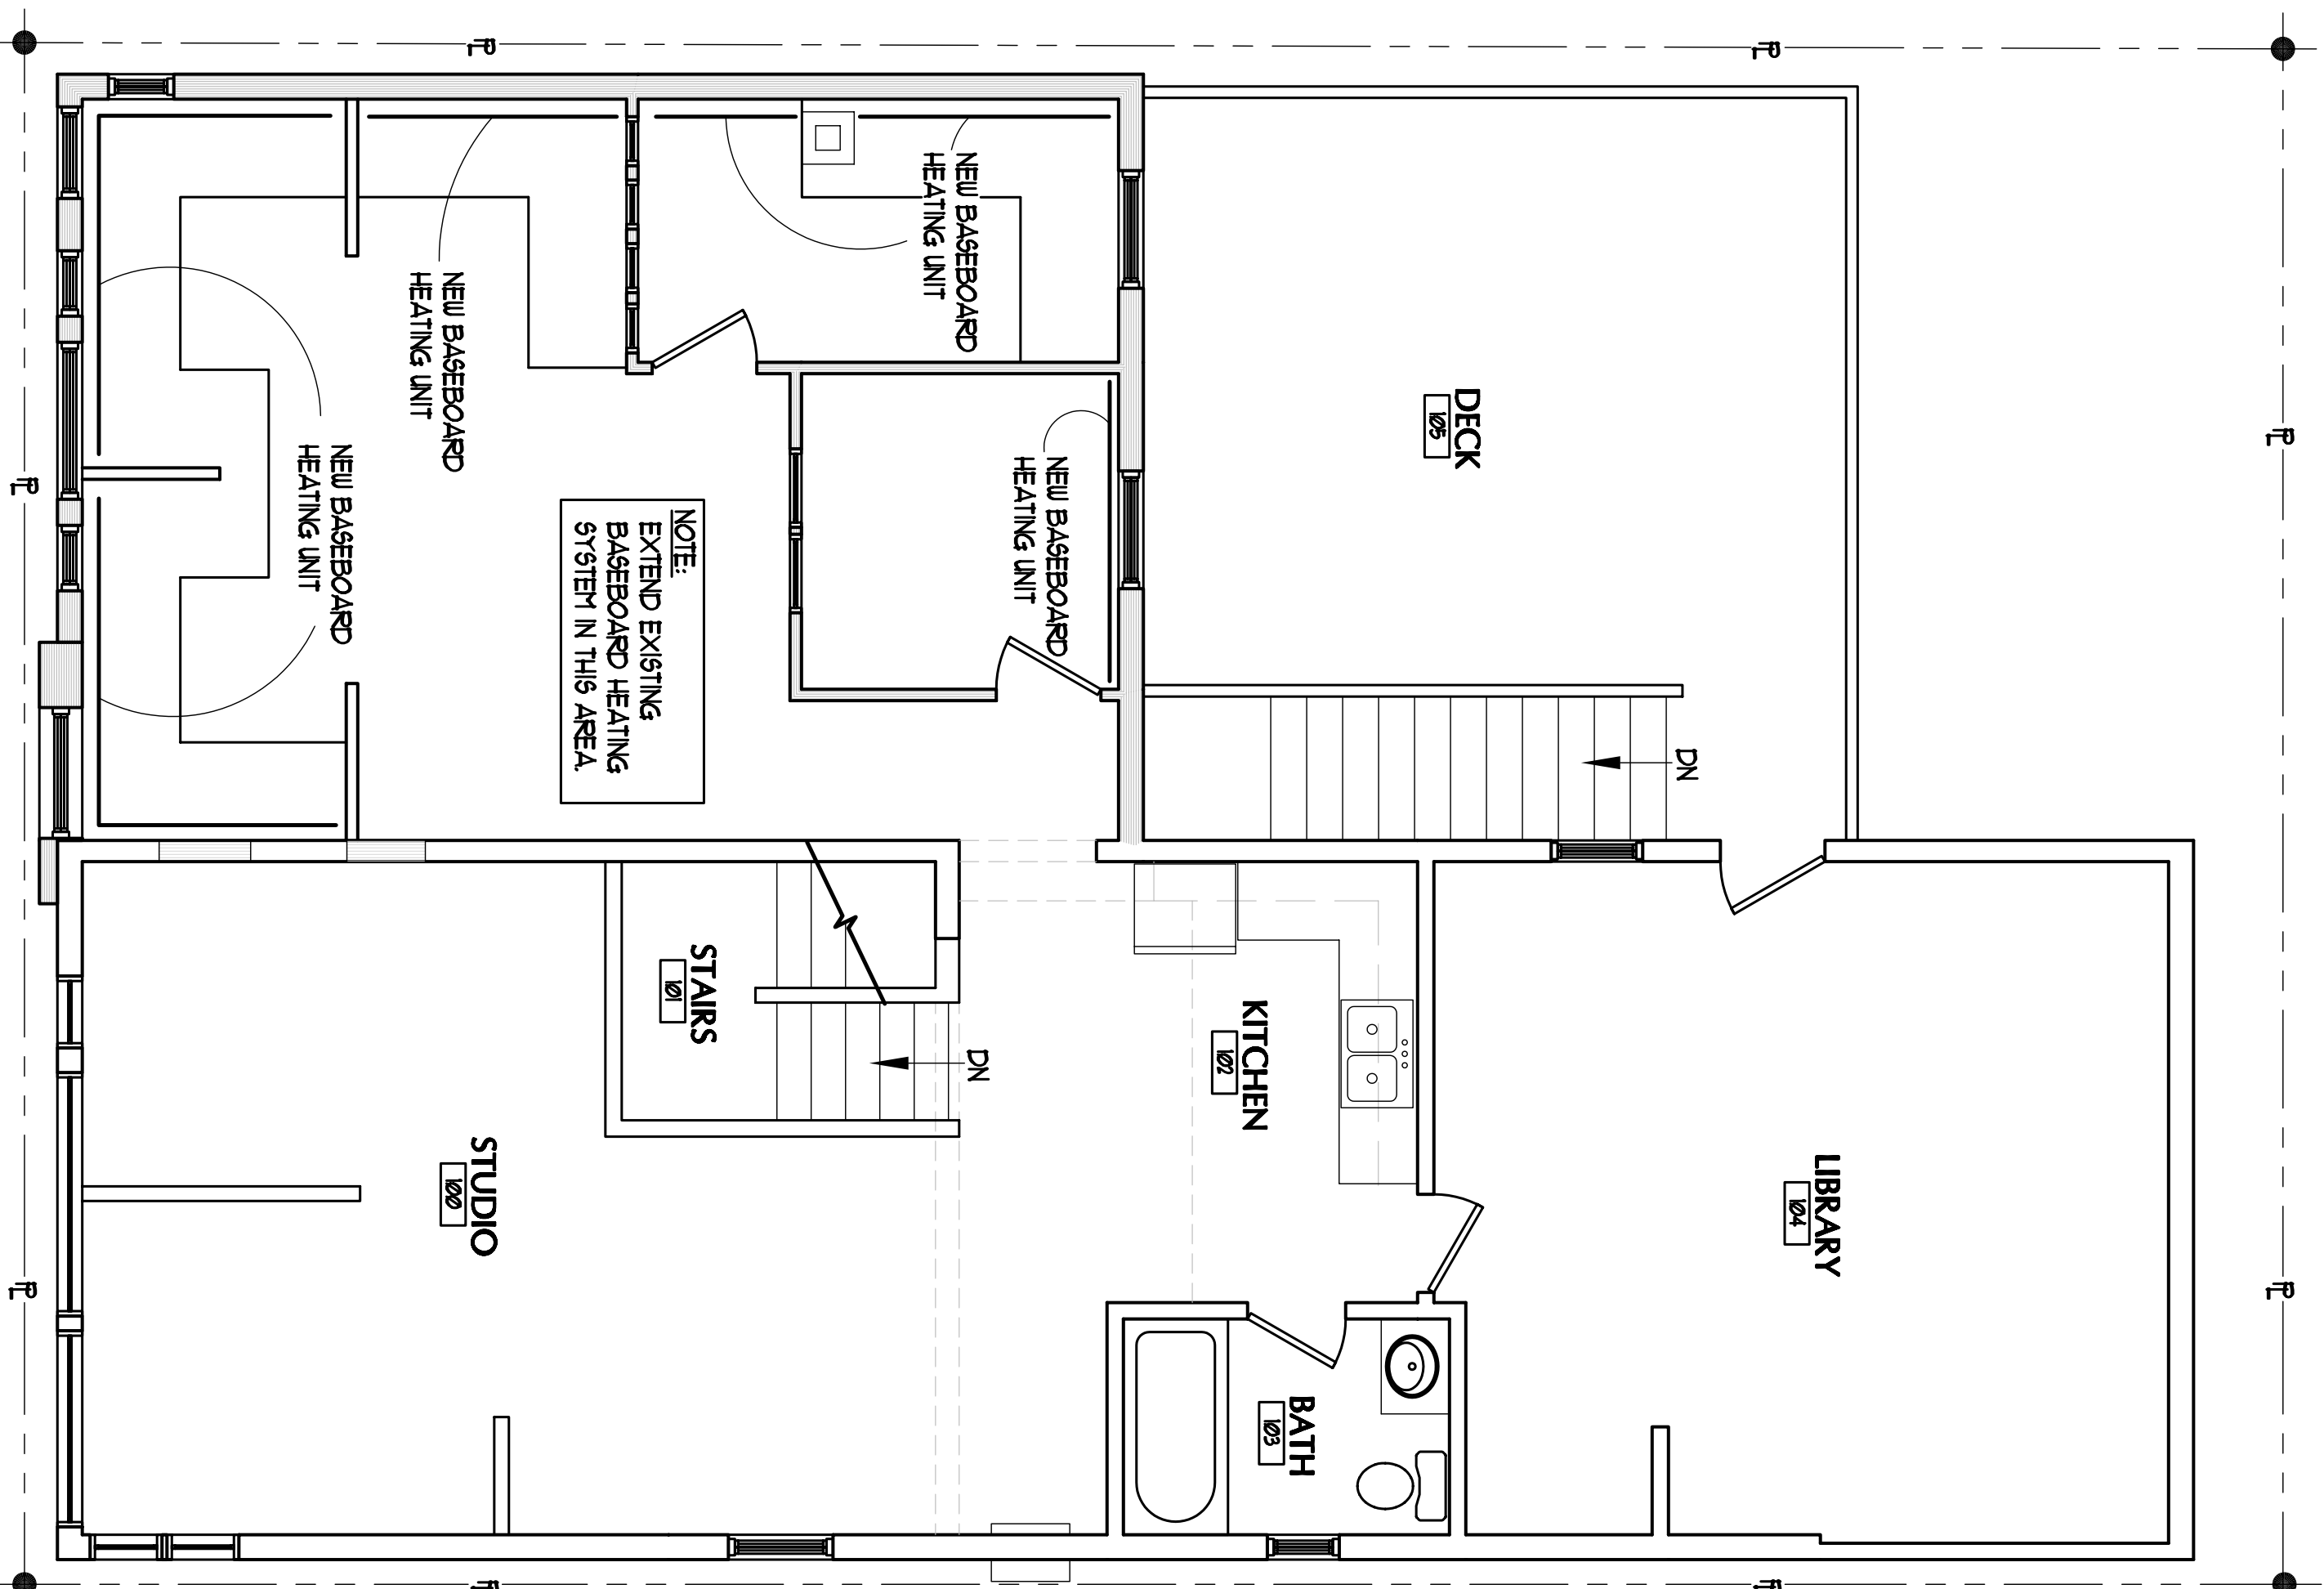

NOTE:  
EXTEND EXISTING  
BASEBOARD HEATING  
SYSTEM IN THIS AREA.

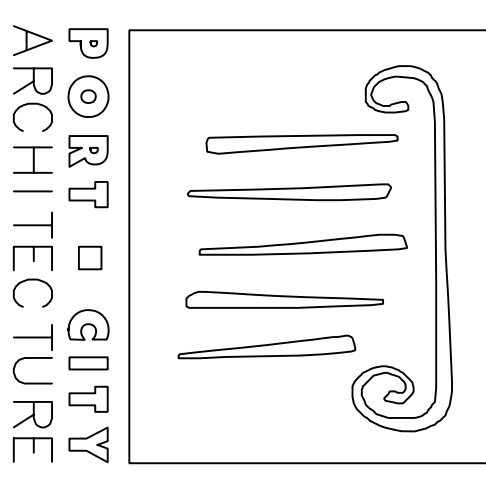

**PORT CITY ARCHITECTURE**  
65 NEWBURY STREET  
PORTLAND, ME 04101  
207.761.9000  
fax: 207.761.2010  
info@portcityarch.com

CONSULTANTS:

**Office Renovations**  
**PORT CITY ARCHITECTURE**  
Portland, Maine

DATE	DESCRIPTION	DESIGN REVIEW
REVISIONS		
DATE		

Date Issued: FEB - 2007  
 Project Number: 07106  
 Drawing Scale:

SHEET NAME  
**UTILITY PLANS**

Drawn By: ANP  
Checked By: ACH  
**EI**

**PERMIT SET**