



LEGEND OF SYMBOLS

- (XX) — COLUMN LINE MARKER
- XXX — CEILING MATERIAL
- X'-XX" — CEILING HEIGHT
- (XX) AX.X — SECTION DESIGNATION
DRWG. NUMBER WHERE SECTION APPEARS
- (XX) AX.X — DETAIL NUMBER
DRWG. NUMBER WHERE DETAIL APPEARS

CEILING TYPE LEGEND

- GMB - PAINTED GYPSUM BOARD - SEE FINISH SCHEDULE ON A9.0
- ACT - ACOUSTICAL CEILING TILE - SEE FINISH SCHEDULE ON SHEET A9.0
- ACT 2 - ACOUSTICAL CEILING TILE - SEE FINISH SCHEDULE ON SHEET A9.0
- PT - PAINTED PLANK - SEE FINISH SCHEDULE ON A9.0
- SB - SURFACE BOARD - SEE FINISH SCHEDULE ON A9.0

- GENERAL NOTES:**
1. SEE A4.4 FOR LIGHT FIXTURE SCHEDULE
 2. ANY CONCEALED SPACES OVER 900 S.F. MUST BE CONSTRUCTED WITH NON-COMBUSTIBLE MATERIALS.
 3. WHERE SPRINKLER HEADS OCCUR IN AREAS WITH SUSPENDED CEILINGS THEY ARE TO BE CENTERED ON CEILING TILES.
 4. CEILING TILES TO BE CENTERED IN CORRIDORS TYPICAL.
 5. WHERE LIGHT FIXTURES OCCUR IN AREAS WITH SUSPENDED CEILINGS THEY ARE TO BE CENTERED ON CEILING TILES.
 6. IN NET AREAS USE MOISTURE RESISTANT GYPSUM BOARD WITH VAPOR BARRIER


PLANK FINISH NOTES:

- ALL UNDERSIDE OF PLANKS ARE TO BE CLEARED OF ALL MORTAR & DEBRIS AND ARE TO BE PATCHED OF ALL CRACKS & FISSURES
- PLANK JOINTS ARE TO BE CAULKED
- PLANK TO RECEIVE TEXTURED SPRAY FINISH PAINT AS INDICATED

PERMIT ISSUE - 09/27/07

NO.	REVISION	DATE

SCALE: As Noted DRAWN BY: LCM/MS/ES
DATE: CHECKED BY: JR

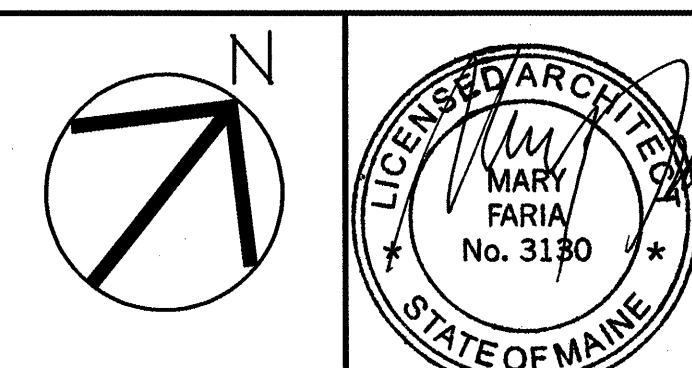

PROJECT

RESIDENCE INN BY MARRIOTT

PORTLAND, ME

JOB# 802

TITLE

FIRST FLOOR REFLECTED CEILING PLAN

GROUP ONE
21 W. THIRD STREET, BOSTON, MA 02127
TEL: (617)268-7000 FAX: (617)268-0209

DRAWING NO.

A4.0

1 REFLECTED CEILING PLAN - FIRST FLOOR
SCALE: 3/16"=1'-0"

2 KEY PLAN
N.T.S.