

LEGEND OF SYMBOLS	
(XX)	COLUMN LINE MARKER
XXX	CEILING MATERIAL
X'-XX"	CEILING HEIGHT
AXX	SECTION DESIGNATION
DRNG. NUMBER	WHERE SECTION APPEARS
XXX	DETAIL NUMBER
AXX	DRNG. NUMBER WHERE DETAIL APPEARS

CEILING TYPE LEGEND	
GMB	- PAINTED GYPSUM BOARD - SEE FINISH SCHEDULE ON A9.0
ACT	- ACOUSTICAL CEILING TILE - SEE FINISH SCHEDULE ON SHEET A9.0
ACT 2	- ACOUSTICAL CEILING TILE - SEE FINISH SCHEDULE ON SHEET A9.0
PT	- PAINTED PLANK - SEE FINISH SCHEDULE ON A9.0
SB	- SURFACE BOARD - SEE FINISH SCHEDULE ON A9.0

- GENERAL NOTES:
- SEE A4.4 FOR LIGHT FIXTURE SCHEDULE
 - ANY CONCEALED SPACES OVER 100 S.F. MUST BE CONSTRUCTED WITH NON-COMBUSTIBLE MATERIALS. WHERE SPRINKLER HEADS OCCUR IN AREAS WITH SUSPENDED CEILINGS THEY ARE TO BE CENTERED ON CEILING TILES.
 - CEILING TILES TO BE CENTERED IN CORRIDORS TYPICAL.
 - WHERE LIGHT FIXTURES OCCUR IN AREAS WITH SUSPENDED CEILINGS THEY ARE TO BE CENTERED ON CEILING TILES.
 - IN WET AREAS USE MOISTURE RESISTANT GYPSUM BOARD WITH VAPOR BARRIER


PLANK FINISH NOTES:

- ALL UNDERSIDE OF PLANKS ARE TO BE CLEARED OF ALL MORTAR & DEBRIS AND ARE TO BE PATCHED OF ALL CRACKS & FISURES.
- PLANK JOINTS ARE TO BE CAULKED
- PLANK TO RECEIVE TEXTURED SPRAY FINISH PAINT AS INDICATED

PERMIT ISSUE - 09/27/07

NO.	REVISION	DATE

SCALE: As Noted DRAWN BY: ES/AVS
 DATE: CHECKED BY: JR

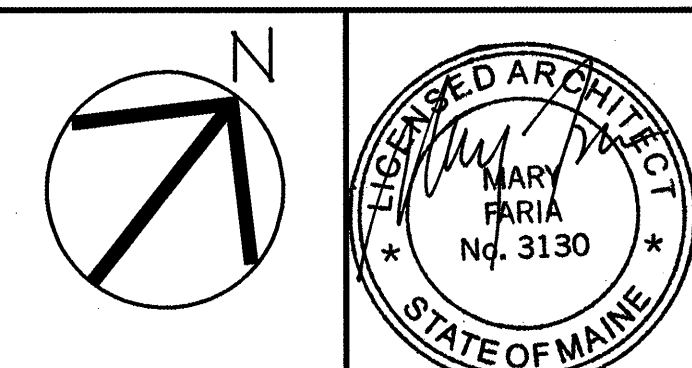

PROJECT

RESIDENCE INN BY MARRIOTT

PORTLAND, ME

JOB# 802

TITLE

FIRST FLOOR REFLECTED CEILING PLAN

GROUP ONE

21 W. THIRD STREET, BOSTON, MA 02127
 TEL: (617)268-7000 FAX: (617)268-0209

DRAWING NO.

A4.2

1 REFLECTED CEILING PLAN - FIRST FLOOR
 SCALE: 3/16"=1'-0"

2 KEY PLAN
 N.T.S.