



1:1855 PM, MA
 09/27/07 10:20:08 Sun 2896.219273-000-DWG.rws

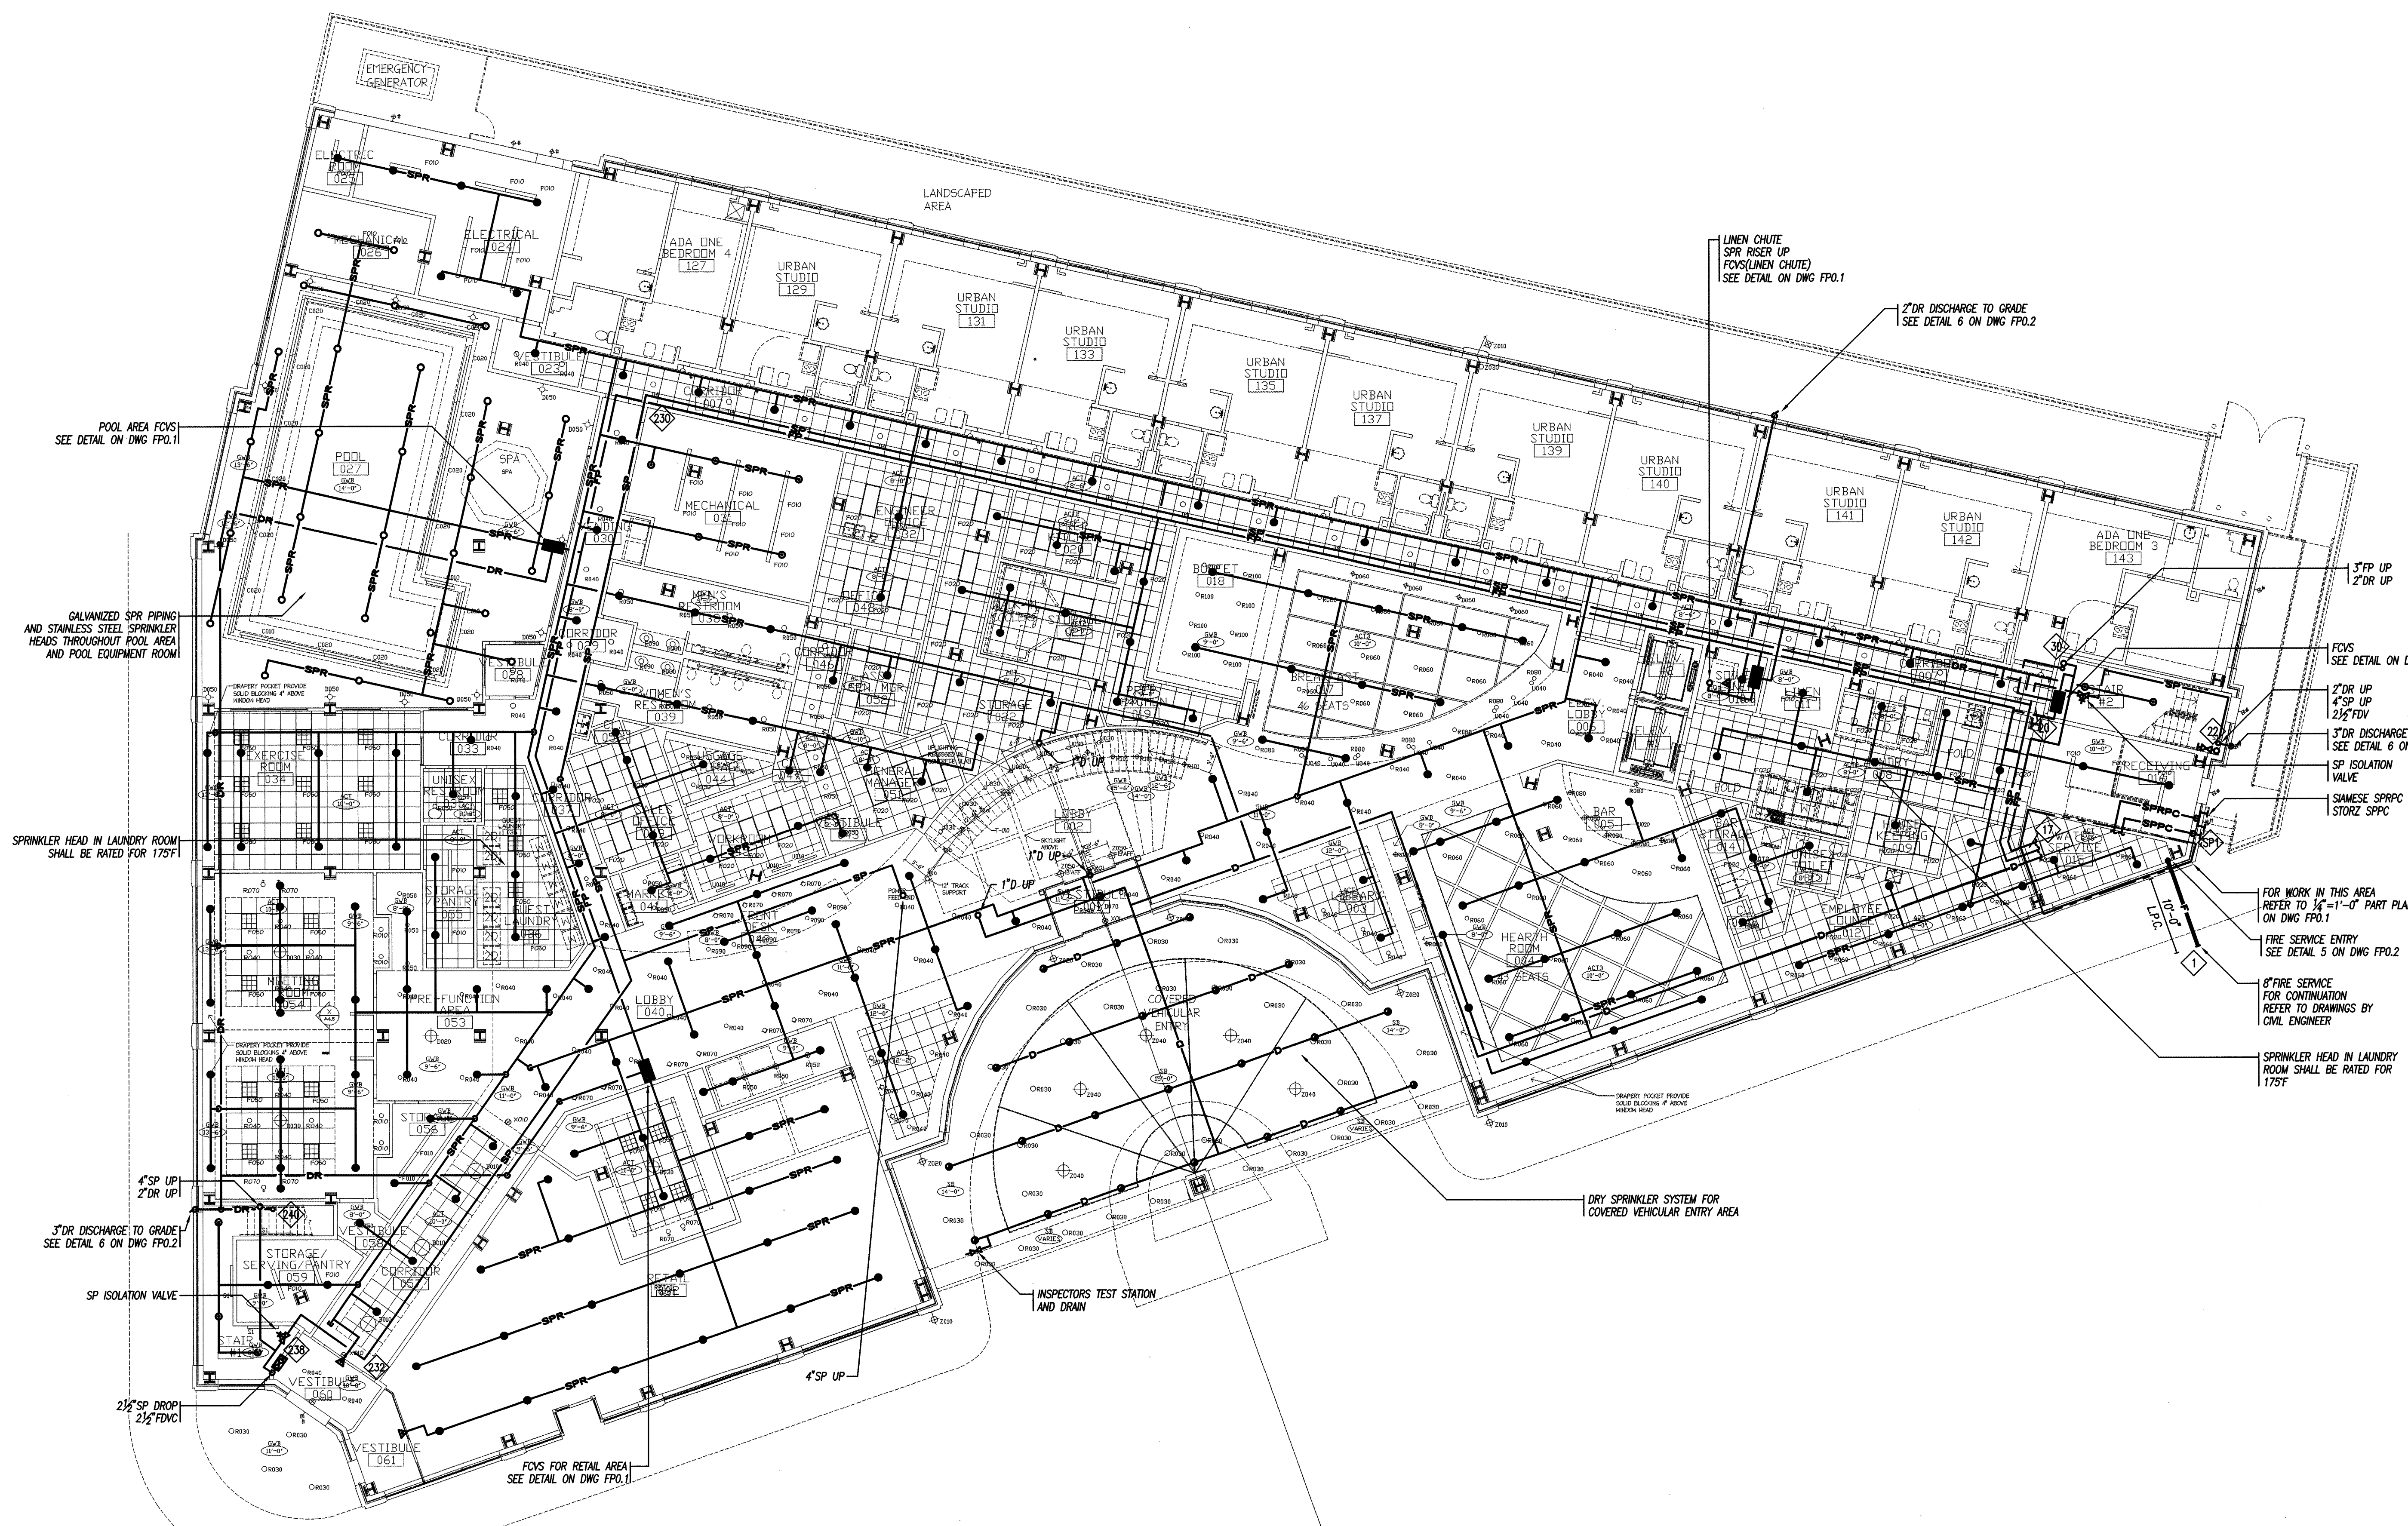

PERMIT ISSUE - 09/27/07

NO.	REVISION	DATE
SCALE: 3/32"=1' 0"	DRAWN BY: EMG	
DATE: 09/27/07	CHECKED BY: RJM	

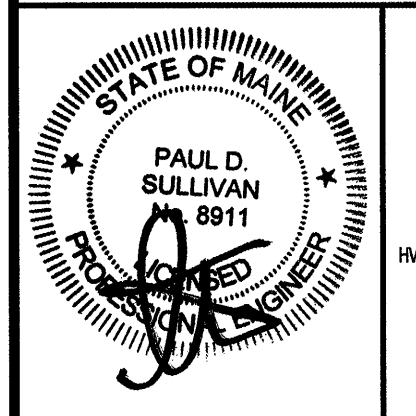

RWS
 R. W. Sullivan Engineering
 HVAC, Electrical, Plumbing, Fire Protection, Code
 The Seaside Center
 529 Main Street, Suite 203
 Boston, Massachusetts 02129-1107
 Phone: (617) 524-8222
 Fax: (617) 524-8216
 www.rwsusa.com
 RWS Job No. 2273.00

PROJECT
RESIDENCE INN BY MARRIOTT
 PORTLAND, ME
JOB# 802

TITLE
FIRE PROTECTION FIRST FLOOR PLAN

GROUP ONE
 21 W. THIRD STREET, BOSTON, MA 02127
 TEL: (617)268-7000 FAX: (617)268-0209

DRAWING NO.
FP1.1