


J:\2007\1620-106-106-2260-219-2123-000-Dwg\1620-106-106-2260-219-2123-000-FP1.2.dwg, 8/27/2007 1:20:07 PM, W

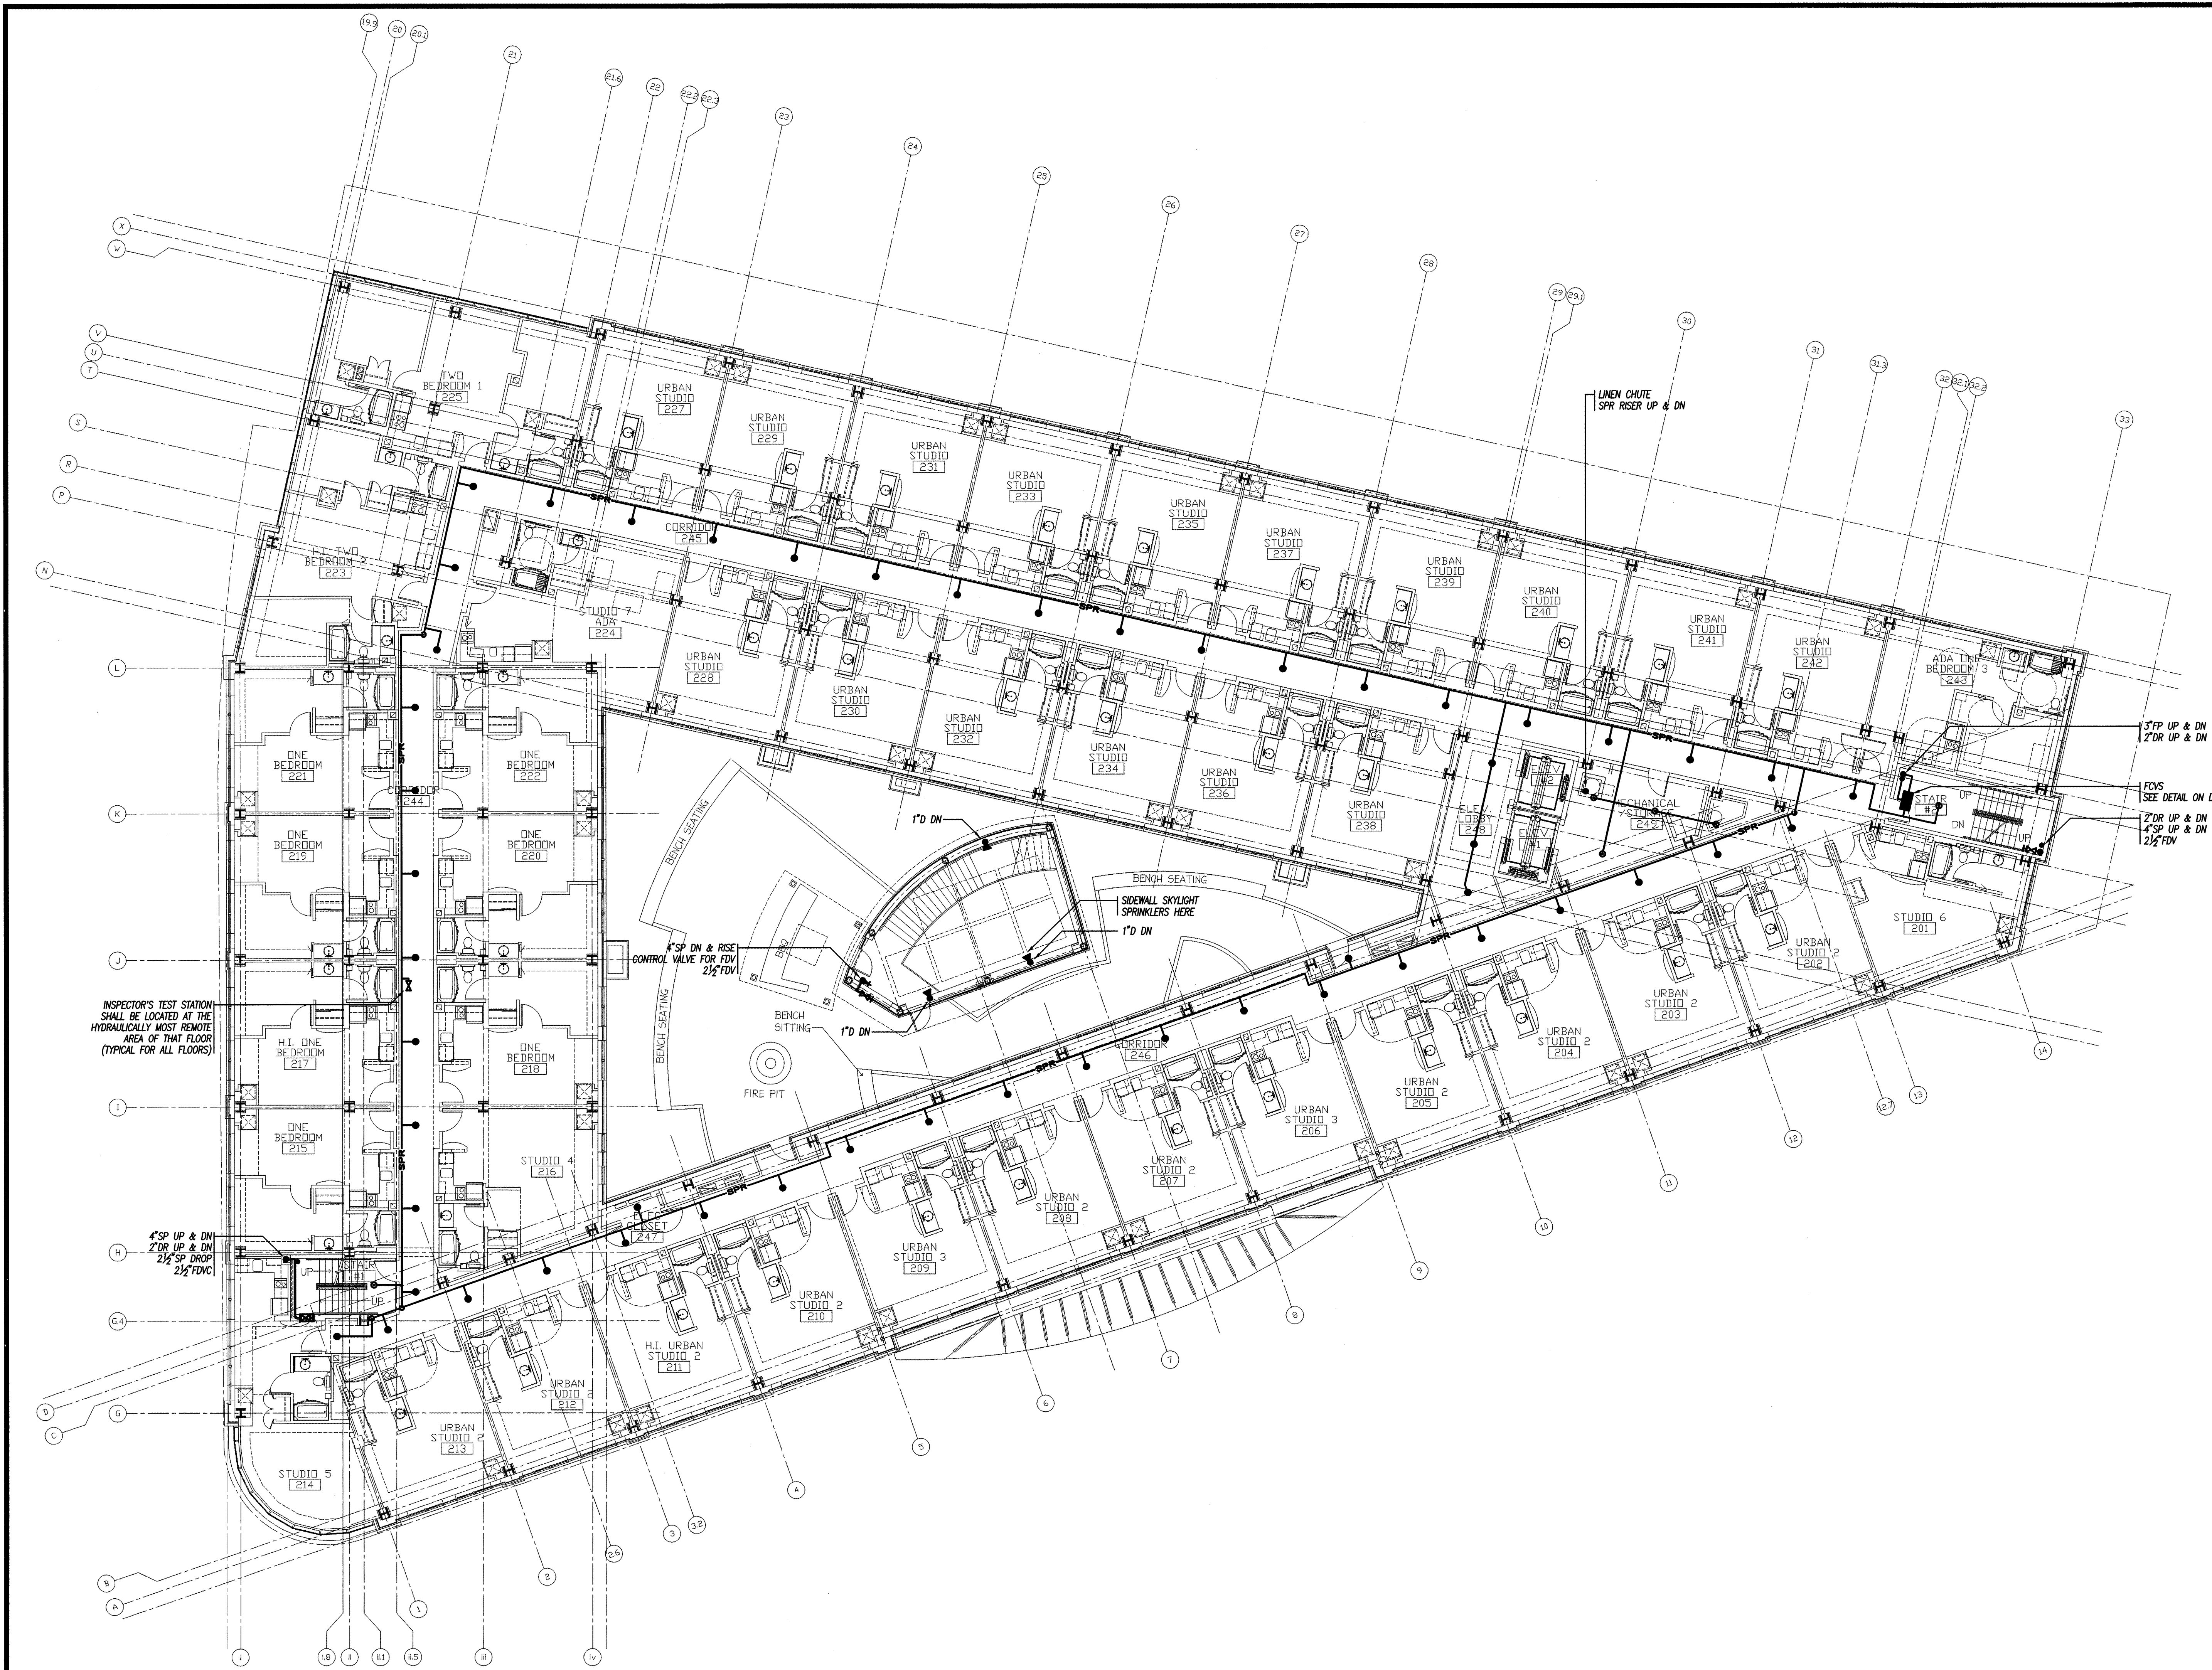

PERMIT ISSUE - 09/27/07

NO.	REVISION	DATE
SCALE: 3/32"=1' 0"		DRAWN BY: EMG
DATE: 09/27/07		CHECKED BY: RJM

PAUL D. SULLIVAN
No. 8911

R. W. Sullivan Engineering
The Small Center
529 Main Street, Suite 203
Boston, Massachusetts 02129-1107
Phone: (617) 524-8227
Fax: (617) 524-8216
www.rwsllian.com
RWS Job No. 2273.00

PROJECT

**RESIDENCE INN
BY MARRIOTT**

PORTLAND, ME

JOB# 802

TITLE

**FIRE PROTECTION
SECOND FLOOR PLAN**

GROUP ONE
21 W. THIRD STREET, BOSTON, MA 02127
TEL: (617)268-7000 FAX: (617)268-0209

DRAWING NO.

FP1.2