



1/2007 1920-06.swg 2260-2119.0213-000.dwg 12/27/07 12:27 PM, WJ

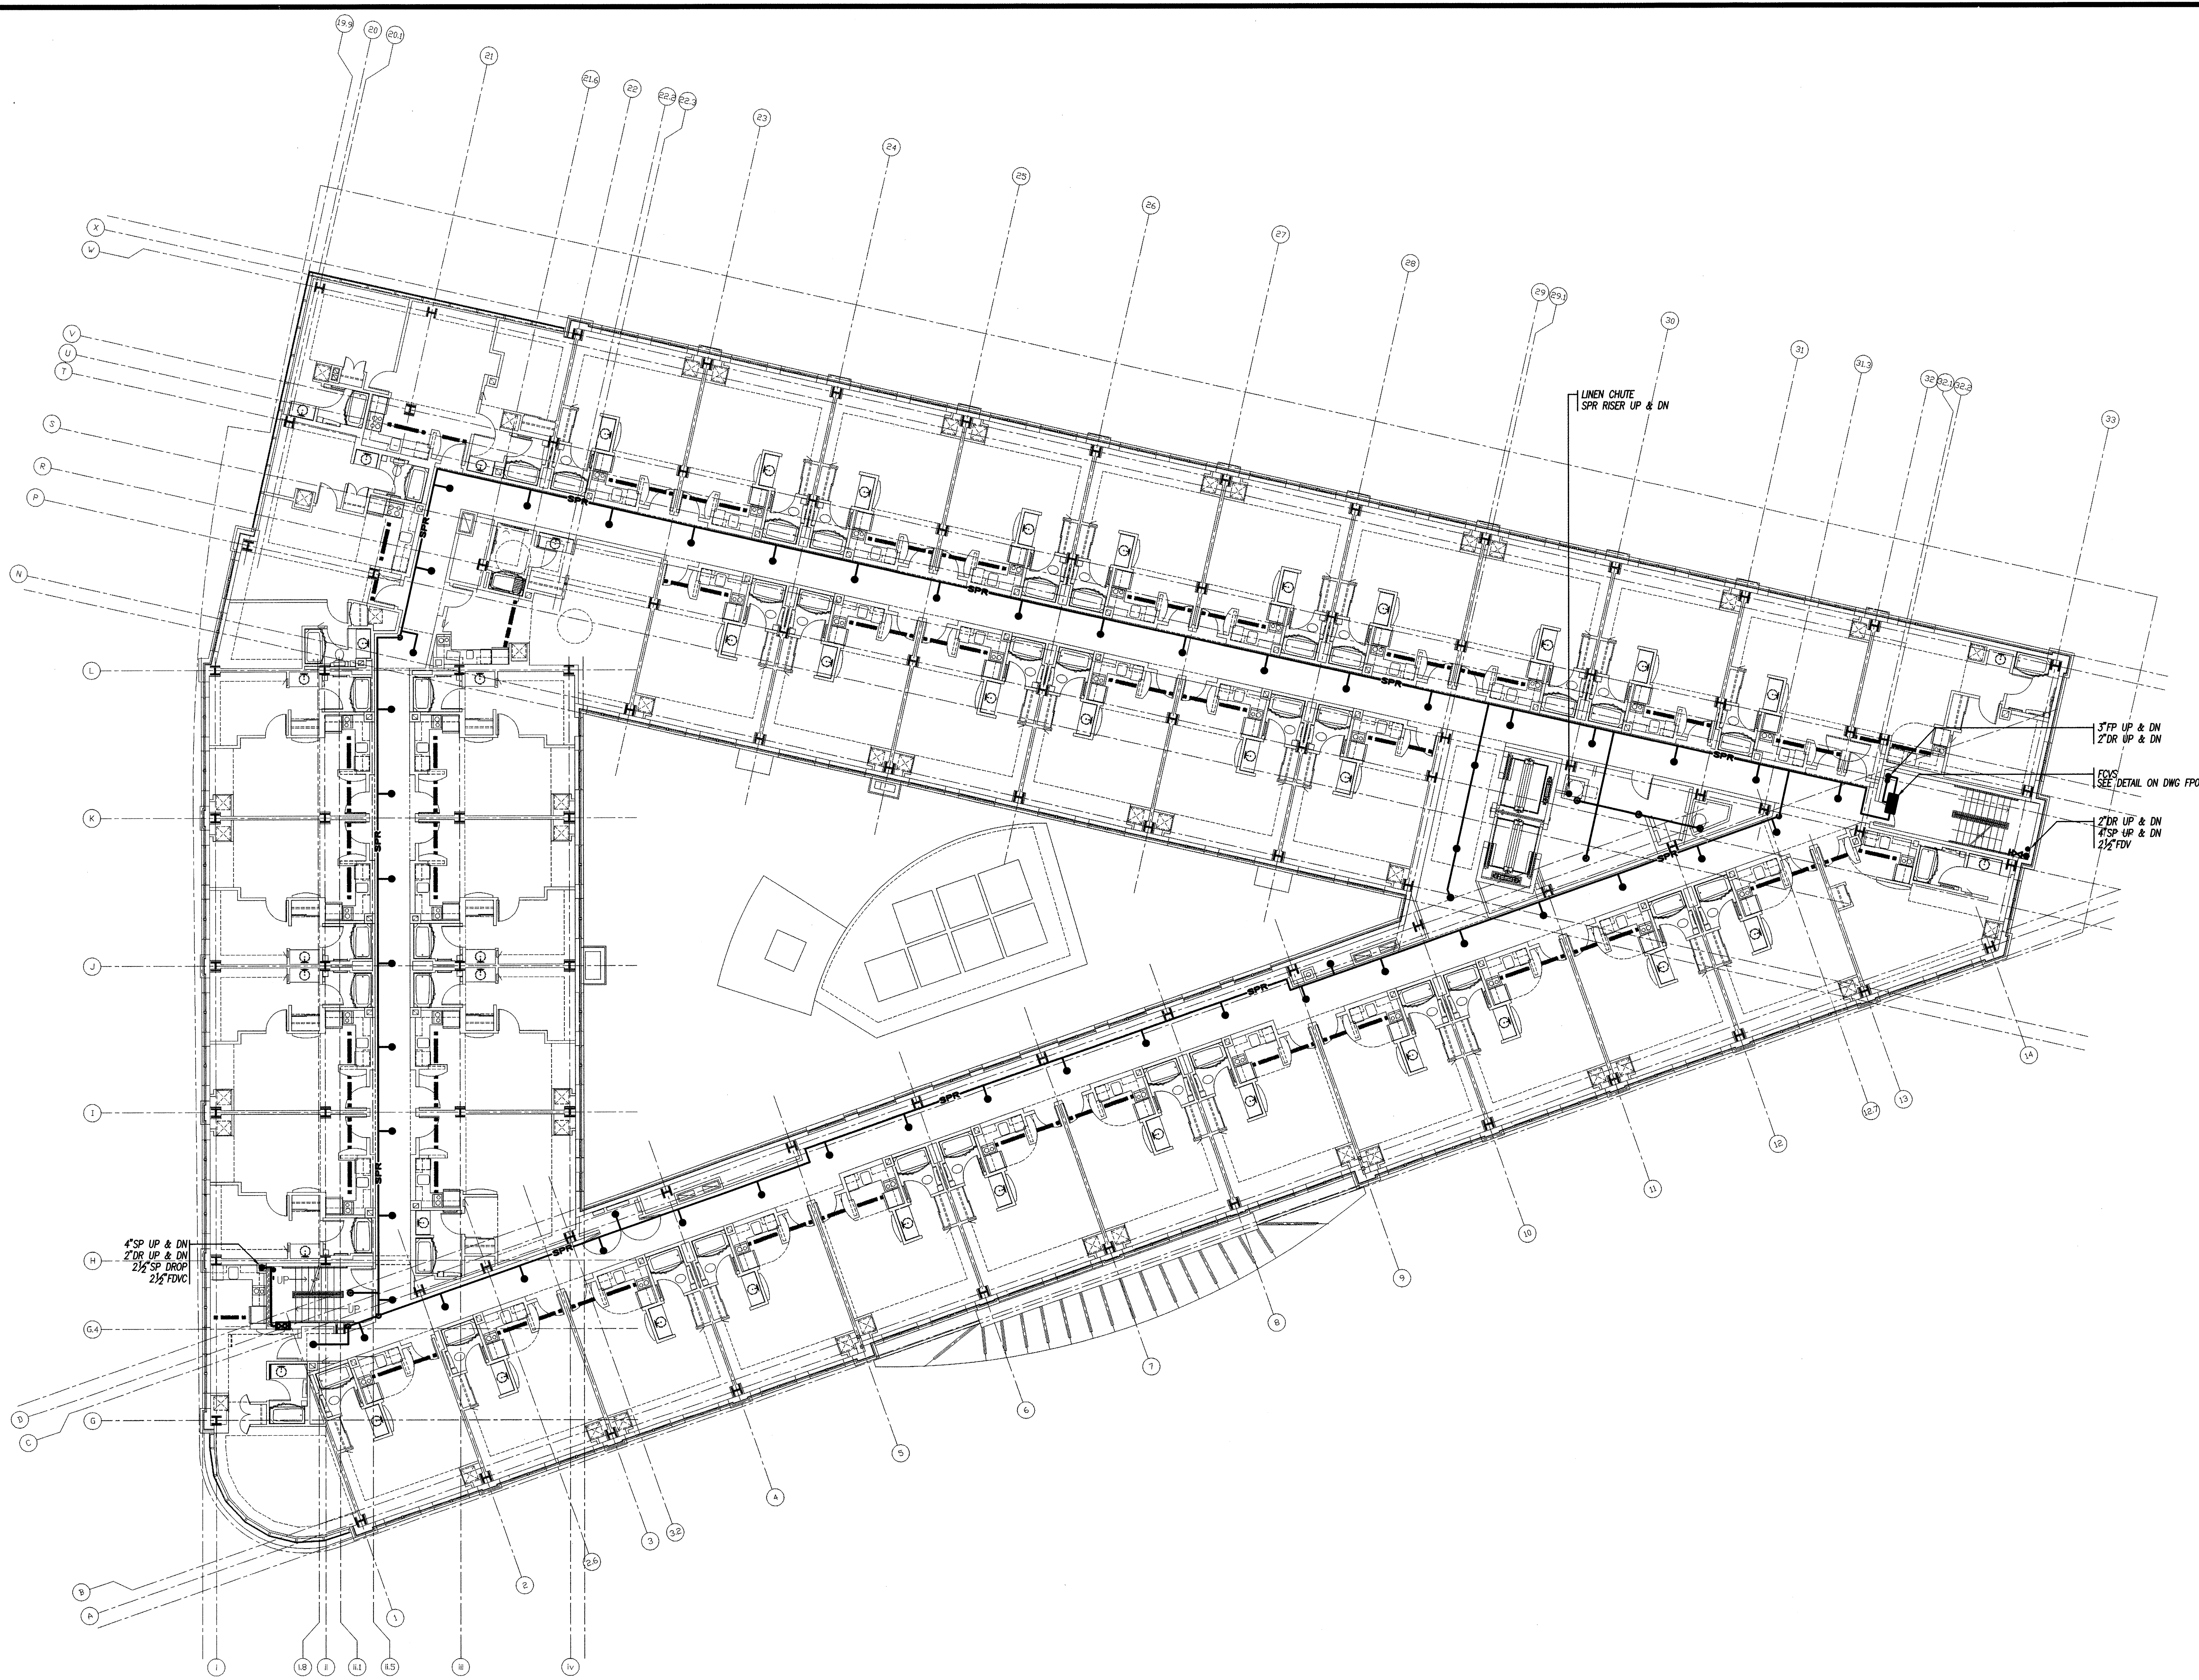

PERMIT ISSUE - 09/27/07

NO.	REVISION	DATE
SCALE: 3/32"=1' 0"	DRAWN BY: EMG	
DATE: 09/27/07	CHECKED BY: RJM	

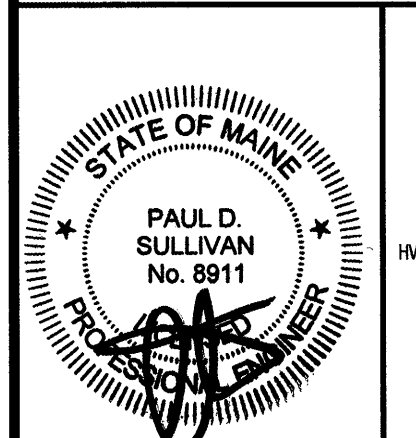

**RWS**  
 R. W. Sullivan Engineering  
 HVAC, Electrical, Plumbing, Fire Protection, Code  
 The Seaport Center  
 529 Main Street, Suite 203  
 Boston, Massachusetts 02129-1107  
 Phone: (617) 523-8222  
 Fax: (617) 523-8216  
 www.rwsnet.com  
 RWS Job No. 2273.00

PROJECT  
**RESIDENCE INN BY MARRIOTT**  
 PORTLAND, ME  
 JOB# 802

TITLE  
**FIRE PROTECTION  
 FOURTH FLOOR PLAN**

GROUP ONE  
 21 W. THIRD STREET, BOSTON, MA 02127  
 TEL: (617)268-7000 FAX: (617)268-0209

DRAWING NO.  
**FP1.4**