



**A** ONE BEDROOM TWO - ENLARGED FLOOR PLAN  
1/4" = 1'-0"

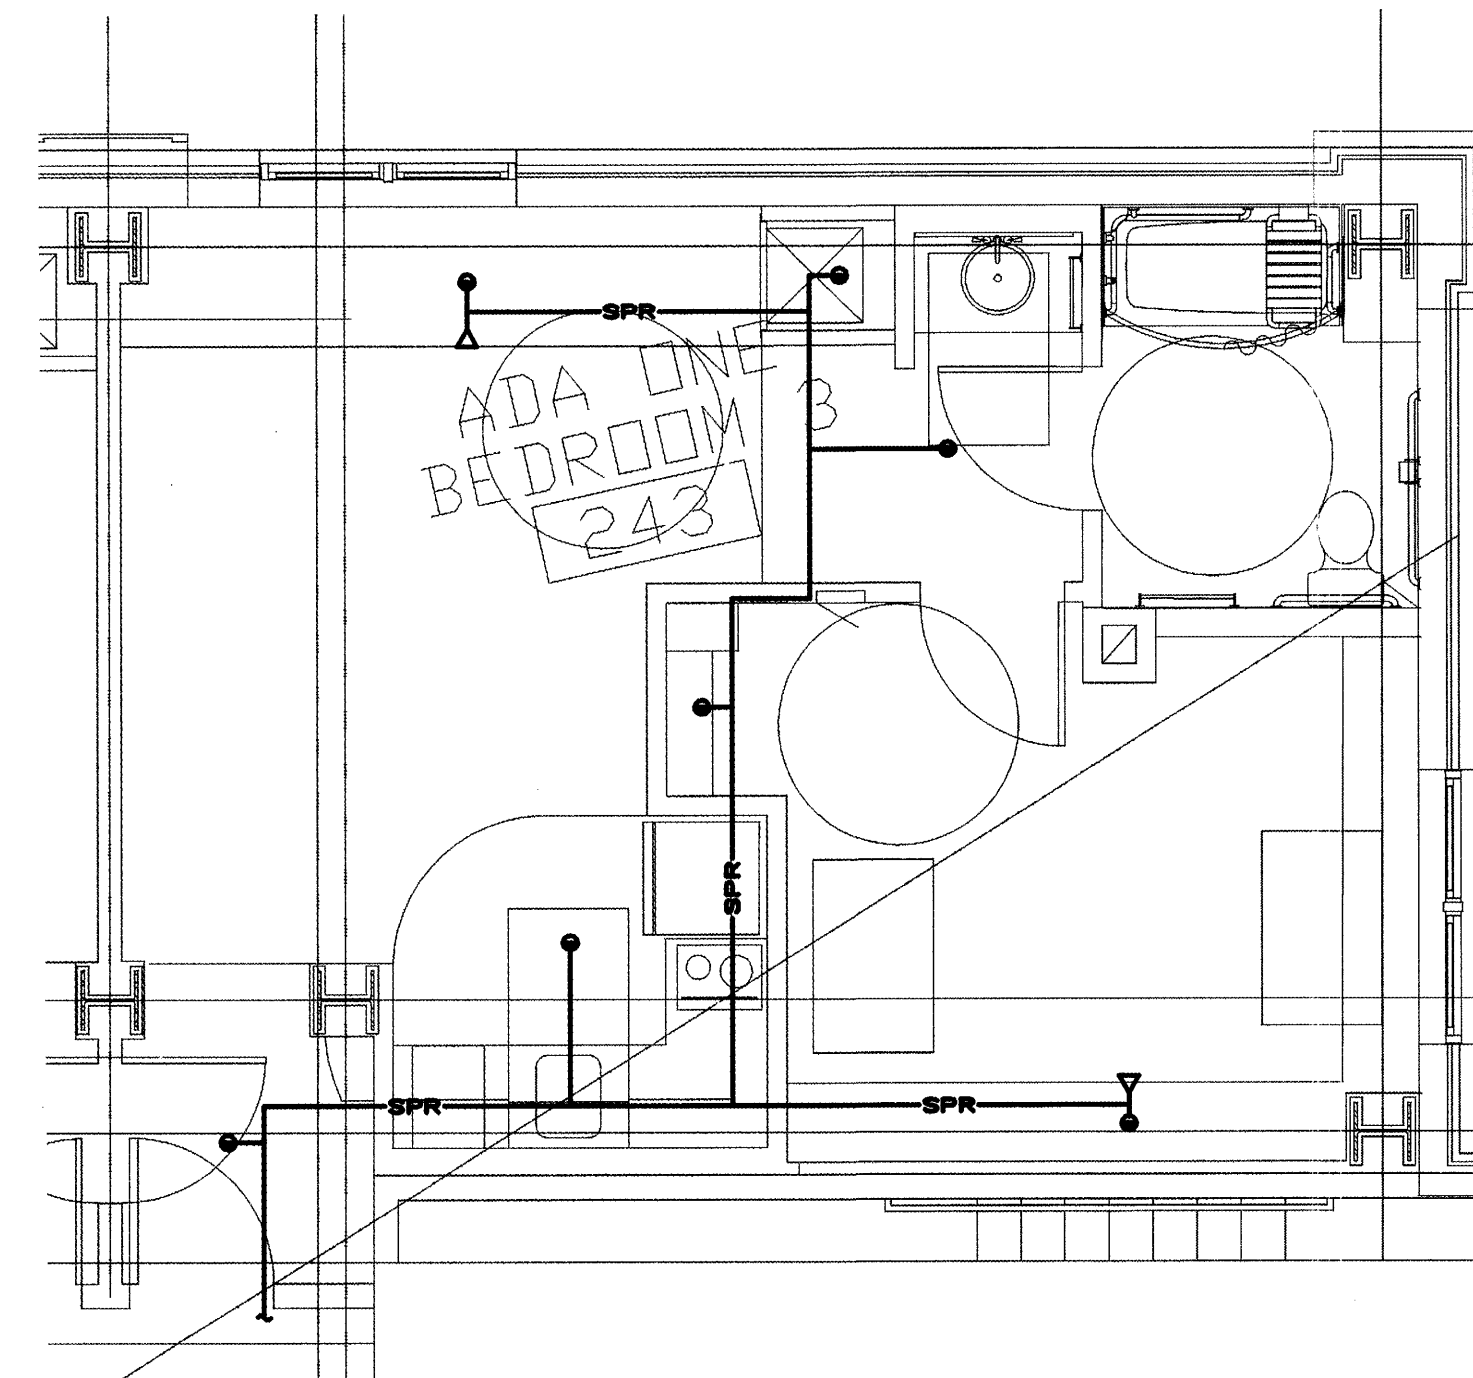


**B** ONE BEDROOM THREE ADA - ENLARGED FLOOR PLAN  
1/4" = 1'-0"

NOTE:  
REFER TO ARCHITECTURAL DRAWING FOR ALL  
SOFFITS, CEILING TYPES, HEIGHTS, ETC.  
COORDINATE SPRINKLER PIPING AND HEAD  
LAYOUT WITH THE ARCHITECT PRIOR TO BIDDING  
AND THE START OF WORK.

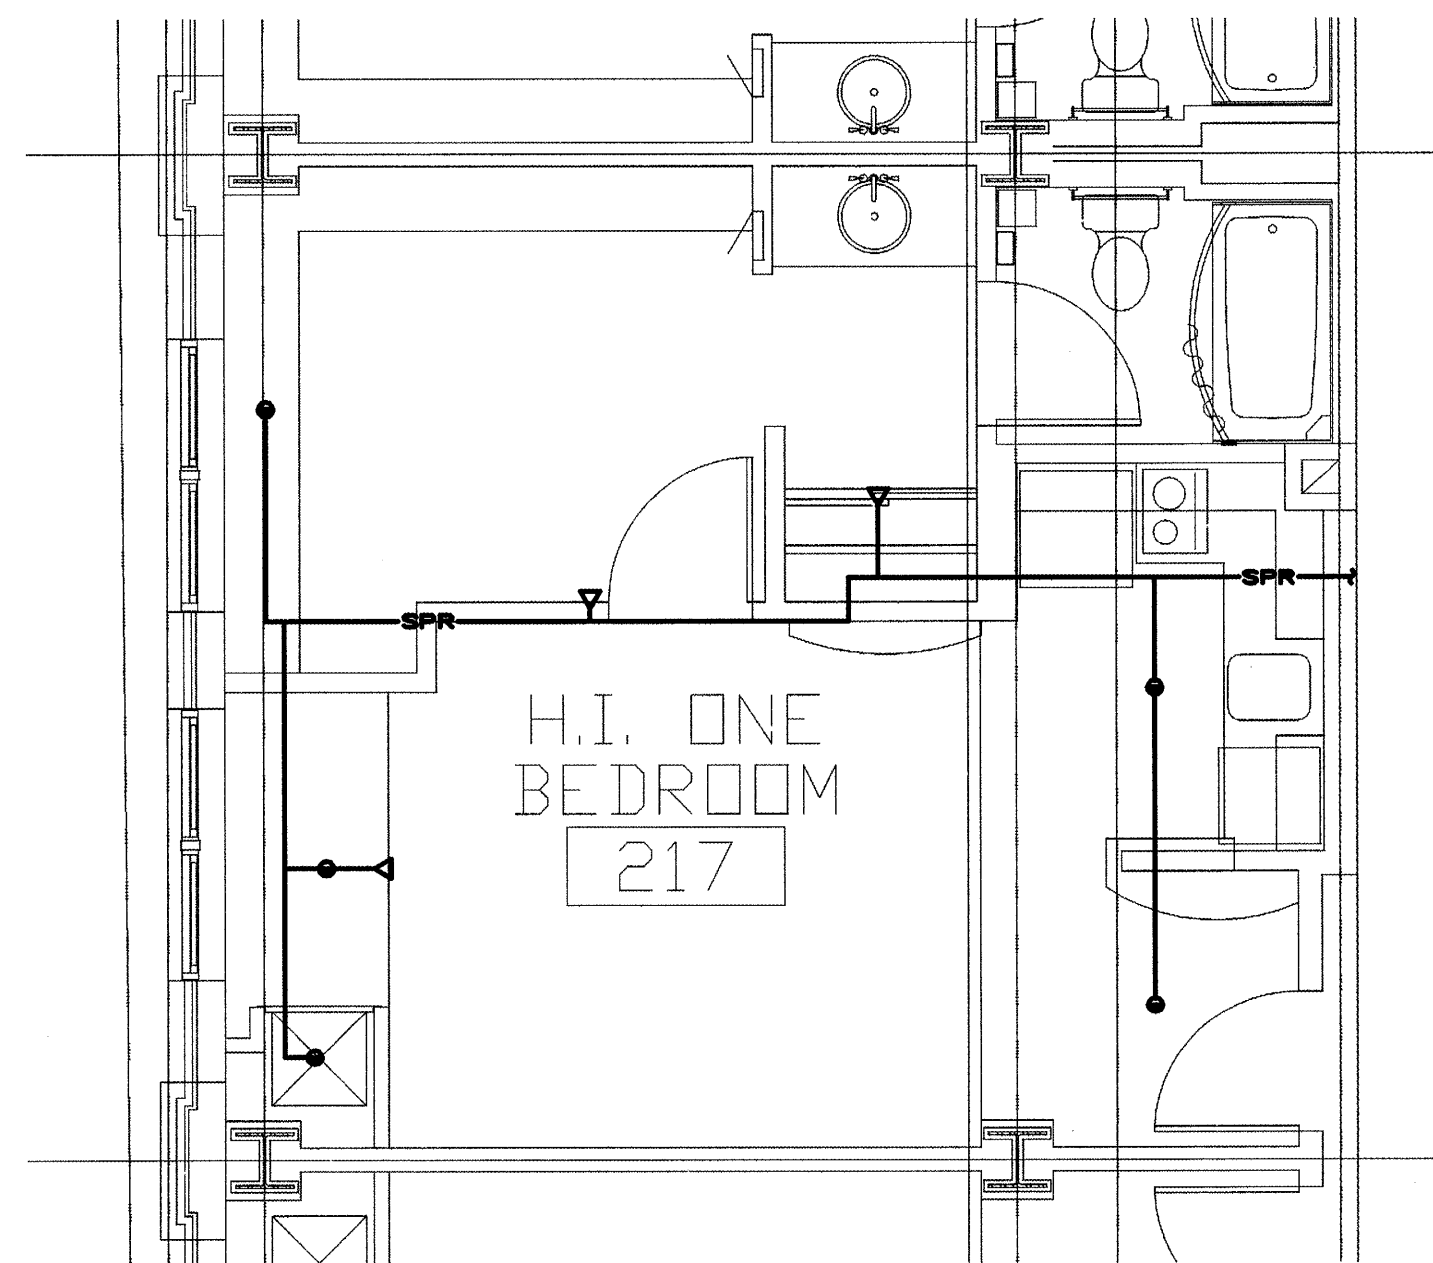

**C** ONE BEDROOM ONE - ENLARGED FLOOR PLAN  
1/4" = 1'-0"

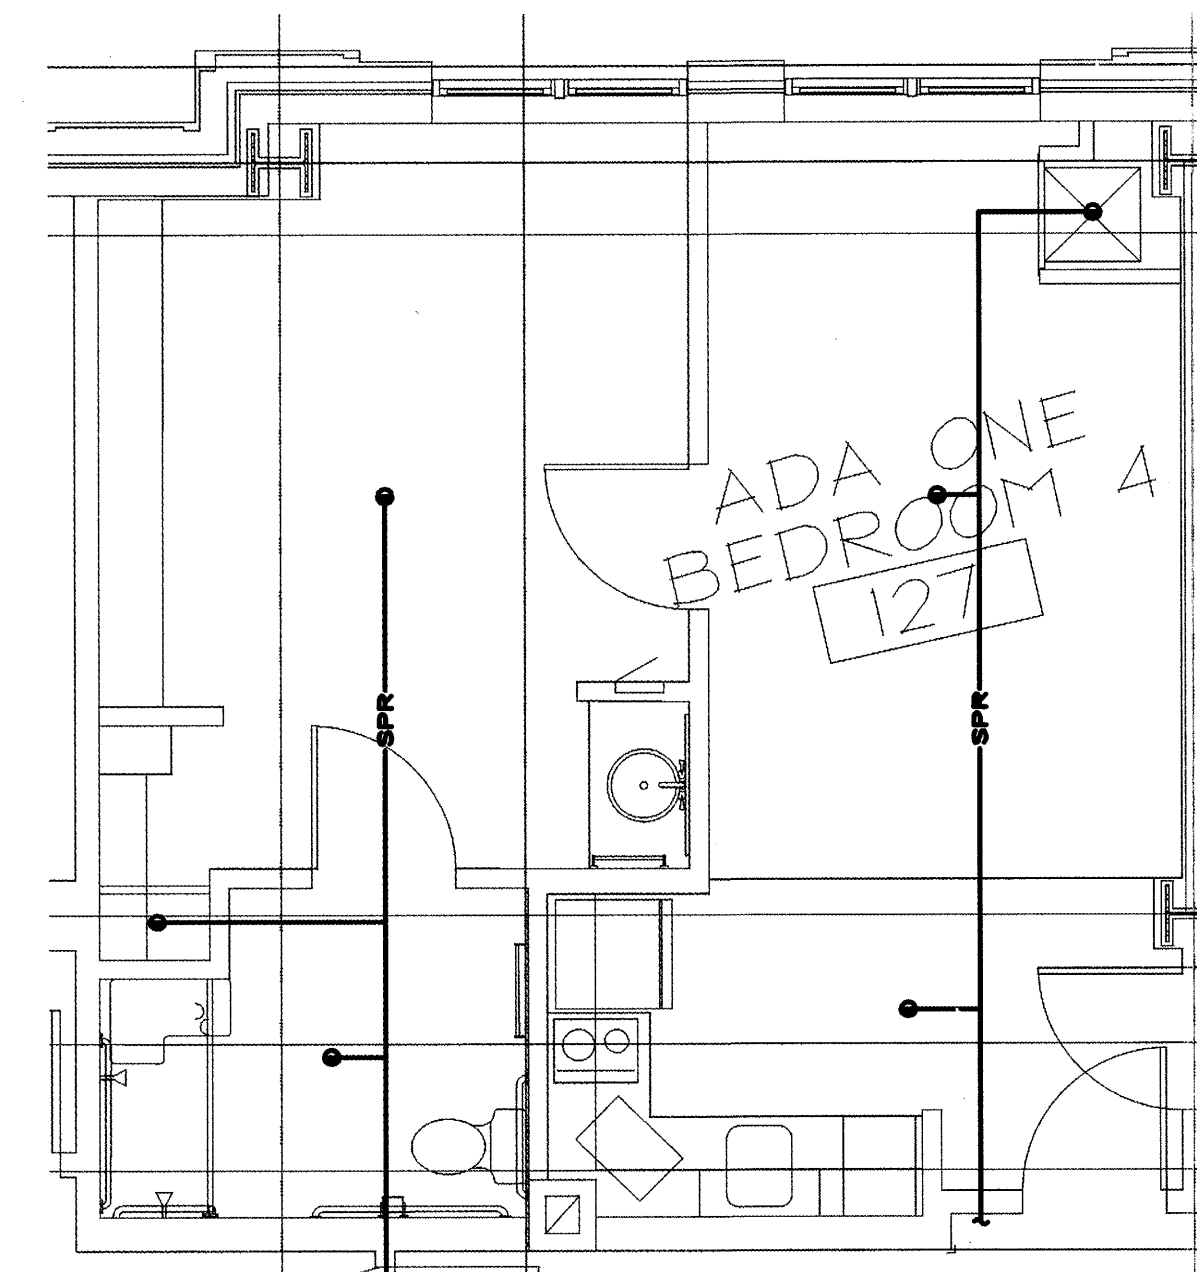

**D** ONE BEDROOM FOUR ADA - ENLARGED FLOOR PLAN  
1/4" = 1'-0"

PERMIT ISSUE - 09/27/07

NO.	REVISION	DATE
SCALE: 1/4" = 1' 0"		DRAWN BY: EMG
DATE: 09/27/07		CHECKED BY: RJM

PAUL D. SULLIVAN  
No. 8911

**R. W. Sullivan Engineering**  
Hvac, Electrical, Plumbing, Fire Protection, Code  
The Scaffold Center  
829 Main Street, Suite 203  
Boston, Massachusetts 02129-1107  
Phone: (617) 523-8227  
Fax: (617) 523-8216  
www.rwsinc.com  
RWS Job No. 2273.00

PROJECT  
**RESIDENCE INN BY MARRIOTT**  
PORTLAND, ME  
JOB# 802

TITLE  
**FIRE PROTECTION UNIT PLANS**

GROUP ONE  
21 W. THIRD STREET, BOSTON, MA 02127  
TEL: (617) 268-7000 FAX: (617) 268-0209

DRAWING NO.  
**FP1.20**