

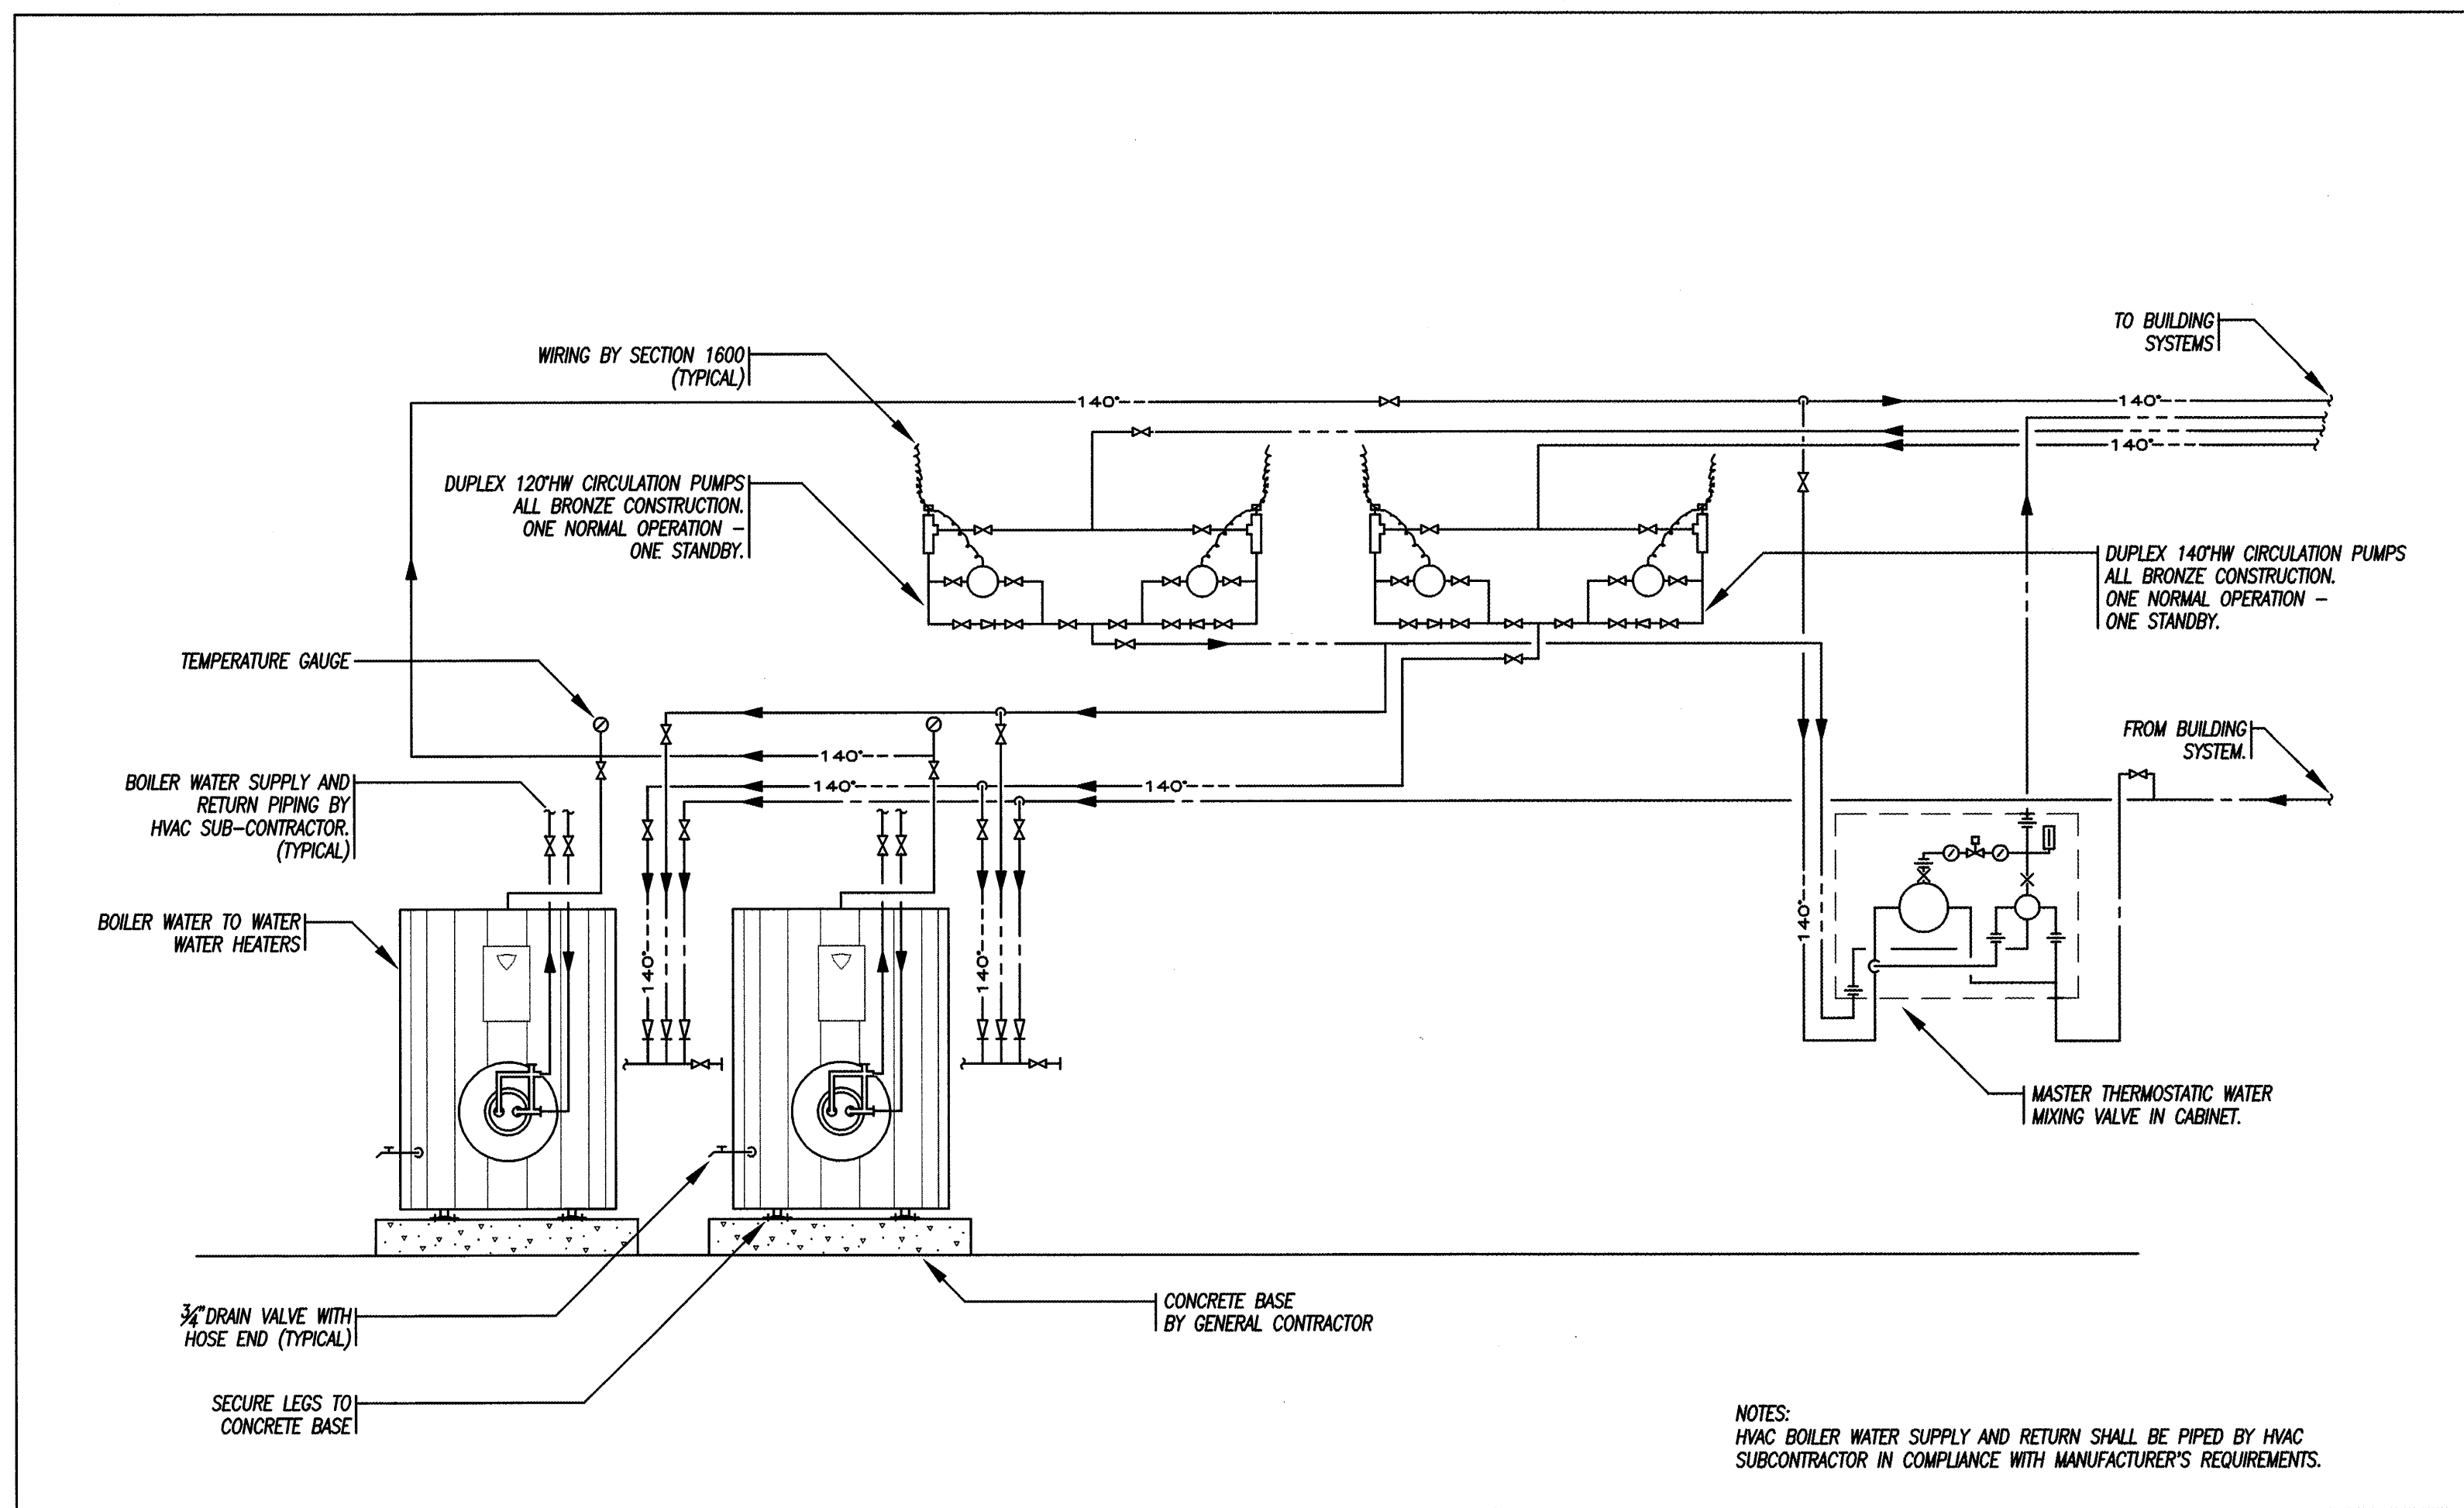



1:2007 1620105 June 28:05:31 162273:00 Drawing: 2273-01_P0.5.dwg, 9/27/2007 1:23:42 PM

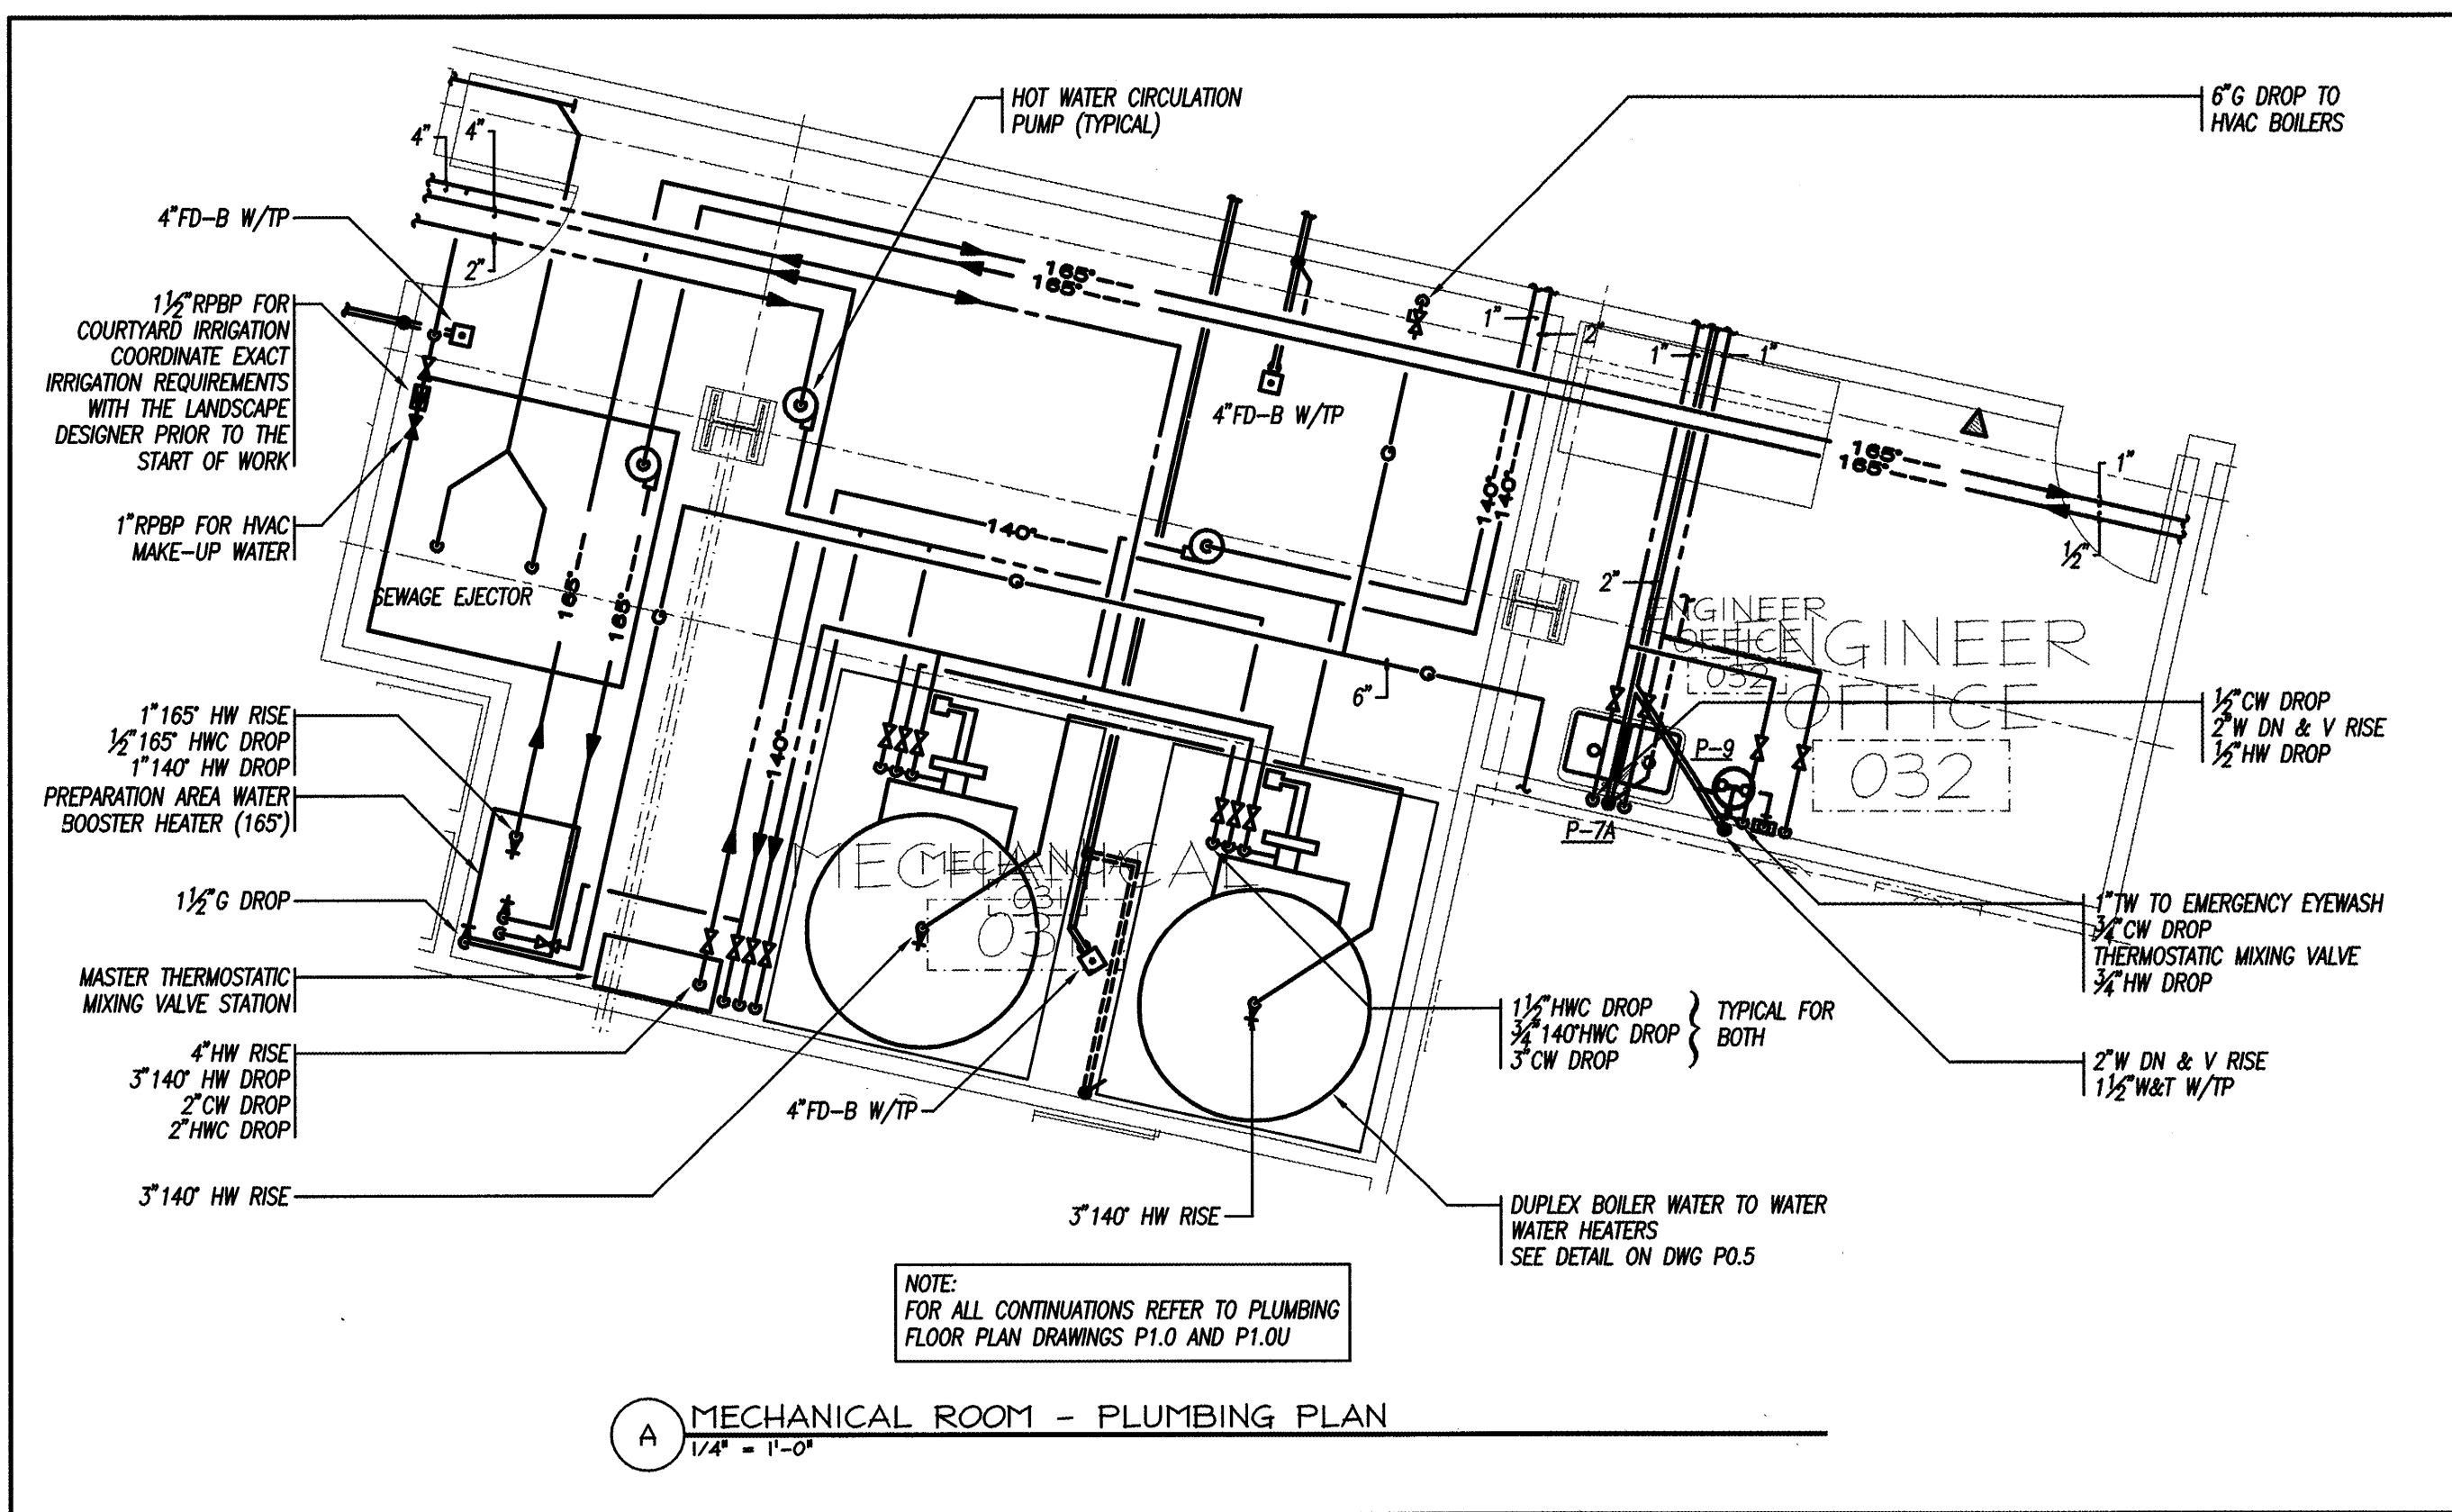

4 DUPLEX BOILER WATER TO WATER, WATER HEATERS (2 temperature system) NOT TO SCALE

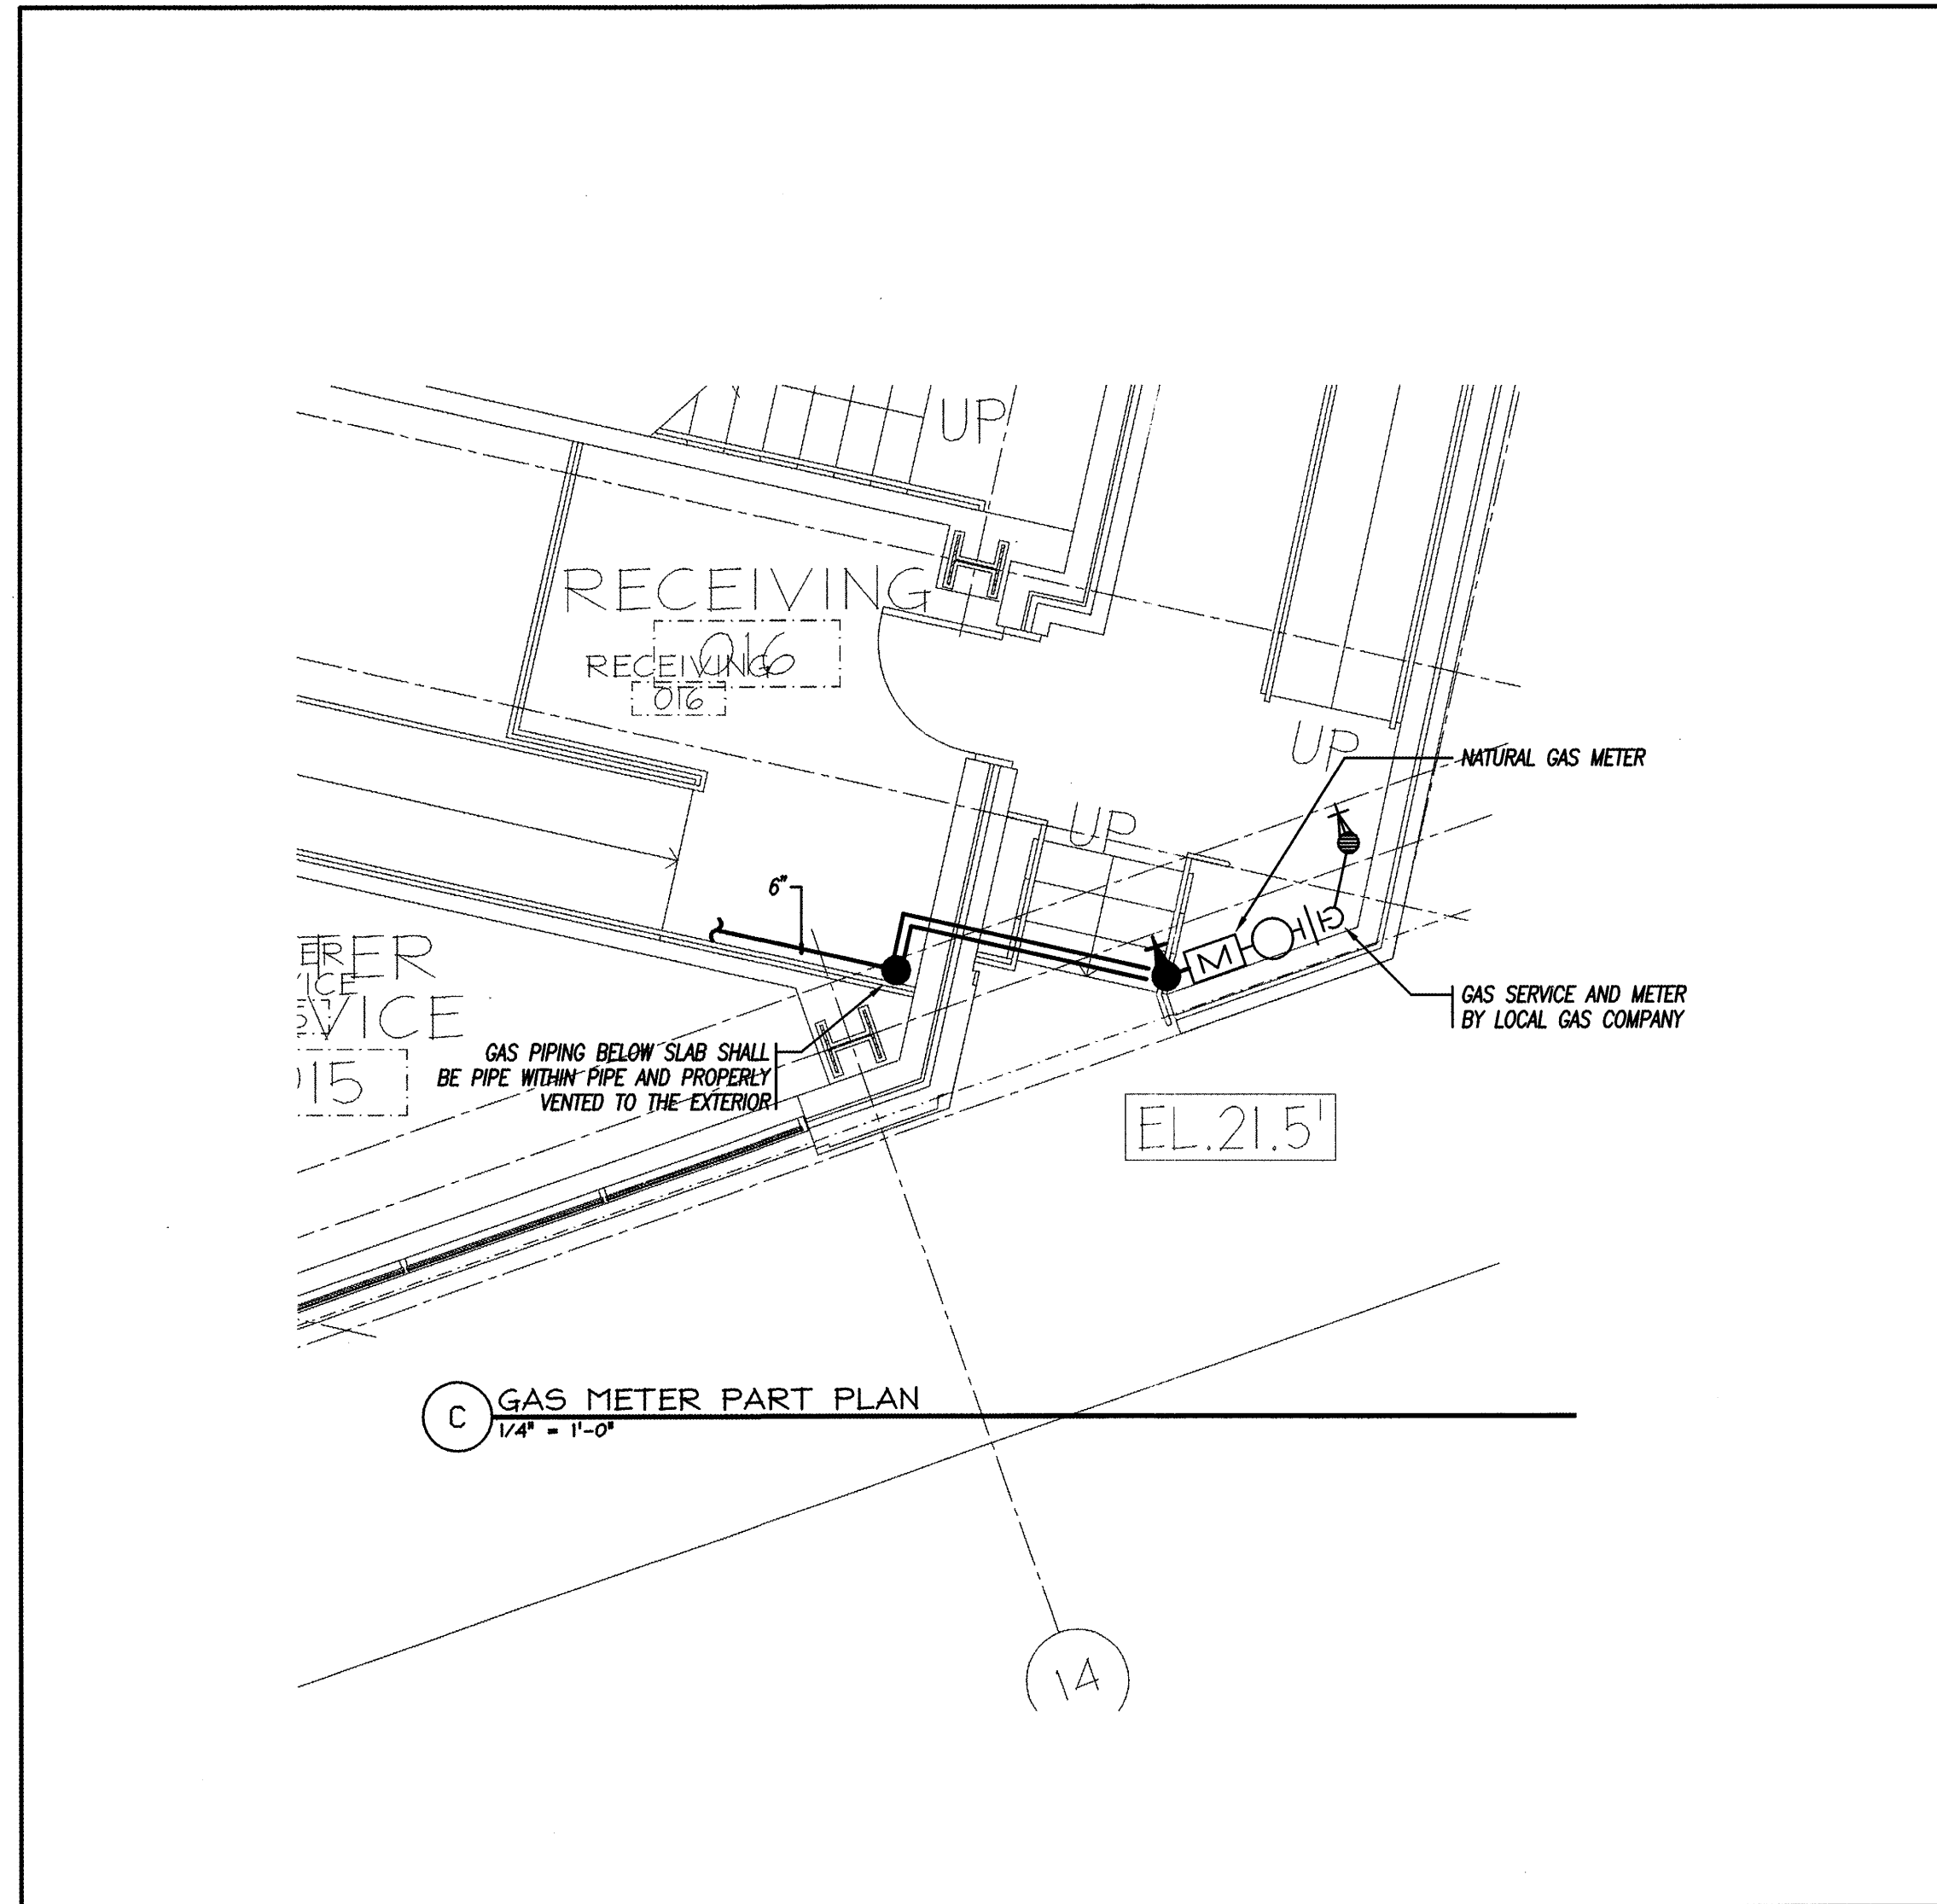

A MECHANICAL ROOM - PLUMBING PLAN 1/4\"/>

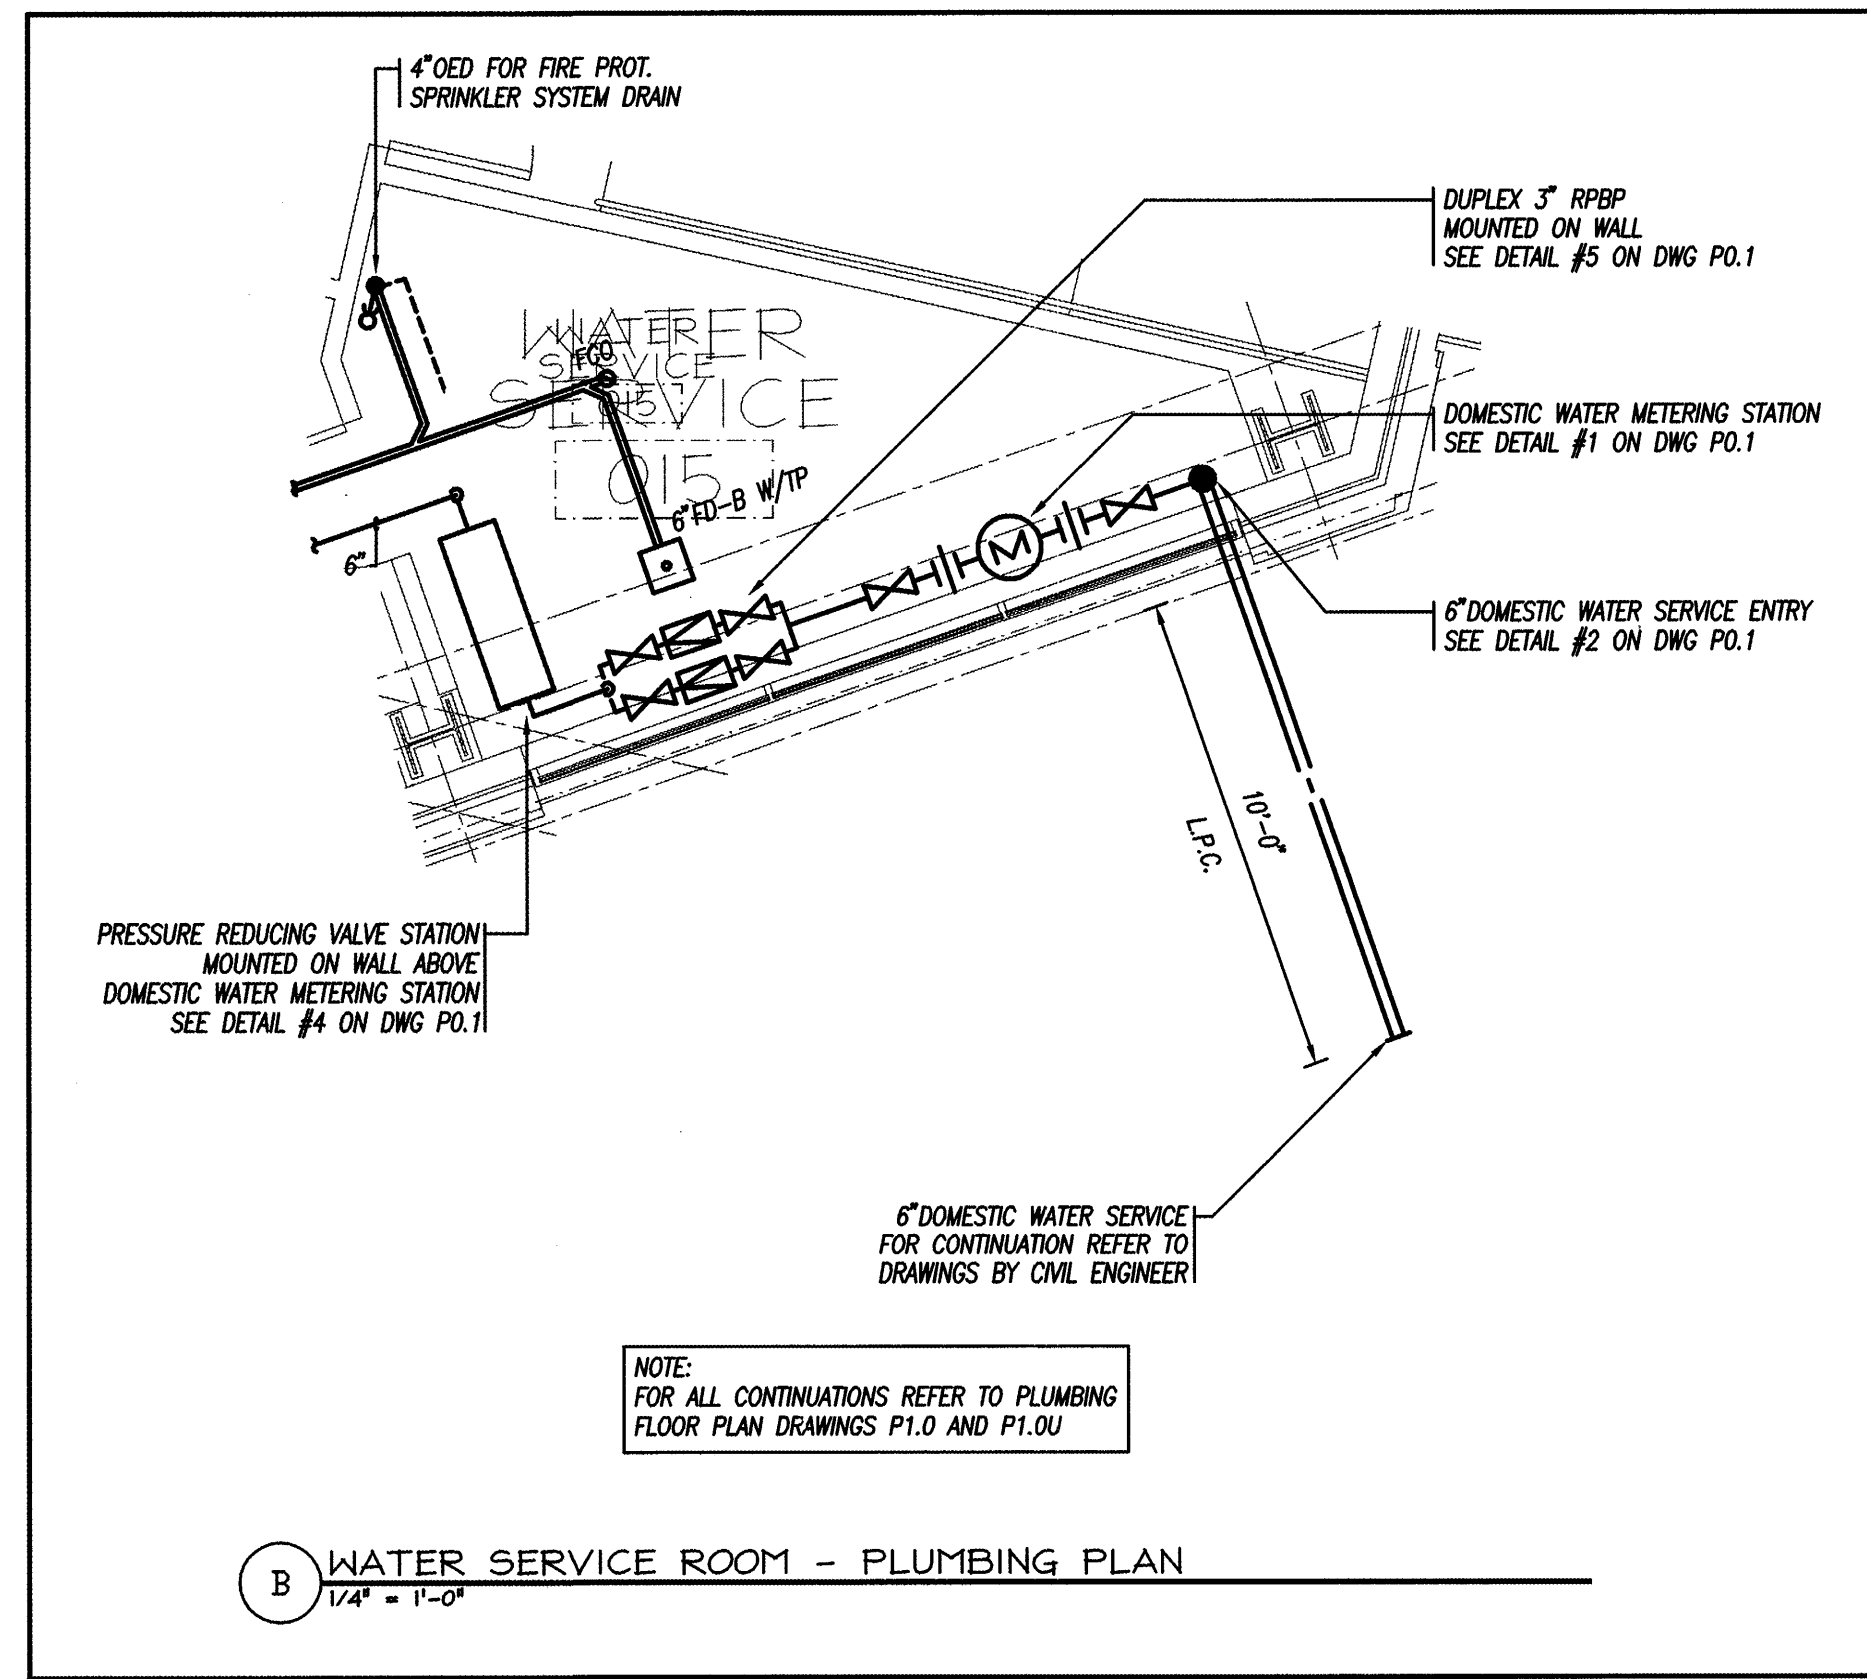

B WATER SERVICE ROOM - PLUMBING PLAN 1/4\"/>

PERMIT ISSUE - 09/27/07

NO.	REVISION	DATE
SCALE: 3/32"=1' 0"	DRAWN BY: EMG	
DATE: 09/27/07	CHECKED BY: RJM	

PAUL D. SULLIVAN
No. 8911

R. W. Sullivan Engineering
Hvac, Electrical, Plumbing, Fire Protection, Code
The Scaffold Center
629 Main Street, Suite 203
Boston, Massachusetts 02129-1107
Phone: (617) 522-8527
Fax: (617) 522-8616
www.rwsinc.com
RWS Job No. 2273.00

PROJECT
RESIDENCE INN BY MARRIOTT
PORTLAND, ME
JOB# 802

TITLE
PLUMBING PART PLAN

GROUP ONE
21 W. THIRD STREET, BOSTON, MA 02127
TEL: (617)268-7000 FAX: (617)268-0209

DRAWING NO.
P0.5