


J:\2007\1820\1820\_08 June 2006\21192273-000\dwg\p1.21.dwg, 9/27/2007 1:26:16 PM, W, PL

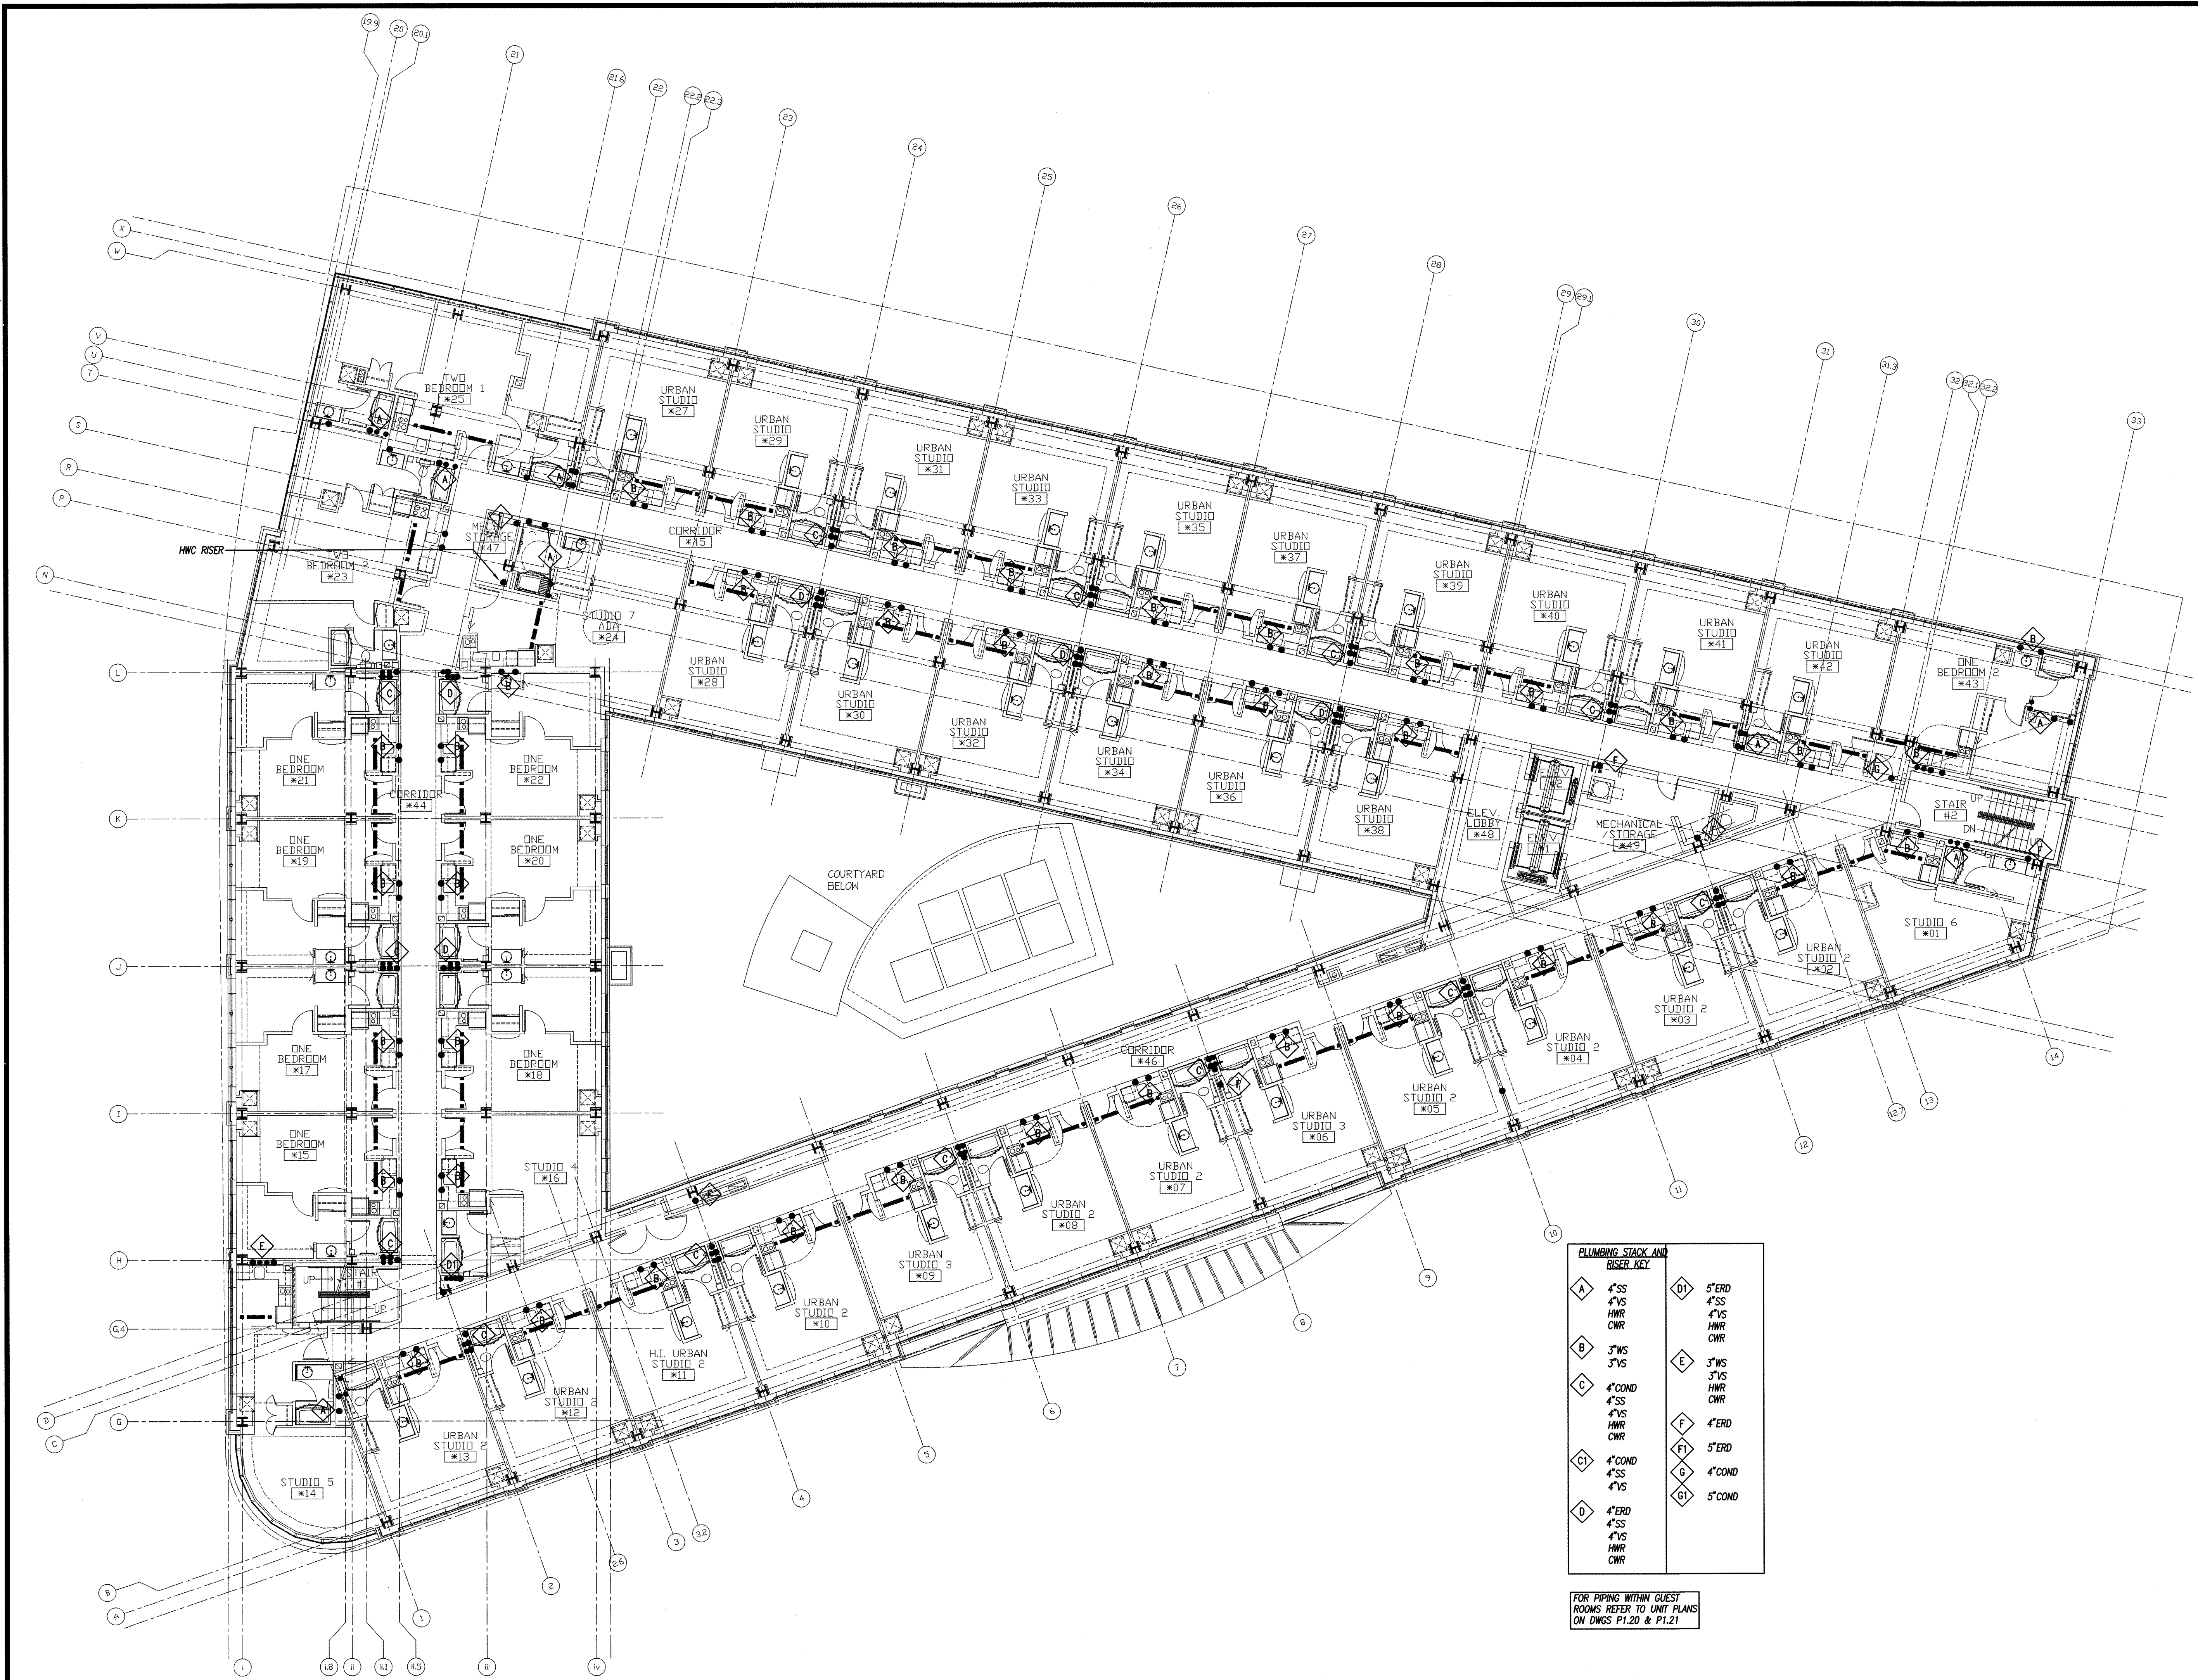



**PLUMBING STACK AND RISER KEY**

A	4"SS 4"VS HWR CWR	D	5"ERD 4"SS 4"VS HWR CWR
B	3"WS 3"VS	E	3"WS 3"VS HWR CWR
C	4"COND 4"SS 4"VS HWR CWR	F	4"ERD
C1	4"COND 4"SS 4"VS	F1	5"ERD
D	4"ERD 4"SS 4"VS HWR CWR	G	4"COND
		G1	5"COND

FOR PIPING WITHIN GUEST ROOMS REFER TO UNIT PLANS ON DWGS P1.20 & P1.21

PERMIT ISSUE - 09/27/07

NO.	REVISION	DATE
SCALE: 3/32"=1' 0"	DRAWN BY: EMG	
DATE: 09/27/07	CHECKED BY: RJM	

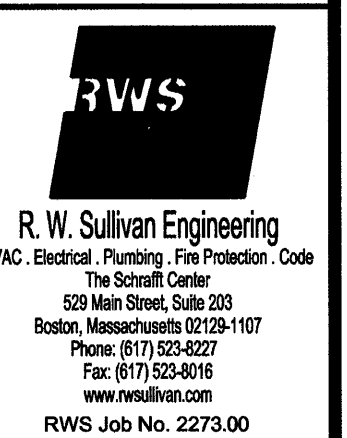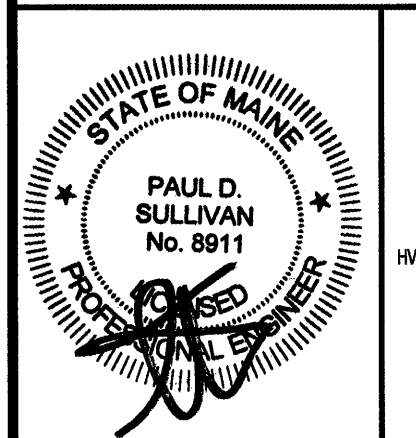

PROJECT  
**RESIDENCE INN BY MARRIOTT**  
 PORTLAND, ME  
 JOB# 802

TITLE  
**PLUMBING  
 THIRD FLOOR PLAN**

GROUP ONE  
 21 W. THIRD STREET, BOSTON, MA 02127  
 TEL: (617)268-7000 FAX: (617)268-0209

DRAWING NO.  
**P1.2**