


J:\2007\1802-08 June 2006\21192273-000\dwg\p13.rvt, P1.3.rvt, 09/27/07 1:26:28 PM, 14

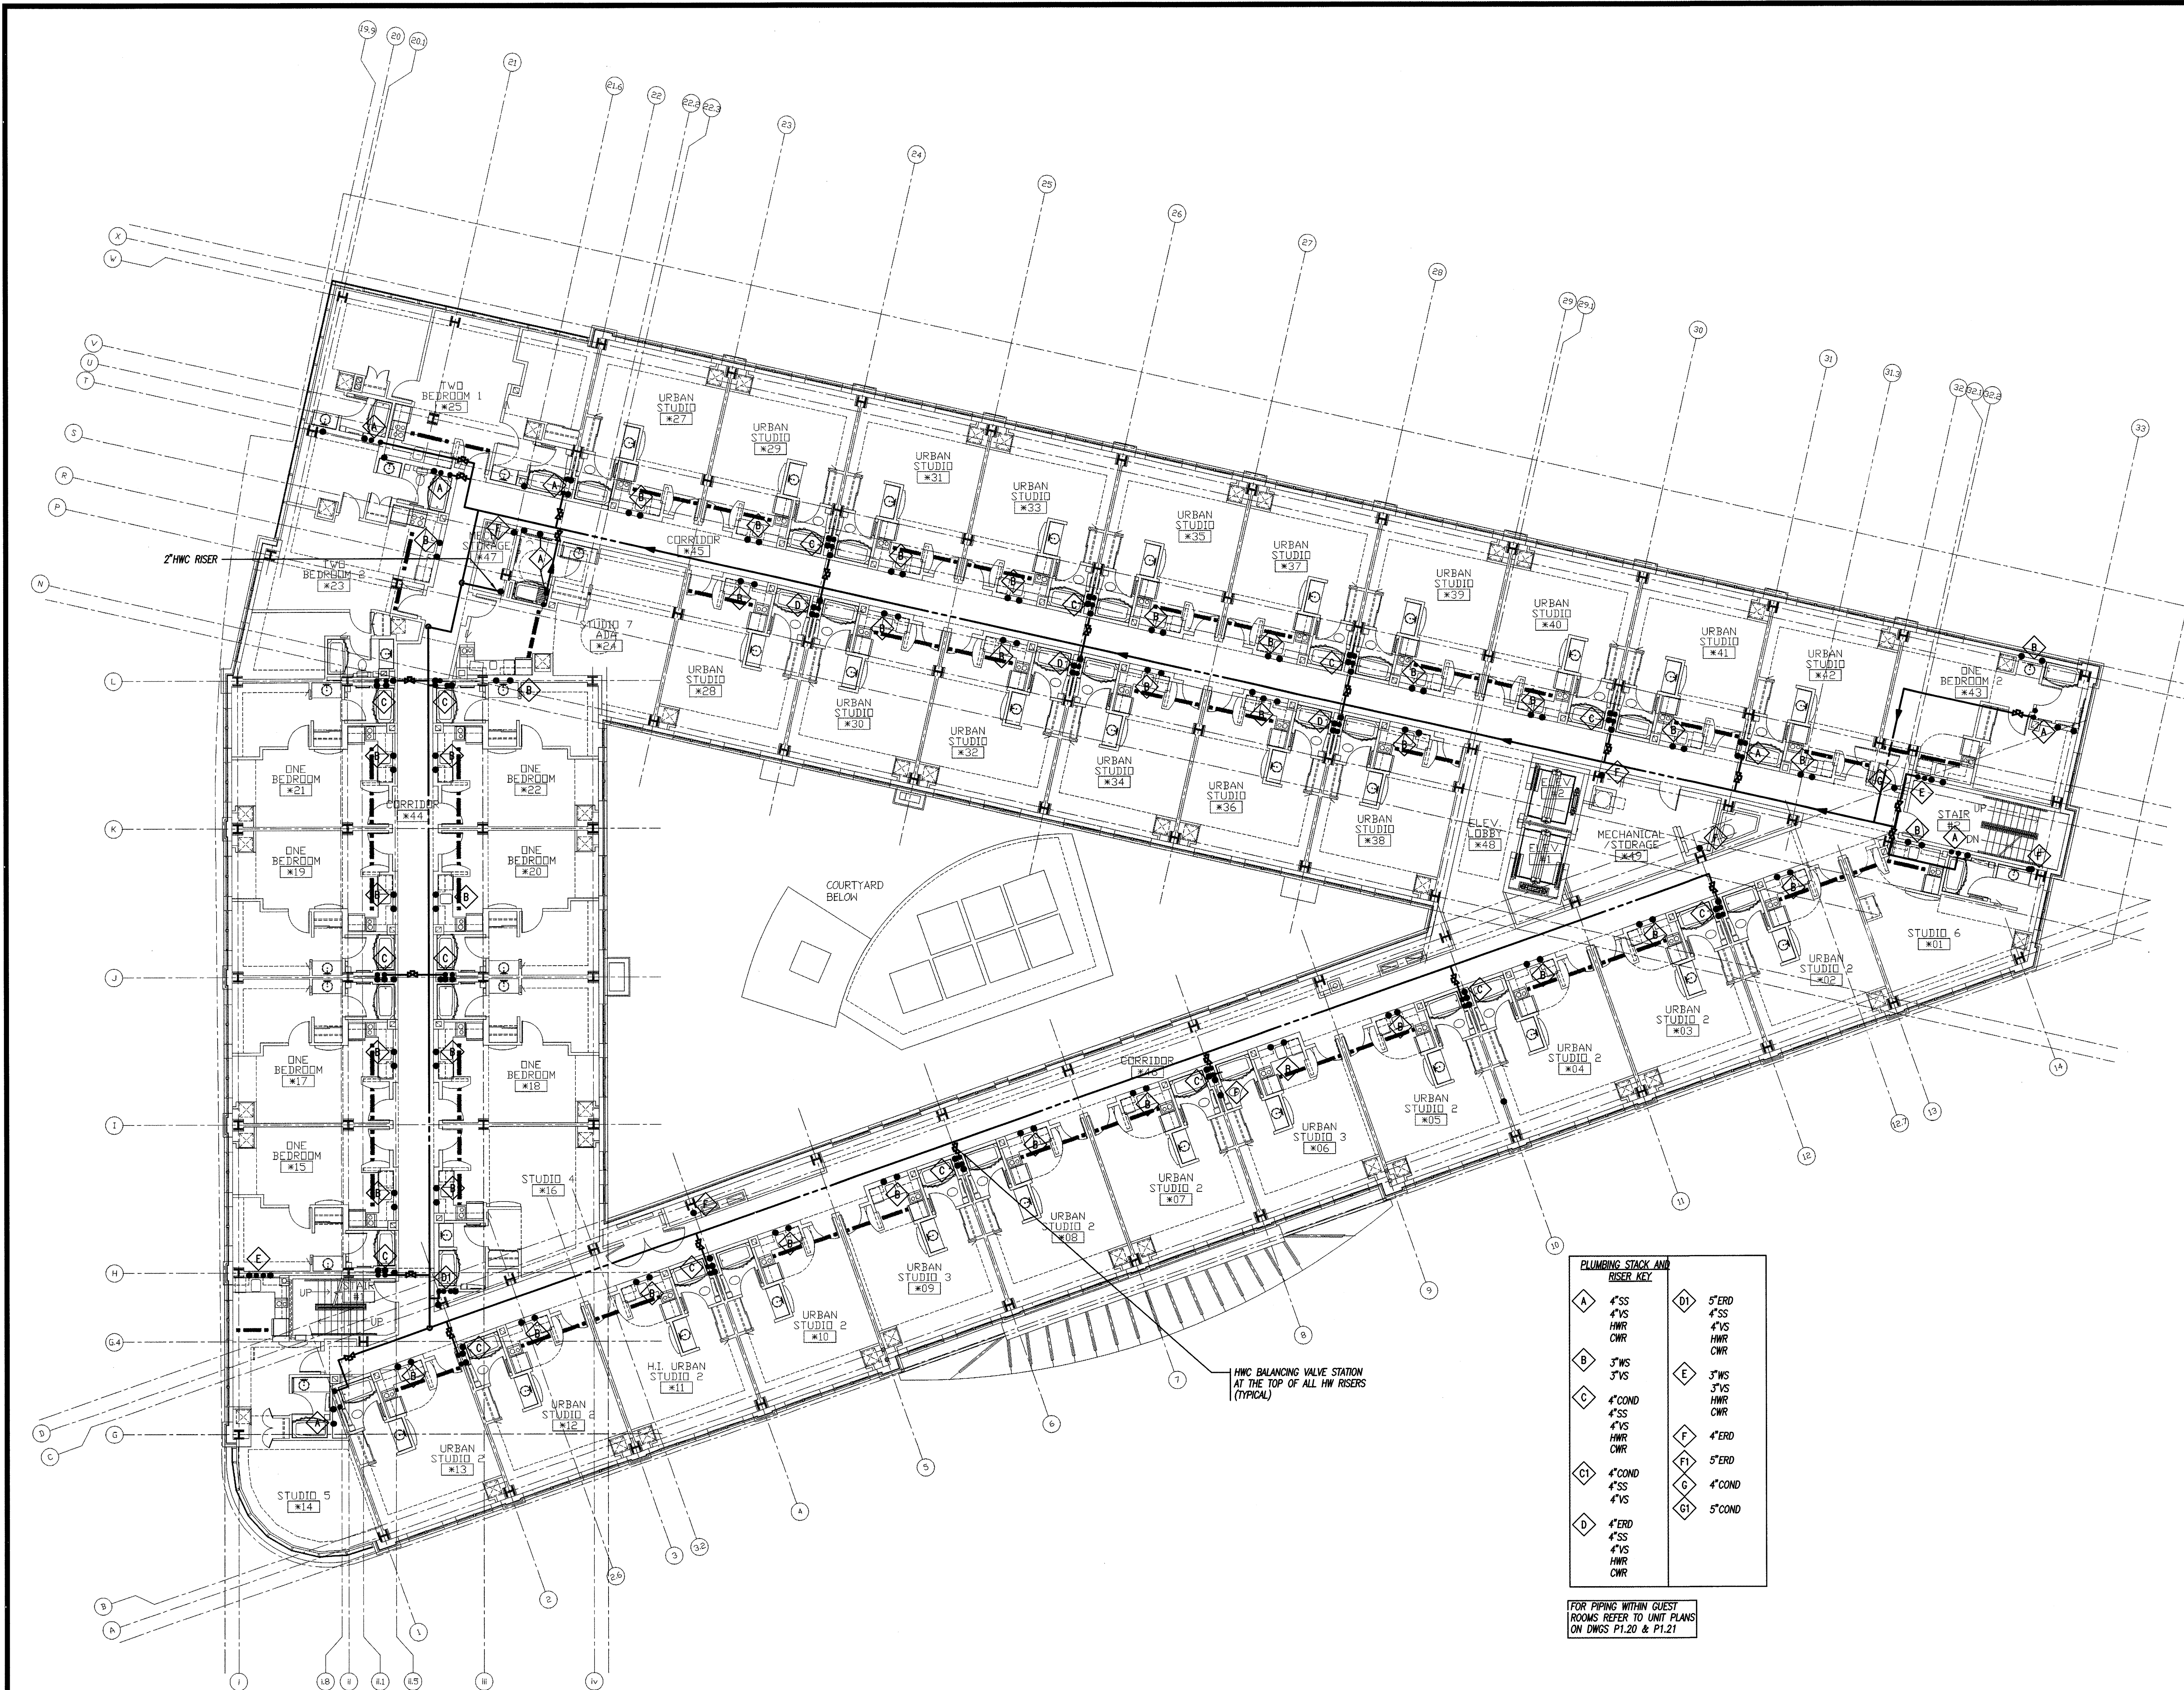

PERMIT ISSUE - 09/27/07

NO.	REVISION	DATE
SCALE: 3/32"=1' 0"	DRAWN BY: EMG	
DATE: 09/27/07	CHECKED BY: RJM	

PAUL D. SULLIVAN
8911

R. W. Sullivan Engineering
Hvac, Electrical, Plumbing, Fire Protection, Code
The Service Center
829 Main Street, Suite 203
Boston, Massachusetts 02128-1107
Phone: (617) 523-8227
Fax: (617) 523-8016
www.rwsinc.com
RWS Job No. 2273.00

PROJECT

**RESIDENCE INN
BY MARRIOTT**

PORTLAND, ME

JOB# 802

TITLE

**PLUMBING
FOURTH FLOOR PLAN**

GROUP ONE

21 W. THIRD STREET, BOSTON, MA 02127
TEL. (617)268-7000 FAX: (617)268-0209

DRAWING NO.

P1.3

PLUMBING STACK AND RISER KEY

A	4"SS	D1	5"ERD
B	4"VS	E	4"SS
C	HWR	F	4"VS
D	CWR	G	HWR
		H	CWR
		I	4"ERD
		J	5"ERD
		K	4"COND
		L	4"SS
		M	4"VS
		N	HWR
		O	CWR
		P	5"COND

HWC BALANCING VALVE STATION
AT THE TOP OF ALL HW RISERS
(TYPICAL)

FOR PIPING WITHIN GUEST
ROOMS REFER TO UNIT PLANS
ON DWGS P1.20 & P1.21