


L:\2007\1602-08 June 2006 21:52:27 000-dwg\1602-08\_P1.4.dwg, 8/7/2007 1:28:38 PM, 14

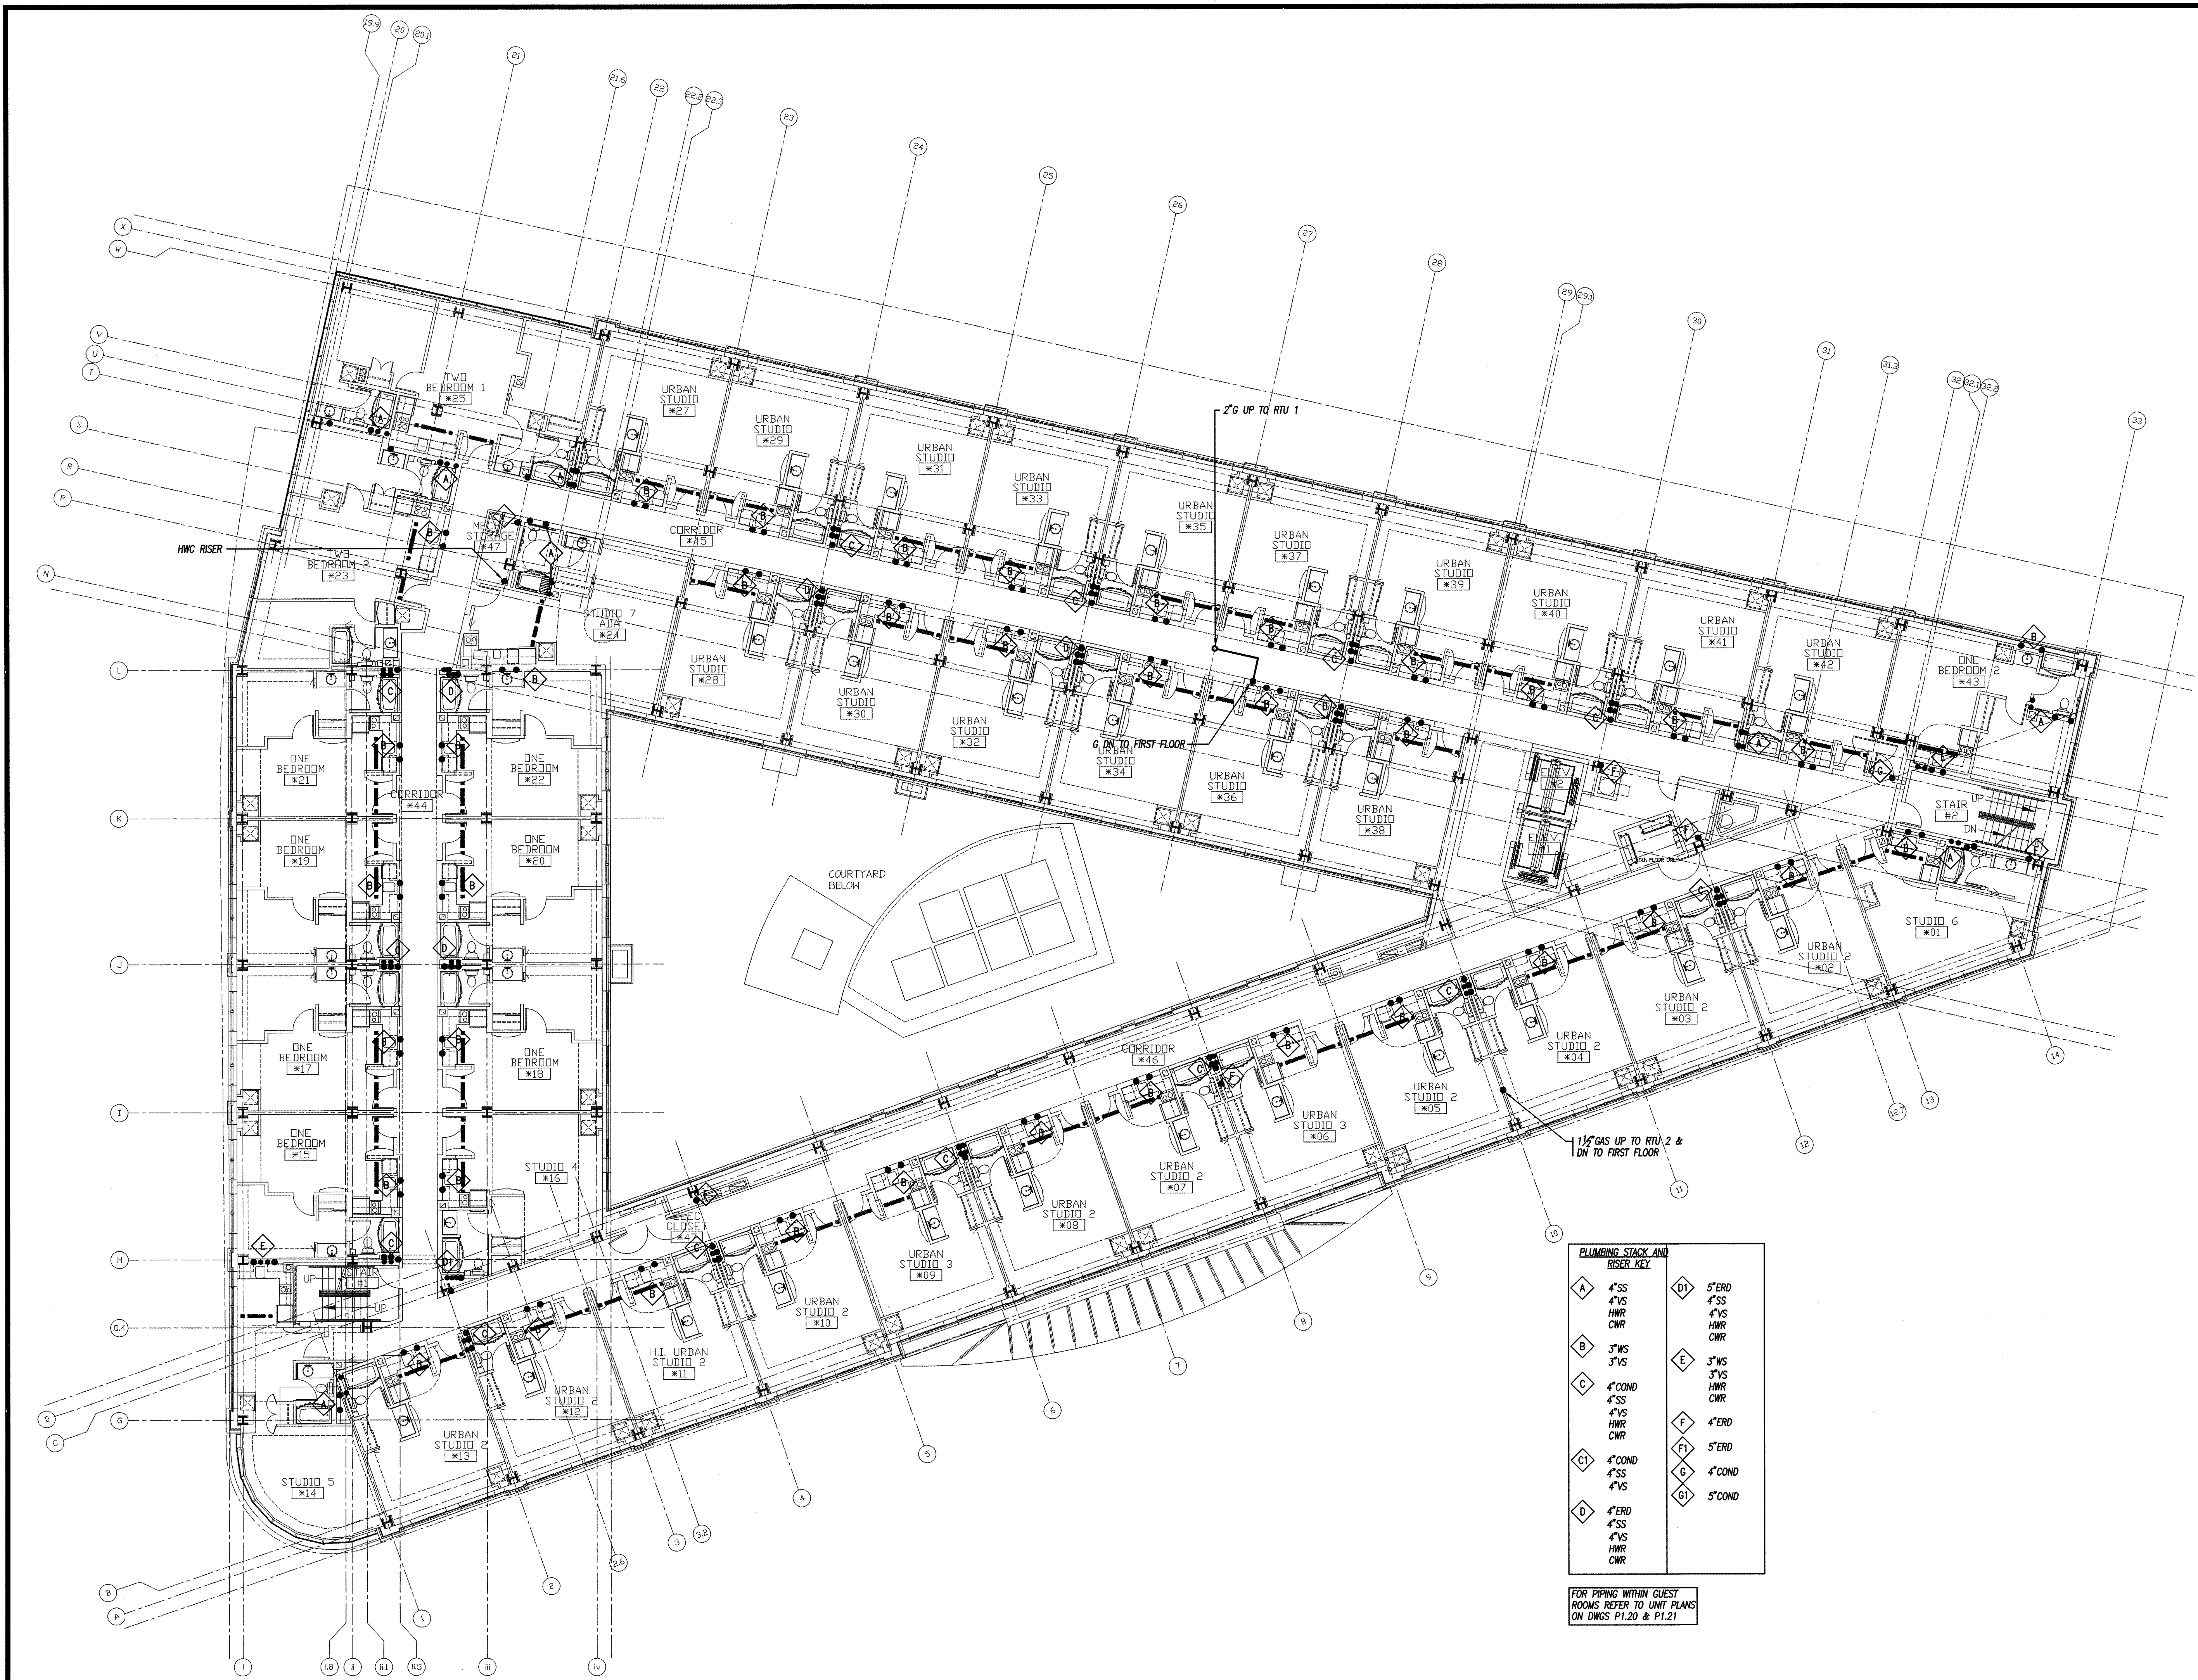

**PERMIT ISSUE - 09/27/07**

NO.	REVISION	DATE
SCALE: 3/32"=1' 0"	DRAWN BY: EMG	
DATE: 09/27/07	CHECKED BY: RJM	

STATE OF MAINE  
PAUL D. SULLIVAN  
No. 8911

**RWS**  
R. W. Sullivan Engineering  
Hvac, Electrical, Plumbing, Fire Protection, Code  
The Strickland Center  
528 Main Street, Suite 203  
Boston, Massachusetts 02129-1107  
Phone: (617) 524-8227  
Fax: (617) 524-8216  
www.rwsusa.com  
RWS Job No. 2273.00

PROJECT  
**RESIDENCE INN BY MARRIOTT**  
PORTLAND, ME  
JOB# 802

TITLE  
**PLUMBING FIFTH FLOOR PLAN**

GROUP ONE  
21 W. THIRD STREET, BOSTON, MA 02127  
TEL: (617)268-7000 FAX: (617)268-0209

DRAWING NO.  
**P1.4**

**PLUMBING STACK AND RISER KEY**

A	4"SS	D	5"ERD
B	4"VS	E	4"SS
C	HWR	F	4"VS
D	CWR	G	HWR
E	3"WS	H	CWR
F	3"VS	I	3"WS
G	4"COND	J	3"VS
H	4"SS	K	HWR
I	4"VS	L	CWR
J	HWR	M	4"ERD
K	CWR	N	5"ERD
L	4"COND	O	4"COND
M	4"SS	P	4"COND
N	4"VS	Q	5"COND
O	HWR		
P	CWR		
Q	4"ERD		
	4"SS		
	4"VS		
	HWR		
	CWR		

FOR PIPING WITHIN GUEST ROOMS REFER TO UNIT PLANS ON DWGS P1.20 & P1.21