




1/23/07 10:20:06 AM 2265.23192273-0000.dwg 2273-00_1-20.dwg 9/27/07 1:28:03 PM 14

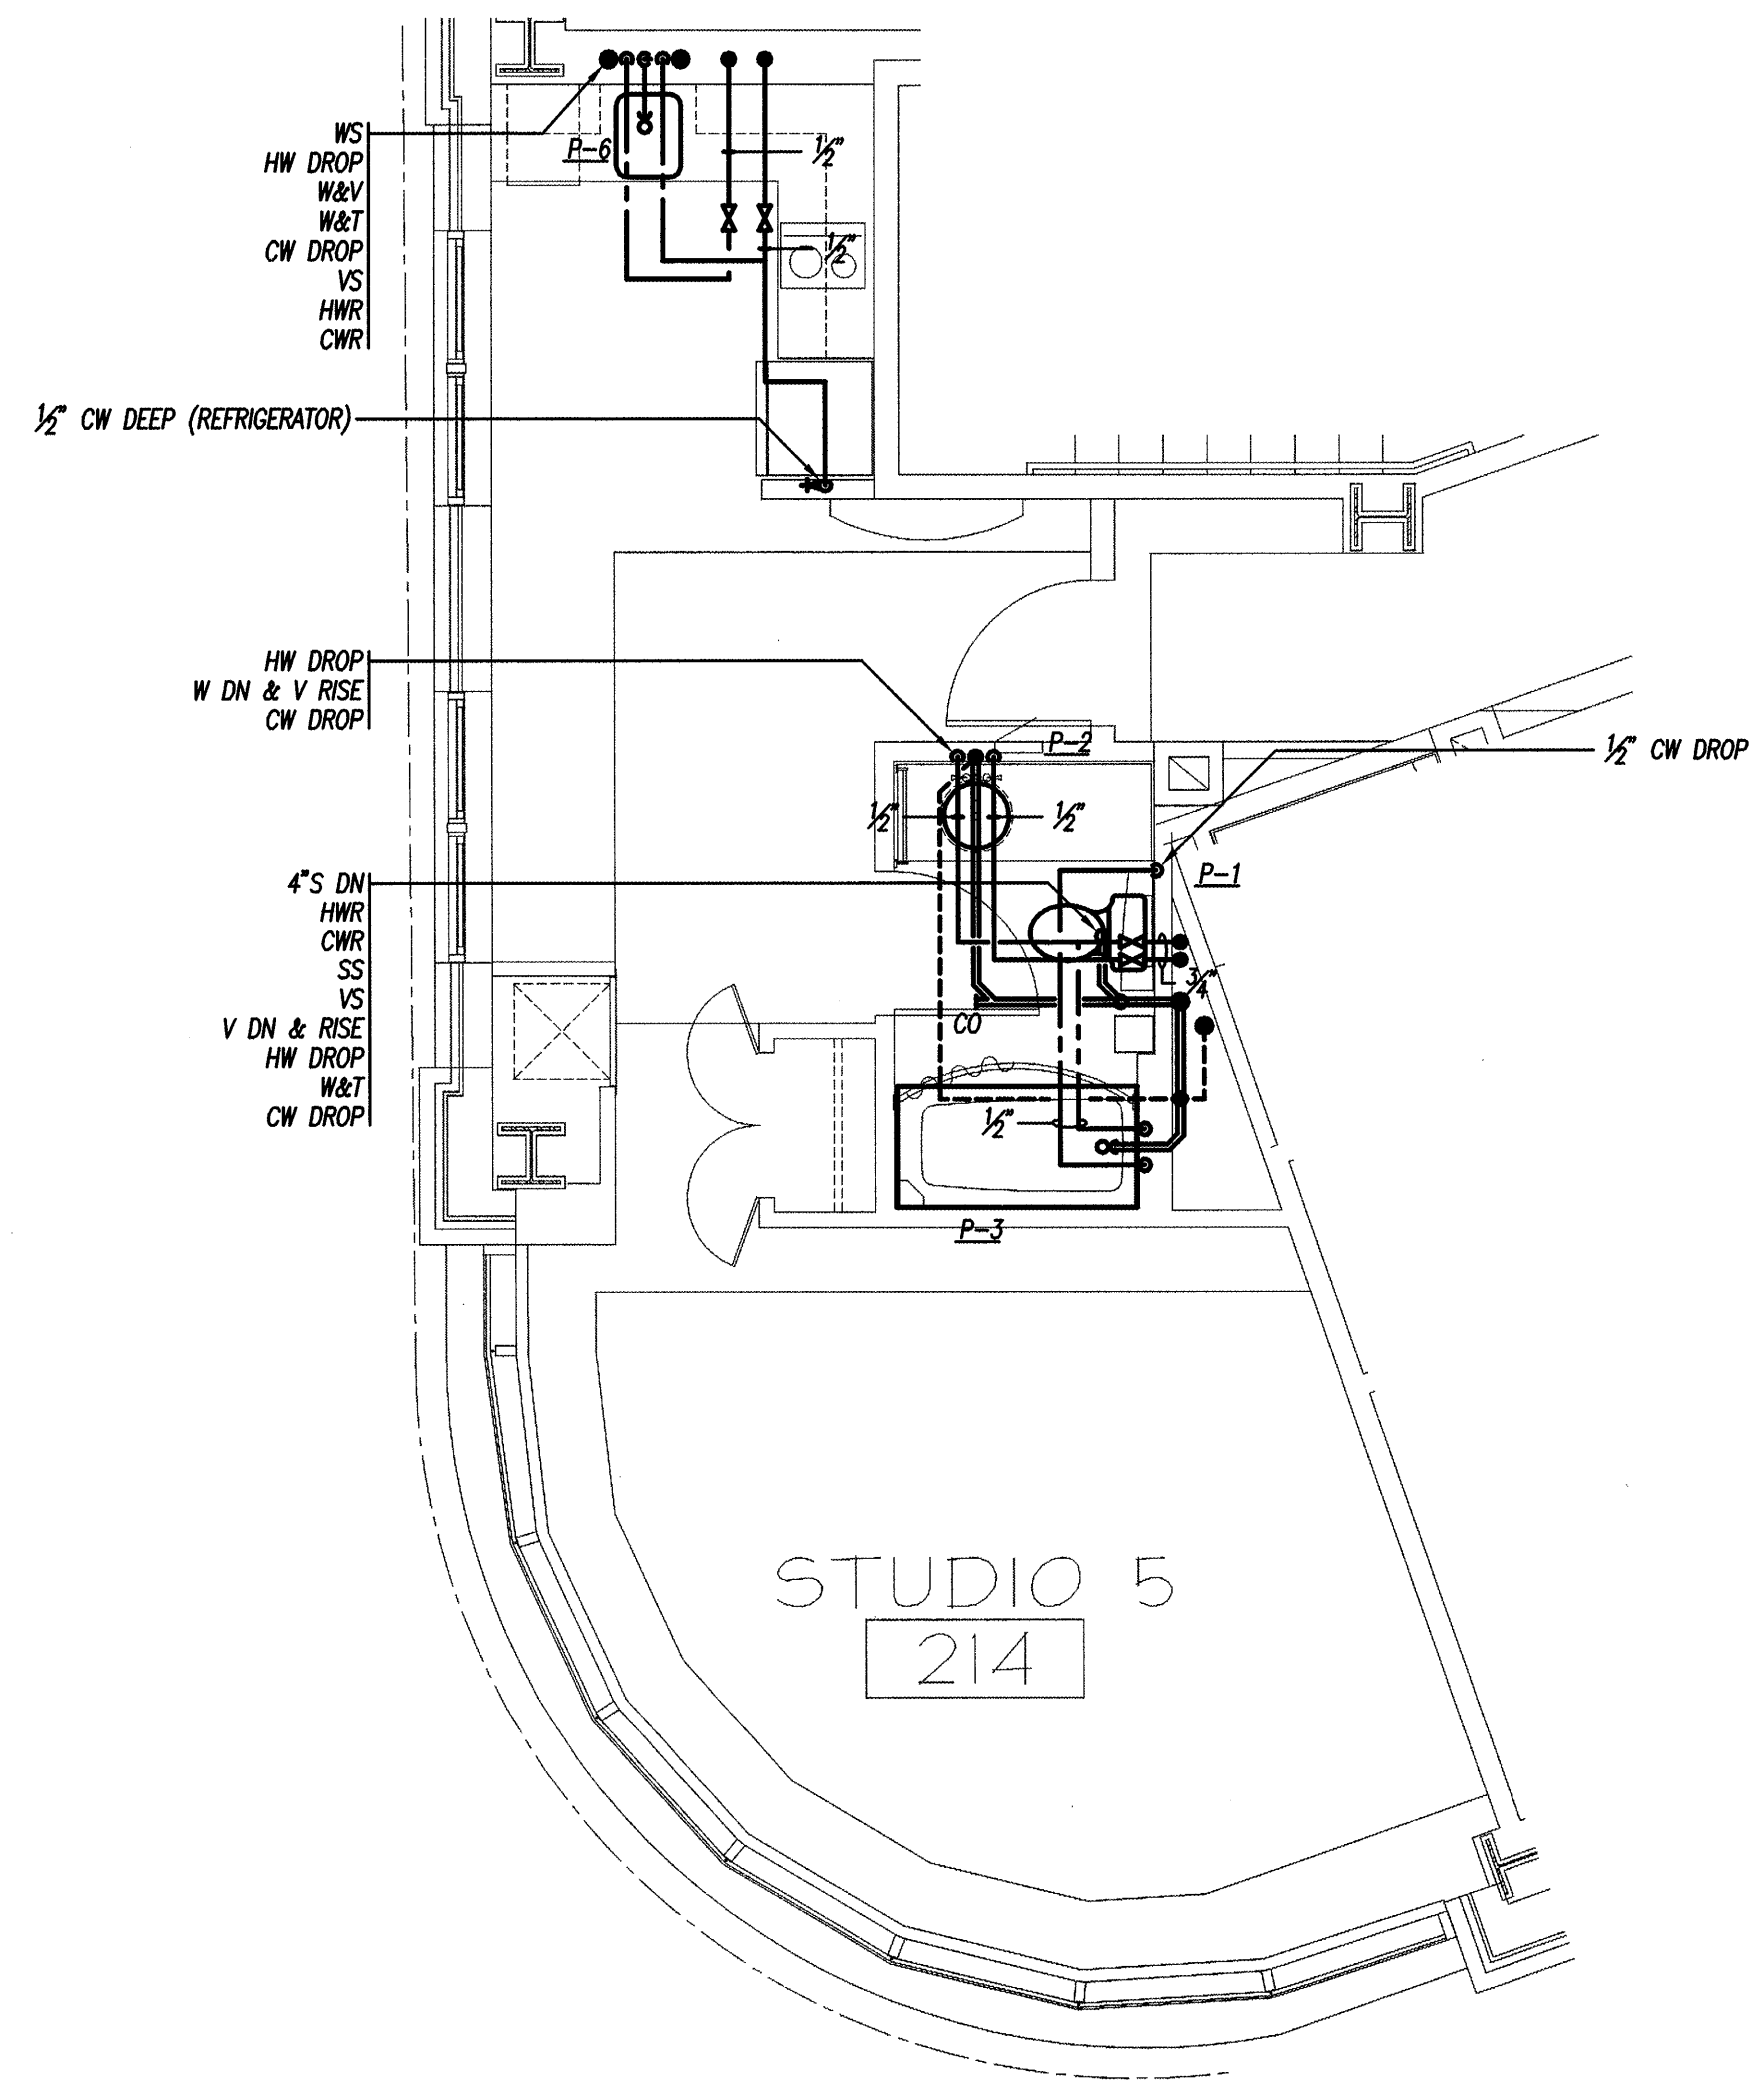


D STUDIO 5 - ENLARGED FLOOR PLAN
1/4" = 1'-0"

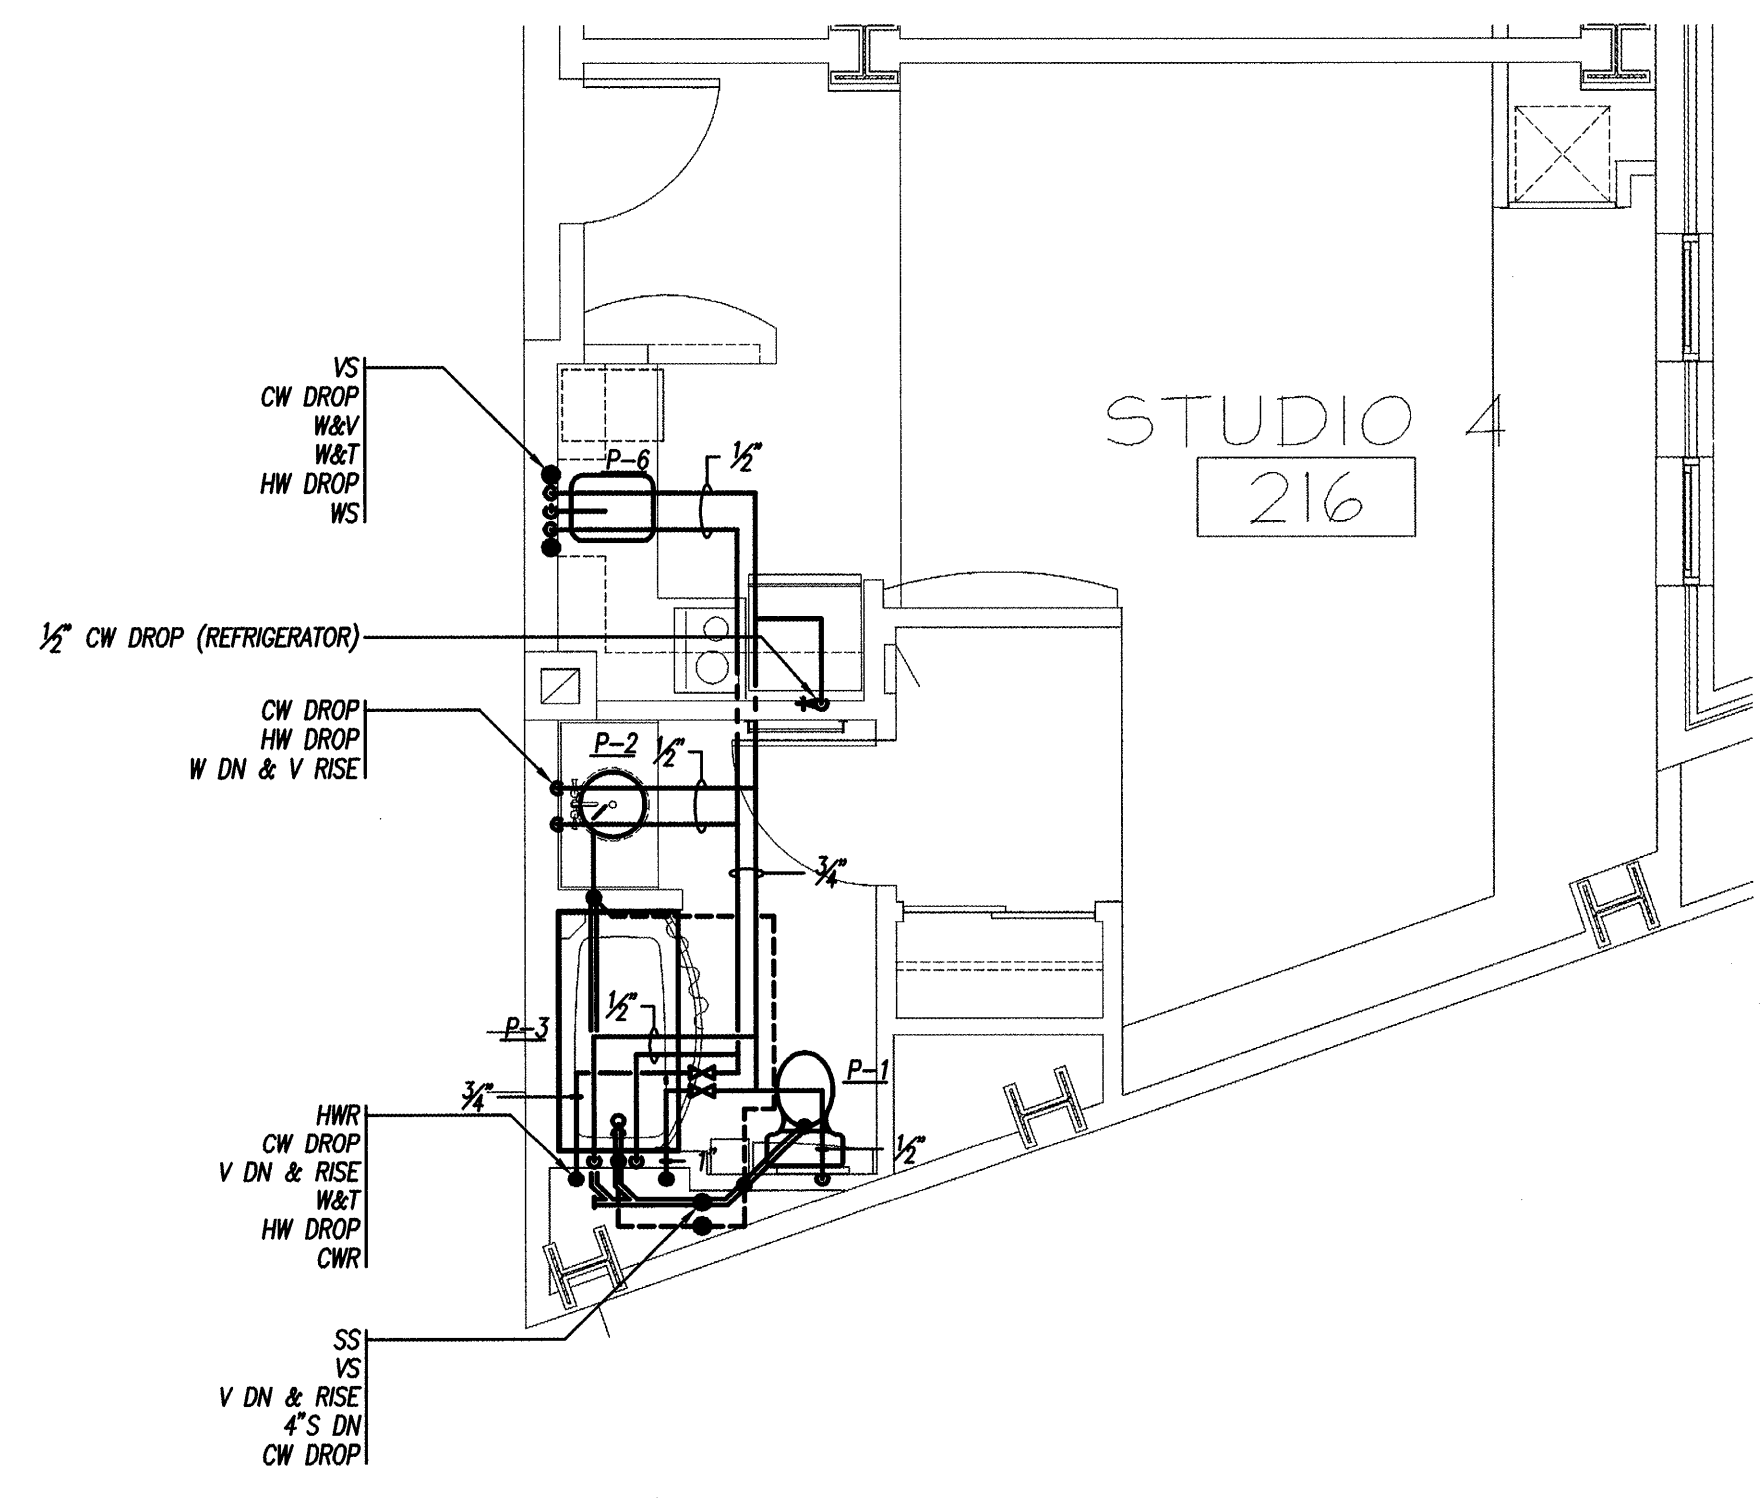

C STUDIO 4 - ENLARGED FLOOR PLAN
1/4" = 1'-0"

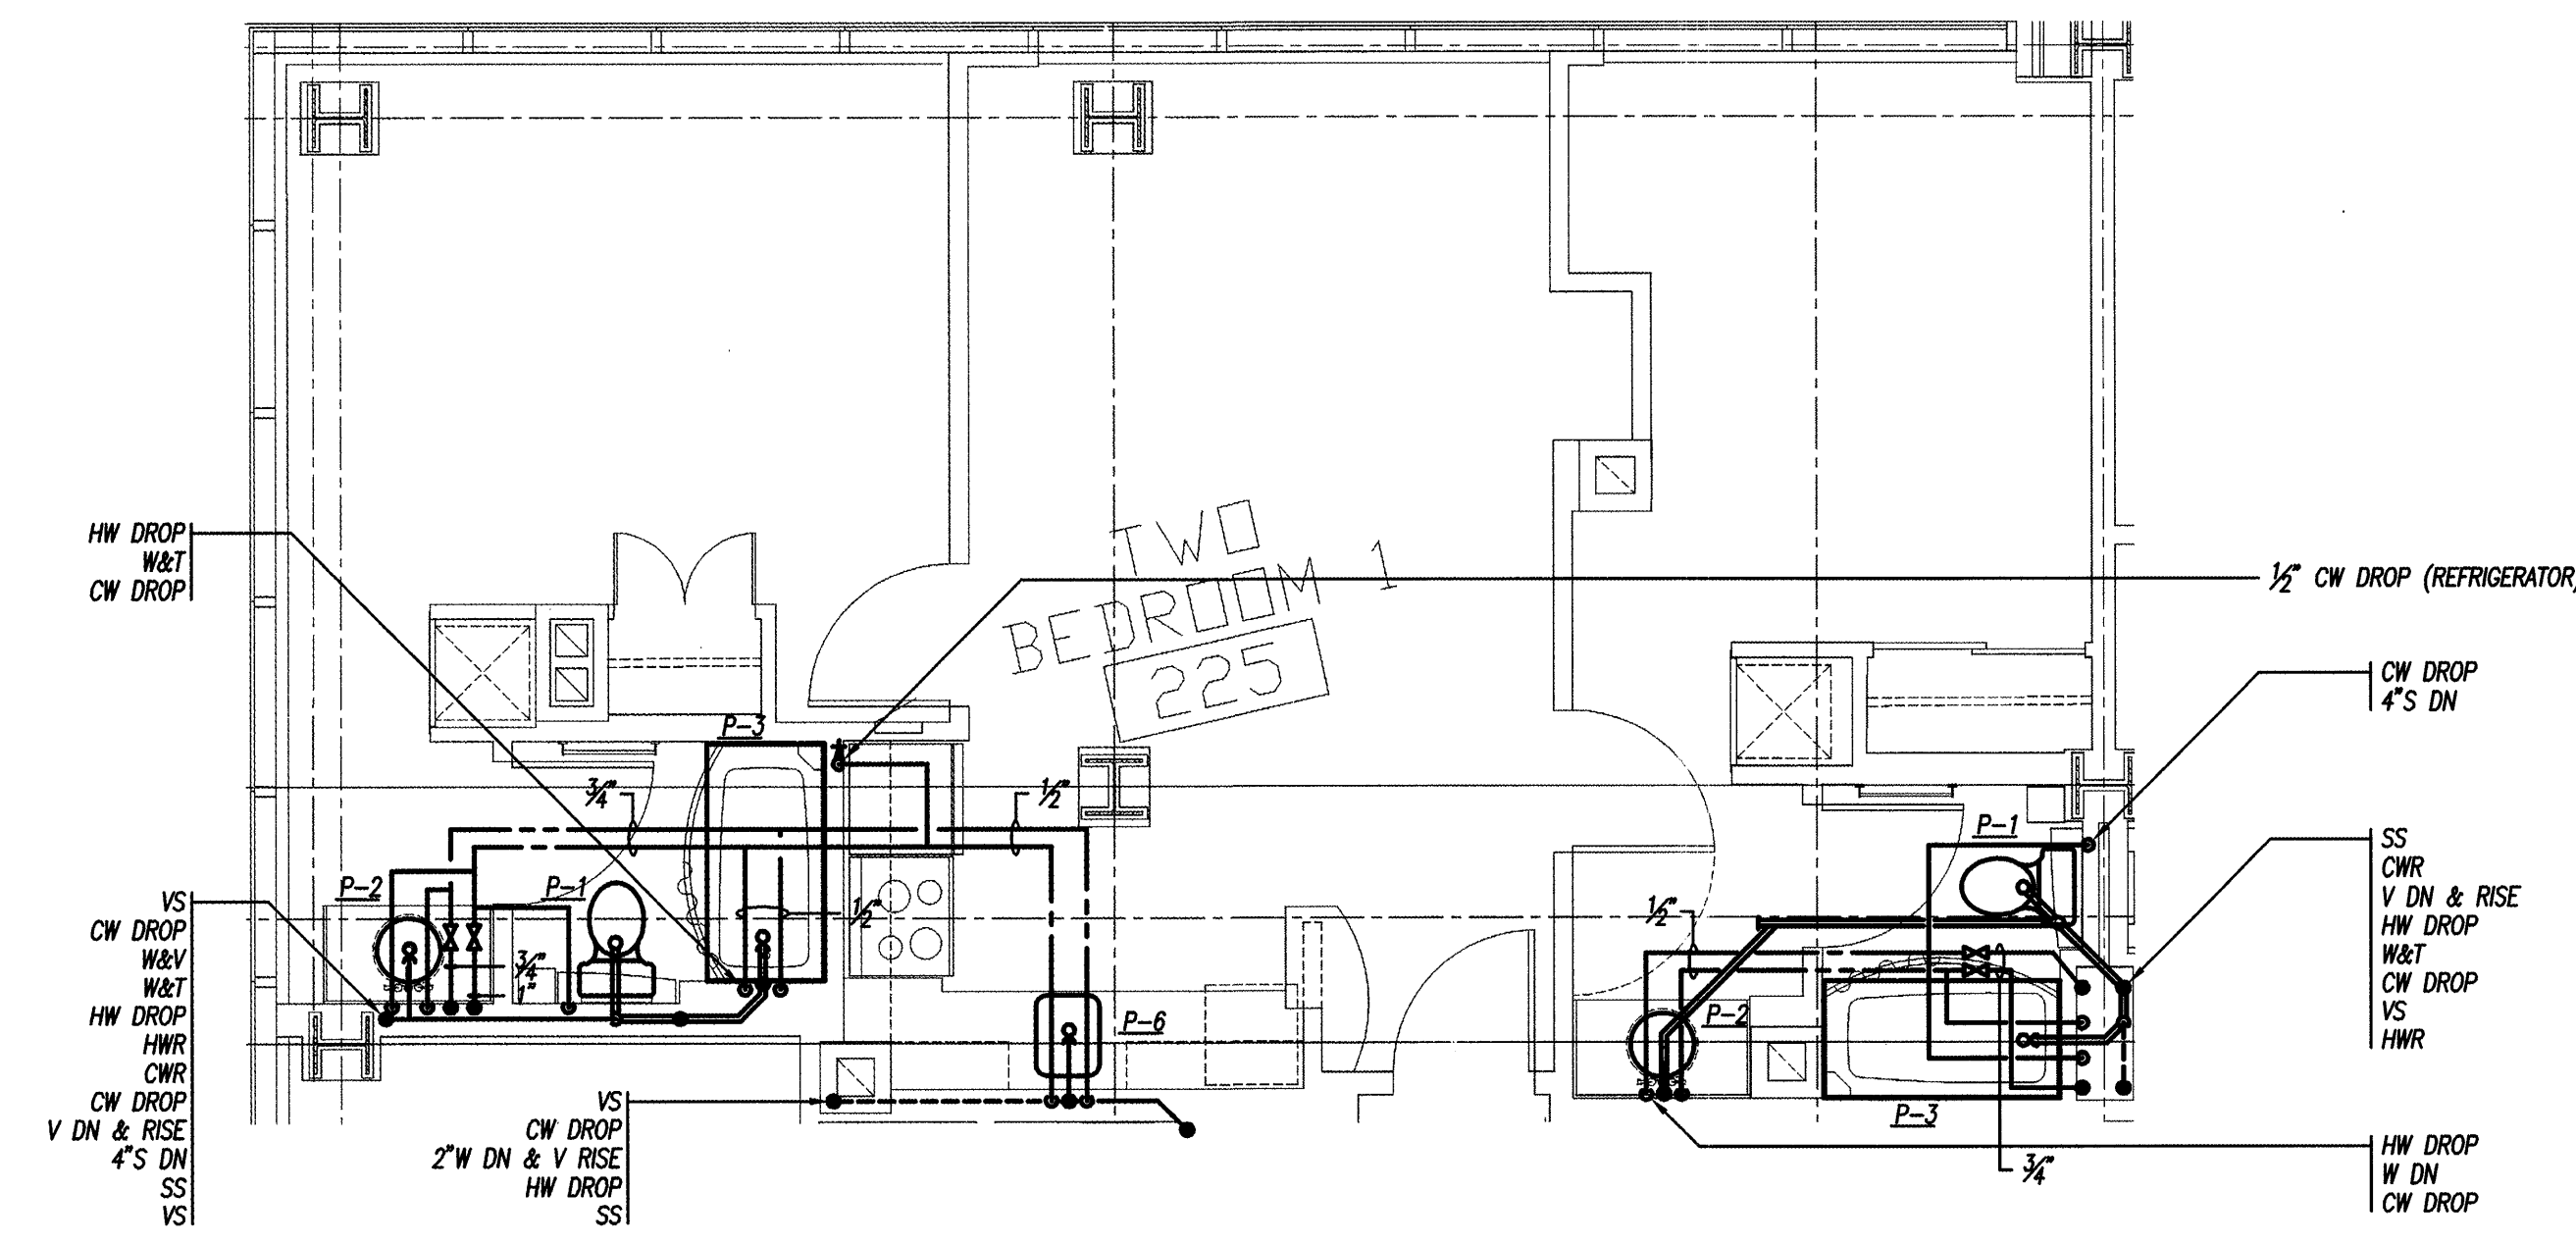


A TWO BEDROOM ONE - ENLARGED FLOOR PLAN
1/4" = 1'-0"

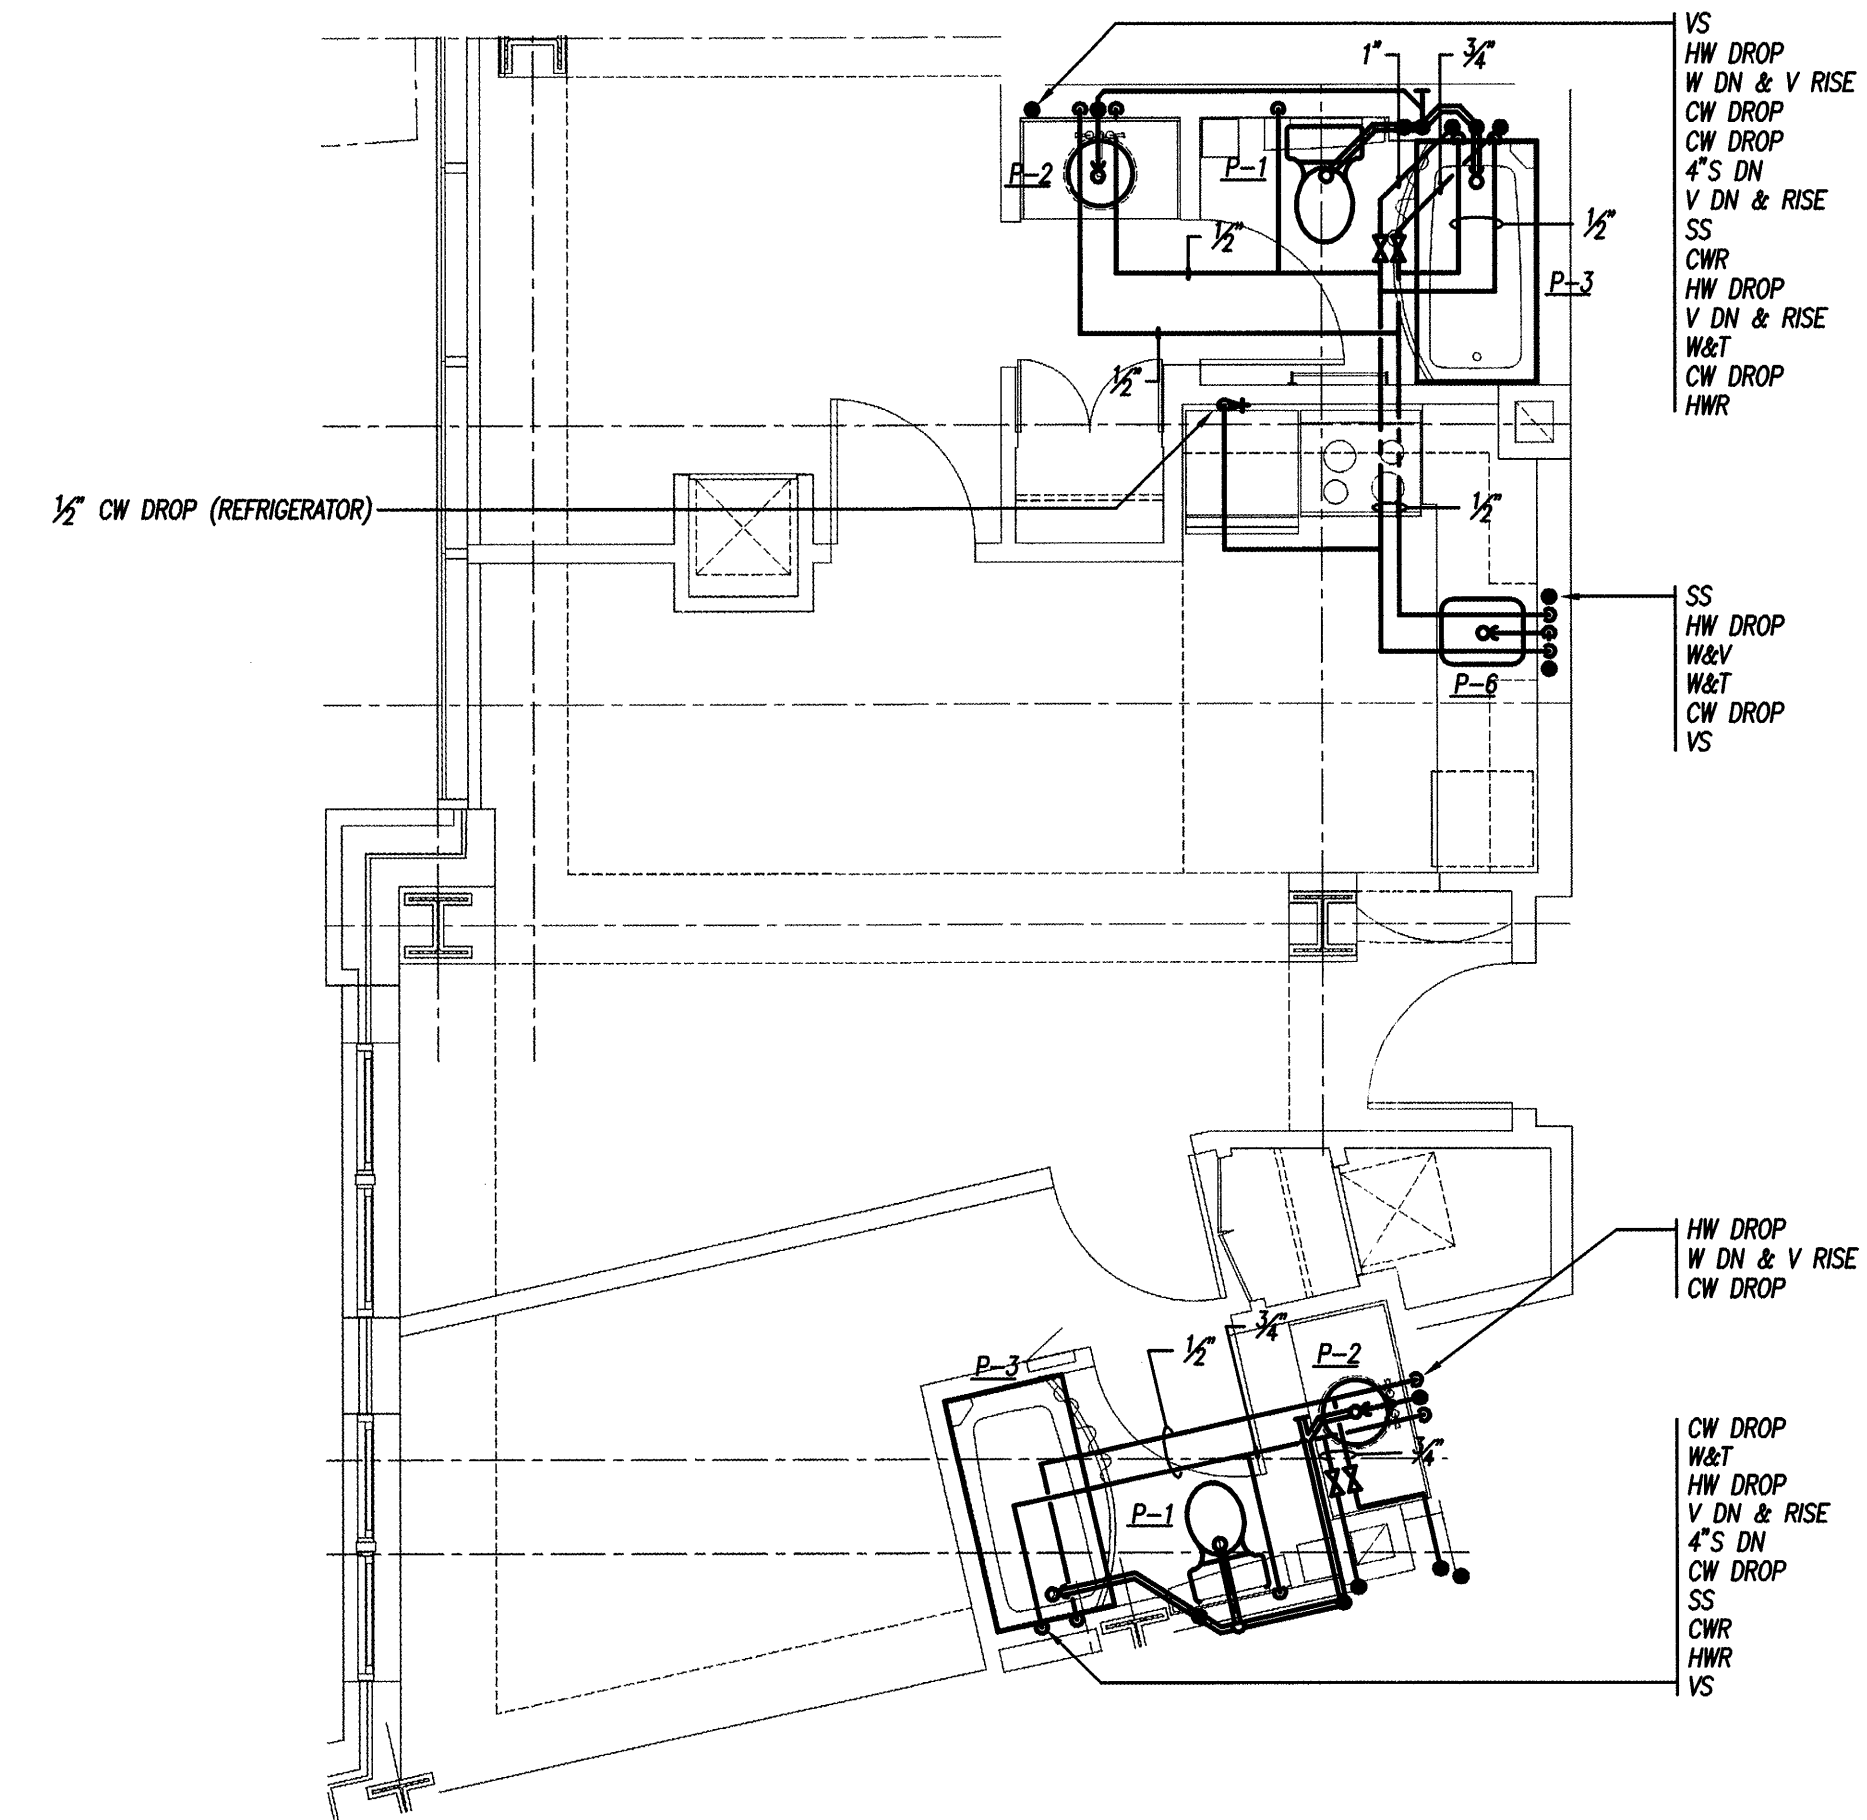

B TWO BEDROOM TWO - ENLARGED FLOOR PLAN
1/4" = 1'-0"

PERMIT ISSUE - 09/27/07

NO.	REVISION	DATE
SCALE: 3/32"=1' 0"		DRAWN BY: EMG
DATE: 09/27/07		CHECKED BY: RJM

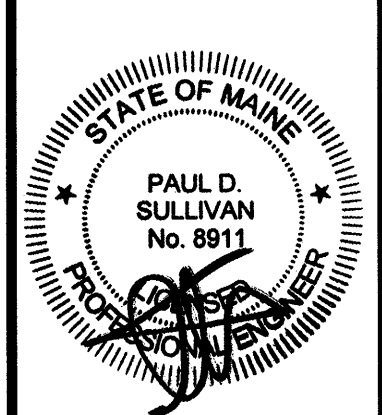

RWS
R. W. Sullivan Engineering
H.V.C. Electrical, Plumbing, Fire Protection Code
The Schroll Center
629 Main Street, Suite 203
Boston, Massachusetts 02128-1107
Phone: (617) 524-8027
Fax: (617) 524-8016
www.rwsllivan.com
RWS Job No. 2273.00

PROJECT
RESIDENCE INN BY MARRIOTT
PORTLAND, ME
JOB# 802

TITLE
BASE UNIT PLANS

GROUP ONE
21 W. THIRD STREET, BOSTON, MA 02127
TEL (617)268-7000 FAX: (617)268-0209

DRAWING NO.
P1.20