




1 VIBRATION ISOLATION ROOF CURB DETAIL NTS

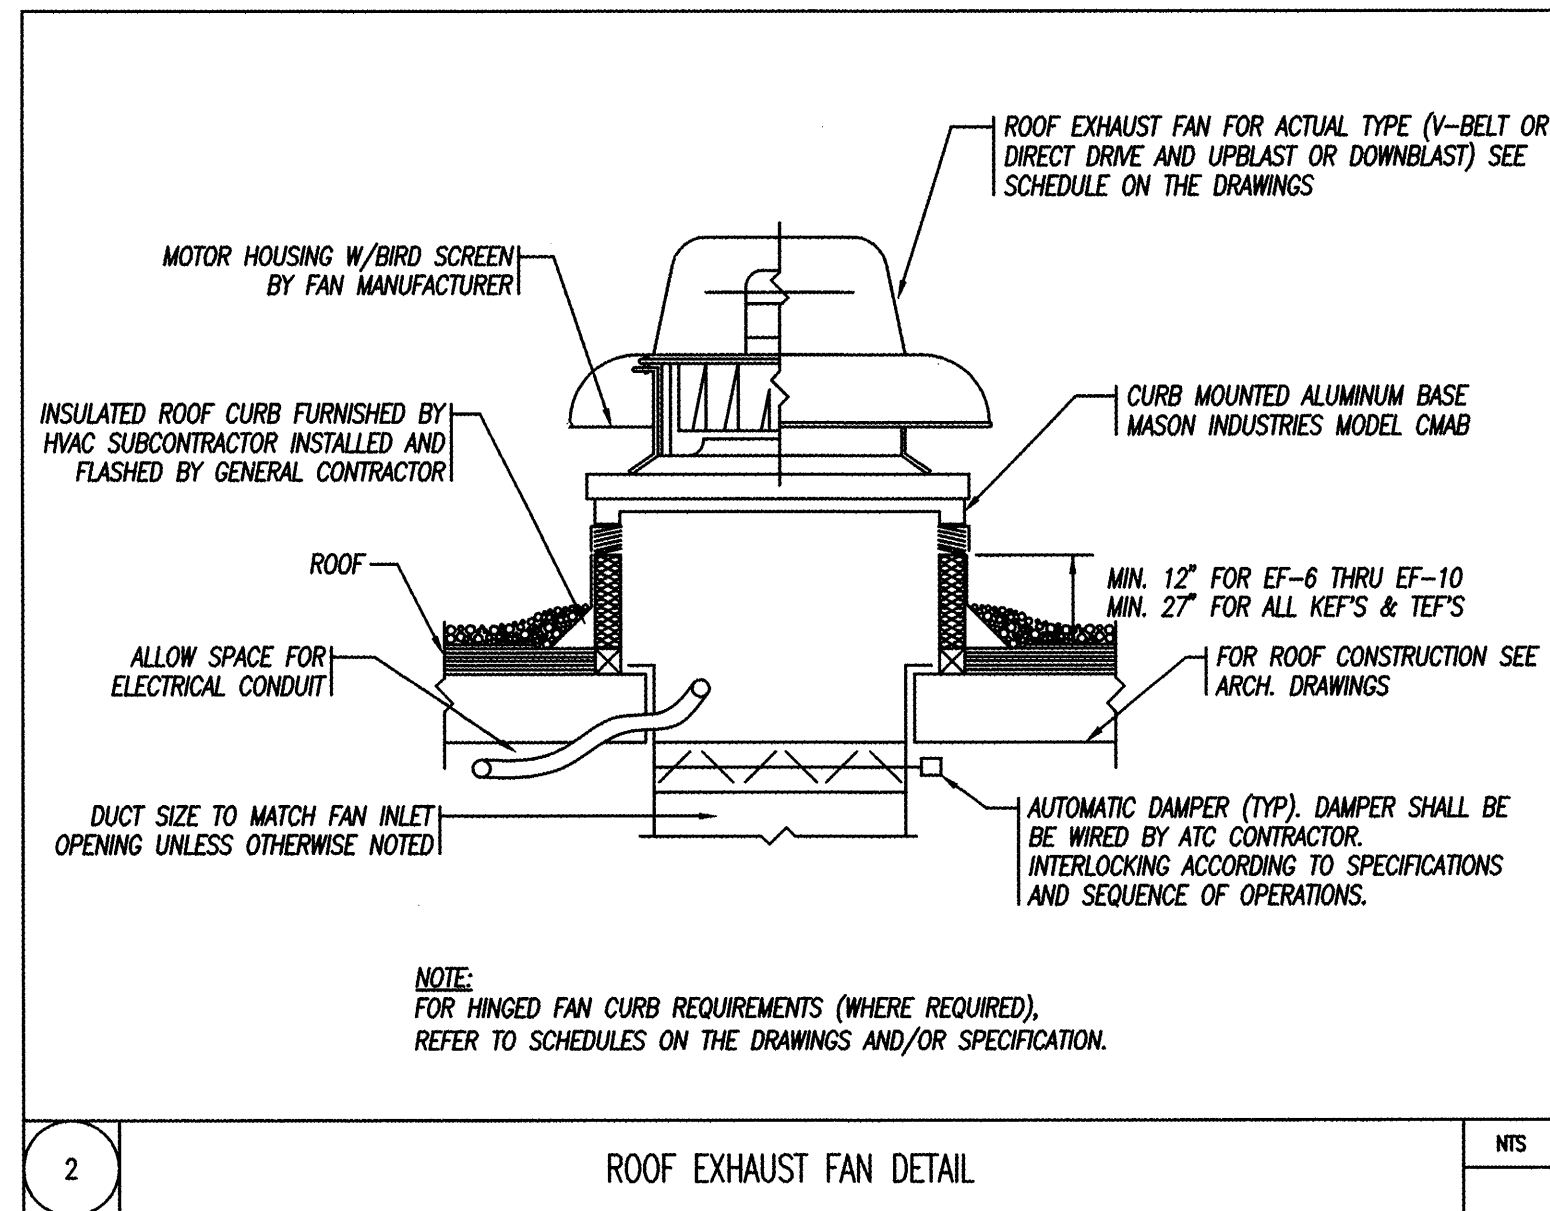


2 ROOF EXHAUST FAN DETAIL NTS

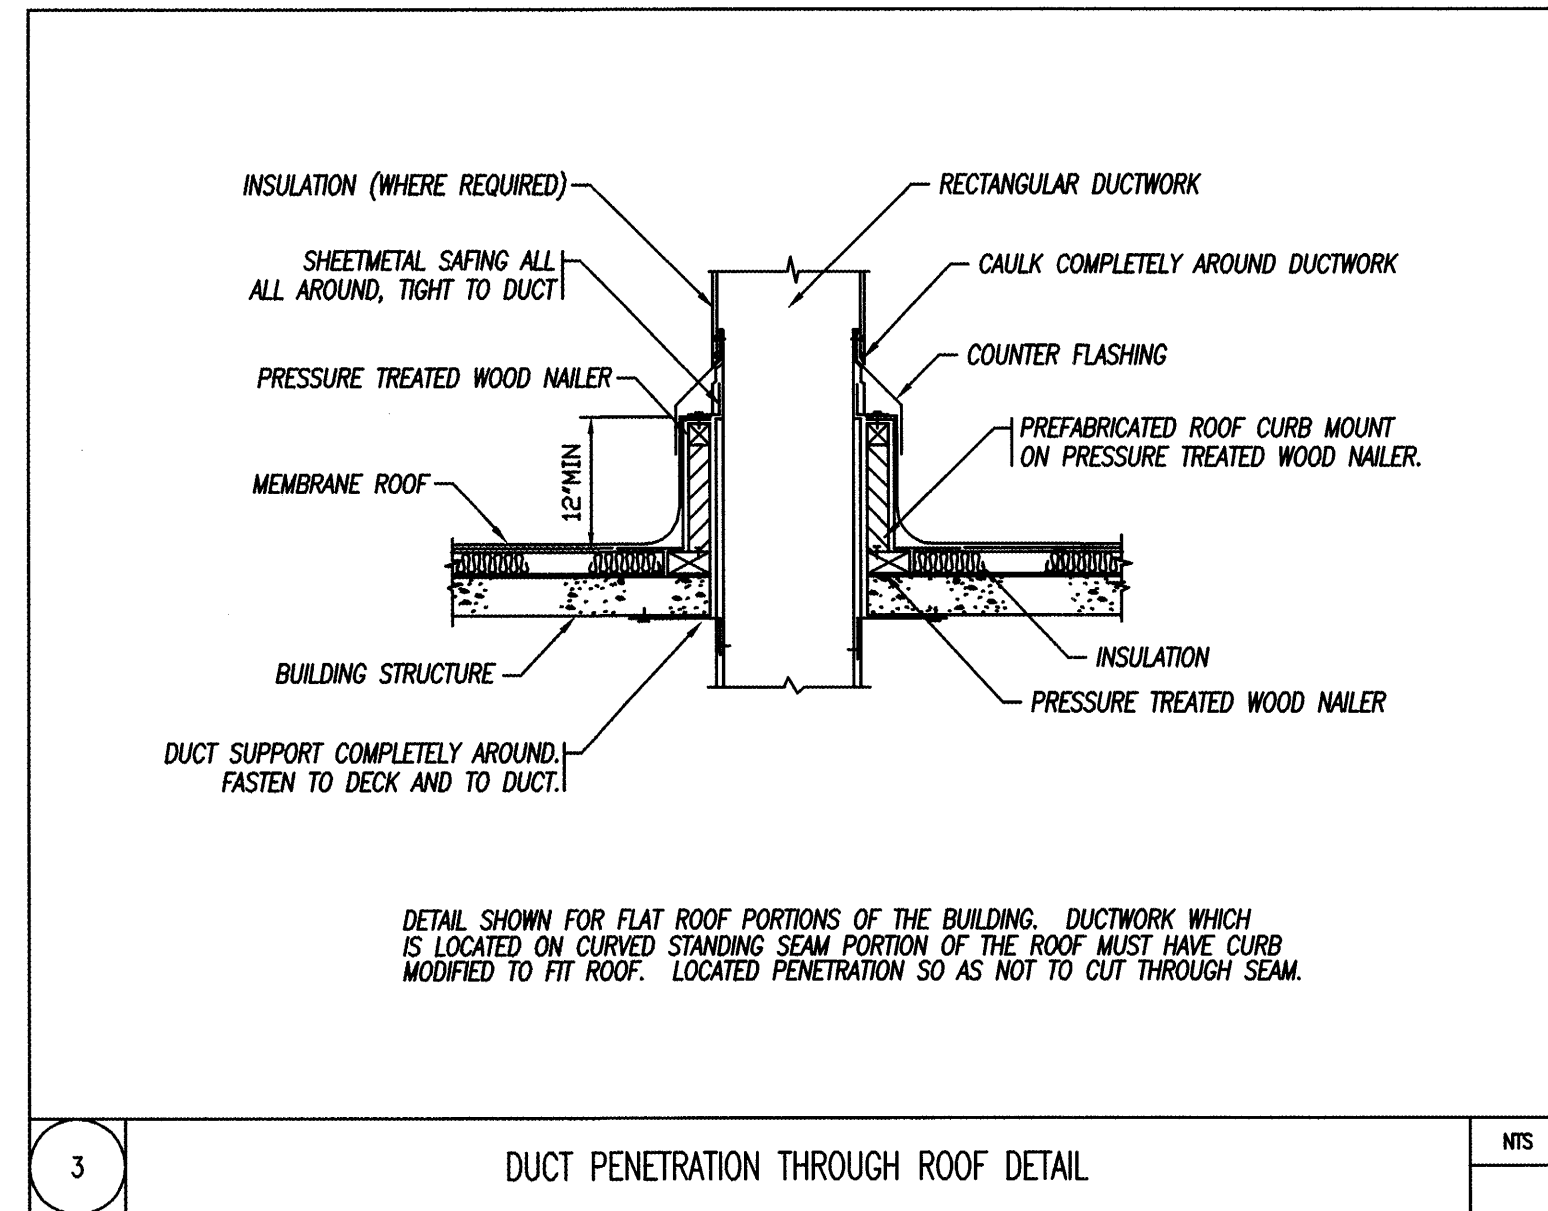


3 DUCT PENETRATION THROUGH ROOF DETAIL NTS

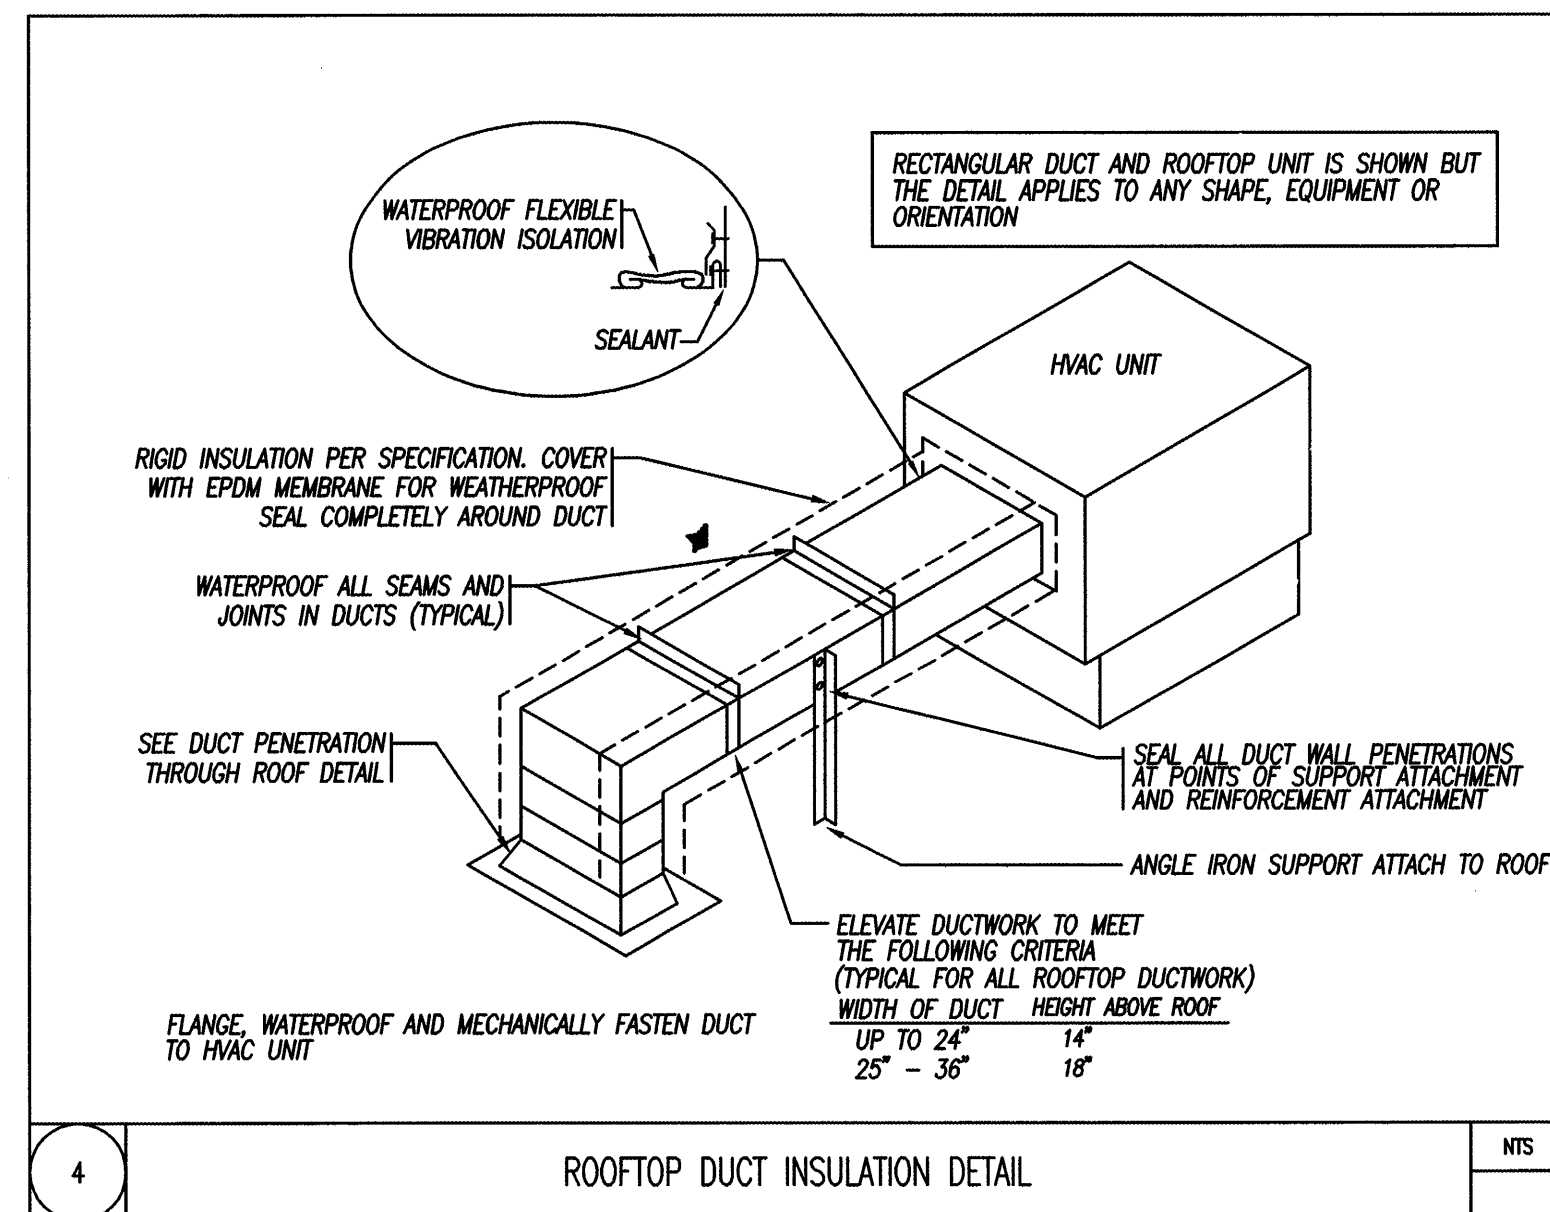


4 ROOFTOP DUCT INSULATION DETAIL NTS

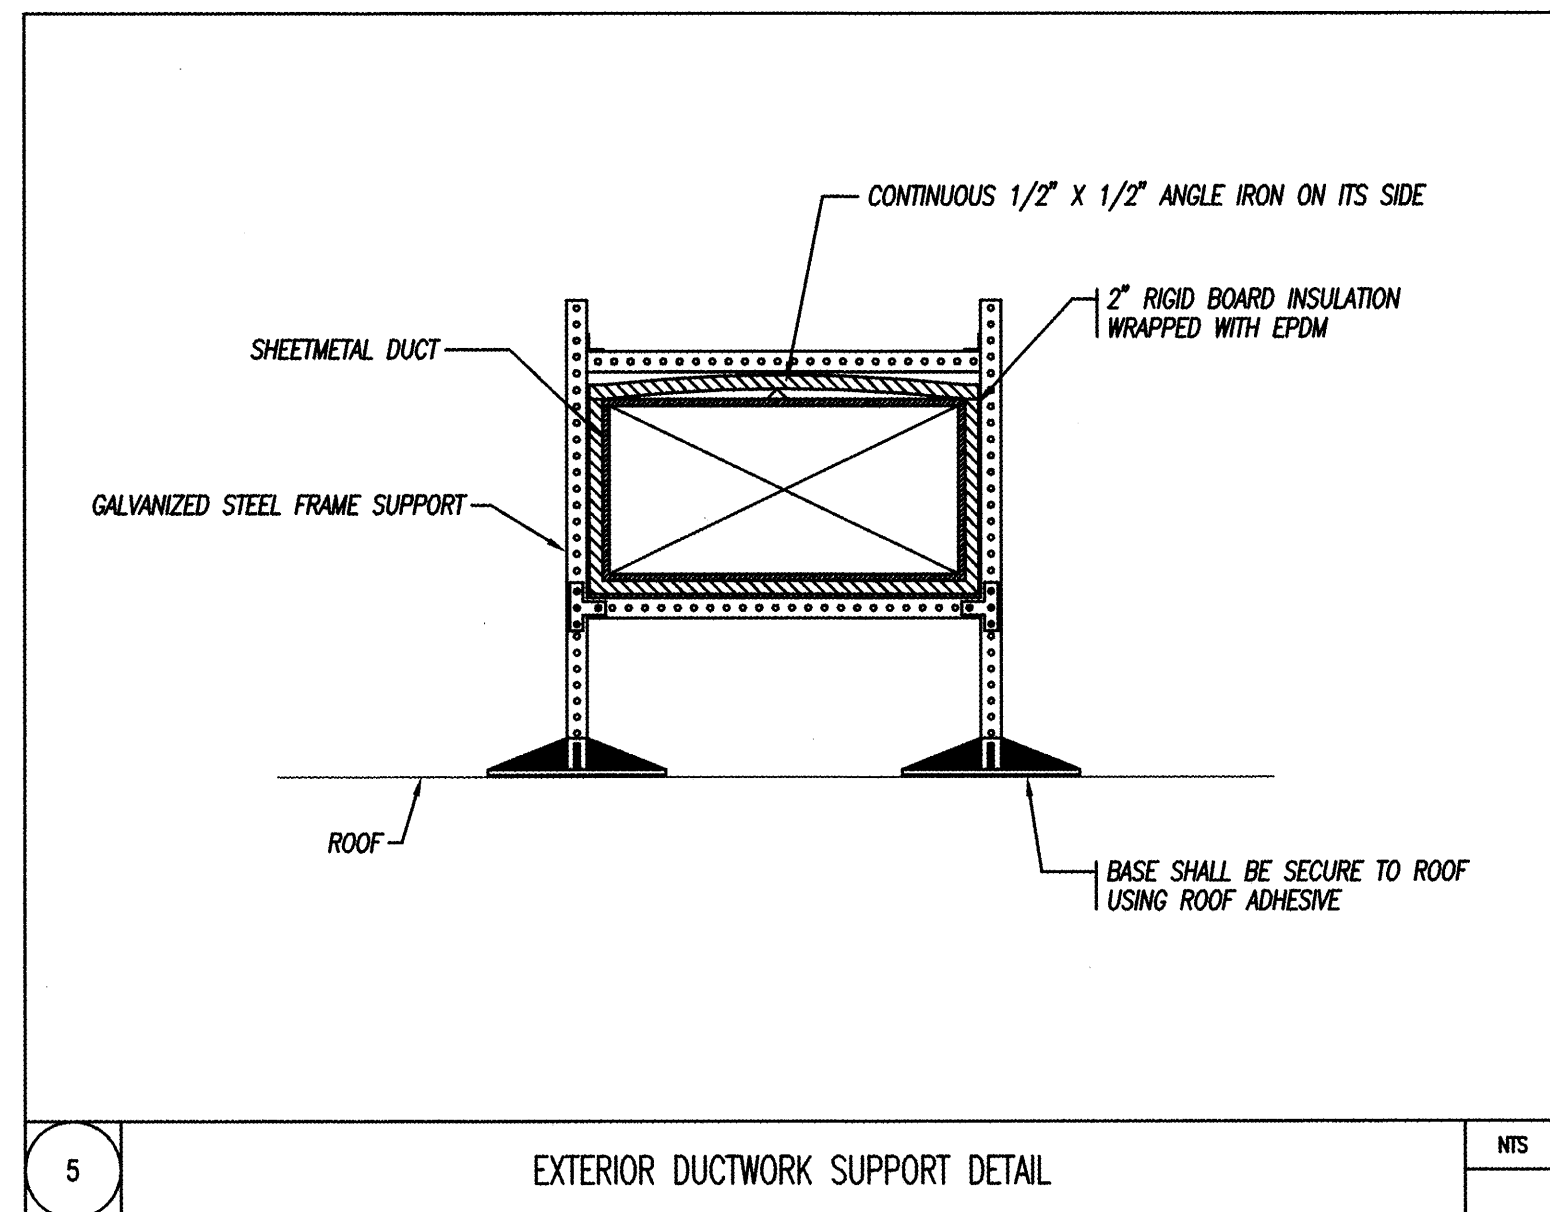


5 EXTERIOR DUCTWORK SUPPORT DETAIL NTS

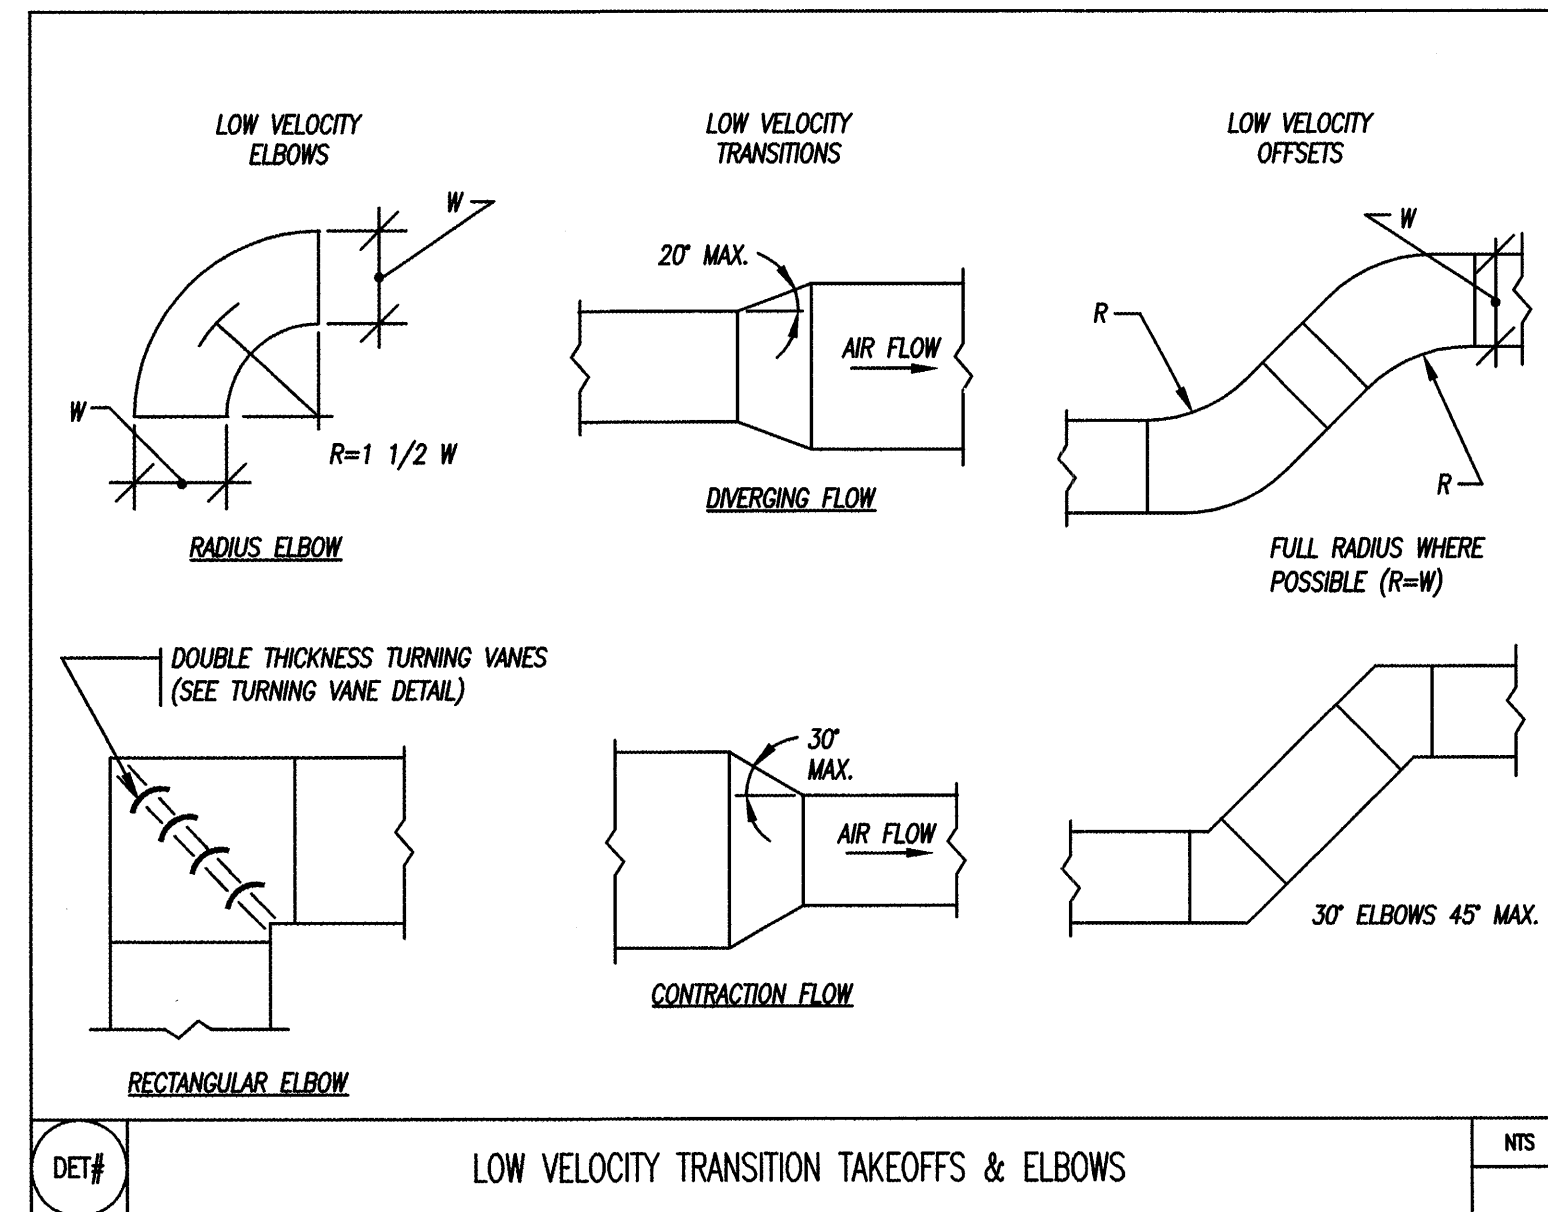

6# LOW VELOCITY TRANSITION TAKEOFFS & ELBOWS NTS

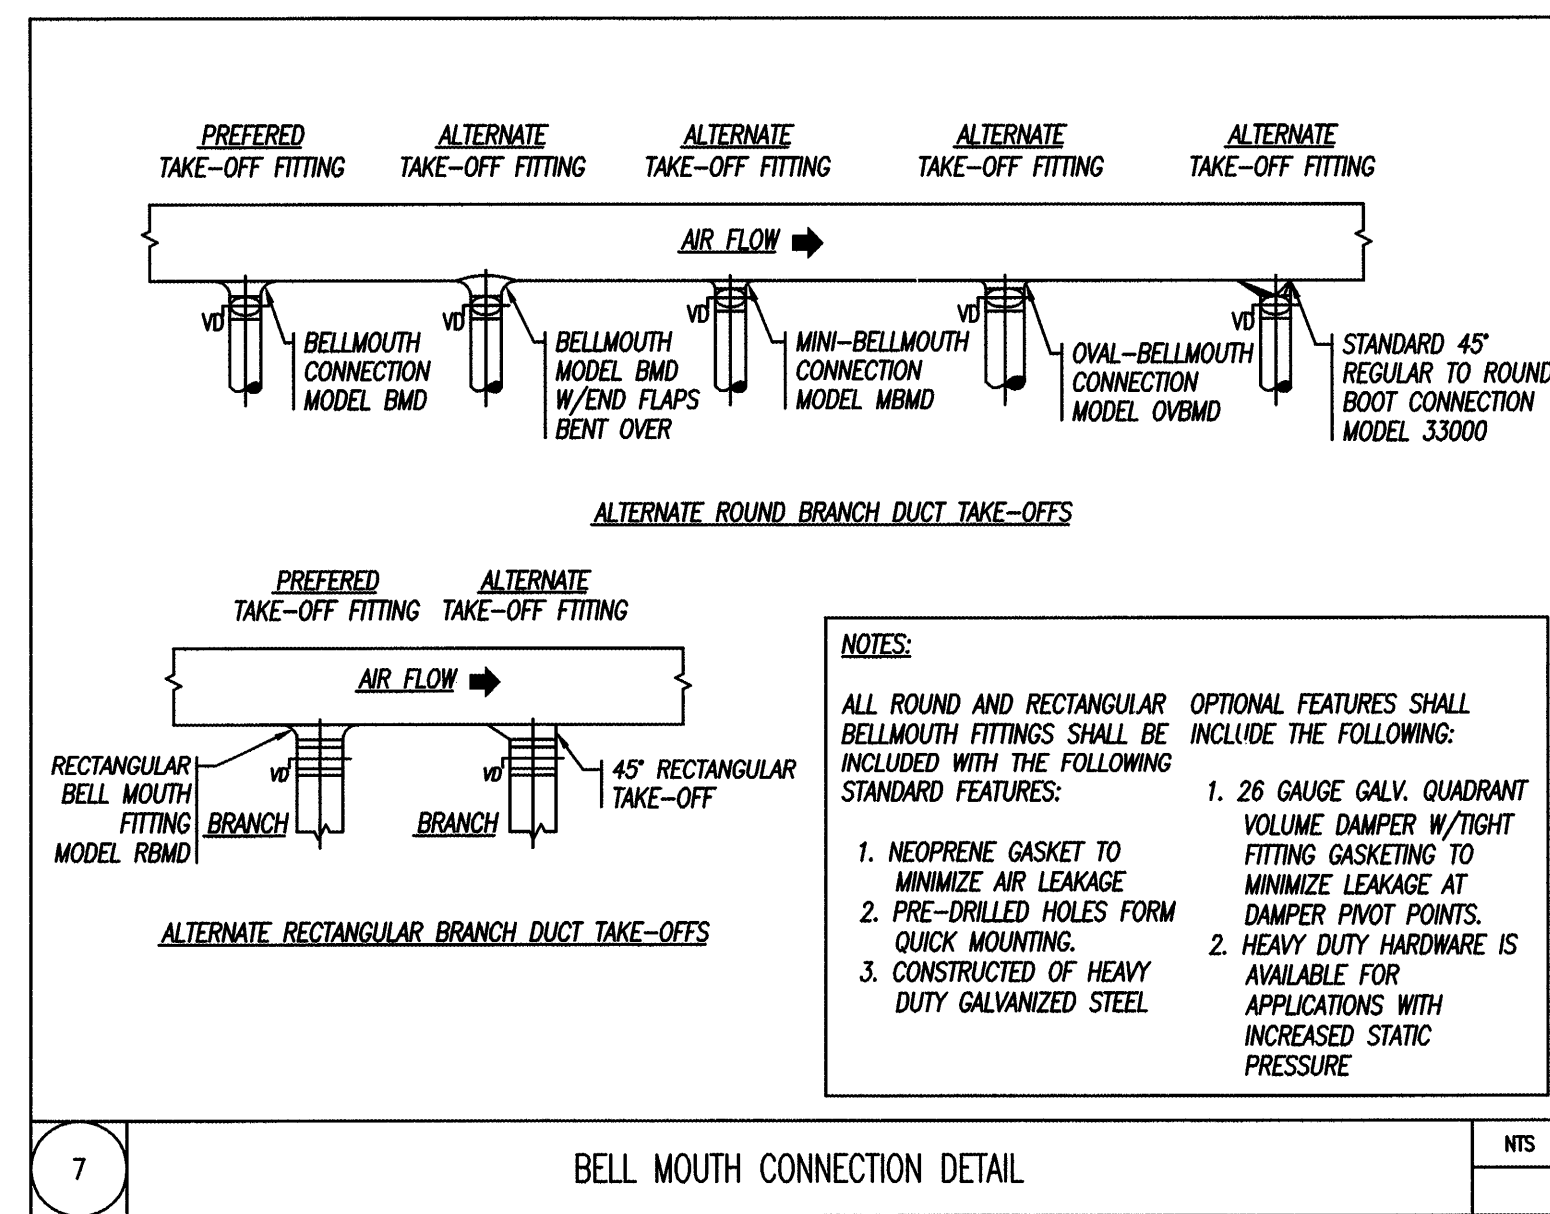

7 BELL MOUTH CONNECTION DETAIL NTS

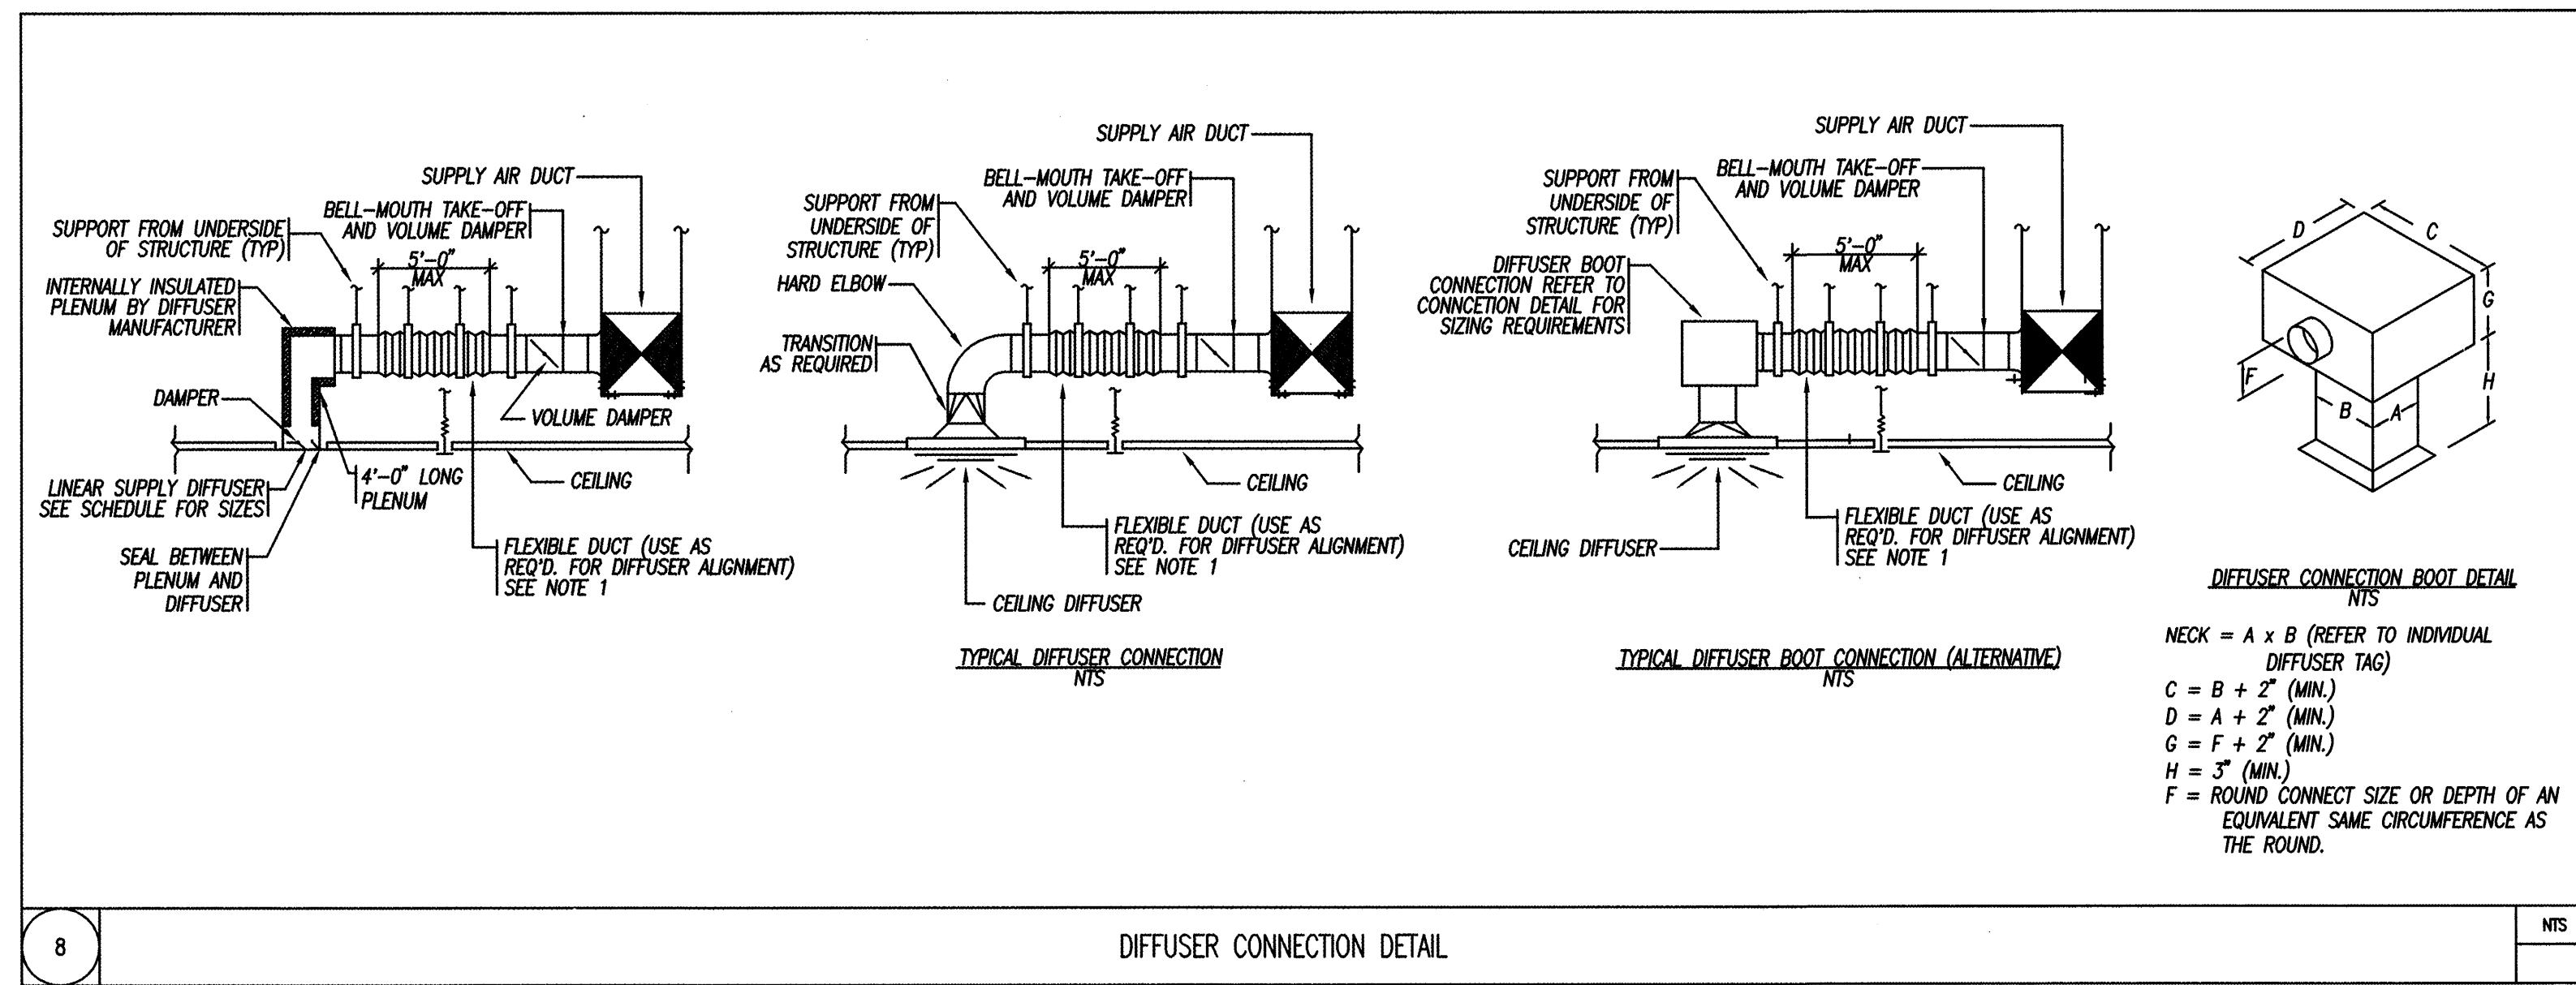

8 DIFFUSER CONNECTION DETAIL NTS

PERMIT ISSUE - 09/27/07

NO.	REVISION	DATE
SCALE: 3/32"=1' 0"	DRAWN BY: MJR	CHECKED BY: JCL
DATE: 09/27/07		

PAUL D. SULLIVAN
No. 8911

R. W. Sullivan Engineering
The Seaford Center
529 Main Street, Suite 203
Boston, Massachusetts 02129-1107
Phone: (617) 524-8277
Fax: (617) 524-8216
www.rwsenr.com
RWS Job No. 2273.00

PROJECT
RESIDENCE INN BY MARRIOTT
PORTLAND, ME
JOB# 802

TITLE
HVAC DETAILS

GROUP ONE
21 W. THIRD STREET, BOSTON, MA 02127
TEL: (617)268-7000 FAX: (617)268-0209

DRAWING NO.
H0.03