




A TWO BEDROOM ONE - ENLARGED FLOOR PLAN
1/4" = 1'-0" (REFERENCE DRAWING A1.31)

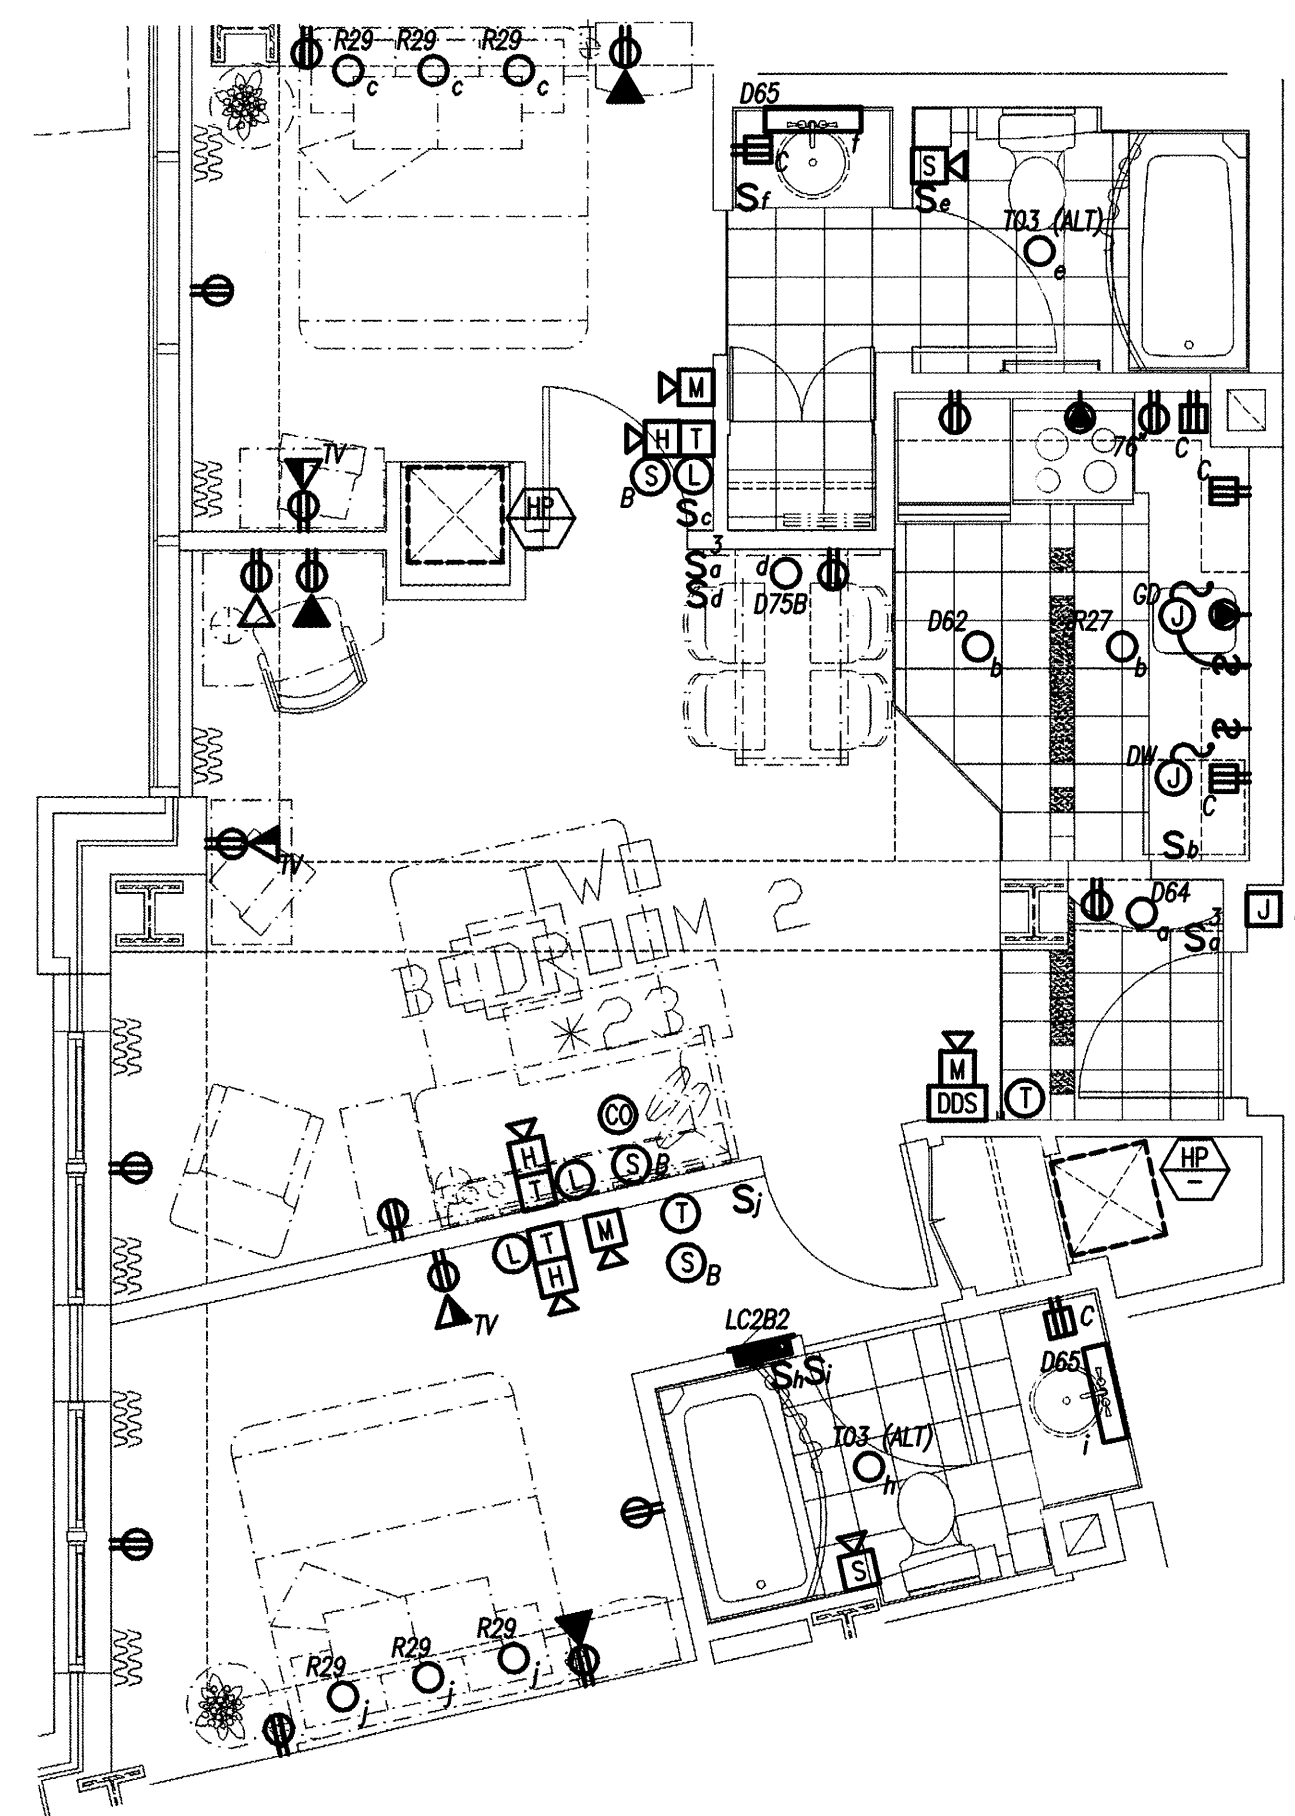

B TWO BEDROOM TWO - ENLARGED FLOOR PLAN
1/4" = 1'-0" (REFERENCE DRAWING A1.33)

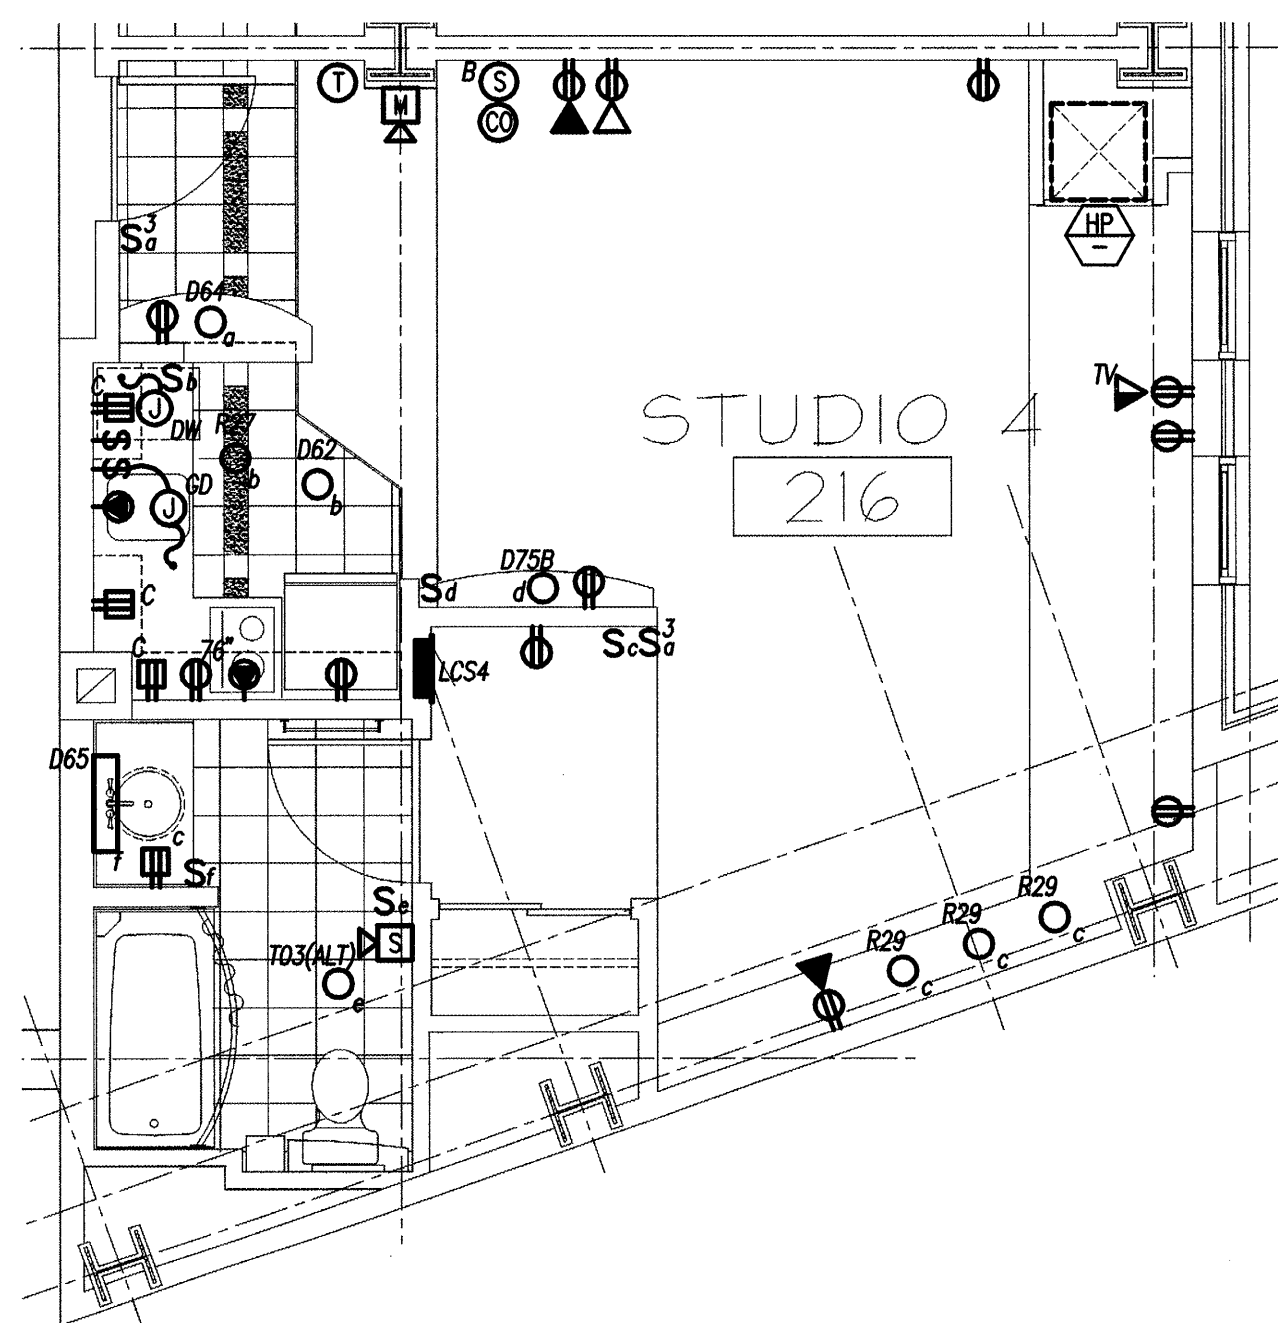


C STUDIO 4 - ENLARGED FLOOR PLAN
1/4" = 1'-0" (REFERENCE DRAWING A1.23)

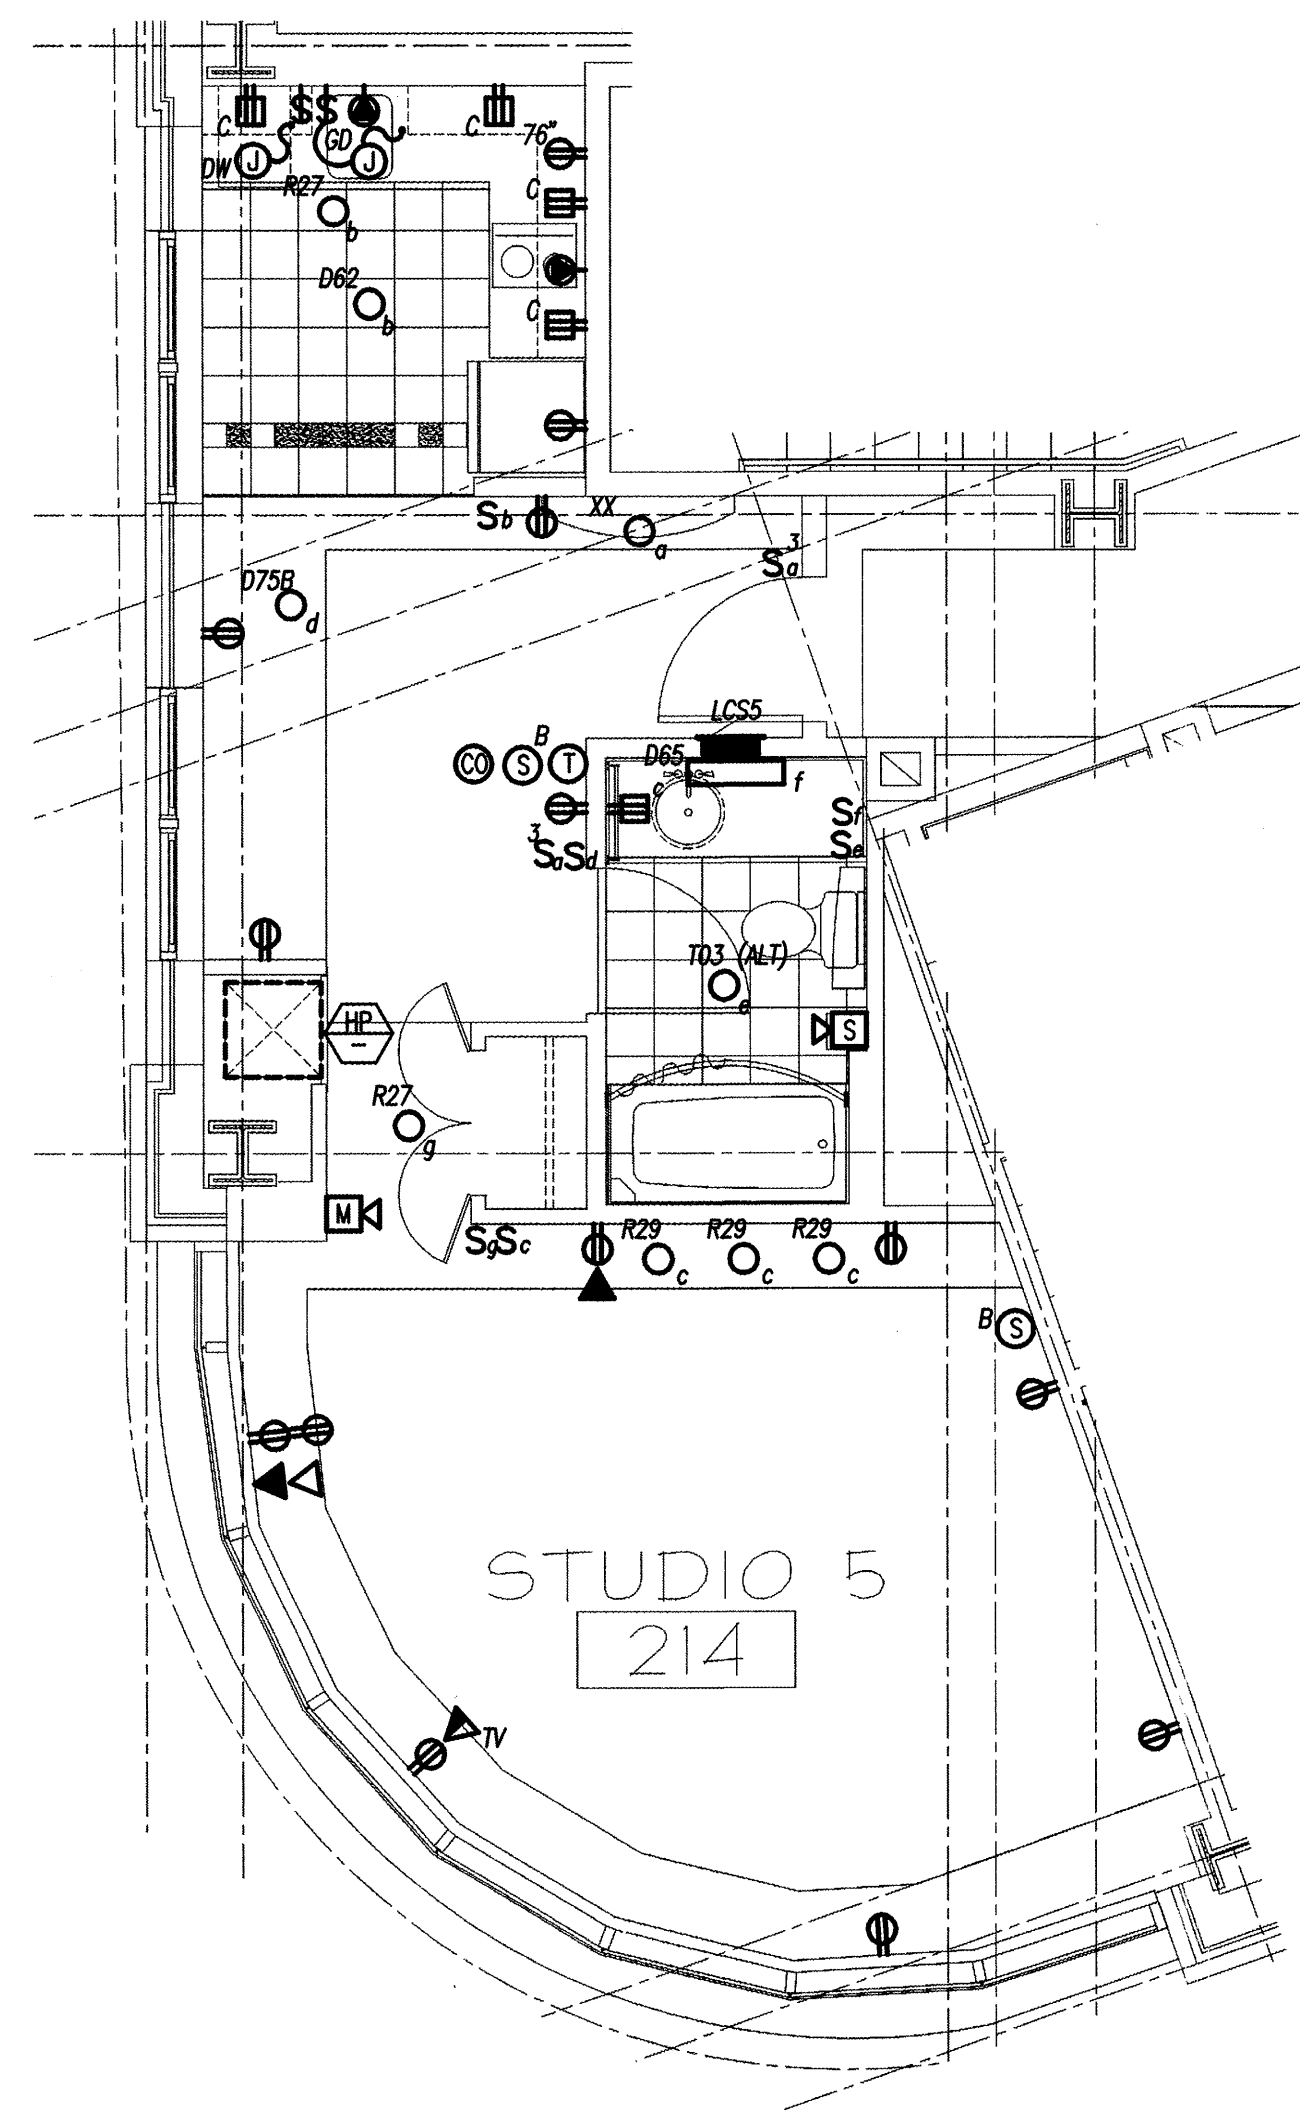

D STUDIO 5 - ENLARGED FLOOR PLAN
1/4" = 1'-0" (REFERENCE DRAWING A1.24)

PERMIT ISSUE - 09/27/07

NO.	REVISION	DATE
SCALE: 3/32"=1' 0"	DRAWN BY: GCH	
DATE: 09/27/07	CHECKED BY: DAH	

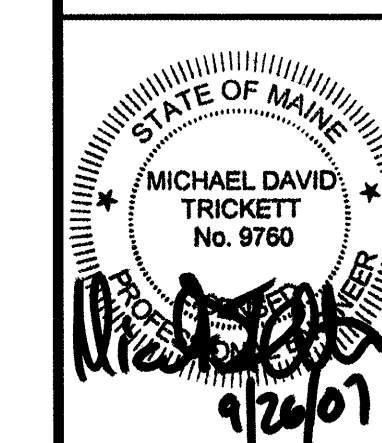

RWS
R. W. Sullivan Engineering
The Seaside Center
529 Main Street, Suite 203
Boston, Massachusetts 02128-1107
Phone: (617) 523-5227
Fax: (617) 523-8016
www.rwsnet.com
RWS Job No. 2273.00

PROJECT
RESIDENCE INN BY MARRIOTT
PORTLAND, ME
JOB# 802

TITLE
ELECTRICAL UNIT PLANS

GROUP ONE
21 W. THIRD STREET, BOSTON, MA 02127
TEL: (617)268-7000 FAX: (617)268-0209

DRAWING NO.
E4.02