
 
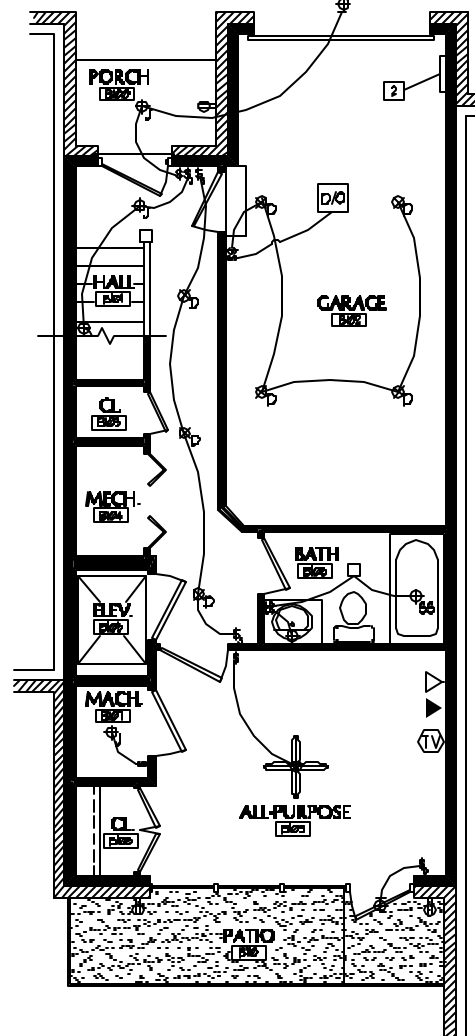



IF THIS SHEET IS NOT 24 X 36 IT IS A REDUCED SCALE PRINT - SCALE ACCORDINGLY




1 ELECT. PLAN - 1st FLOOR SCALE: 1/4" = 1'-0"

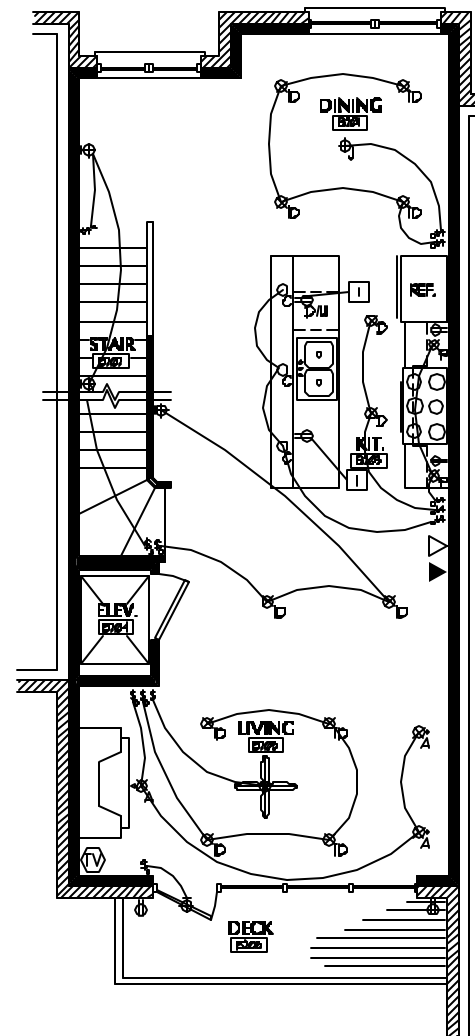

2 ELECT. PLAN - 2nd FLOOR SCALE: 1/4" = 1'-0"

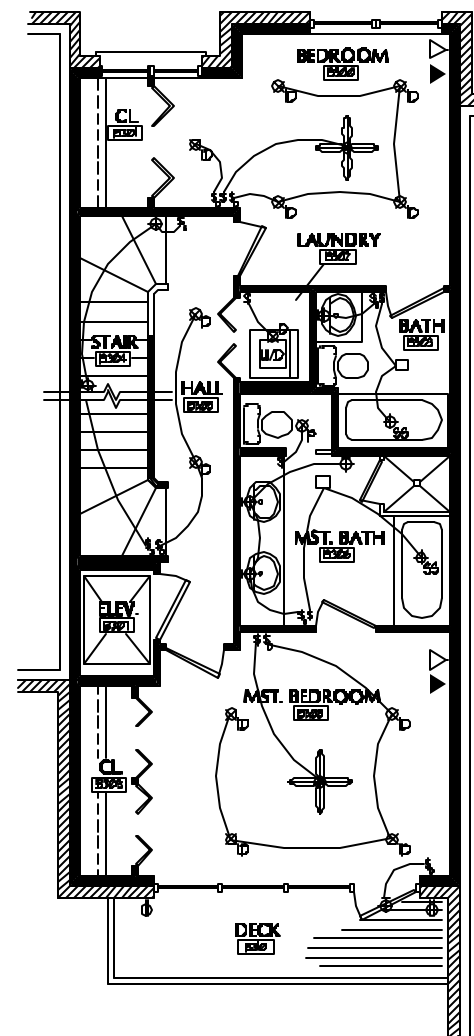

3 ELECT. PLAN - 3rd FLOOR SCALE: 1/4" = 1'-0"

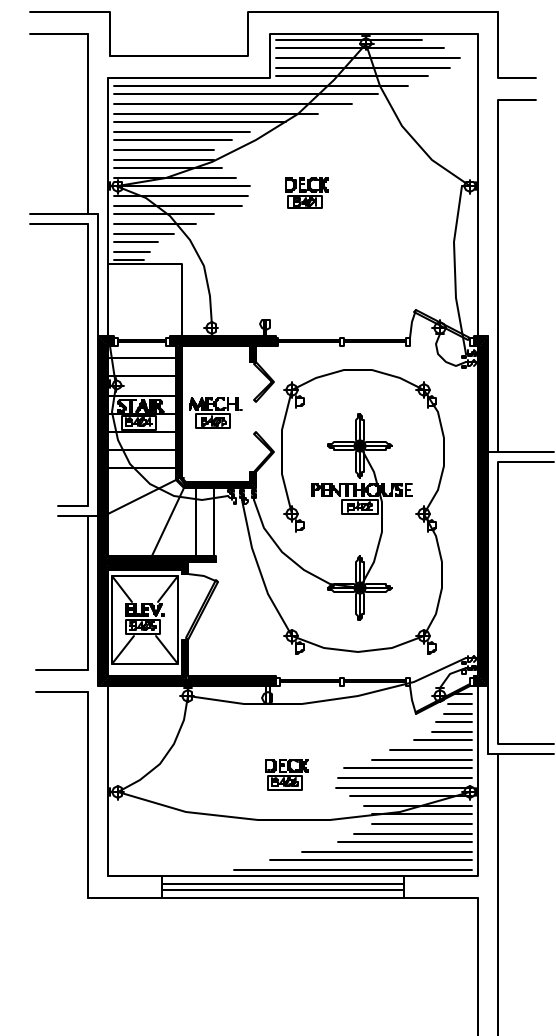

4 ELECT. PLAN - 4th FLOOR SCALE: 1/4" = 1'-0"

ELECTRICAL KEY

- ⓧ TV CONNECTION
- ⓧ POWER OUTLET
- ⓧ 220 POWER OUTLET
- ▲ DATA OUTLET
- △ TELEPHONE OUTLET
- EXHAUST FAN
- ⓧ SURFACE CEILING LIGHT - J BOX
- ⓧ TRIS DIRECTIONAL CEILING LIGHT (RECESSED)
- ⓧ WALL MOUNTED LIGHT
- ⓧ SINGLE SWITCH
- ⓧ 3 WAY SWITCH
- ⓧ DIMMER SWITCH
- ⓧ CABLE TV FIXTURE
- ⓧ RECESSED DOWNLIGHT
- ⓧ TRIS RECESSED DOWNLIGHT
- ⓧ TRIS - A LAMP WALL WASH
- ⓧ TRIS - CORNER WALL WASH
- ⓧ TRIS - LENSED SHOWER LIGHT
- ⓧ TRIS - SLOTTED ACCENT
- ⓧ TRIS - FINICLE
- ⓧ BASIC WALL WASH - RECESSED
- ⓧ BASIC RECESSED SHOWER LIGHT

 
ELECTRICAL PLAN - GENERAL NOTES

- A. ALL SWITCHES ARE MOUNTED AT 36" AFF UNLESS OTHERWISE INDICATED.
- B. ALL ELECTRICAL OUTLETS TO BE MOUNTED HORIZ.
- C. VERIFY EXACT LOCATIONS AND EXACT FIXTURES WITH OWNER.
- D. VERIFY ELECTRICAL REQUIREMENTS AND SWITCH LOCATIONS OF ELEVATOR WITH MANUFACTURER USED.
- E. THE ENTIRETY OF ELECTRICAL OUTLETS IS NOT SHOWN. LOCATIONS OF OUTLETS ARE TO BE DETERMINED BY CODE. THE OUTLETS SHOWN ON THESE DRAWINGS ARE ADDITIONAL OUTLETS DESIGNED BY THE OWNER. FIELD VERIFY LOCATIONS OF ALL OUTLETS WITH OWNER.
- F. ALSO SEE ELEVATIONS FOR EXTERIOR LIGHTING.
- G. ALL EXTERIOR OUTLETS TO BE PROTECTED AS REQD.

ELECTRICAL PLAN - KEYED NOTES

- 1 OUTLETS TO BE MOUNTED ABOVE THE COUNTER (THE DISHWASHER WILL REQUIRE ADDITIONAL POWER)
- 2 APPROX. LOCATION OF ELECTRICAL PANEL

PORT CITY ARCHITECTURE
 65 NEWBURY STREET
 PORTLAND, ME 04101
 207.781.9000
 fax: 207.781.2010
 info@portcityarch.com



CONSULTANTS:

44 FEDERAL STREET CONDOMINIUMS

44 FEDERAL STREET
 Portland, Maine 04101

REVISIONS		
DATE	DATE	DESCRIPTION
2	1-3-06	PERMIT SET
1	6-9-05	REVIEW SET
+		DATE DESCRIPTION

Date Issued	Date - Year
Project Number	04126
Drawing Scale	
SHEET NAME	
ELECT. PLAN UNIT B	
Drawn By	MC
Checked By	ACH
E1.1	

PERMIT SET - NOT FOR CONSTRUCTION