




IF THIS SHEET IS NOT 24 X 36 IT IS A REDUCED SCALE PRINT - SCALE ACCORDINGLY

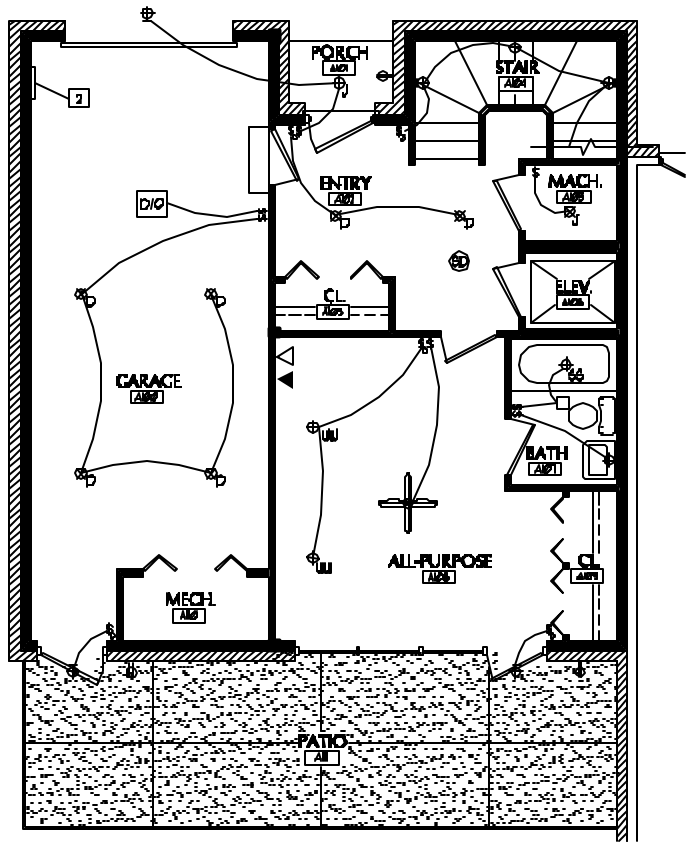


1 ELECT. PLAN - 1st FLOOR
SCALE: 1/4" = 1'-0"

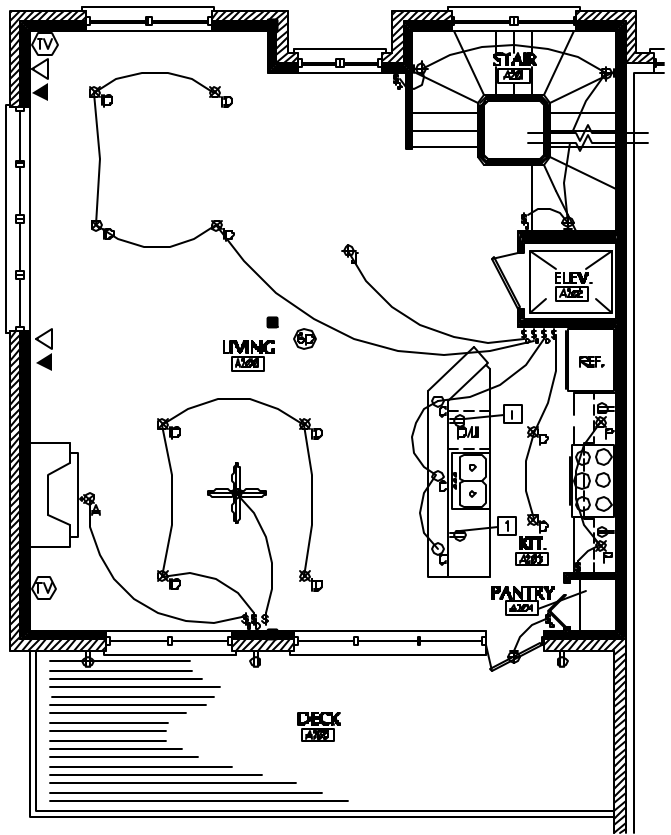

2 ELECT. PLAN - 2nd FLOOR
SCALE: 1/4" = 1'-0"

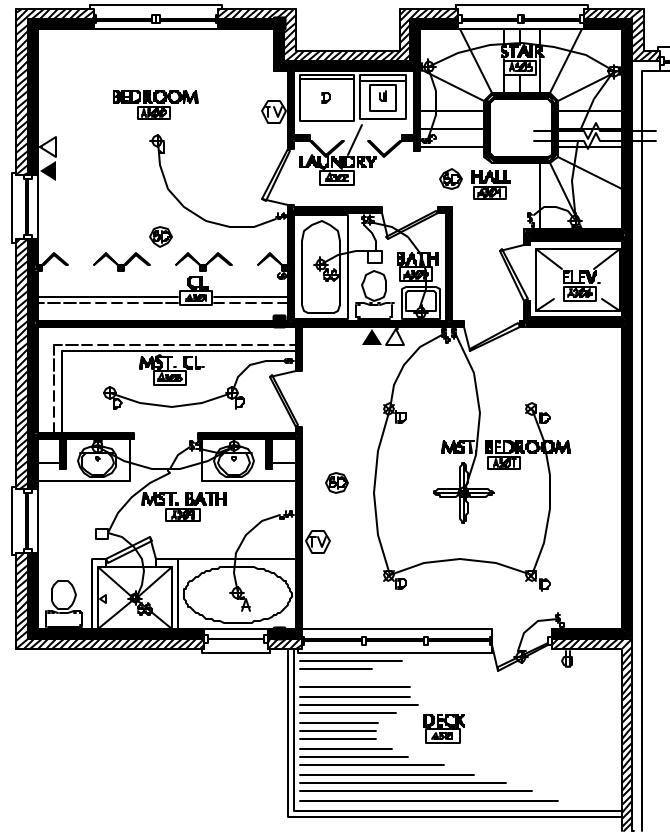

3 ELECT. PLAN - 3rd FLOOR
SCALE: 1/4" = 1'-0"

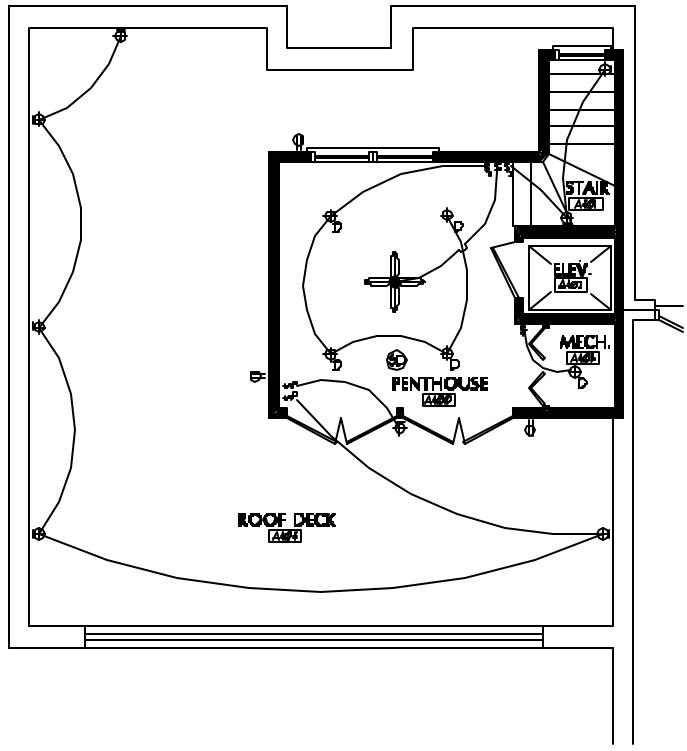

4 FLOOR PLAN - PENTHOUSE
SCALE: 1/4" = 1'-0"

ELECTRICAL KEY


- TV CONNECTION
- POWER OUTLET
- 220 POWER OUTLET
- DATA OUTLET
- TELEPHONE OUTLET
- SMOKE DETECTOR
- EXHAUST FAN
- SURFACE CEILING LIGHT - J BOX
- IRS DIRECTIONAL CEILING LIGHT (RECESSED)
- WALL MOUNTED LIGHT
- SINGLE SWITCH
- 3 WAY SWITCH
- DINNER SWITCH
- CABLE HTD FIXTURE
- RECESSED DOWNLIGHT
- IRS RECESSED DOWNLIGHT
- IRS - A LAMP WALL WASH
- IRS - CORNER WALL WASH
- IRS - LENSED SHOWER LIGHT
- IRS - ALIGNED ACCENT
- IRS - PINACLE
- BASIC WALL WASHER - RECESSED
- BASIC RECESSED SQUARE LIGHT

ELECTRICAL PLAN - GENERAL NOTES

- A. ALL SWITCHES ARE MOUNTED AT 36" AFF. UNLESS OTHERWISE INDICATED.
- B. ALL ELECTRICAL OUTLETS TO BE MOUNTED HORIZ.
- C. VERIFY EXACT LOCATIONS AND EXACT FIXTURES WITH OWNER.
- D. VERIFY ELECTRICAL REQUIREMENTS AND SWITCH LOCATIONS OF ELEVATOR WITH MANUFACTURER USED.
- E. THE ENTIRETY OF ELECTRICAL OUTLETS IS NOT SHOWN. LOCATIONS OF OUTLETS ARE TO BE DETERMINED BY CODE. THE OUTLETS SHOWN ON THESE DRAWINGS ARE ADDITIONAL OUTLETS DEEMED BY THE OWNER. FIELD VERIFY LOCATIONS OF ALL OUTLETS WITH OWNER.
- F. ALSO SEE ELEVATIONS FOR EXTERIOR LIGHTING.
- G. ALL EXTERIOR OUTLETS TO BE PROTECTED AS REQD.

ELECTRICAL PLAN - KEYED NOTES

- 1 OUTLETS TO BE MOUNTED ABOVE THE COUNTER (THE DISHWASHER WILL REQUIRE ADDITIONAL POWER)
- 2 APPROX. LOCATION OF ELECTRICAL PANEL

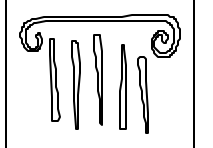

PORT CITY ARCHITECTURE

85 NEWBURY STREET
PORTLAND, ME 04101
207.781.9000
fax 207.781.2010
info@portcityarch.com

CONSULTANTS:

44 FEDERAL STREET CONDOMINIUMS

44 FEDERAL STREET
Portland, Maine 04101

NO.	DATE	DESCRIPTION
3	8-15-06	CONSTRUCTION SET
2	7-11-06	PERMIT SET
1	6-9-06	REVIEW SET

DATE ISSUED	DATE - YEAR

Project Number: 0426
Drawing Scale:
Sheet Name:
ELECT. PLAN UNIT A

Drawn By: MC
Checked By: E1
ACB

CONSTRUCTION SET - FOR CONSTRUCTION