


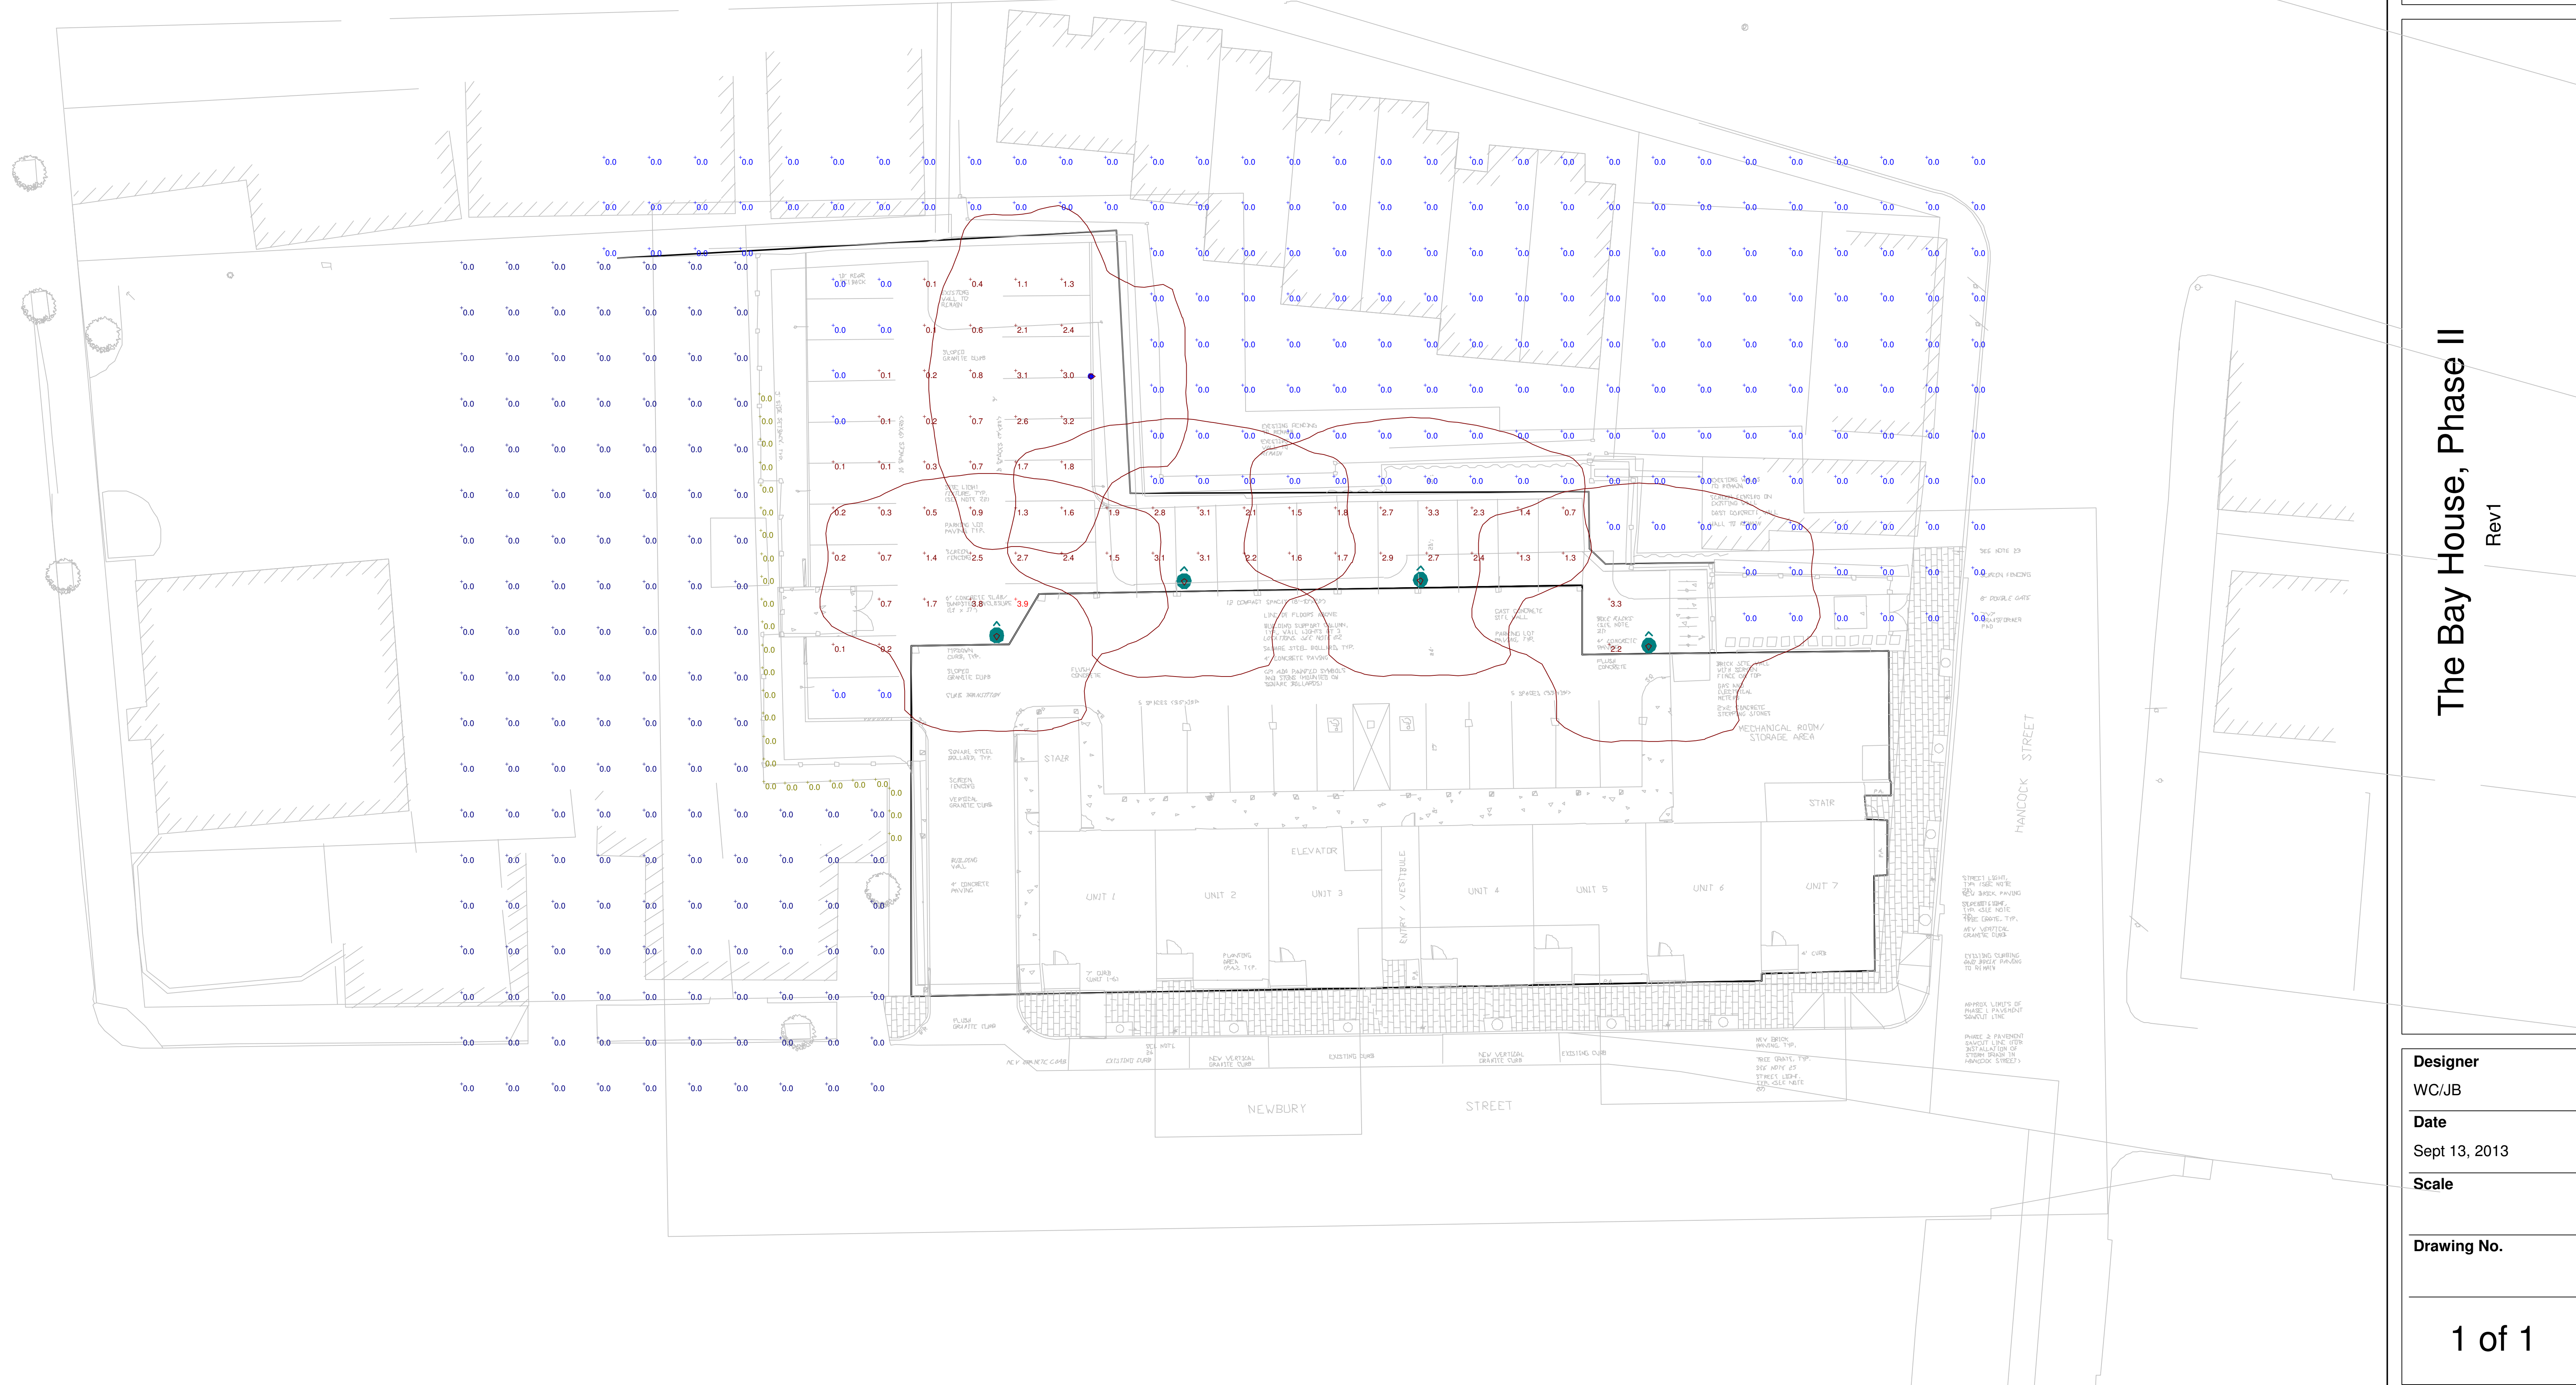

STATISTICS						
Description	Symbol	Avg	Max	Min	Max/Min	Avg/Min
east spill at 0' AFG	+	0.0 fc	0.0 fc	0.0 fc	N/A	N/A
north spill at 12' AFG	+	0.0 fc	0.0 fc	0.0 fc	N/A	N/A
parking lot footcandies	+	1.4 fc	3.9 fc	0.0 fc	N/A	N/A
property line	+	0.0 fc	0.0 fc	0.0 fc	N/A	N/A

LUMINAIRE SCHEDULE							
Symbol	Label	Qty	Catalog Number	Description	Lamp	File	Lumens LLF Watts
●	A	4	PUL0704KASXL3X	Holophane- FCO LED POST TOP SERIES	70W LED ARRAY	PUL0704KASXL3X.ies	Absolute 0.81 70
●	B	1	PUL0704KASXL3X	Holophane- FCO LED POST TOP SERIES	70W LED ARRAY	PUL0704KASXL3X.ies	Absolute 0.81 70



The Bay House, Phase II

Rev1

<b>Designer</b>	WC/JB
<b>Date</b>	Sept 13, 2013
<b>Scale</b>	
<b>Drawing No.</b>	
<b>1 of 1</b>	