

Corey Electric  
609 Main Street #3  
Westbrook, ME 04092

THE VILLAGE AT OCEANGATE, LLC  
c/o Atlas Investments Group  
35 Fay Street Suite 5-2  
Boston, MA 02118


THE BAY HOUSE  
Middle Street  
Portland, Maine

SINGLE LINE  
DIAGRAM  
Scale: NONE  
Commission No: 11-013  
Date: November 29, 2012

REVISIONS:

DRG. NO.

E4.1

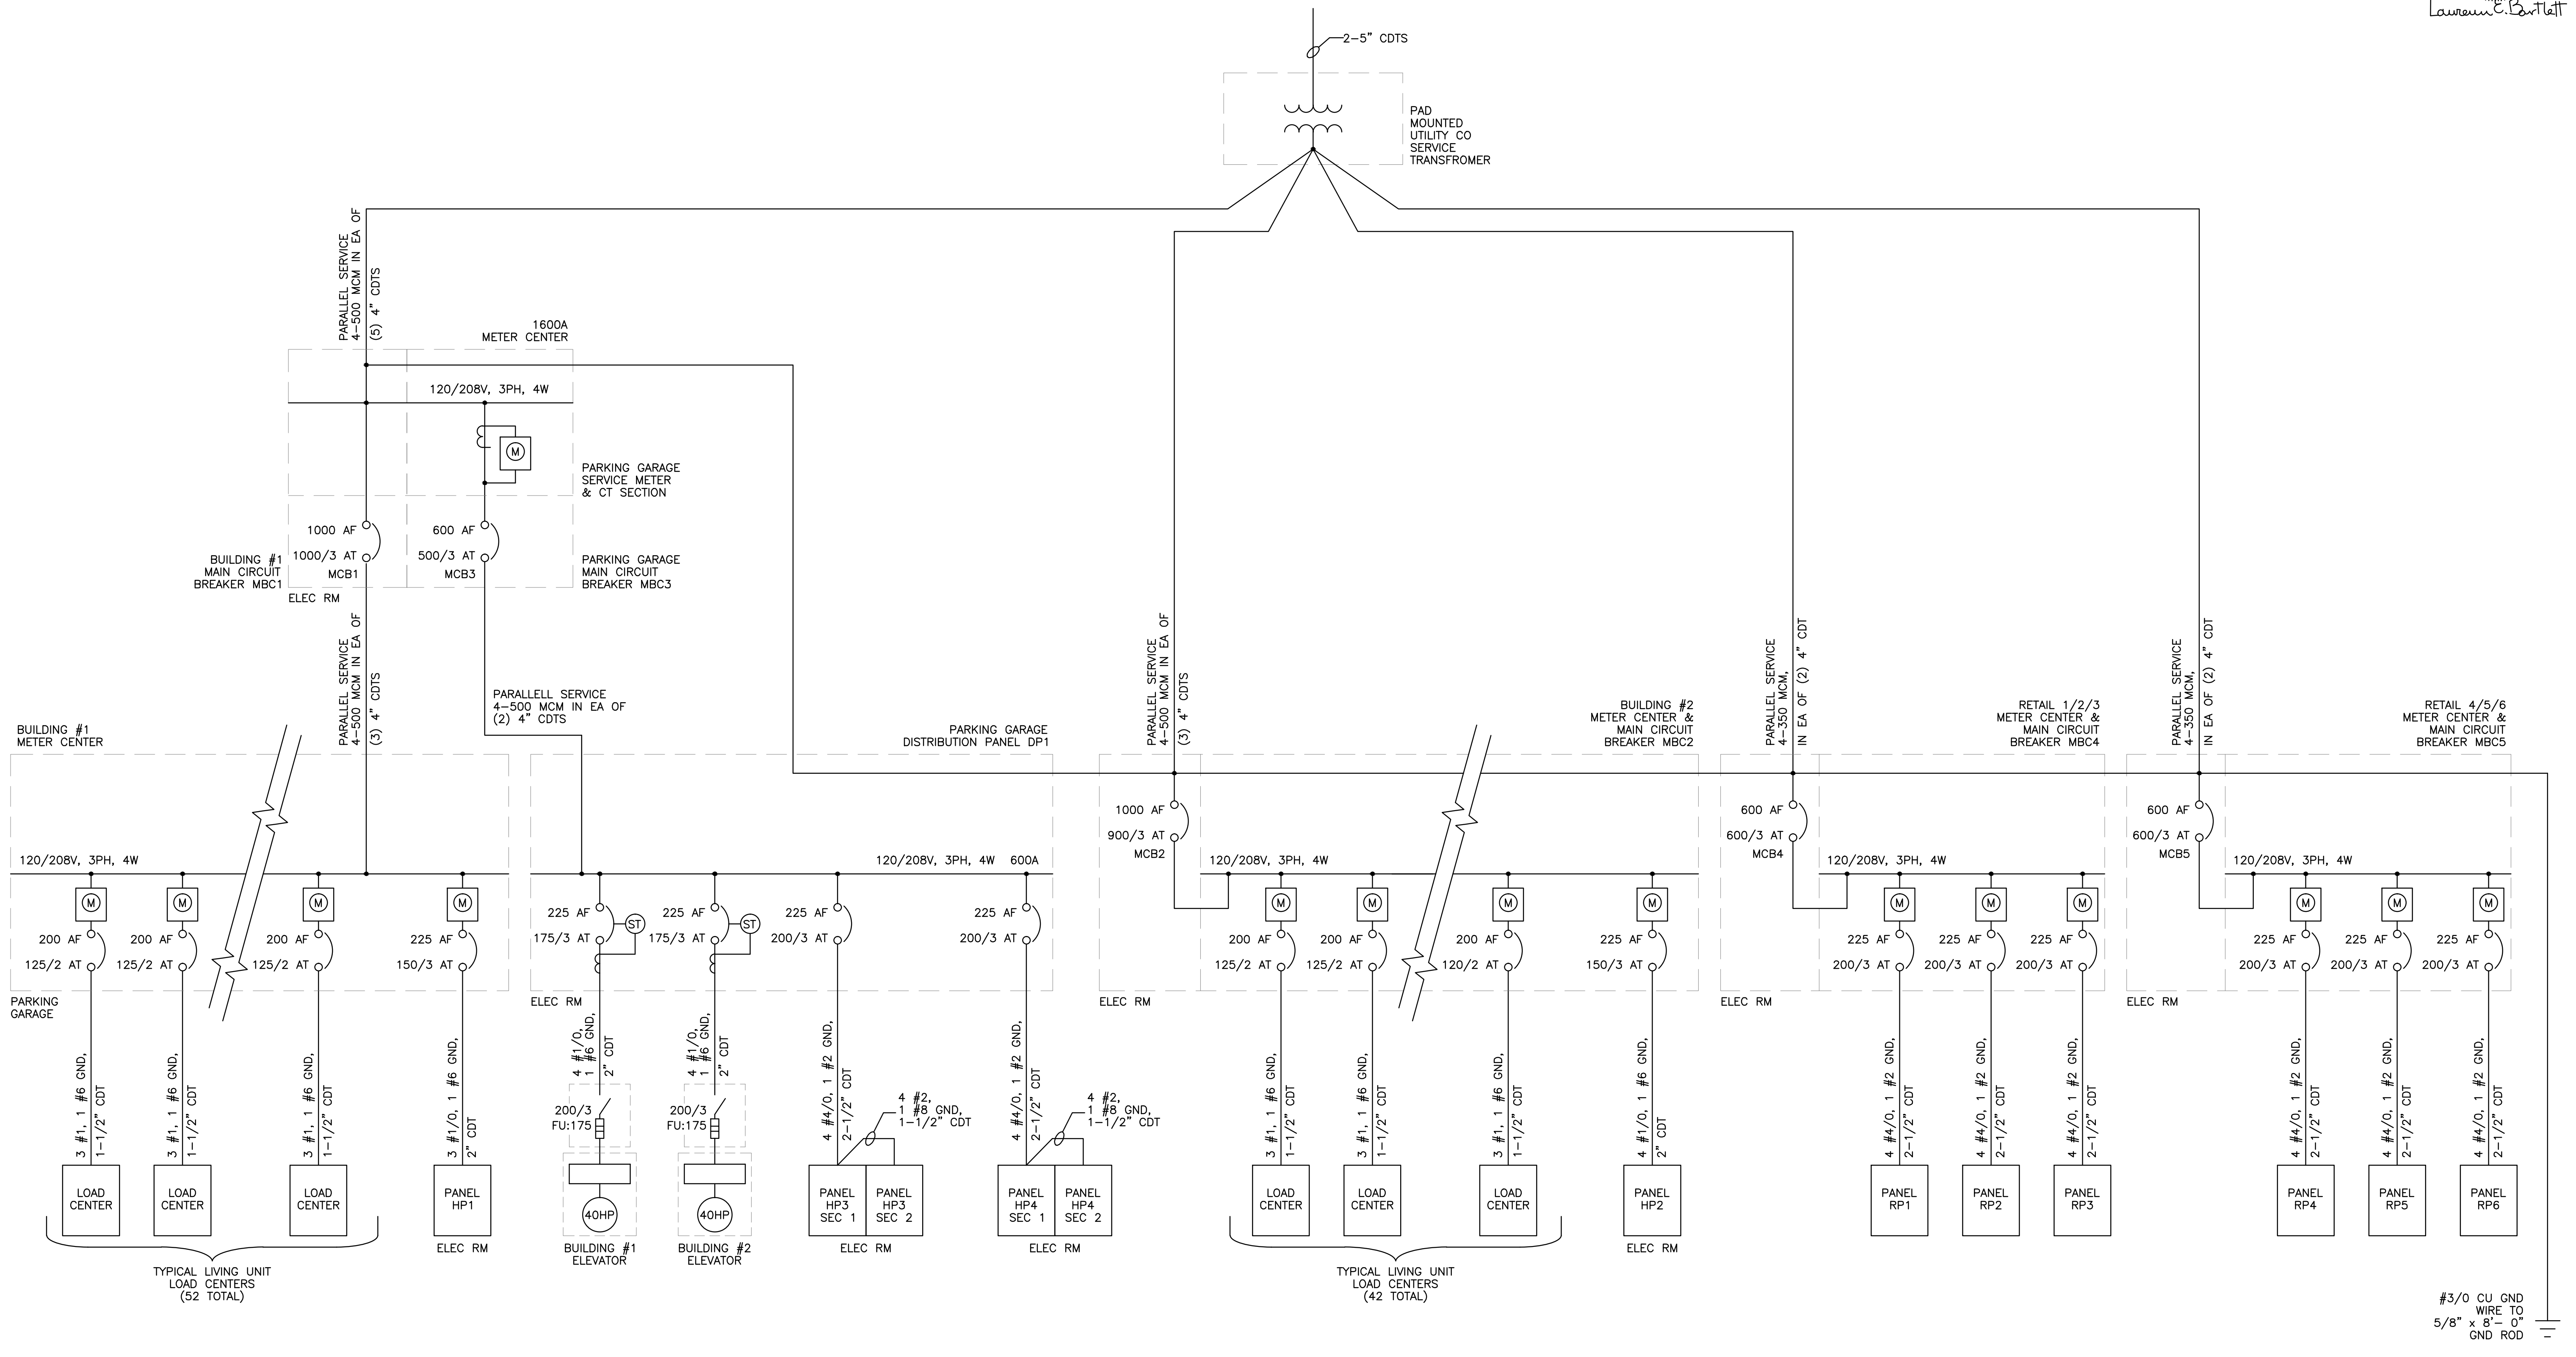

**SINGLE LINE DIAGRAM**

NOT TO SCALE

NOTE:  
PROVIDE GROUNDING PER NFPA 70 ARTICLE 250 FOR EACH SERVICE ENTRANCE. PROVIDE 5/8" x 8'-0" GROUND RODS WITH #3/0 COPPER GROUNDING CONDUCTORS.

#3/0 CU GND WIRE TO 0" GND ROD