

Revisions:
11/29/2012 - UNDERSLAB PIPING FOR
CONSTRUCTION FOR PERMIT.
12/14/2012 - FOR PERMIT.

Bay House
Portland, ME


BENNETT ENGINEERING
MECHANICAL • ELECTRICAL
(207) 865-9475

Job No.: 3346
Date: 12/4/12
Scale: 1/8" = 1'-0" or A.N.
Drawn by: SF Doel
Checked by: SF Doel

Drawing Title:
**HVAC Third Floor
Plan Building "1"**

**Atlantic Comfort
Systems, Inc.**
Mechanical Contractor • 207-884-4390
882 Hill Street, Biddeford, ME 04005
www.atlanticcomfort.com

M.3

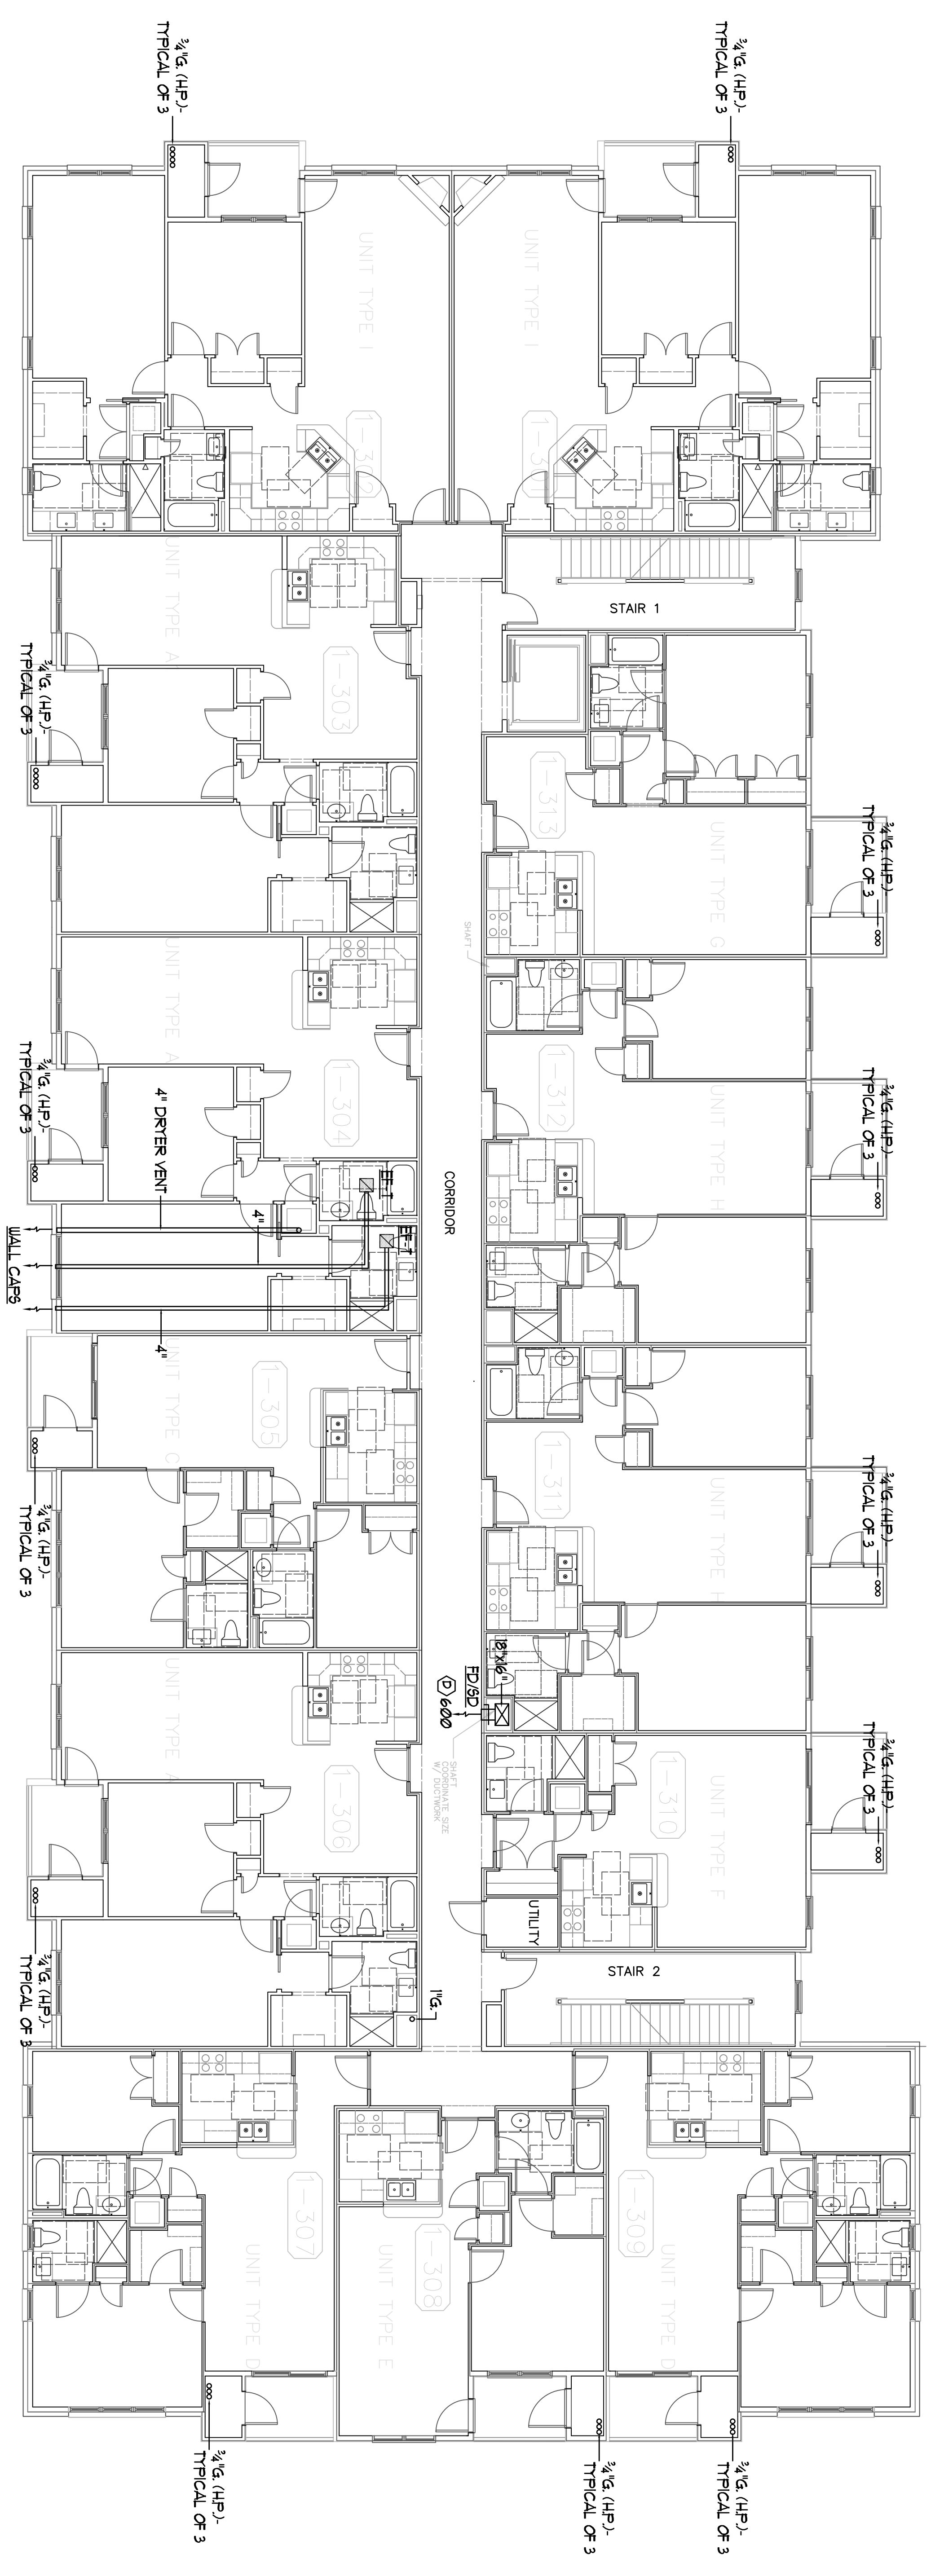

**3rd FLOOR PLAN
BUILDING 1**
SCALE: 1/8" = 1'-0"

DATE