

Revisions:  
11/29/2012 - UNDER LAB PIPING FOR  
CONSTRUCTION  
12/14/2012 - FOR PERMIT.

Bay House  
Portland, ME




**BENNETT**  
ENGINEERING  
MECHANICAL • ELECTRICAL  
(207) 865-9475

Job No.: 3346  
Date: 12/14/12  
Scale: 1/8" = 1'-0" or A.N.  
Drawn by: SF Doel  
Checked by: SF Doel

Drawing Title:  
HVAC Fourth Floor  
Plan Building "1"

**M.4**

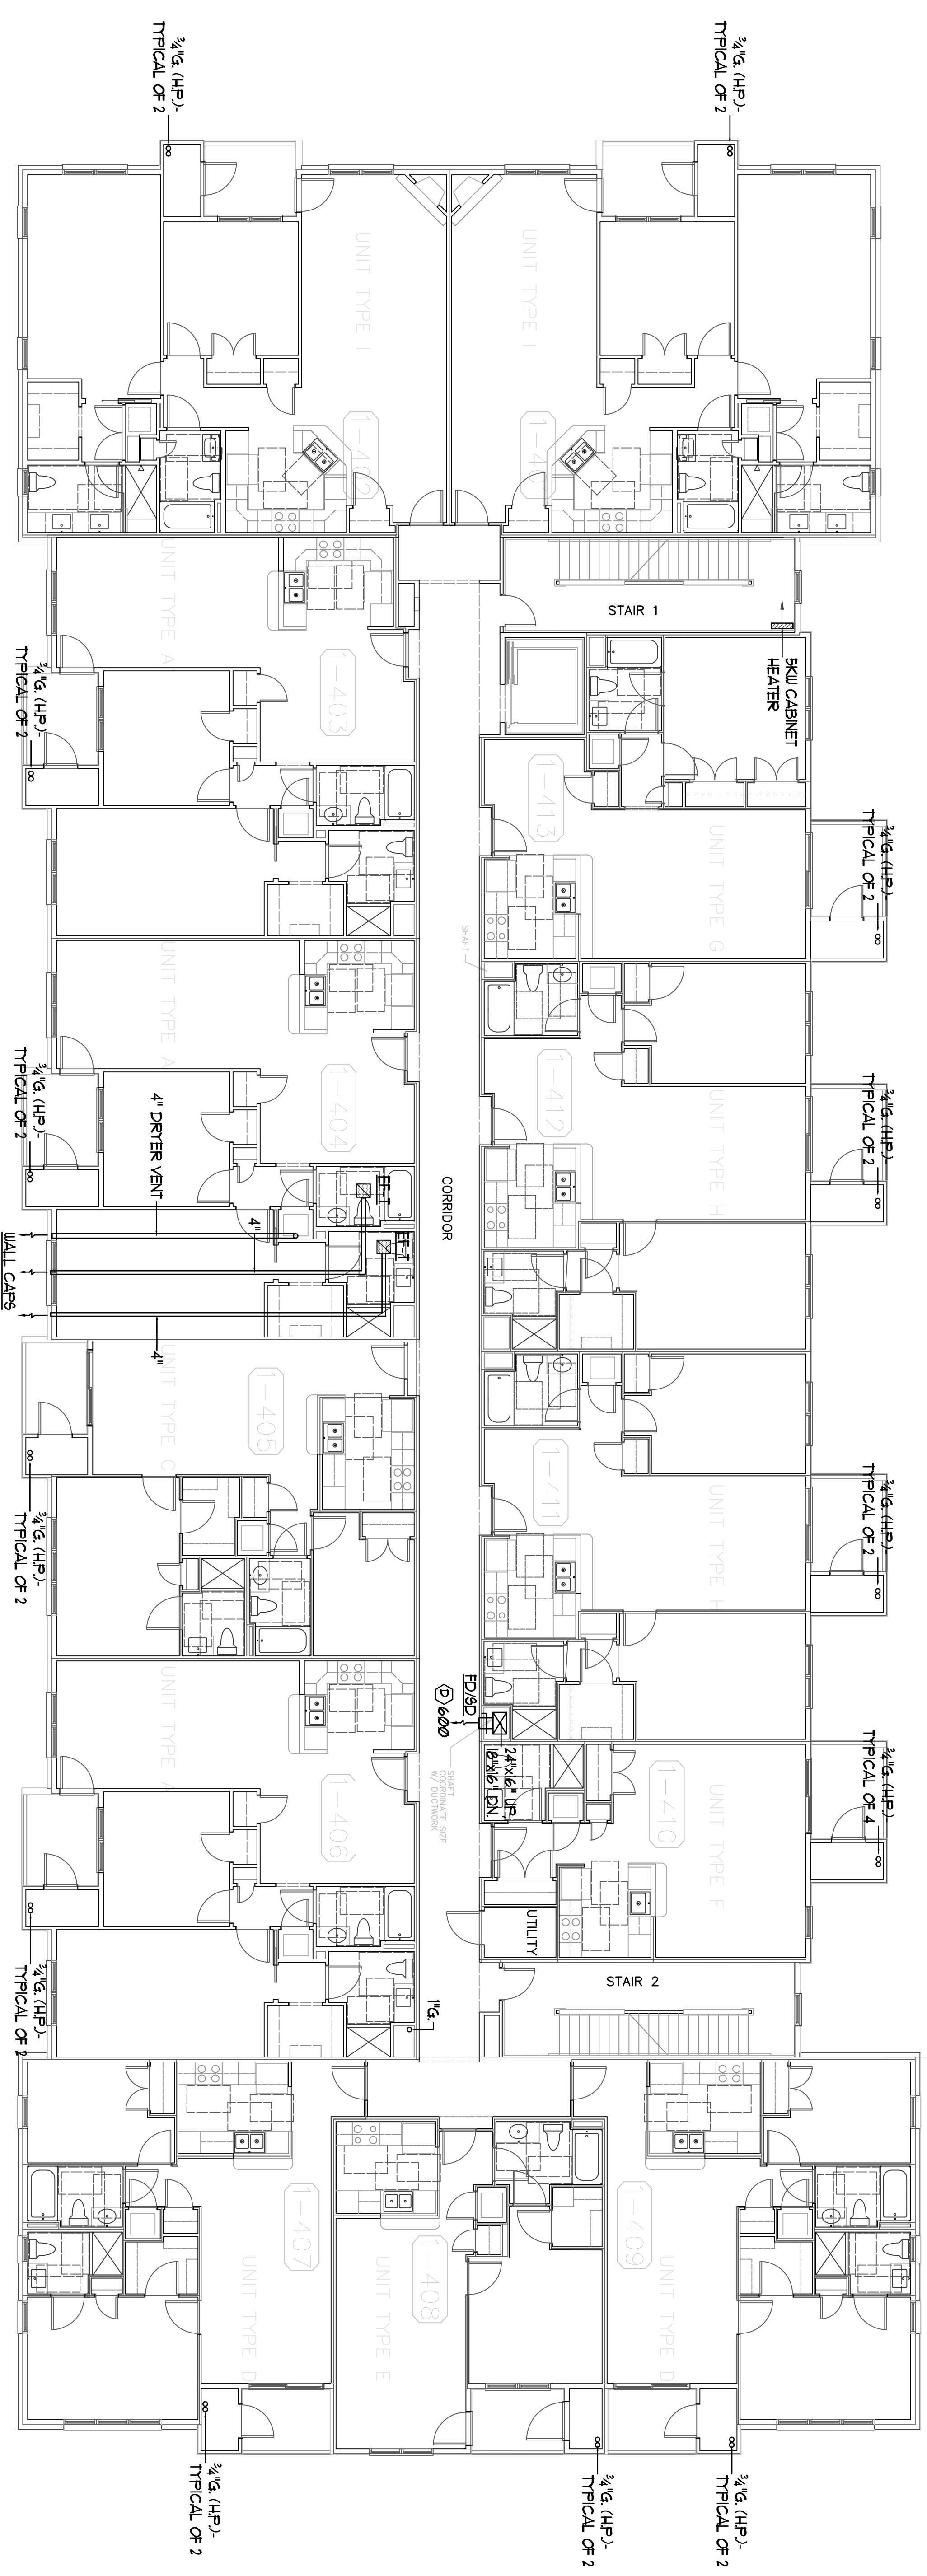

4th FLOOR PLAN  
BUILDING 1  
SCALE: 1/8" = 1' 0"

**Atlantic Comfort**  
Systems, Inc.  
Mechanical Contractors • 507-284-4390  
882 Hill Street, Biddeford, ME 04005  
www.atlanticcomfort.com