

Revisions:
11/29/2012-INDERS, LAB PIPING FOR
CONSTRUCTION FOR PERMIT.
12/14/2012-

Bay House
Portland, ME




**BENNETT
ENGINEERING**
MECHANICAL • ELECTRICAL
(207) 865-9475

Job No.: 3346
Date: 12/4/12
Scale: 1/8" = 1'-0" or A.N.
Drawn by: SF Doel
Checked by: SF Doel

Drawing Title:
HVAC Fifth Floor
Plan Building "1"

M.5

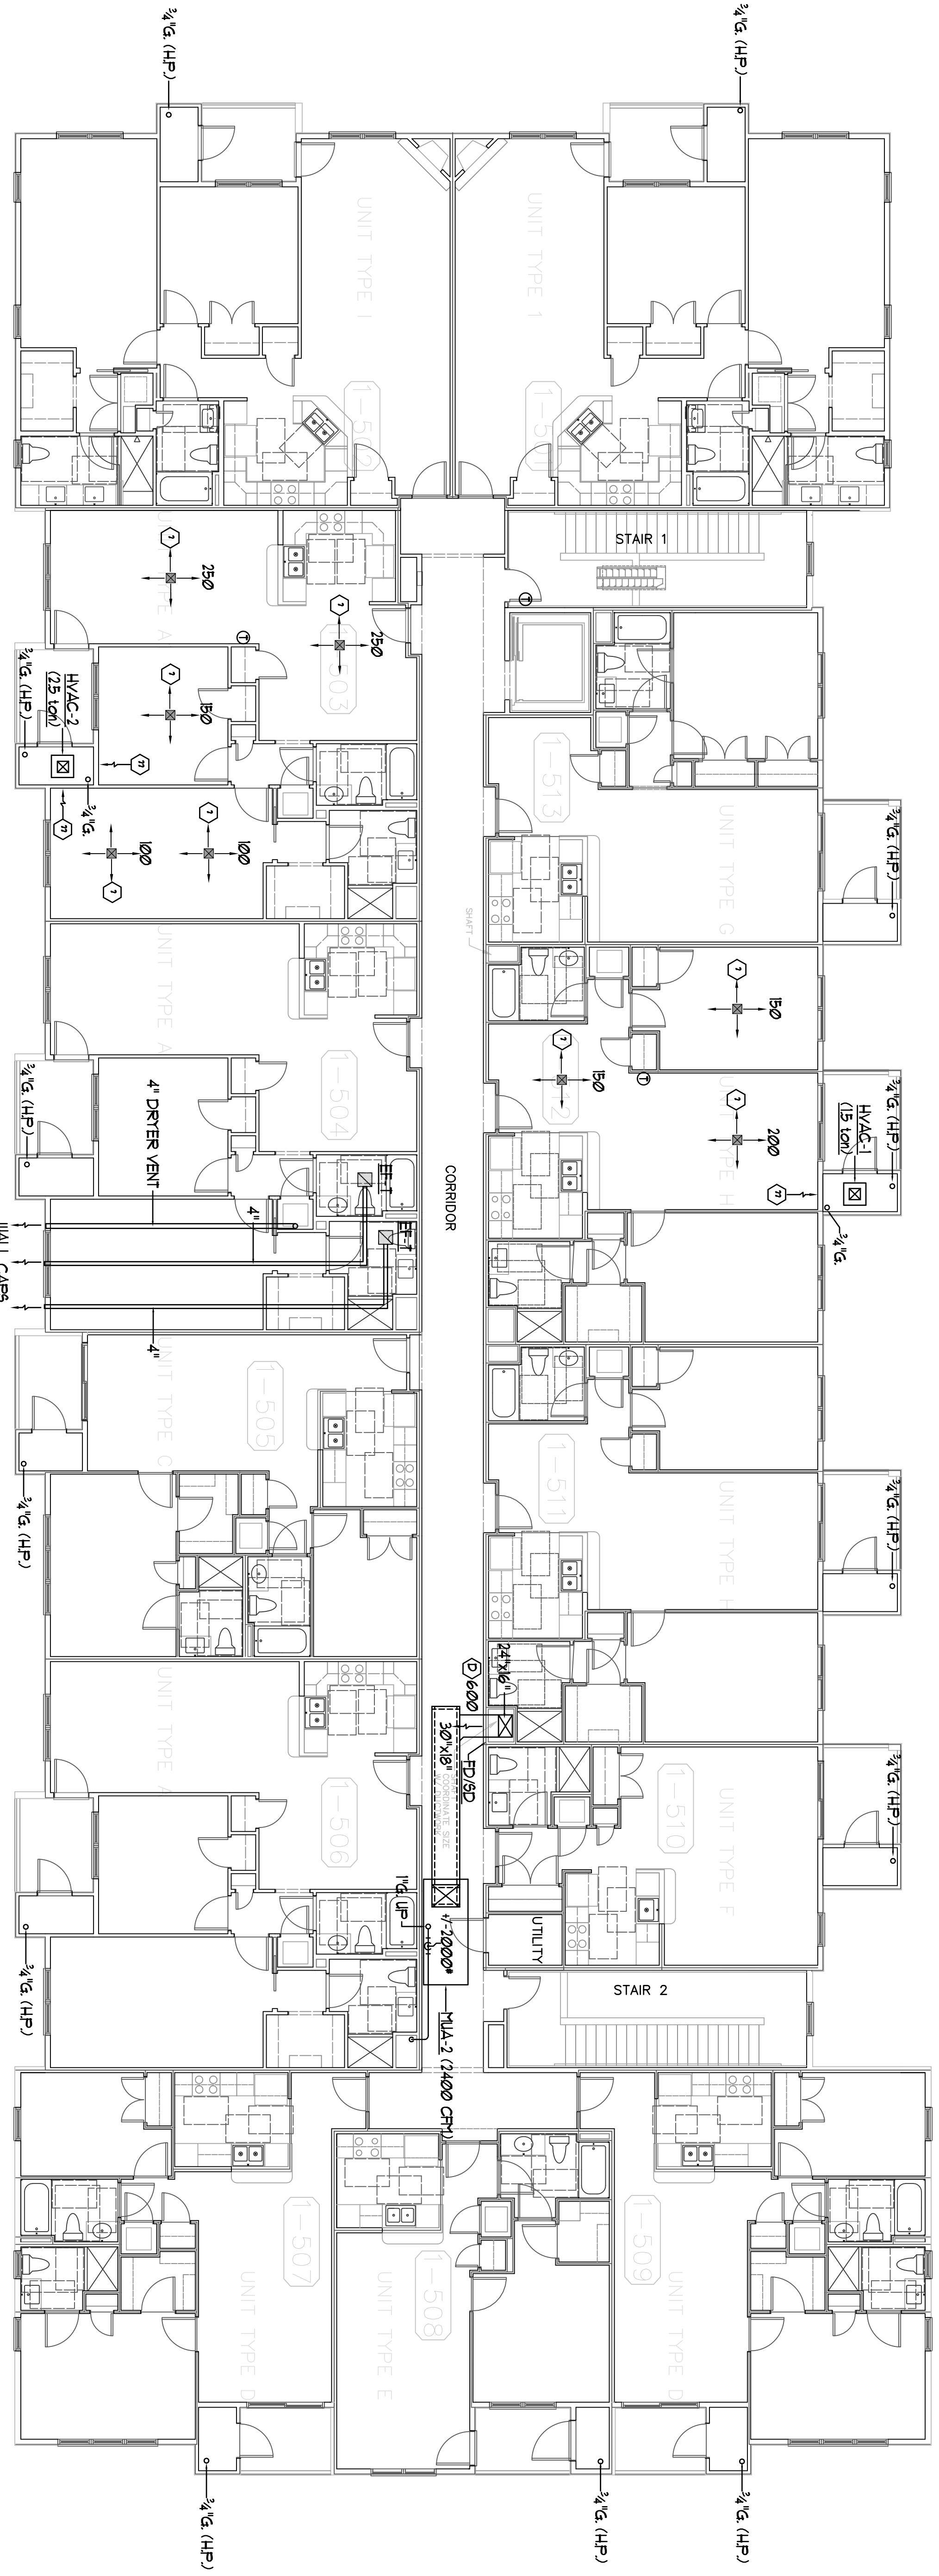

General Notes
1. Ceiling diffusers shall have ceiling fire dampers (CFD) with volume control.

**5th FLOOR PLAN
BUILDING 1**
SCALE: 1/8" = 1' 0"

**Atlantic Comfort
Systems, Inc.**
Mechanical Contractor • 207-884-4390
882 Hill Street, Portland, ME 04105
www.atlanticcomfort.com