





Revisions
11/29/2012-INDERS LAB PIPING FOR
CONSTRUCTION- FOR PERMIT.
12/14/2012- FOR PERMIT.

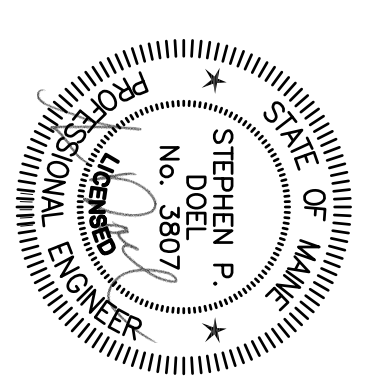

Bay House
Portland, ME

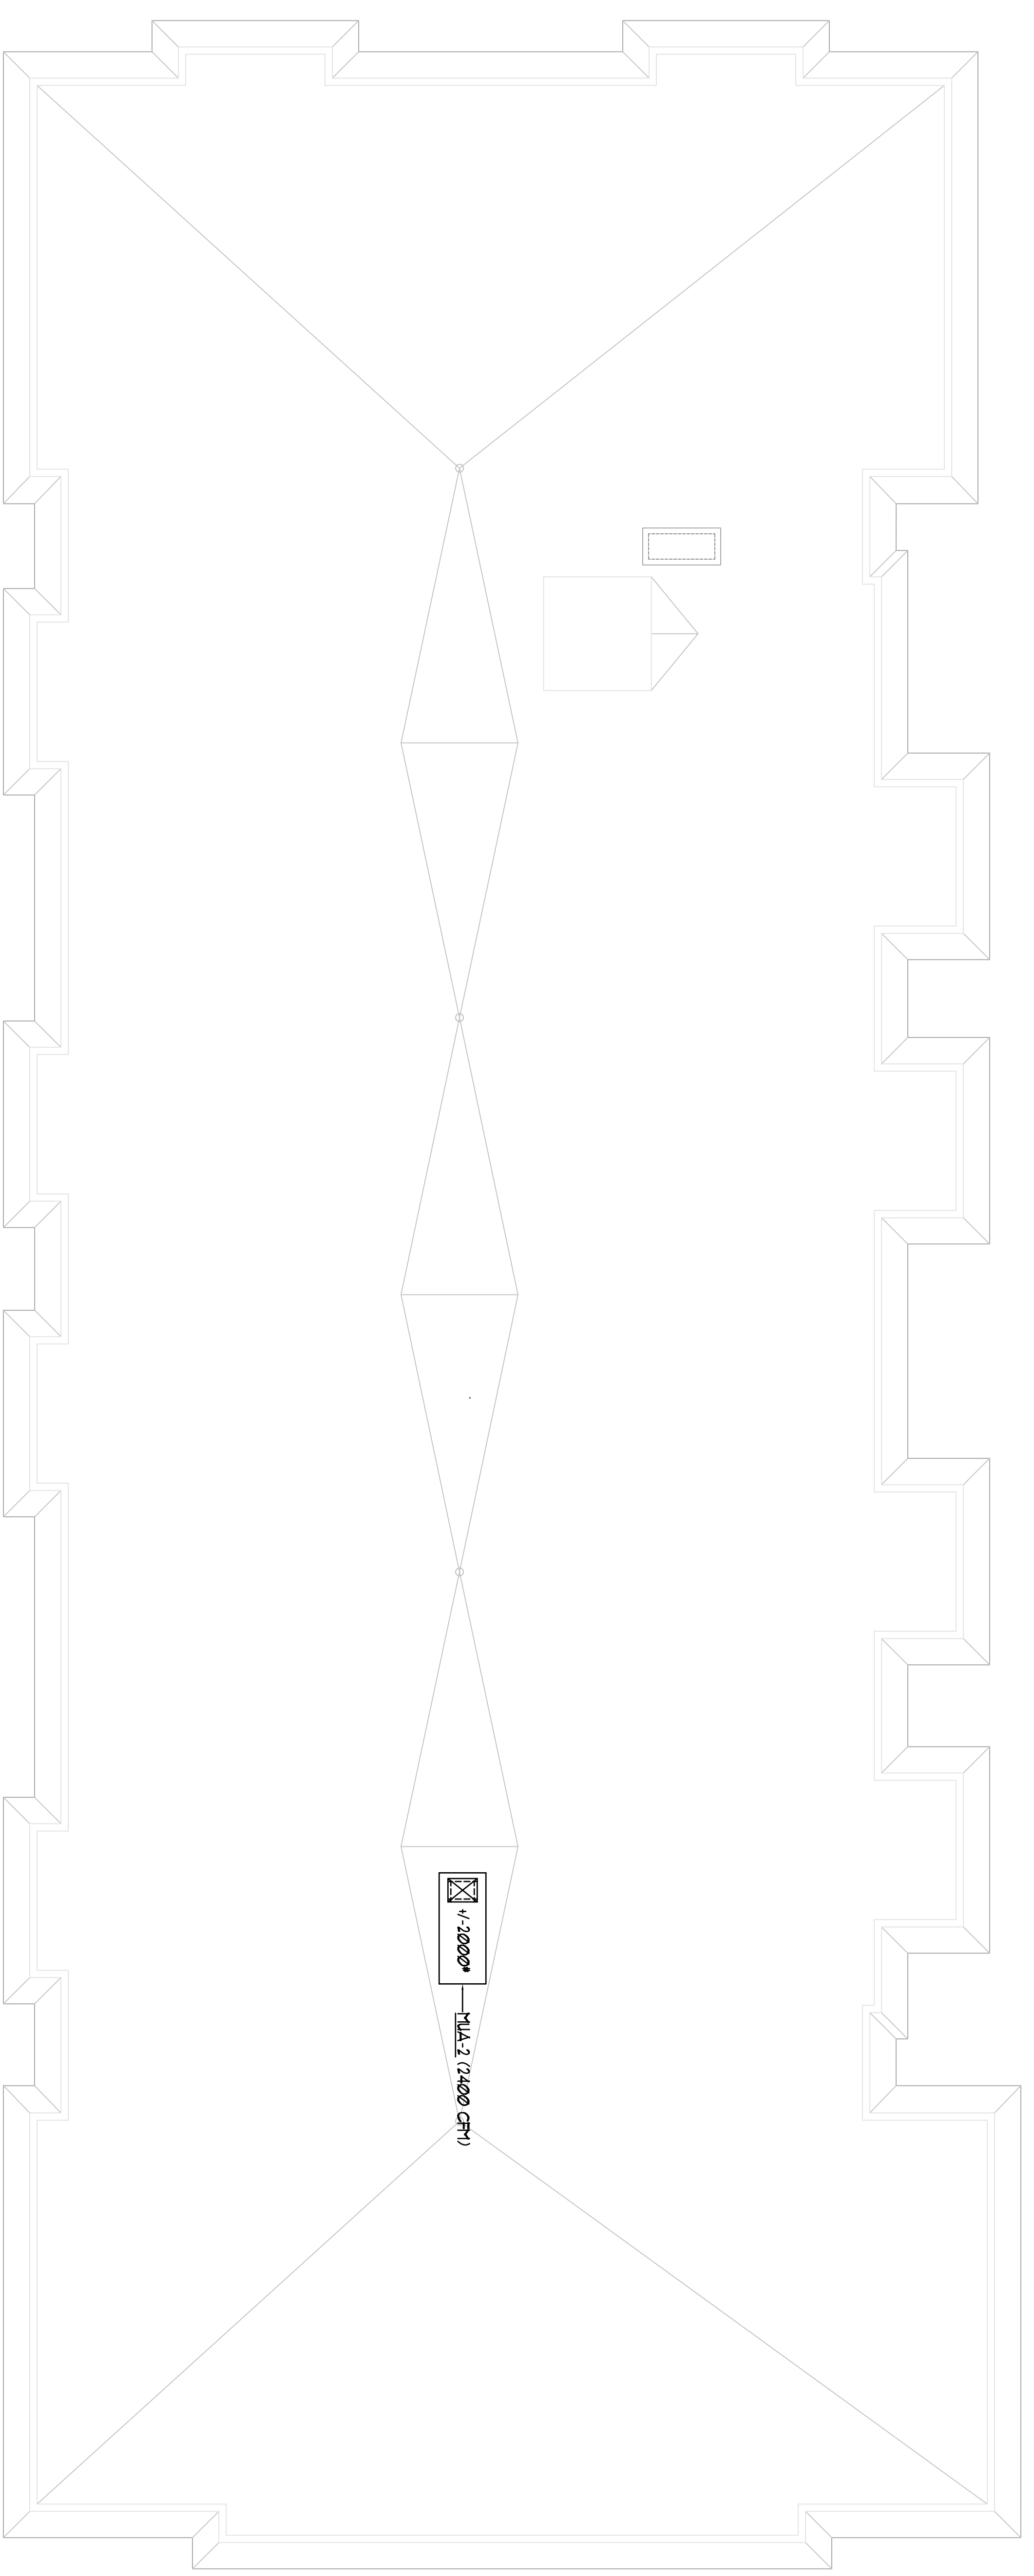

ROOF PLAN BUILDING 1

SCALE: 1/8" = 1' 0"

**Atlantic Comfort
Systems, Inc.**
Mechanical Contractor • 807-884-4390
882 Hill Street, Biddeford, ME 04005
www.atlanticcomfort.com

**BENNETT
ENGINEERING**
MECHANICAL • ELECTRICAL
(207) 865-9475

Job No.: 3346
Date: 12/4/12
Scale: 1/8" = 1'-0" or A.N.
Drawn by: SF Doel
Checked by: SF Doel

Drawing Title:
HVAC Roof Plan
Building "1"

M.6