

Revisions:  
11/29/2012-UNDERSLAB PIPING FOR  
CONSTRUCTION FOR PERMIT.  
12/14/2012-

Bay House  
Portland, ME




**BENNETT  
ENGINEERING**  
MECHANICAL • ELECTRICAL  
(207) 865-9475

Job No.: 3346  
Date: 12/14/12  
Scale: 1/8" = 1'-0" or A.N.  
Drawn by: SF Doel  
Checked by: SF Doel

Drawing Title:  
**Pumbing Roof Plan  
Building "2"**

# ROOF PLAN BUILDING 2

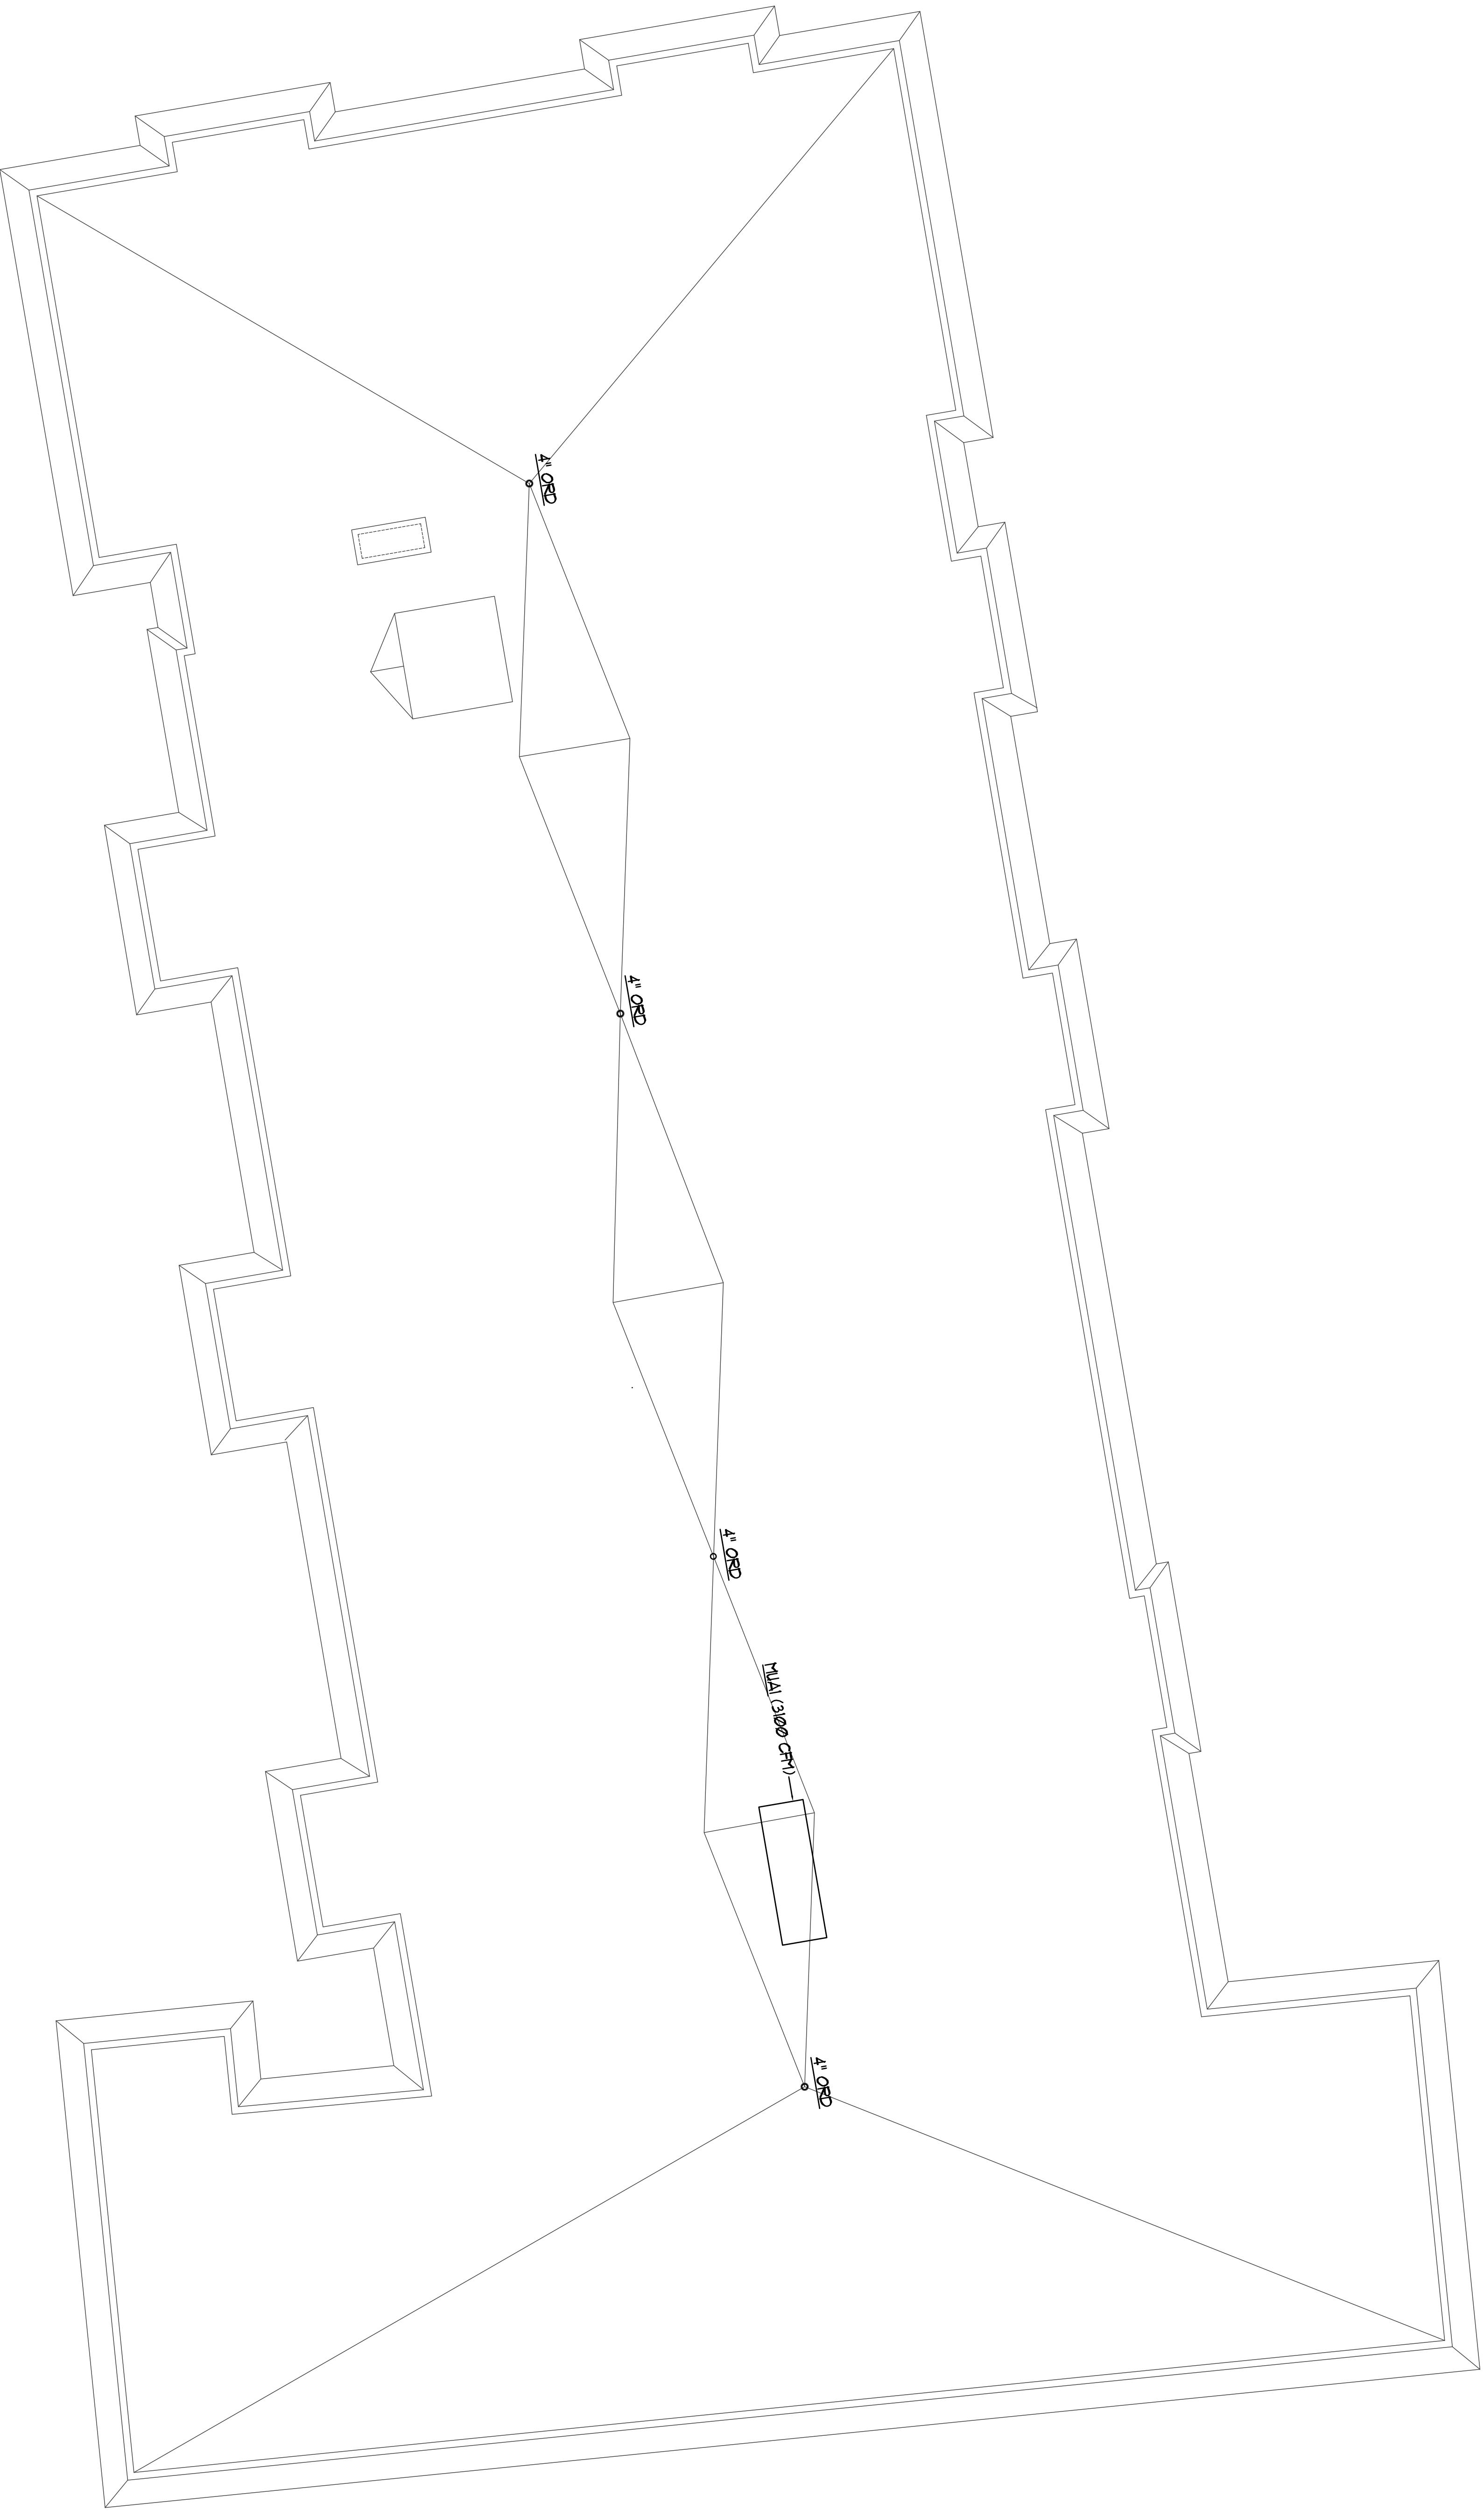

**Atlantic Comfort  
Systems, Inc.**  
Mechanical Contractor • 807-894-4390  
882 Hill Street, Portland, ME 04105  
www.atlanticcomfort.com

# P.12