

Revisions:  
 11/29/2012 - UNDERSLAB PIPING FOR  
 CONSTRUCTION - FOR PERMIT.  
 12/14/2012 - FOR PERMIT.

Bay House  
 Portland, ME




**BENNETT  
 ENGINEERING**  
 MECHANICAL • ELECTRICAL  
 (207) 865-9475


Job No.: 3346  
 Date: 12/14/12  
 Scale: 1/8" = 1'-0" or A.N.  
 Drawn by: SF Doel  
 Checked by: SF Doel

Drawing Title:  
 Unit Plans

**P.13**

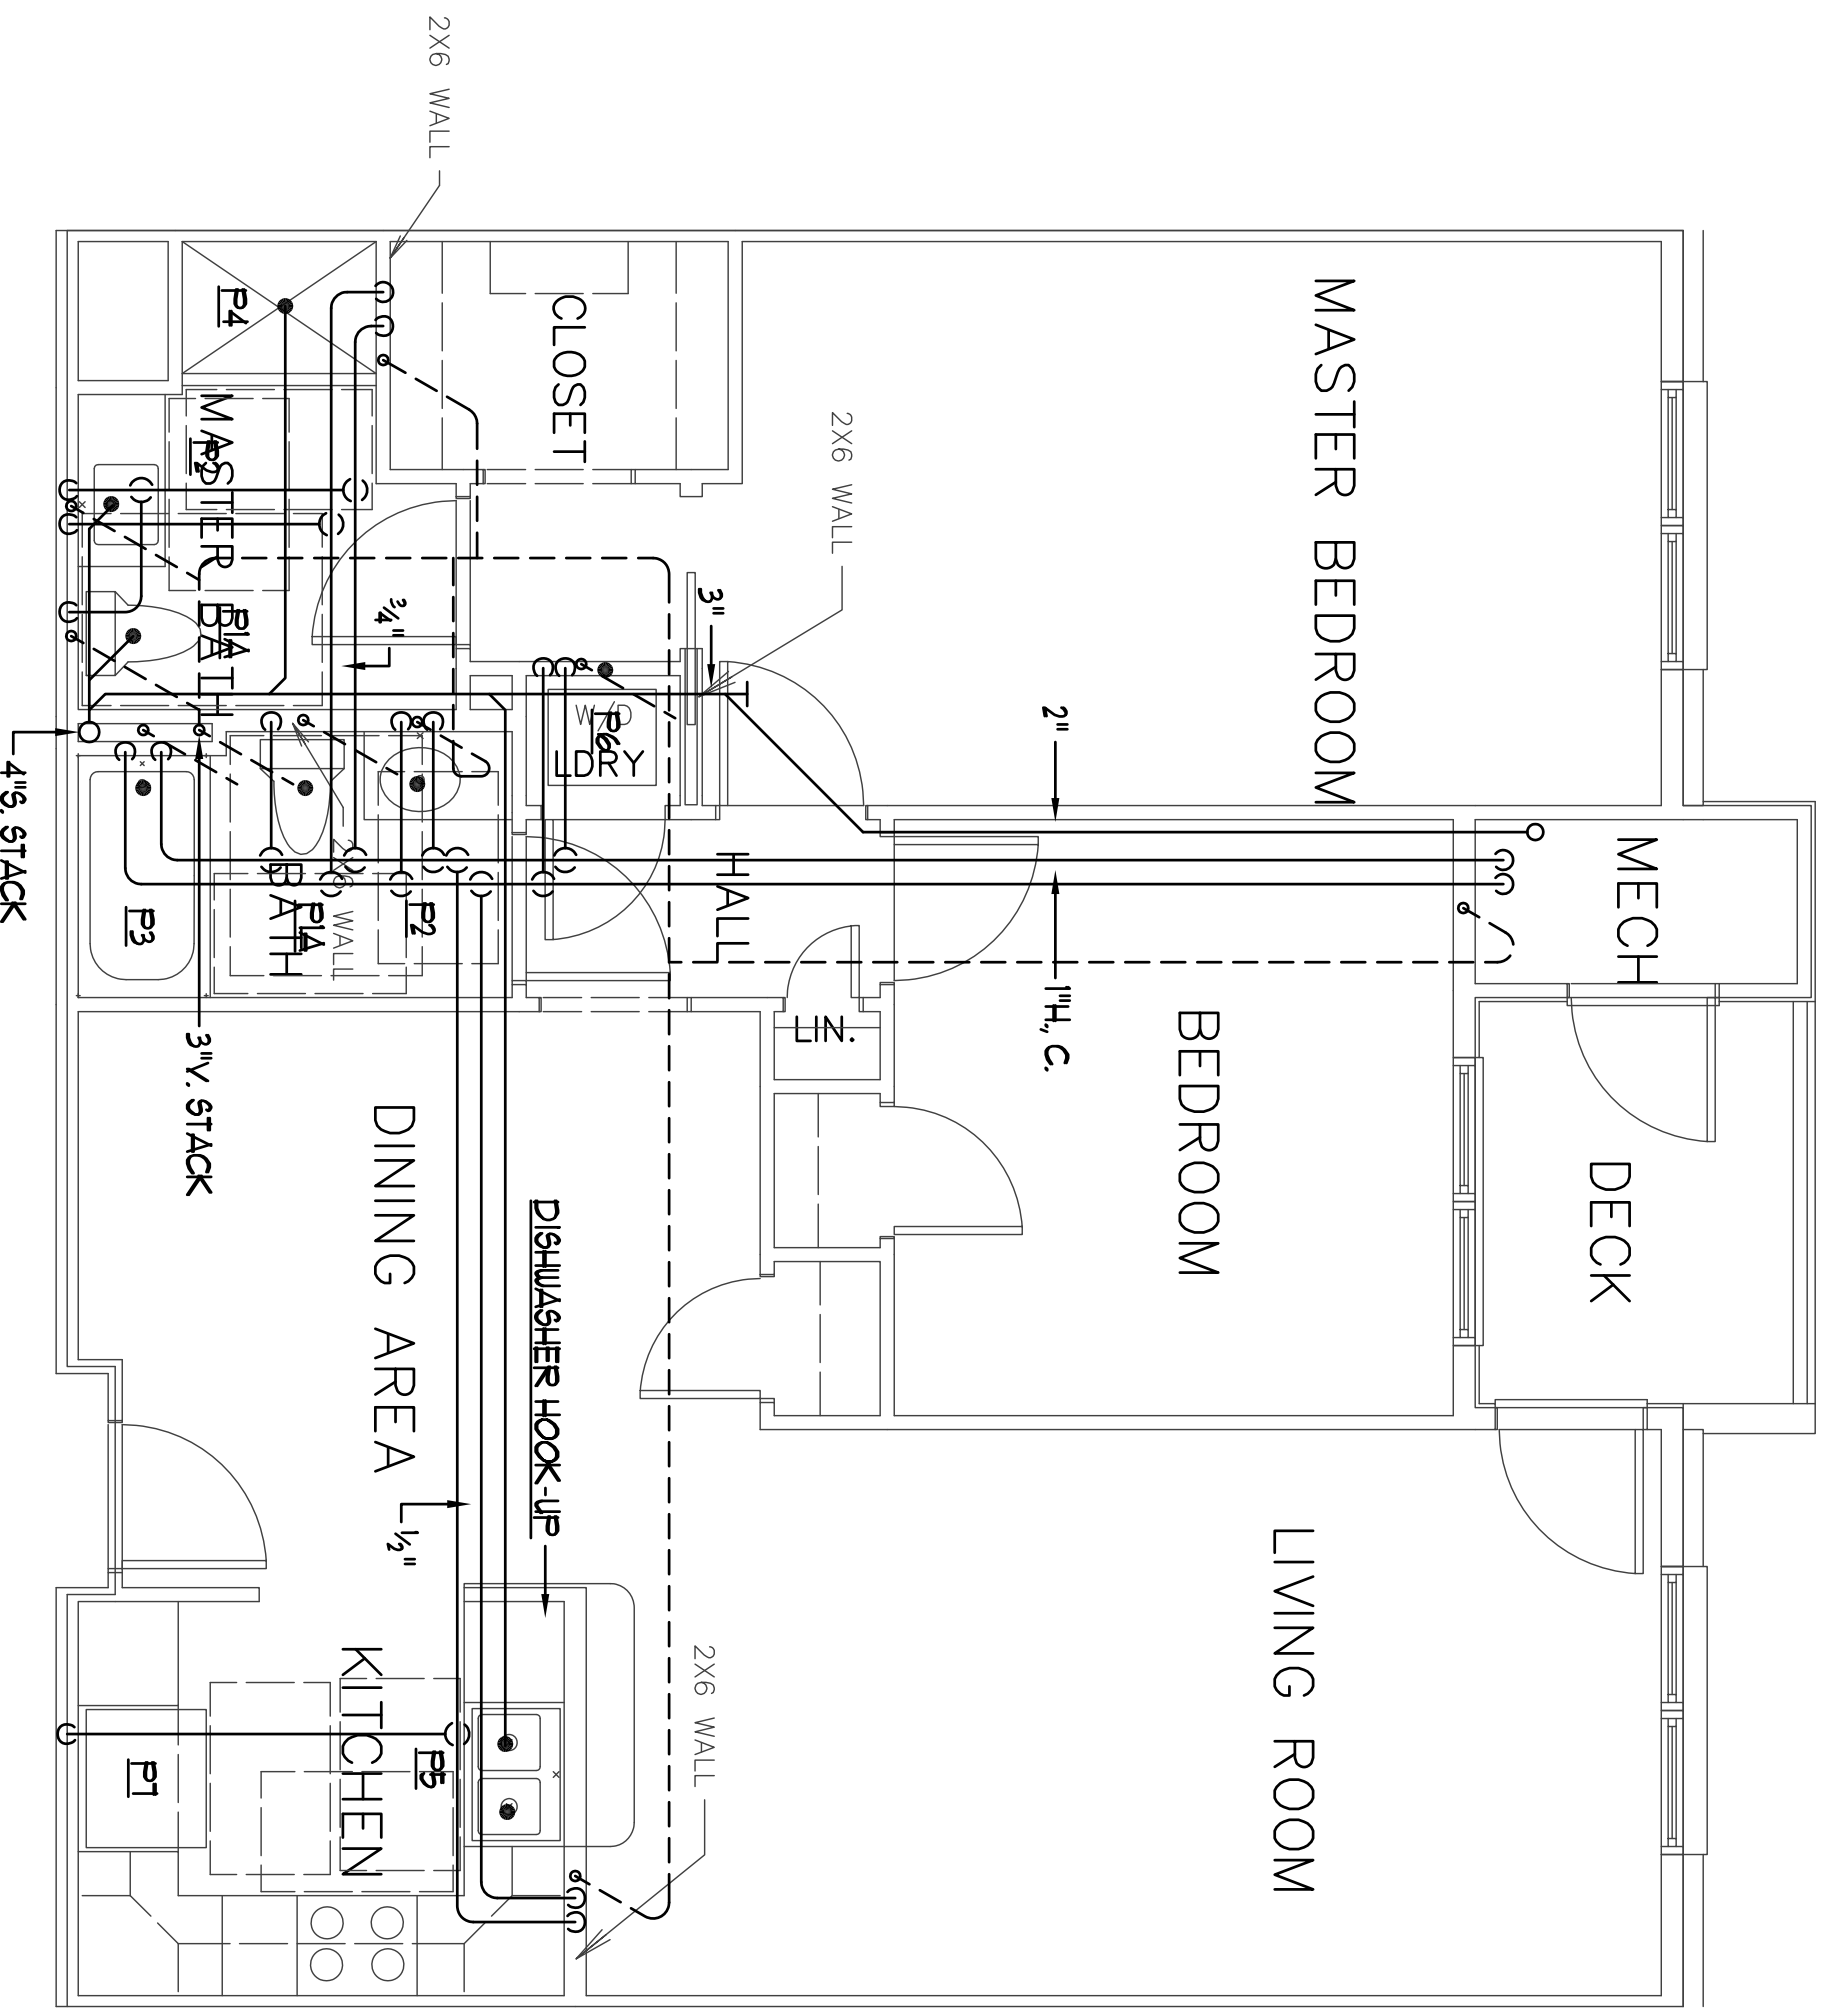

UNIT TYPE A  
 SCALE: 1/4" = 1' 0"

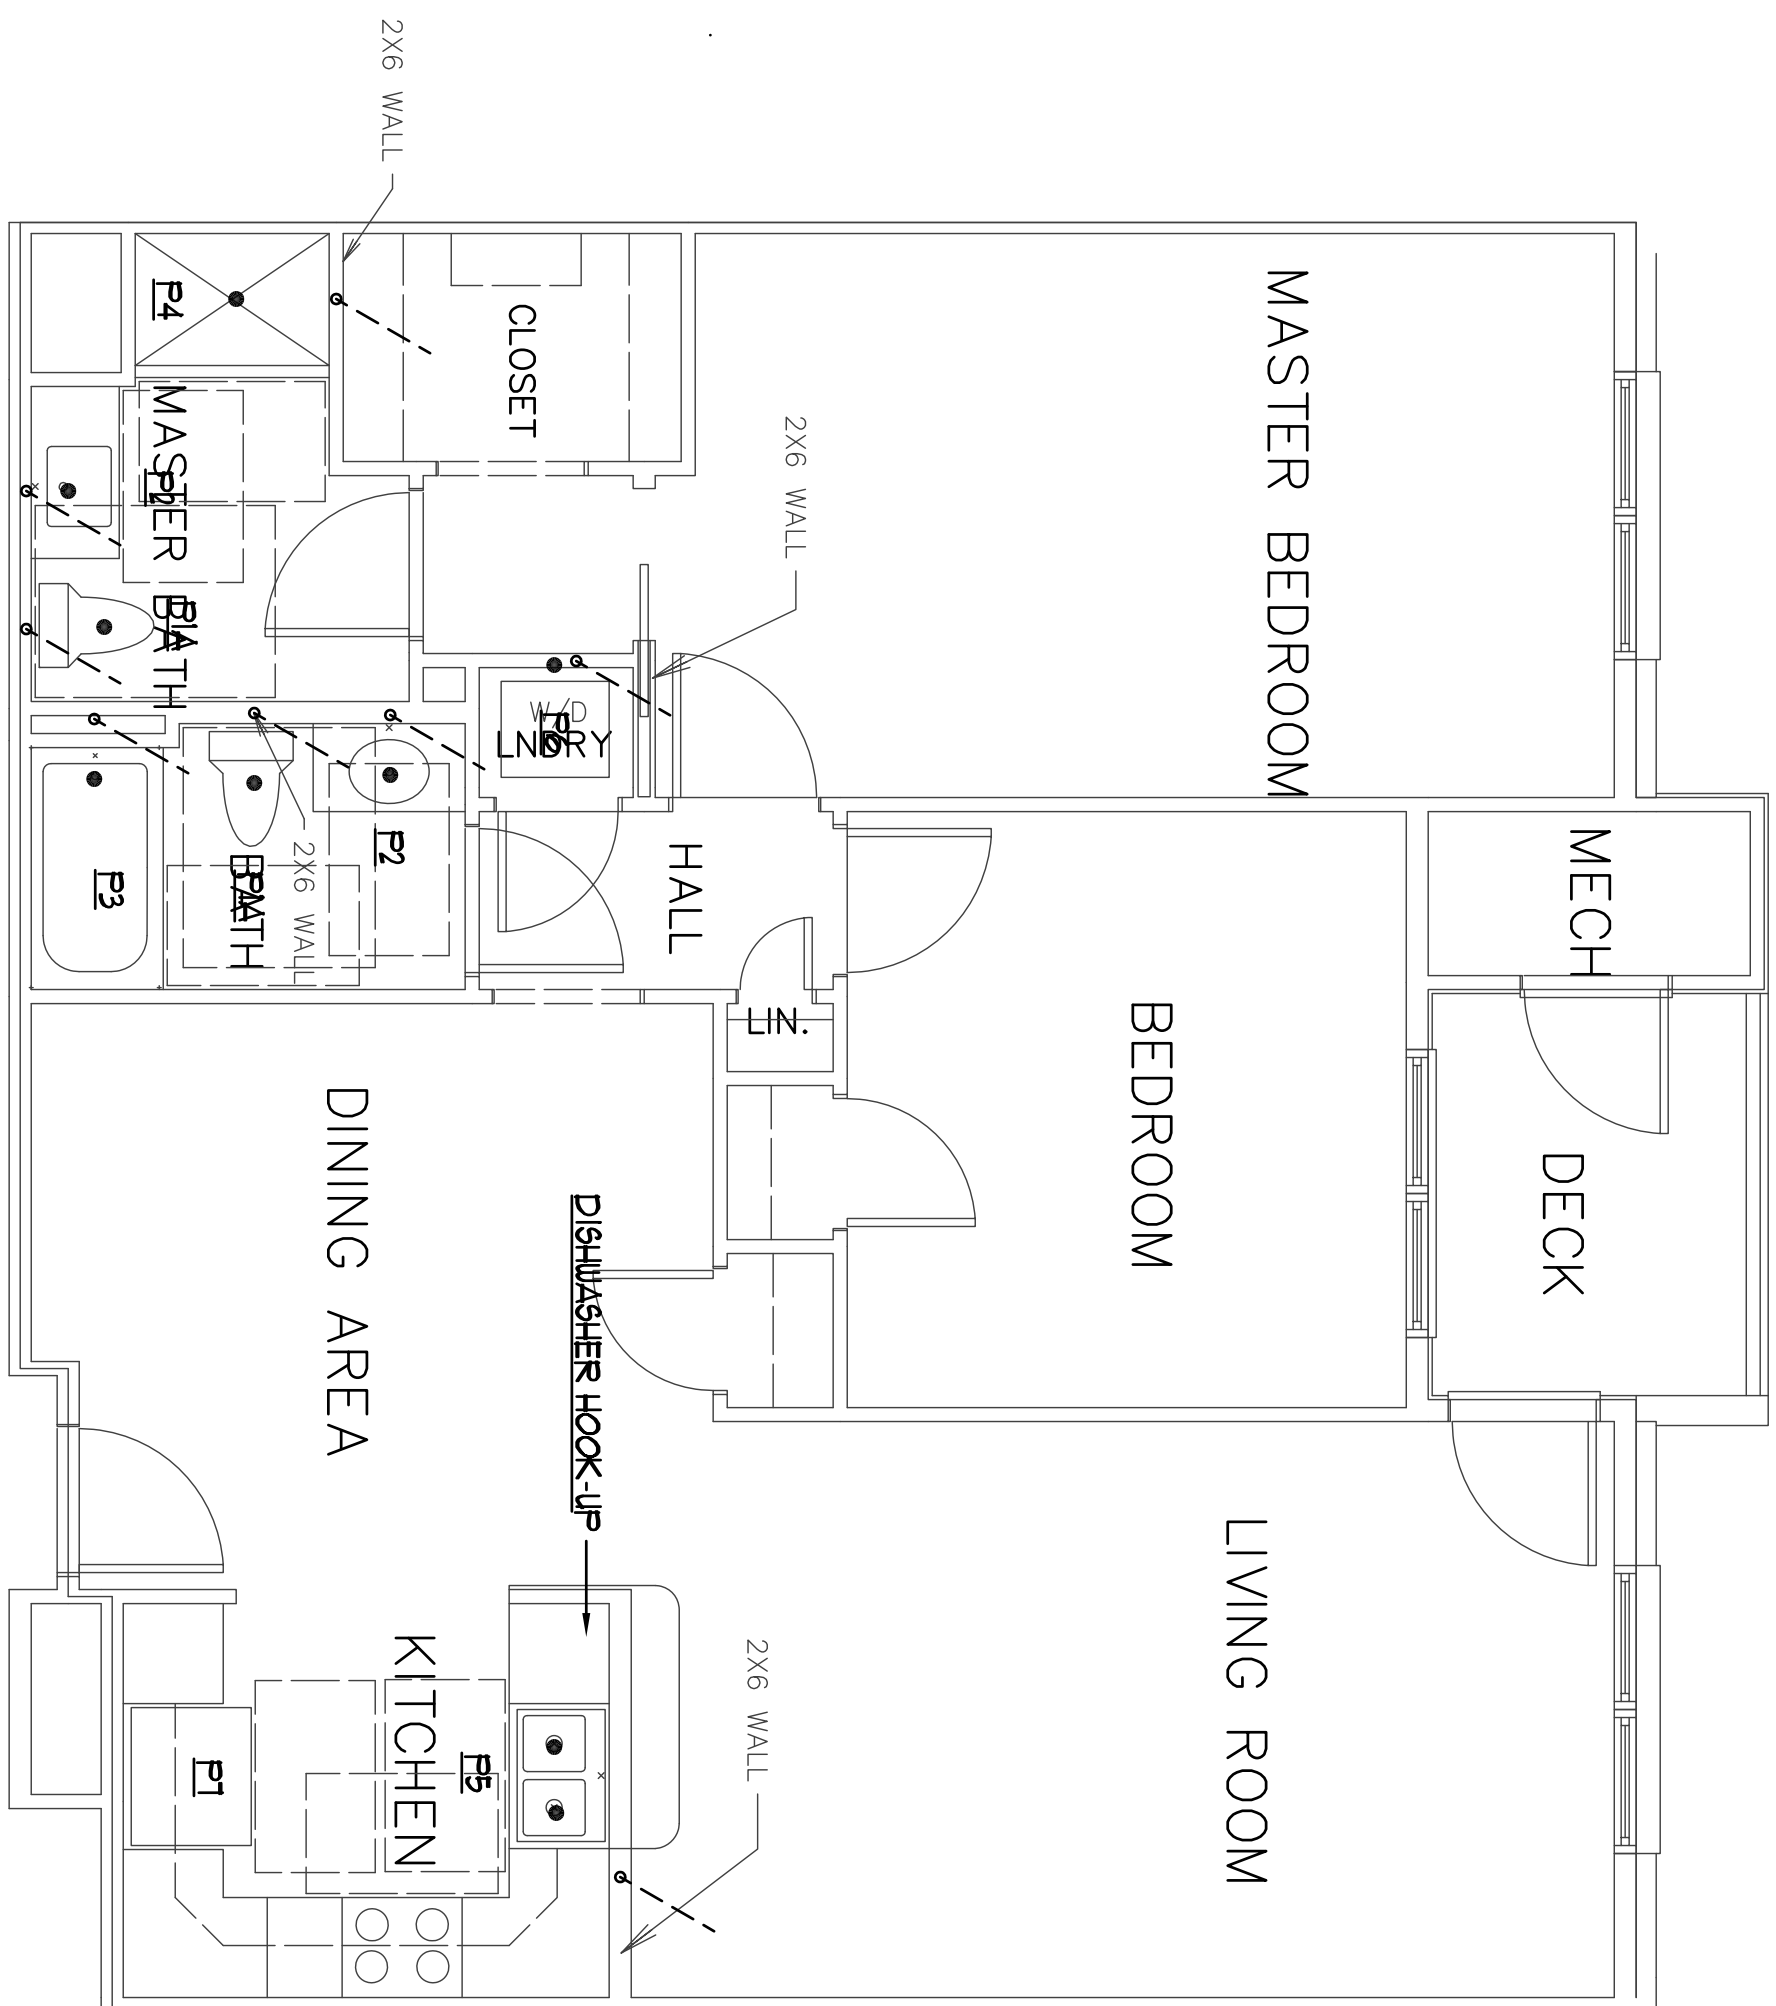

General Note  
 1. Unit Type A1 is similar to Unit Type A. See piping layout for Unit Type A for  
 more information.

UNIT TYPE A1  
 SCALE: 1/4" = 1' 0"

**Atlantic Comfort  
 Systems, Inc.**  
 Mechanical Contractor • 507-284-4390  
 882 Hill Street, Biddeford, ME 04005  
 www.atlanticcomfort.com