



Revisions
11/29/2012--UNDERSLAB PIPING FOR
CONSTRUCTION
12/14/2012-- FOR PERMIT.

Bay House
Portland, ME

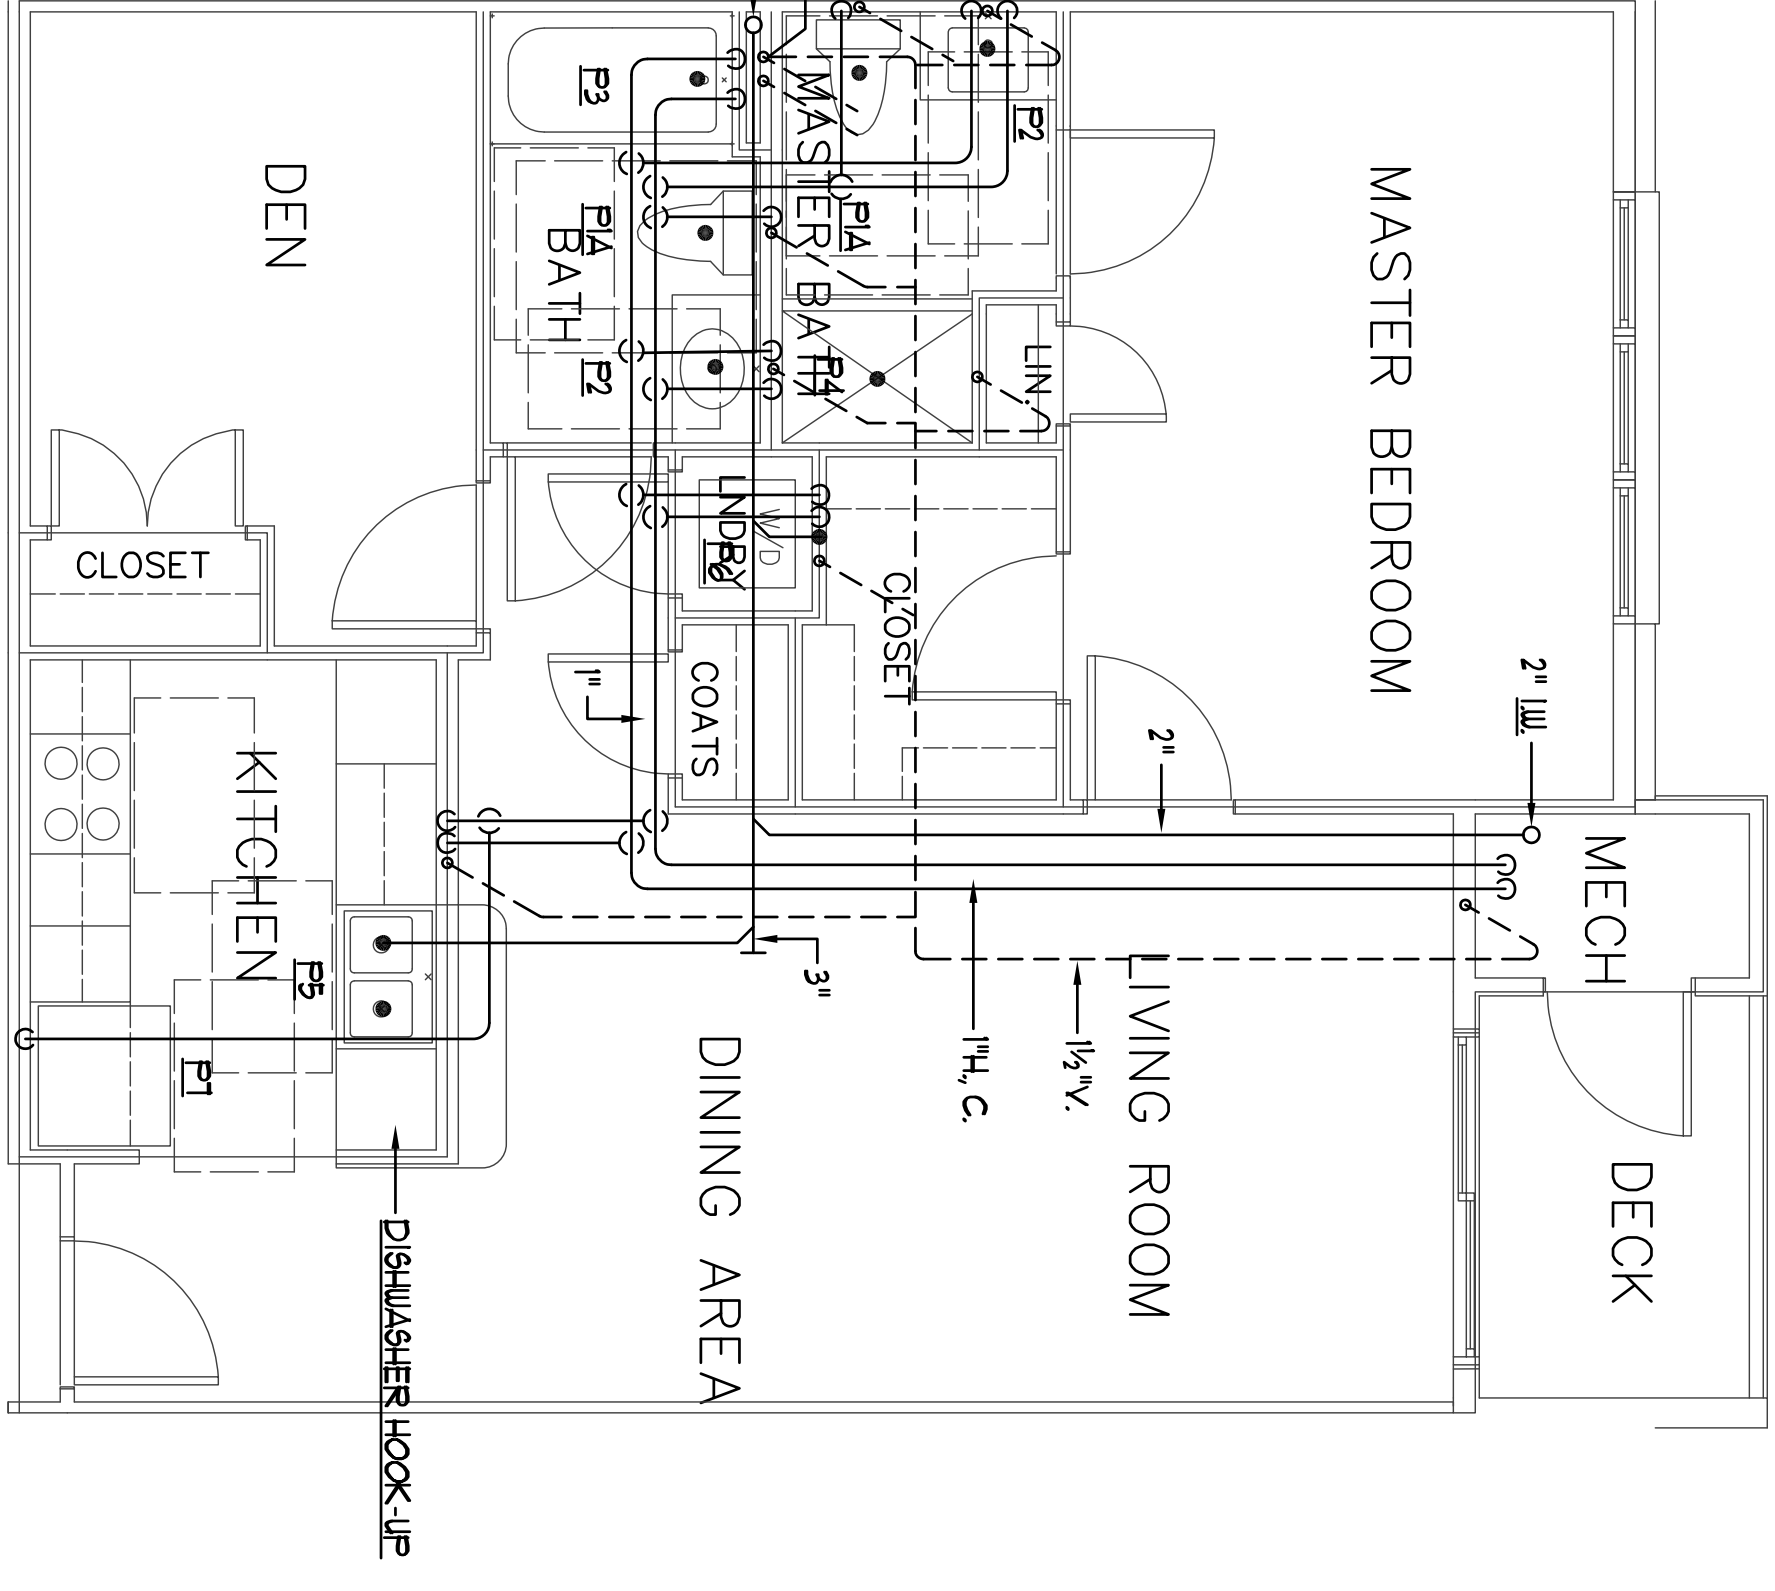


UNIT TYPE C
SCALE: 1/4" = 1' 0"

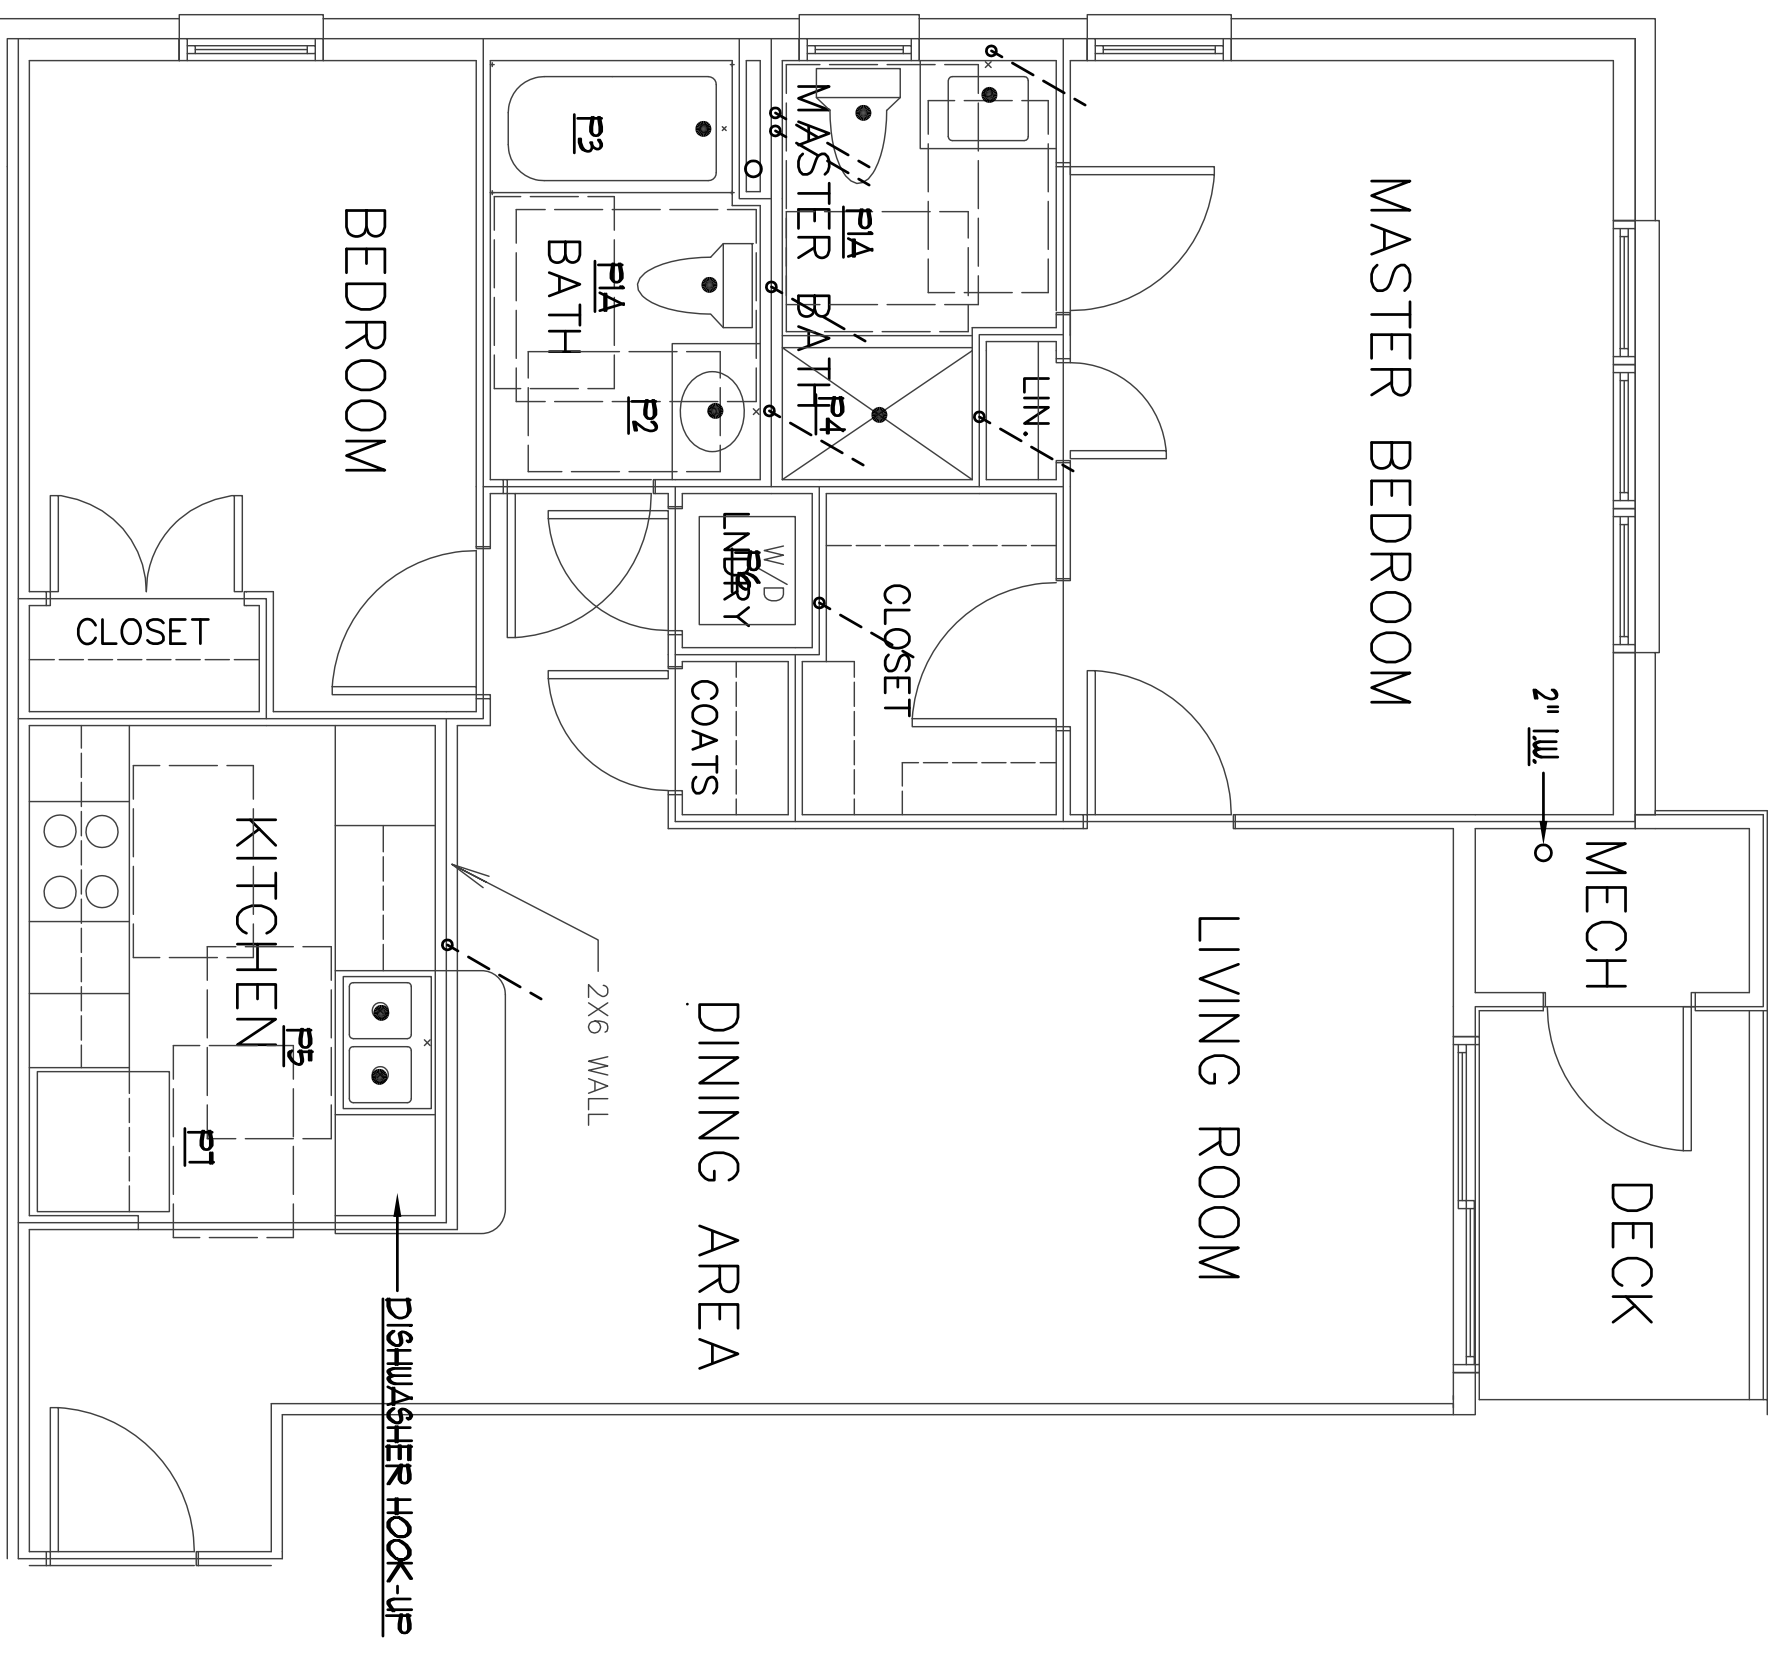

General Note
1. Unit Type D is similar to Unit Type C. See piping layout for Unit Type C for more information.

UNIT TYPE D
SCALE: 1/4" = 1' 0"

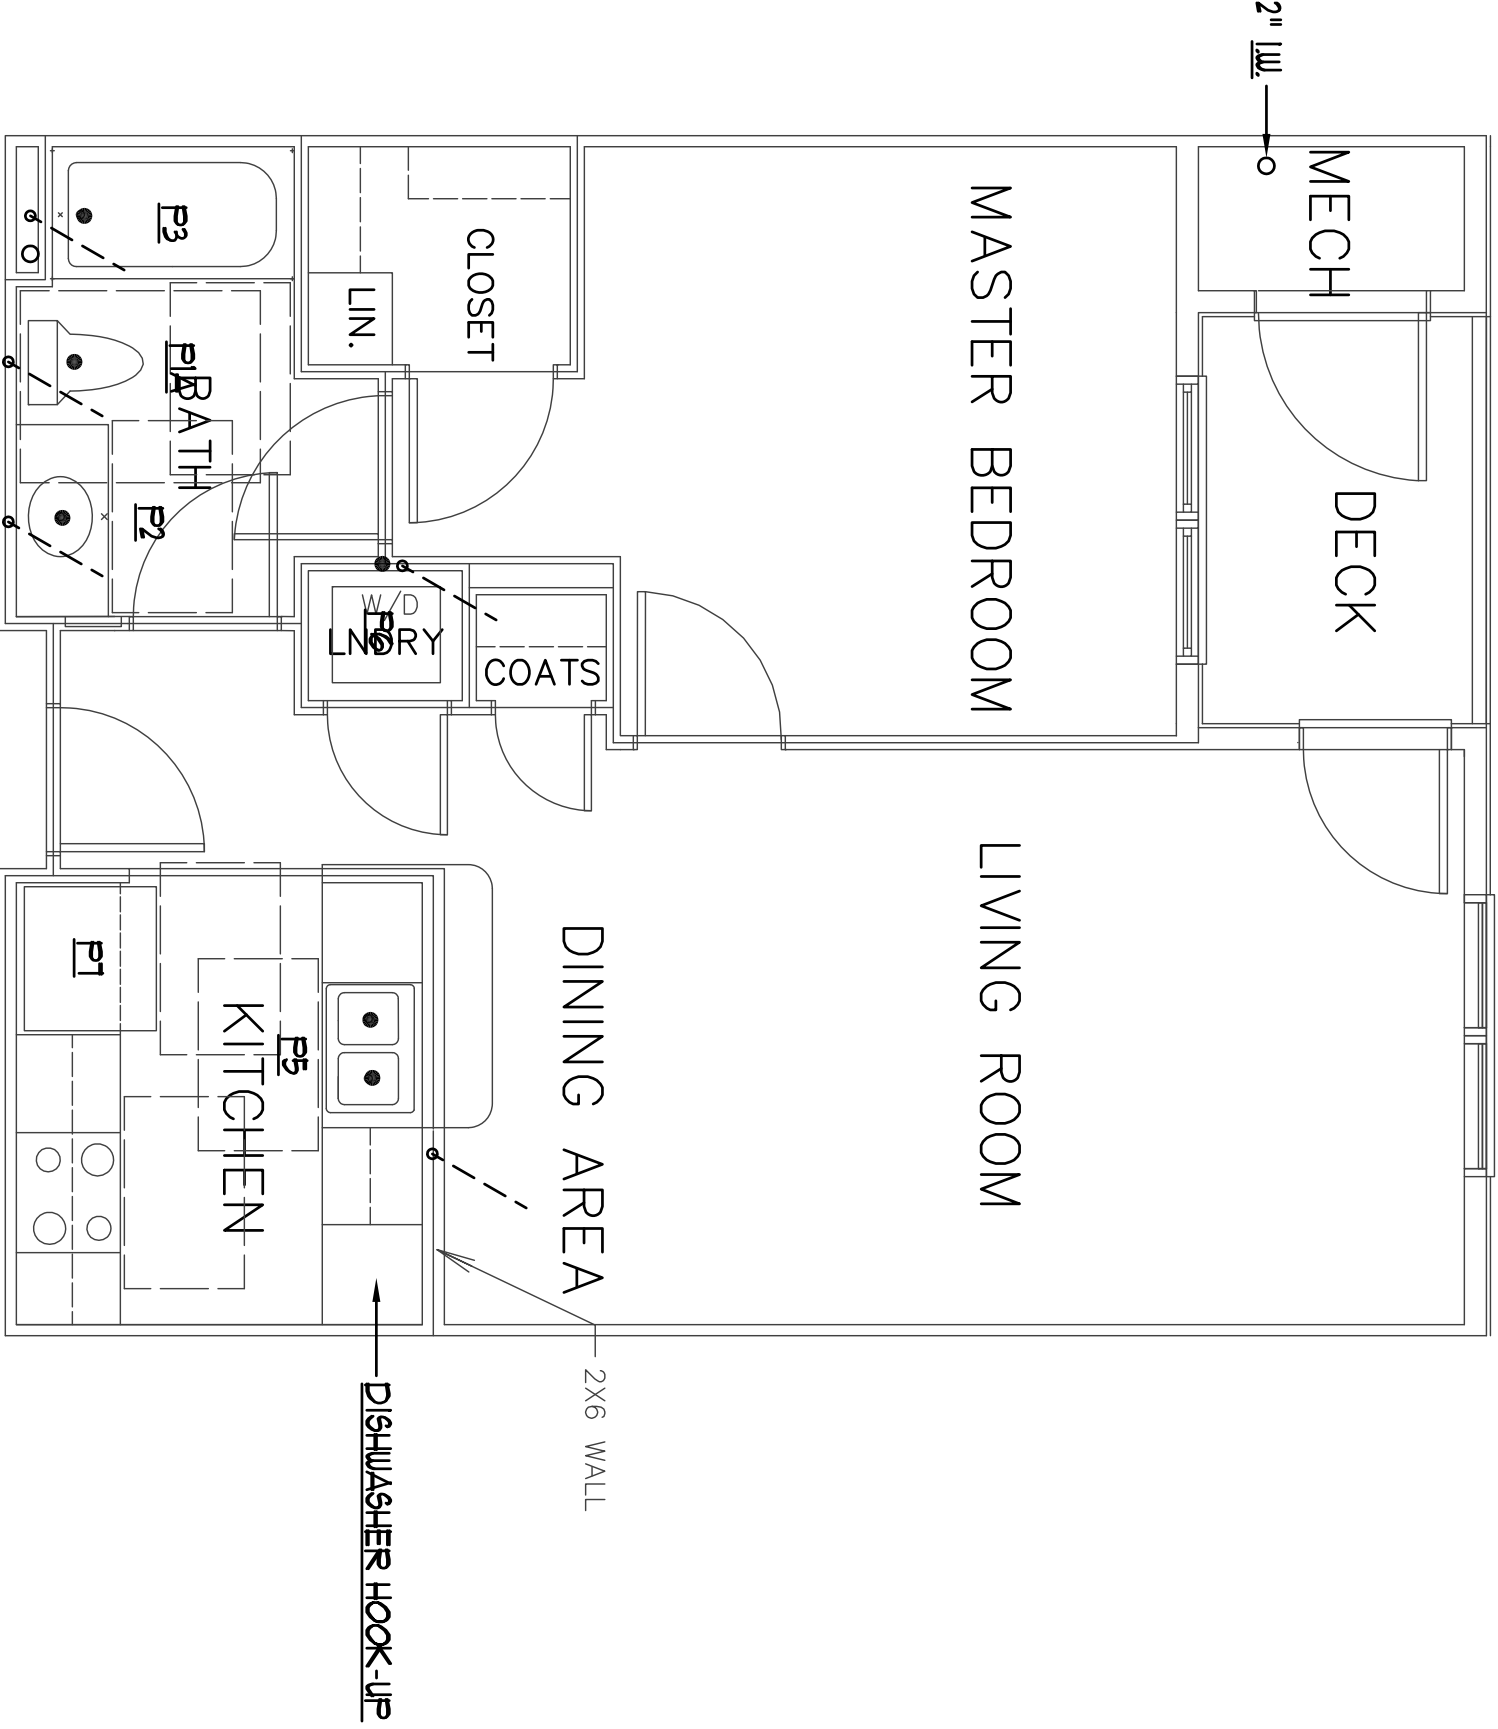

General Note
1. Unit Type E is similar to Unit Type A. See piping layout for Unit Type A for more information.

UNIT TYPE E
SCALE: 1/4" = 1' 0"

Atlantic Comfort
Systems, Inc.
Mechanical Contractor • 807-884-4390
882 Hill Street, Biddeford, ME 04005
www.atlanticcomfort.com

BENNETT
ENGINEERING
MECHANICAL • ELECTRICAL
(207) 865-9475

Job No.: 3346
Date: 12/14/12
Scale: 1/8" = 1'-0" or A1.
Drawn by: SF Doel
Checked by: SF Doel

Drawing Title:
Unit Plans

P.14