

Revisions
11/29/2012-INDERS LAB PIPING FOR
CONSTRUCTION FOR PERMIT.
12/14/2012-

Bay House
Portland, ME




**BENNETT
ENGINEERING**
MECHANICAL • ELECTRICAL
(207) 865-9475

Job No.: 3346
Date: 12/14/12
Scale: 1/8" = 1'-0" or A.N.
Drawn by: SF Doel
Checked by: SF Doel


Drawing Title:
Unit Plans

P.17

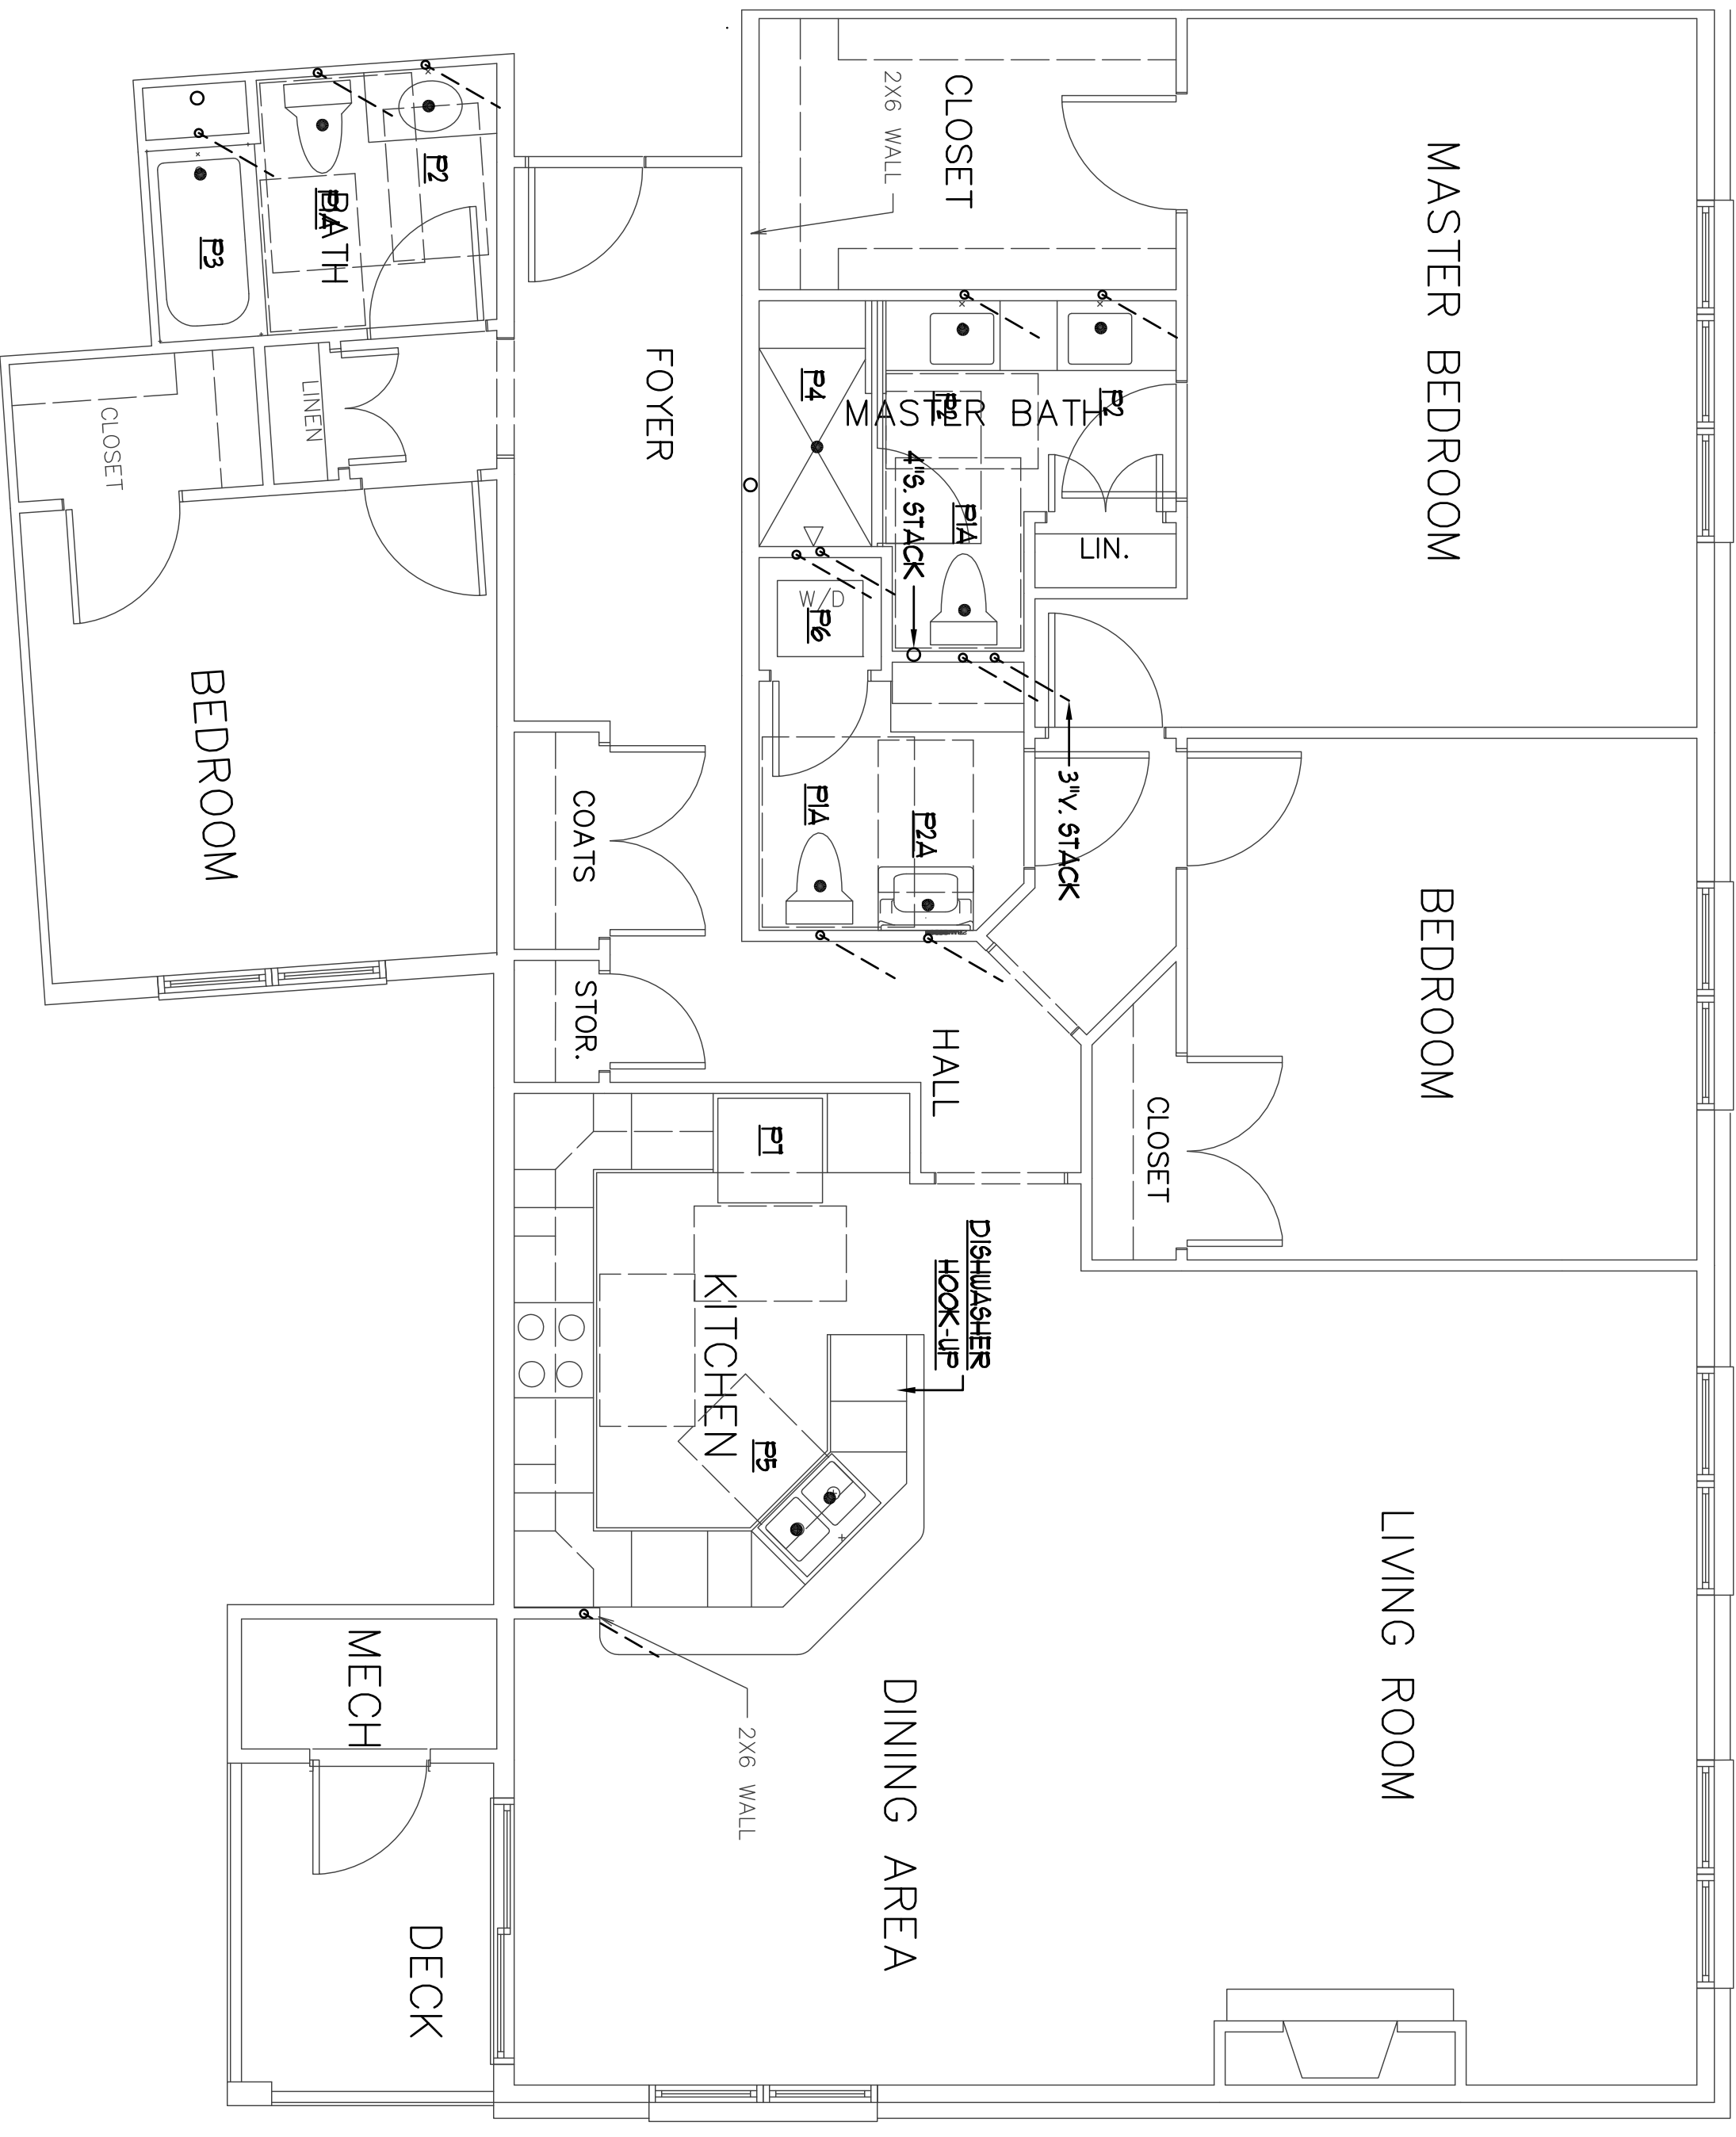

UNIT TYPE M
SCALE: 1/4" = 1' 0"

General Note
1. Unit Type M is similar but mirrored to Unit Type N. See piping layout for Unit Type N for more information.

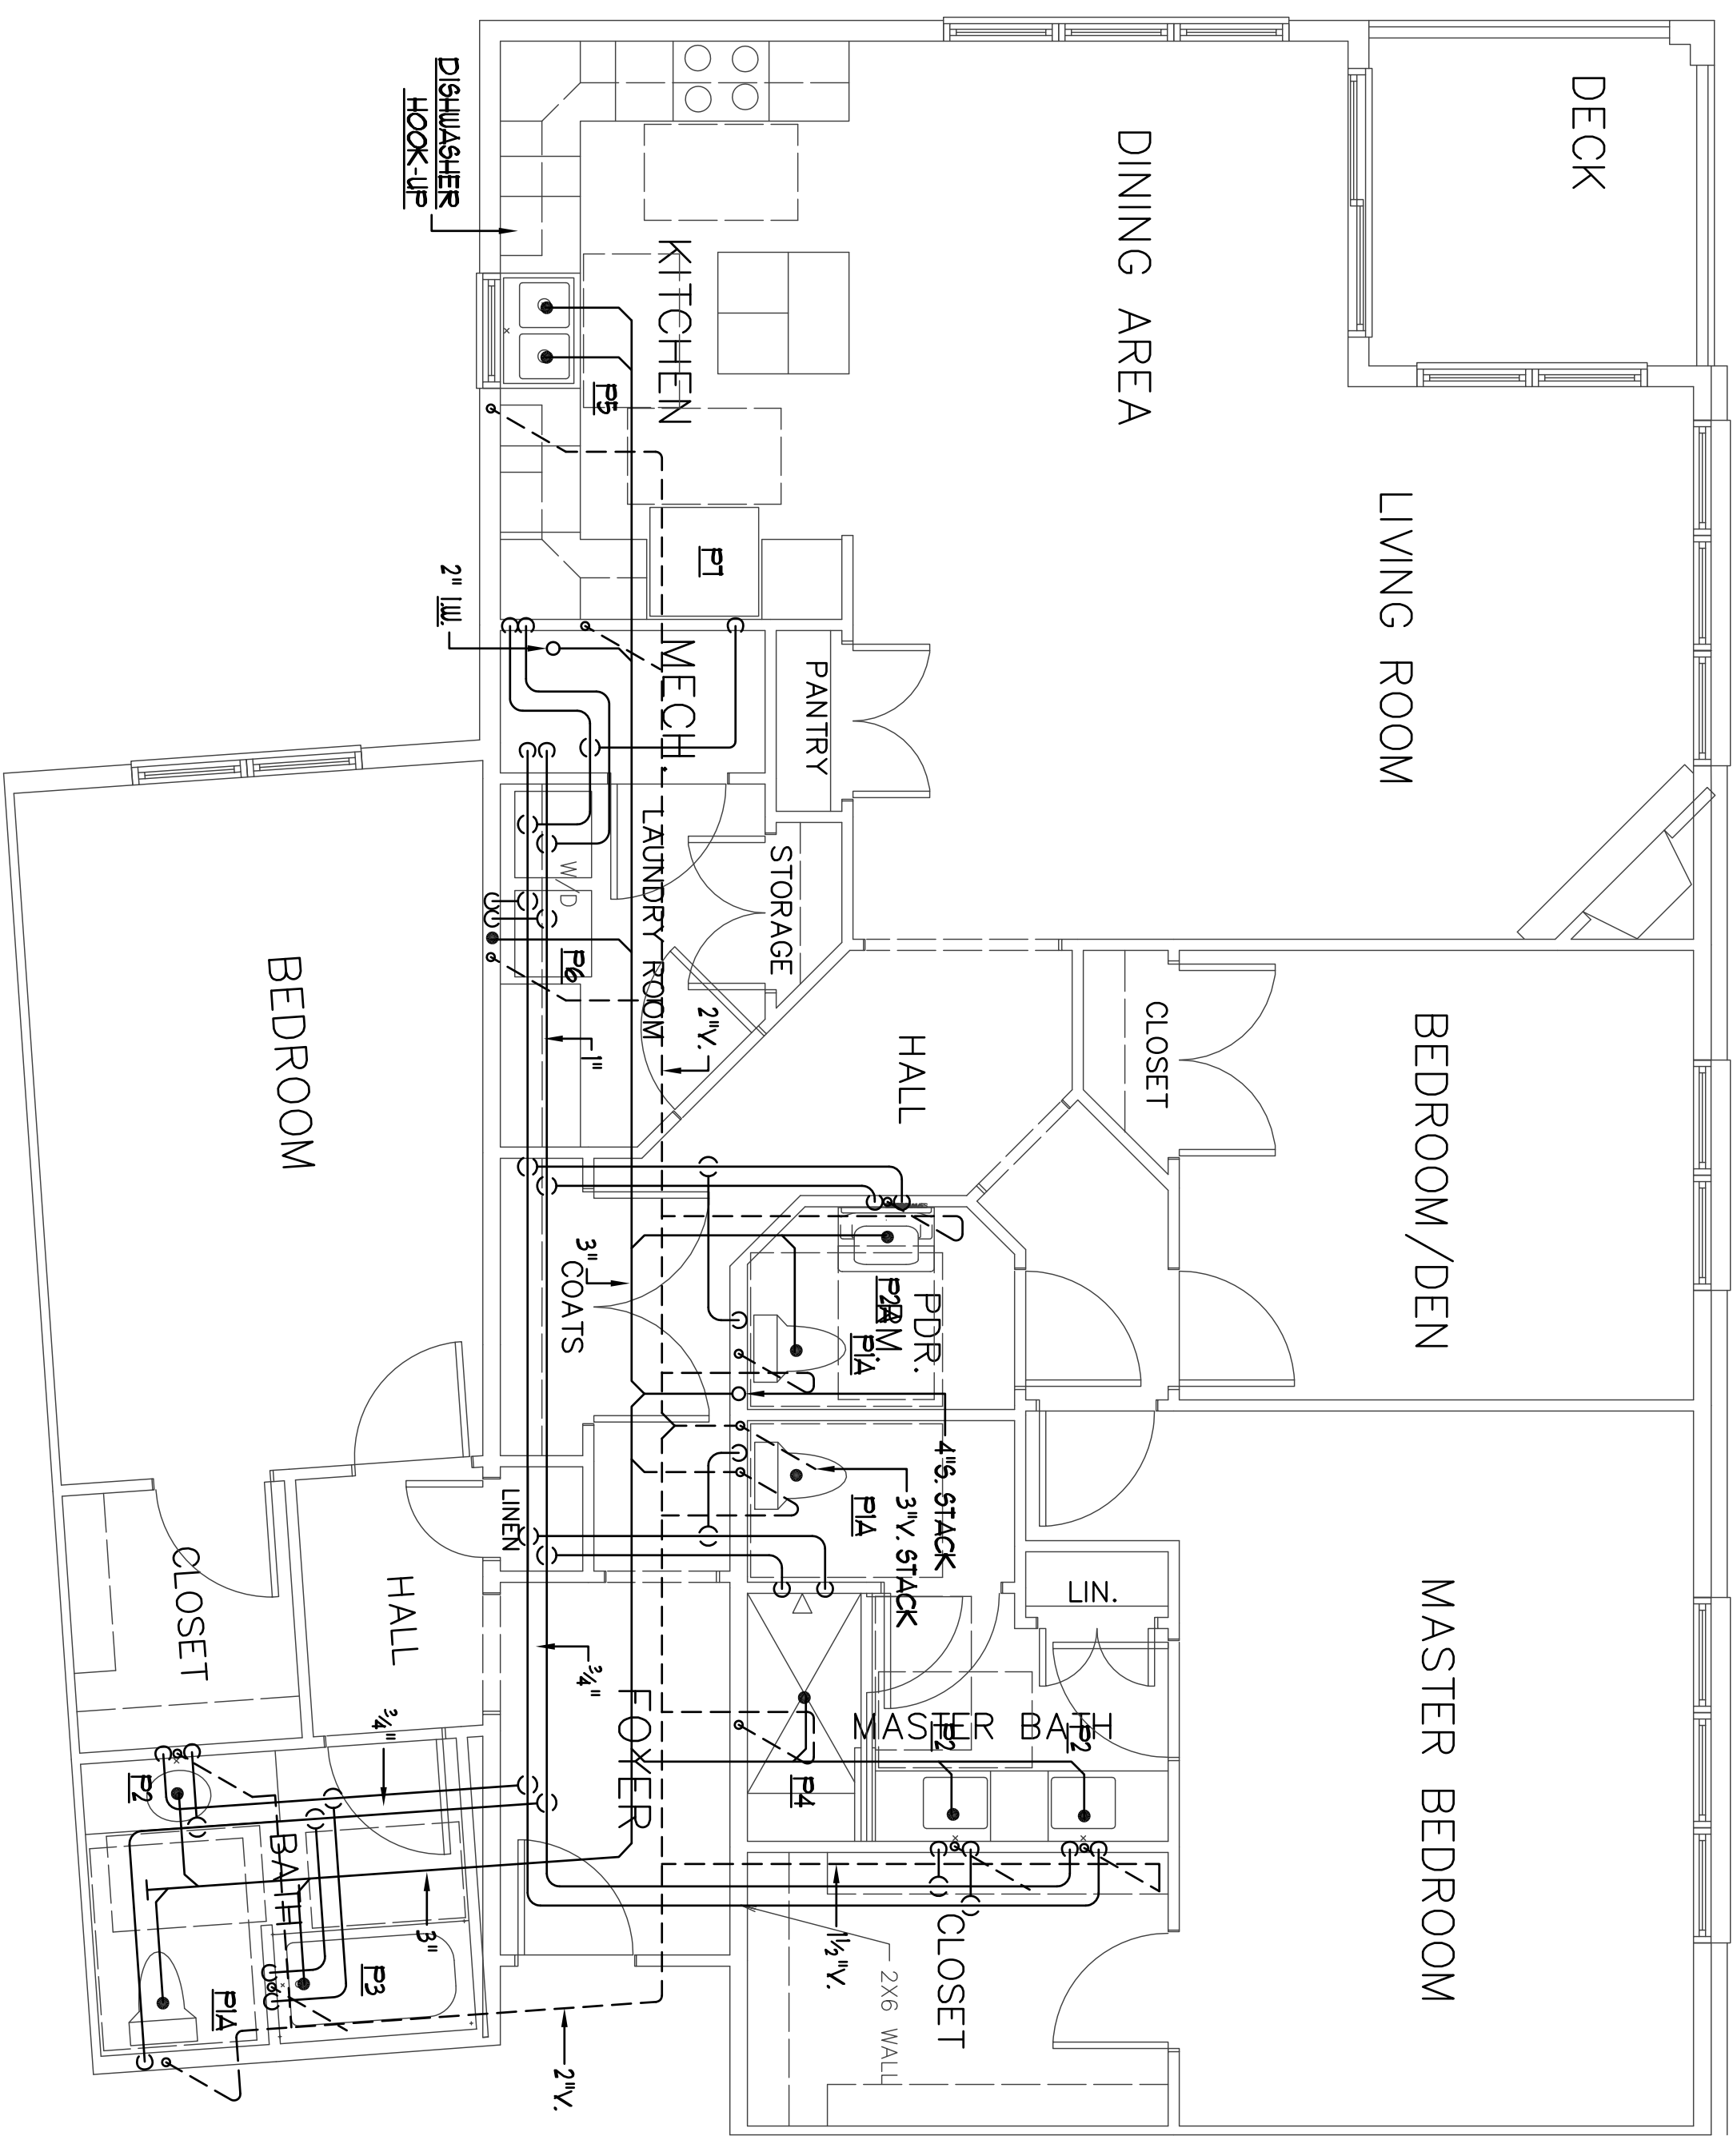

UNIT TYPE N
SCALE: 1/4" = 1' 0"