



Revisions:
11/29/2012 - UNDER LAB PIPING FOR
CONSTRUCTION - FOR PERMIT.
12/14/2012 - FOR PERMIT.

Bay House

Portland, ME

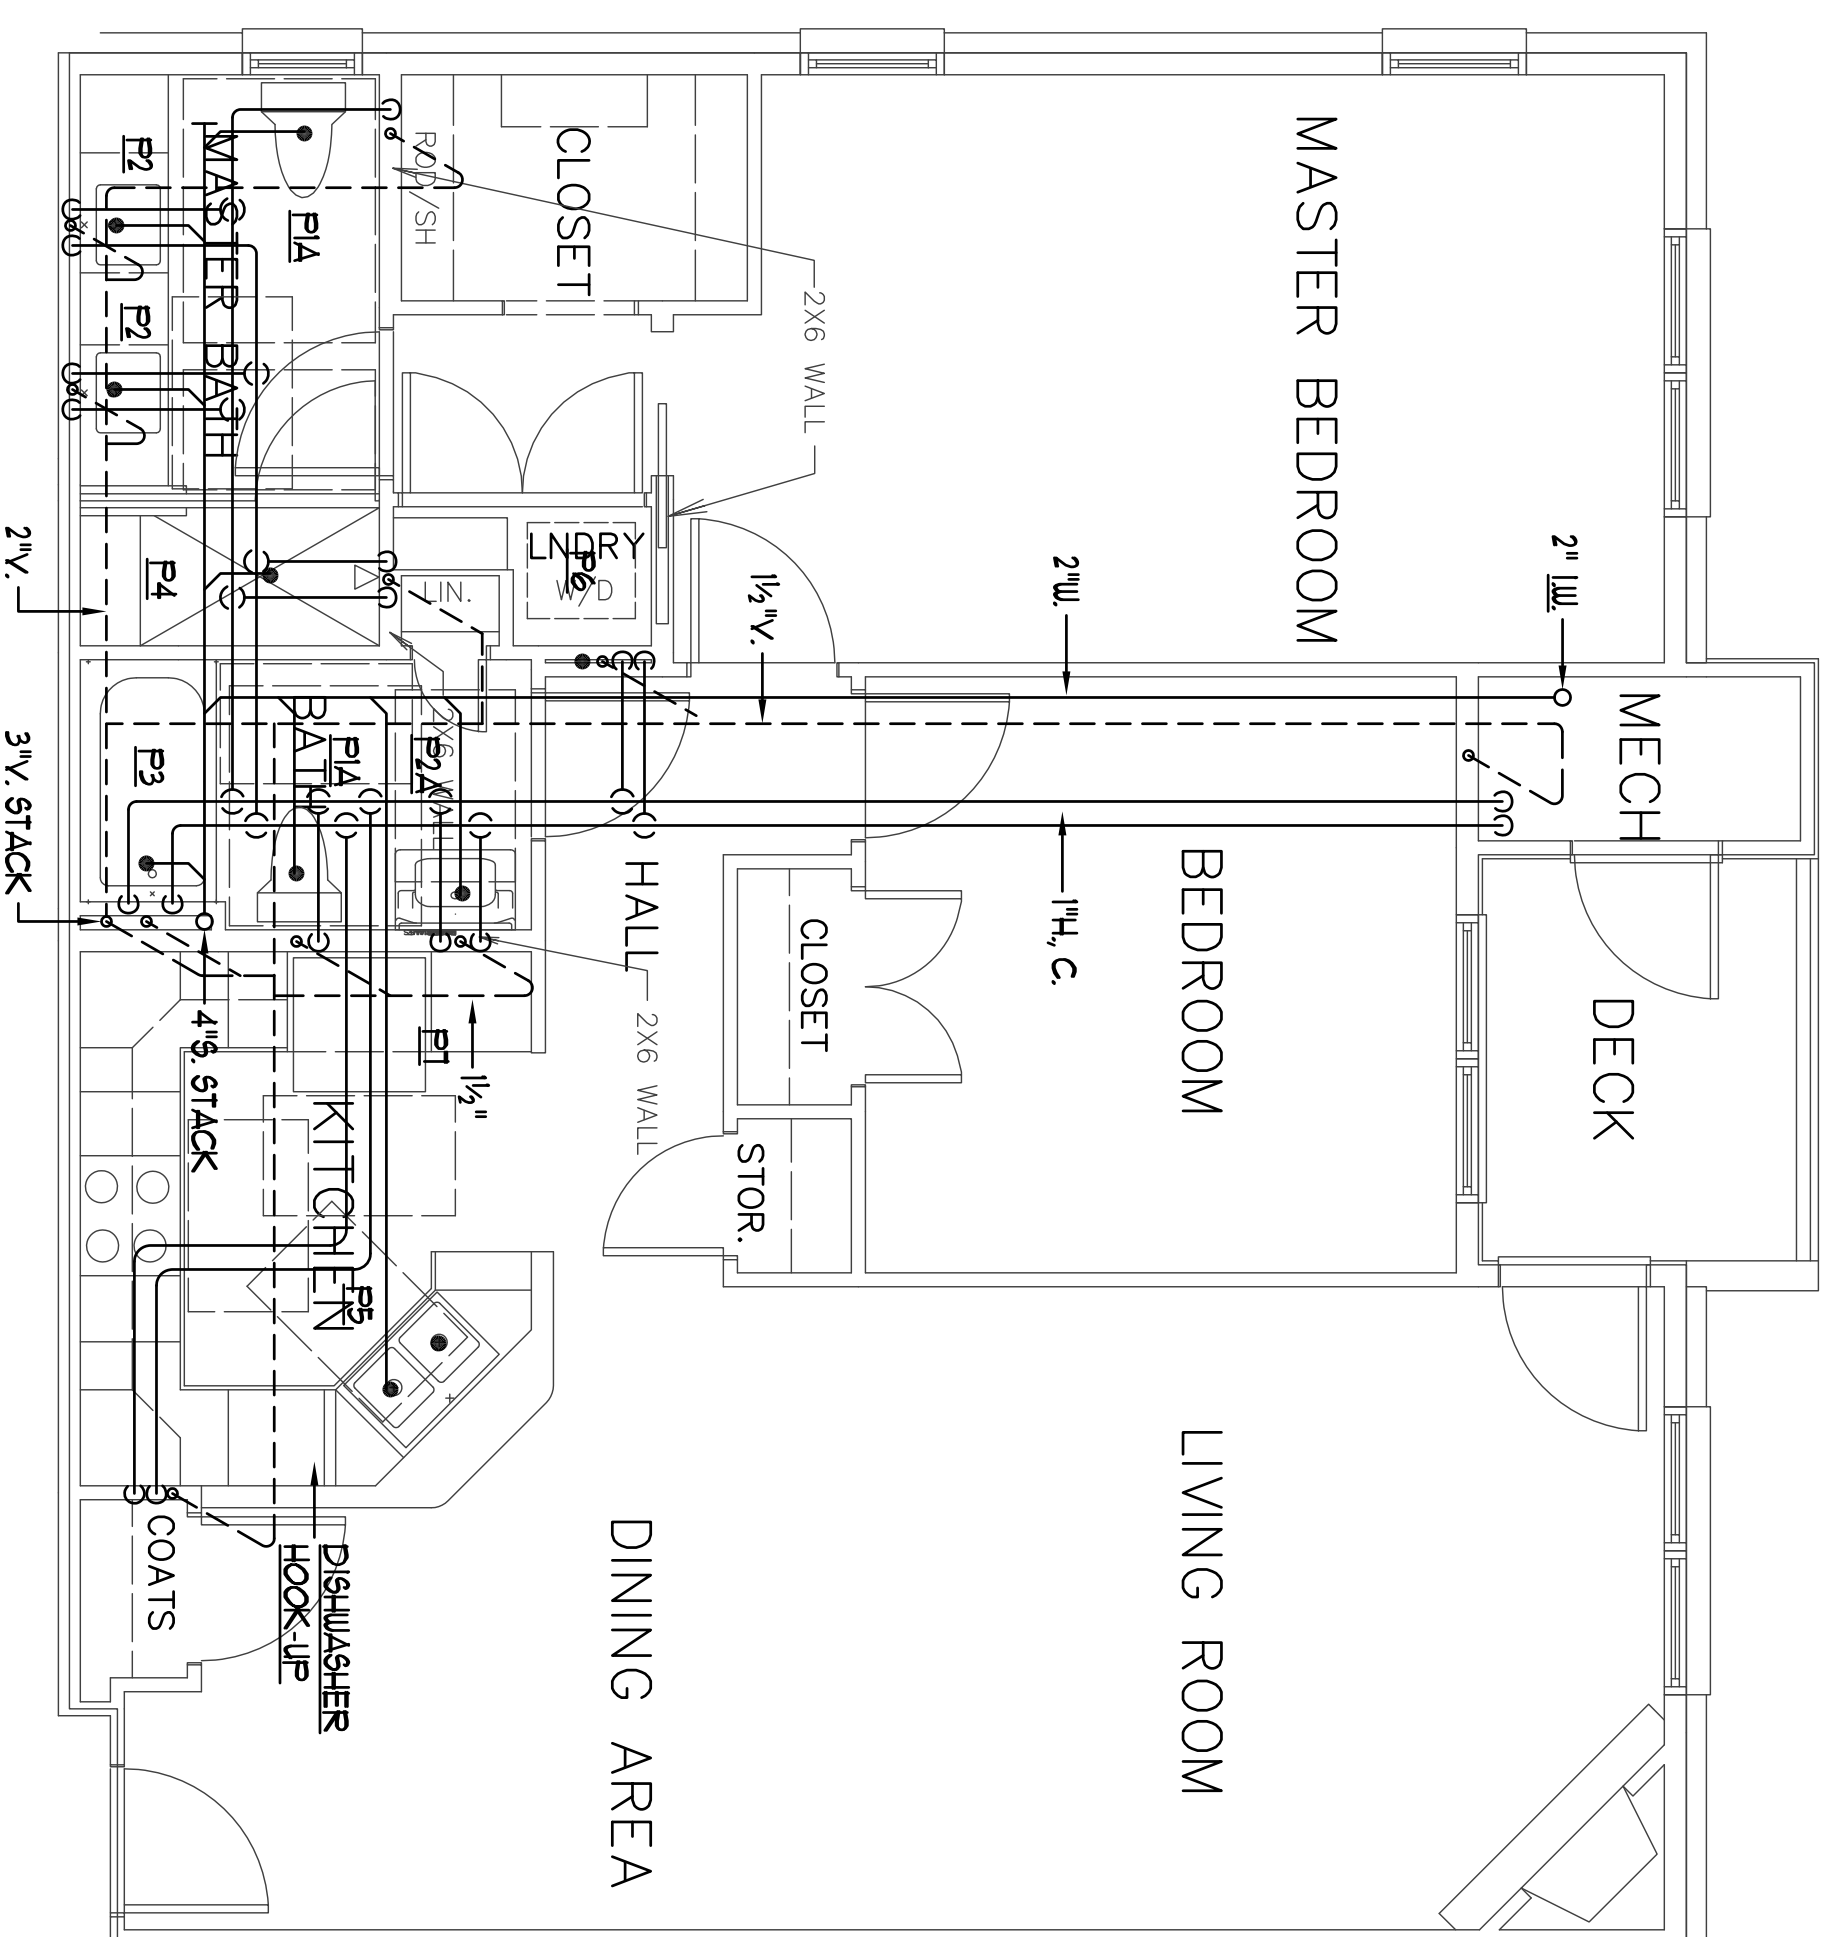

UNIT TYPE I
SCALE: 1/4" = 1' 0"

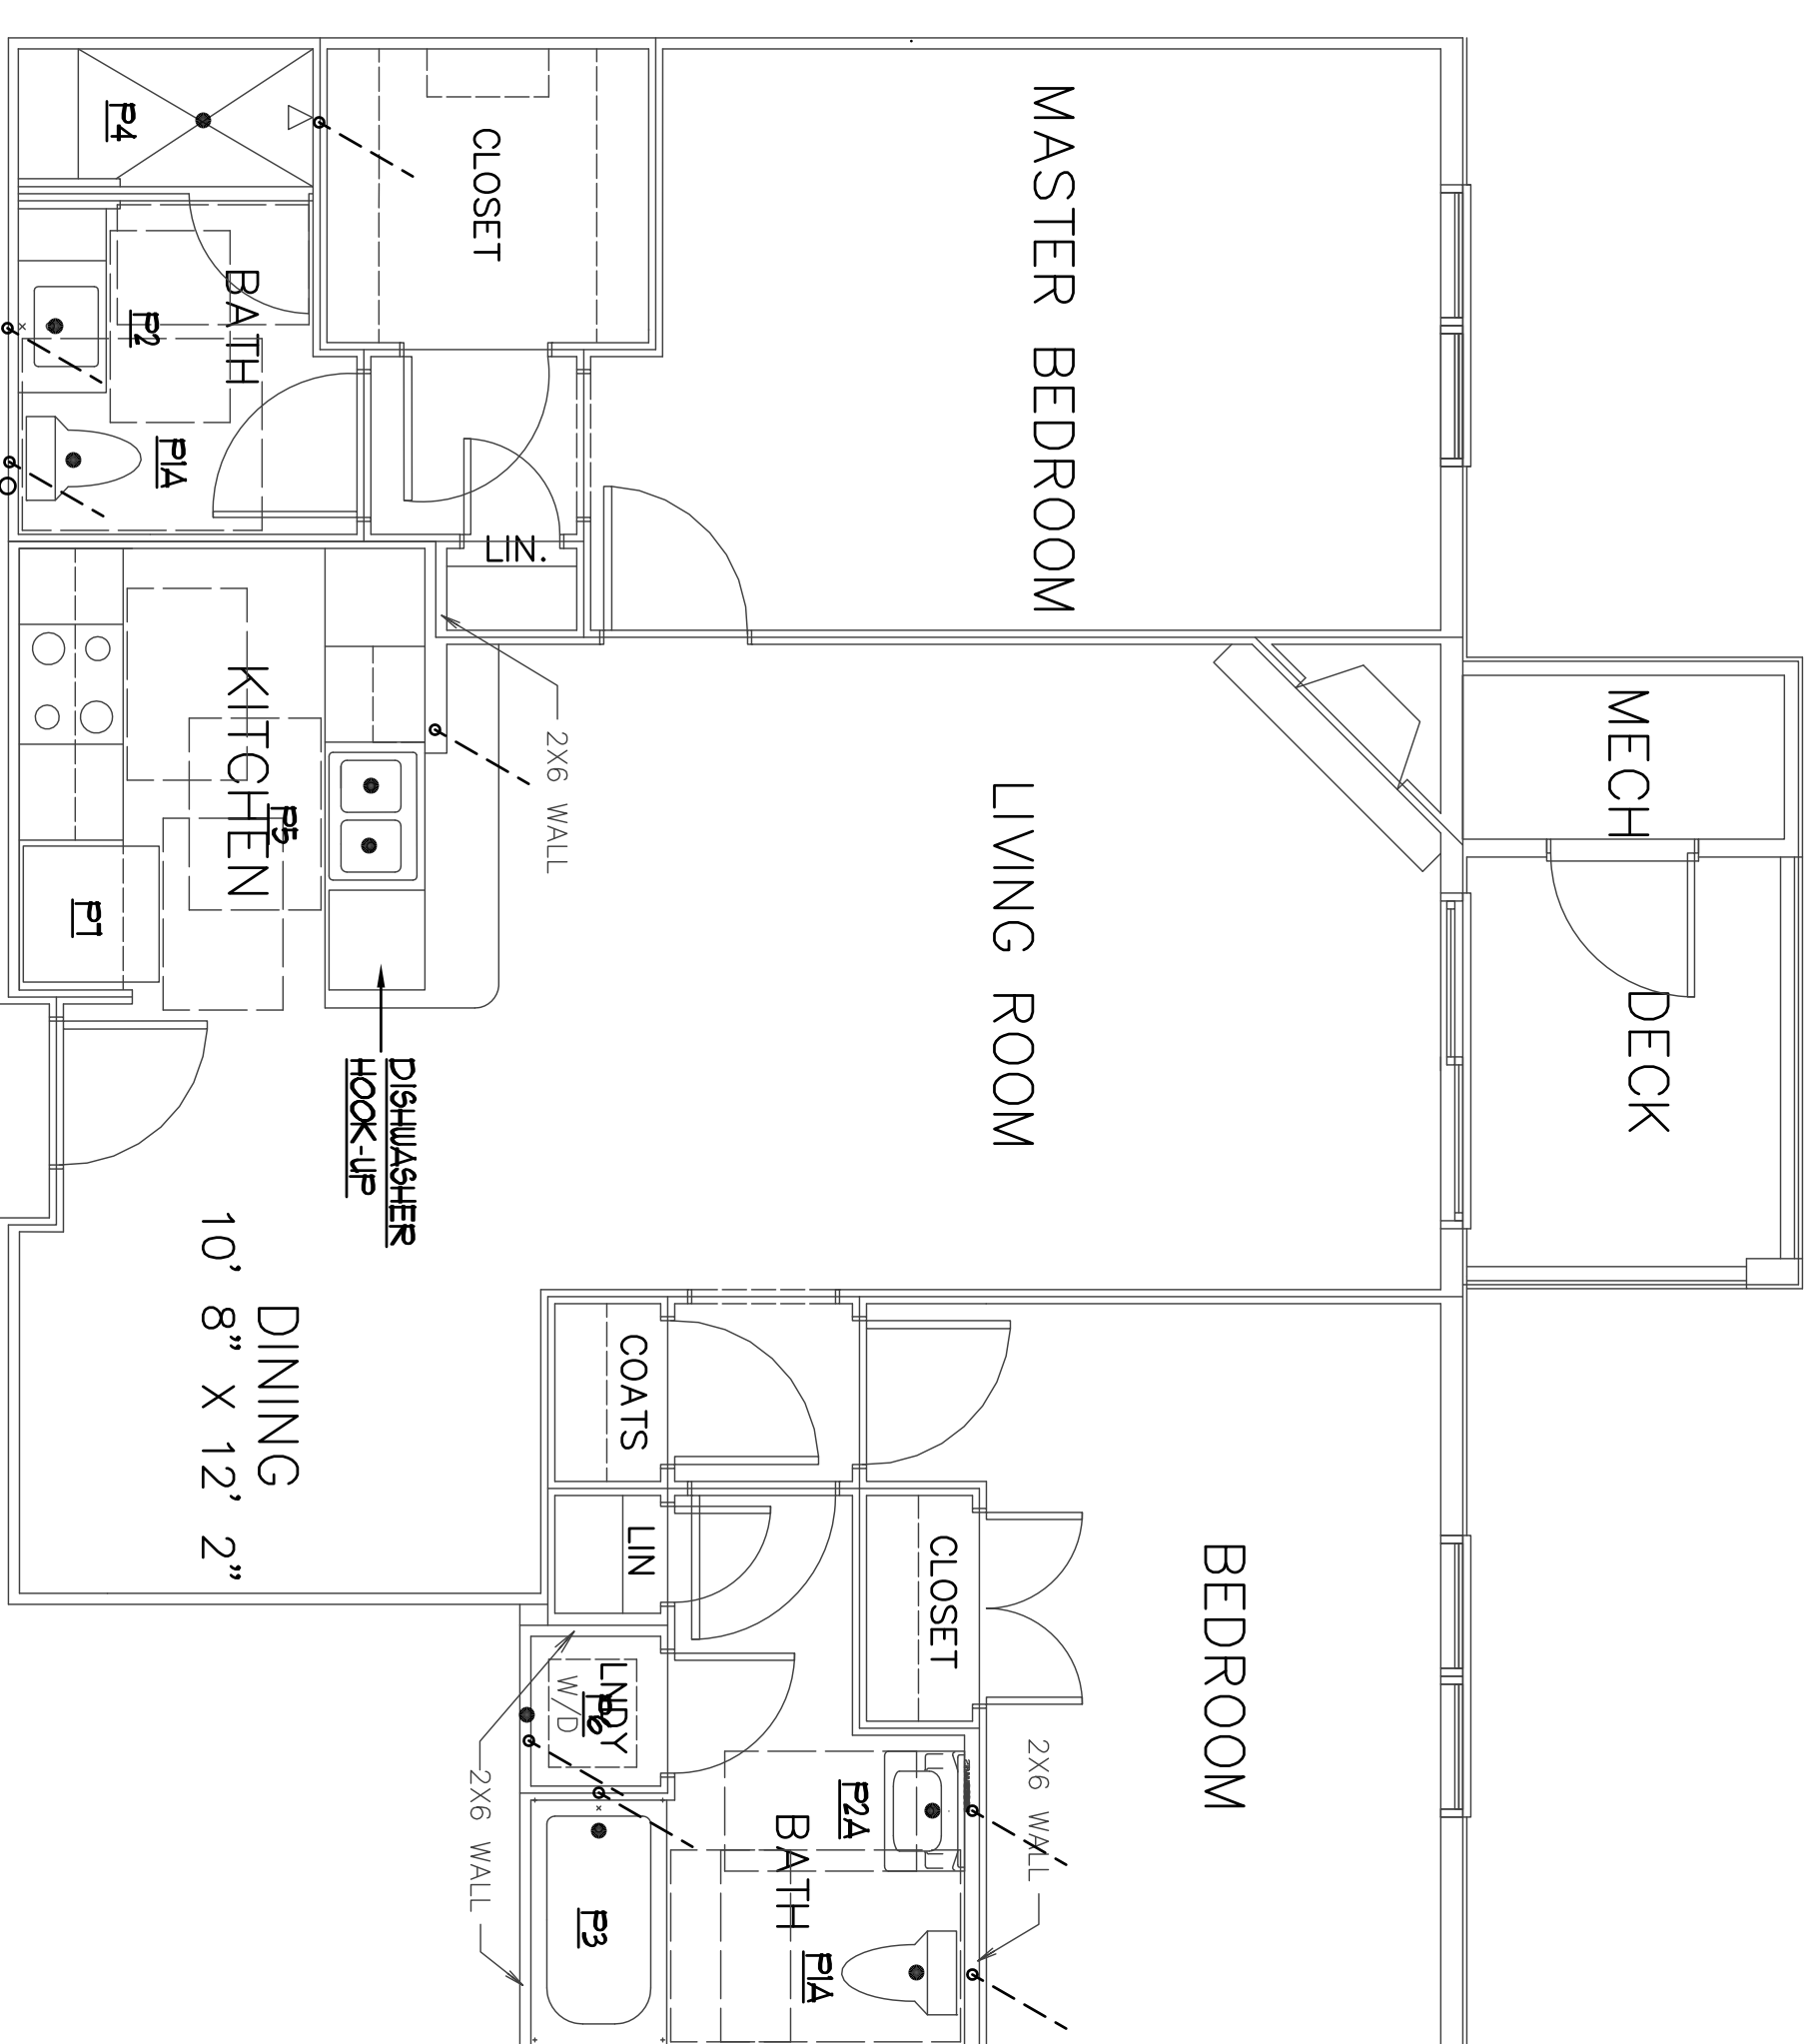

General Note
1. Unit Type J is similar to Unit Type I. See piping layout for Unit Type I for more information.
UNIT TYPE J
SCALE: 1/4" = 1' 0"

**Atlantic Comfort
Systems, Inc.**
Mechanical Contractor • 207-284-4390
882 Hill Street, Bridgton, ME 04005
www.atlanticcomfort.com



**BENNETT
ENGINEERING**
MECHANICAL • ELECTRICAL
(207) 865-9475

Job No.: 3346
Date: 12/14/12
Scale: 1/8" = 1'-0" or A1.
Drawn by: SF Doel
Checked by: SF Doel

Drawing Title:
Unit Plans

P.19