


Revisions:
11/29/2012-UNDERSLAB PIPING FOR
CONSTRUCTION FOR PERMIT.
12/14/2012-

Bay House
Portland, ME




**BENNETT
ENGINEERING**
MECHANICAL • ELECTRICAL
(207) 865-9475

Job No.: 3346
Date: 12/14/12
Scale: 1/8" = 1'-0" or A.N.
Drawn by: SF Doel
Checked by: SF Doel

Drawing Title:
Plumbing 2nd Floor
Plan Building "1"

P.2

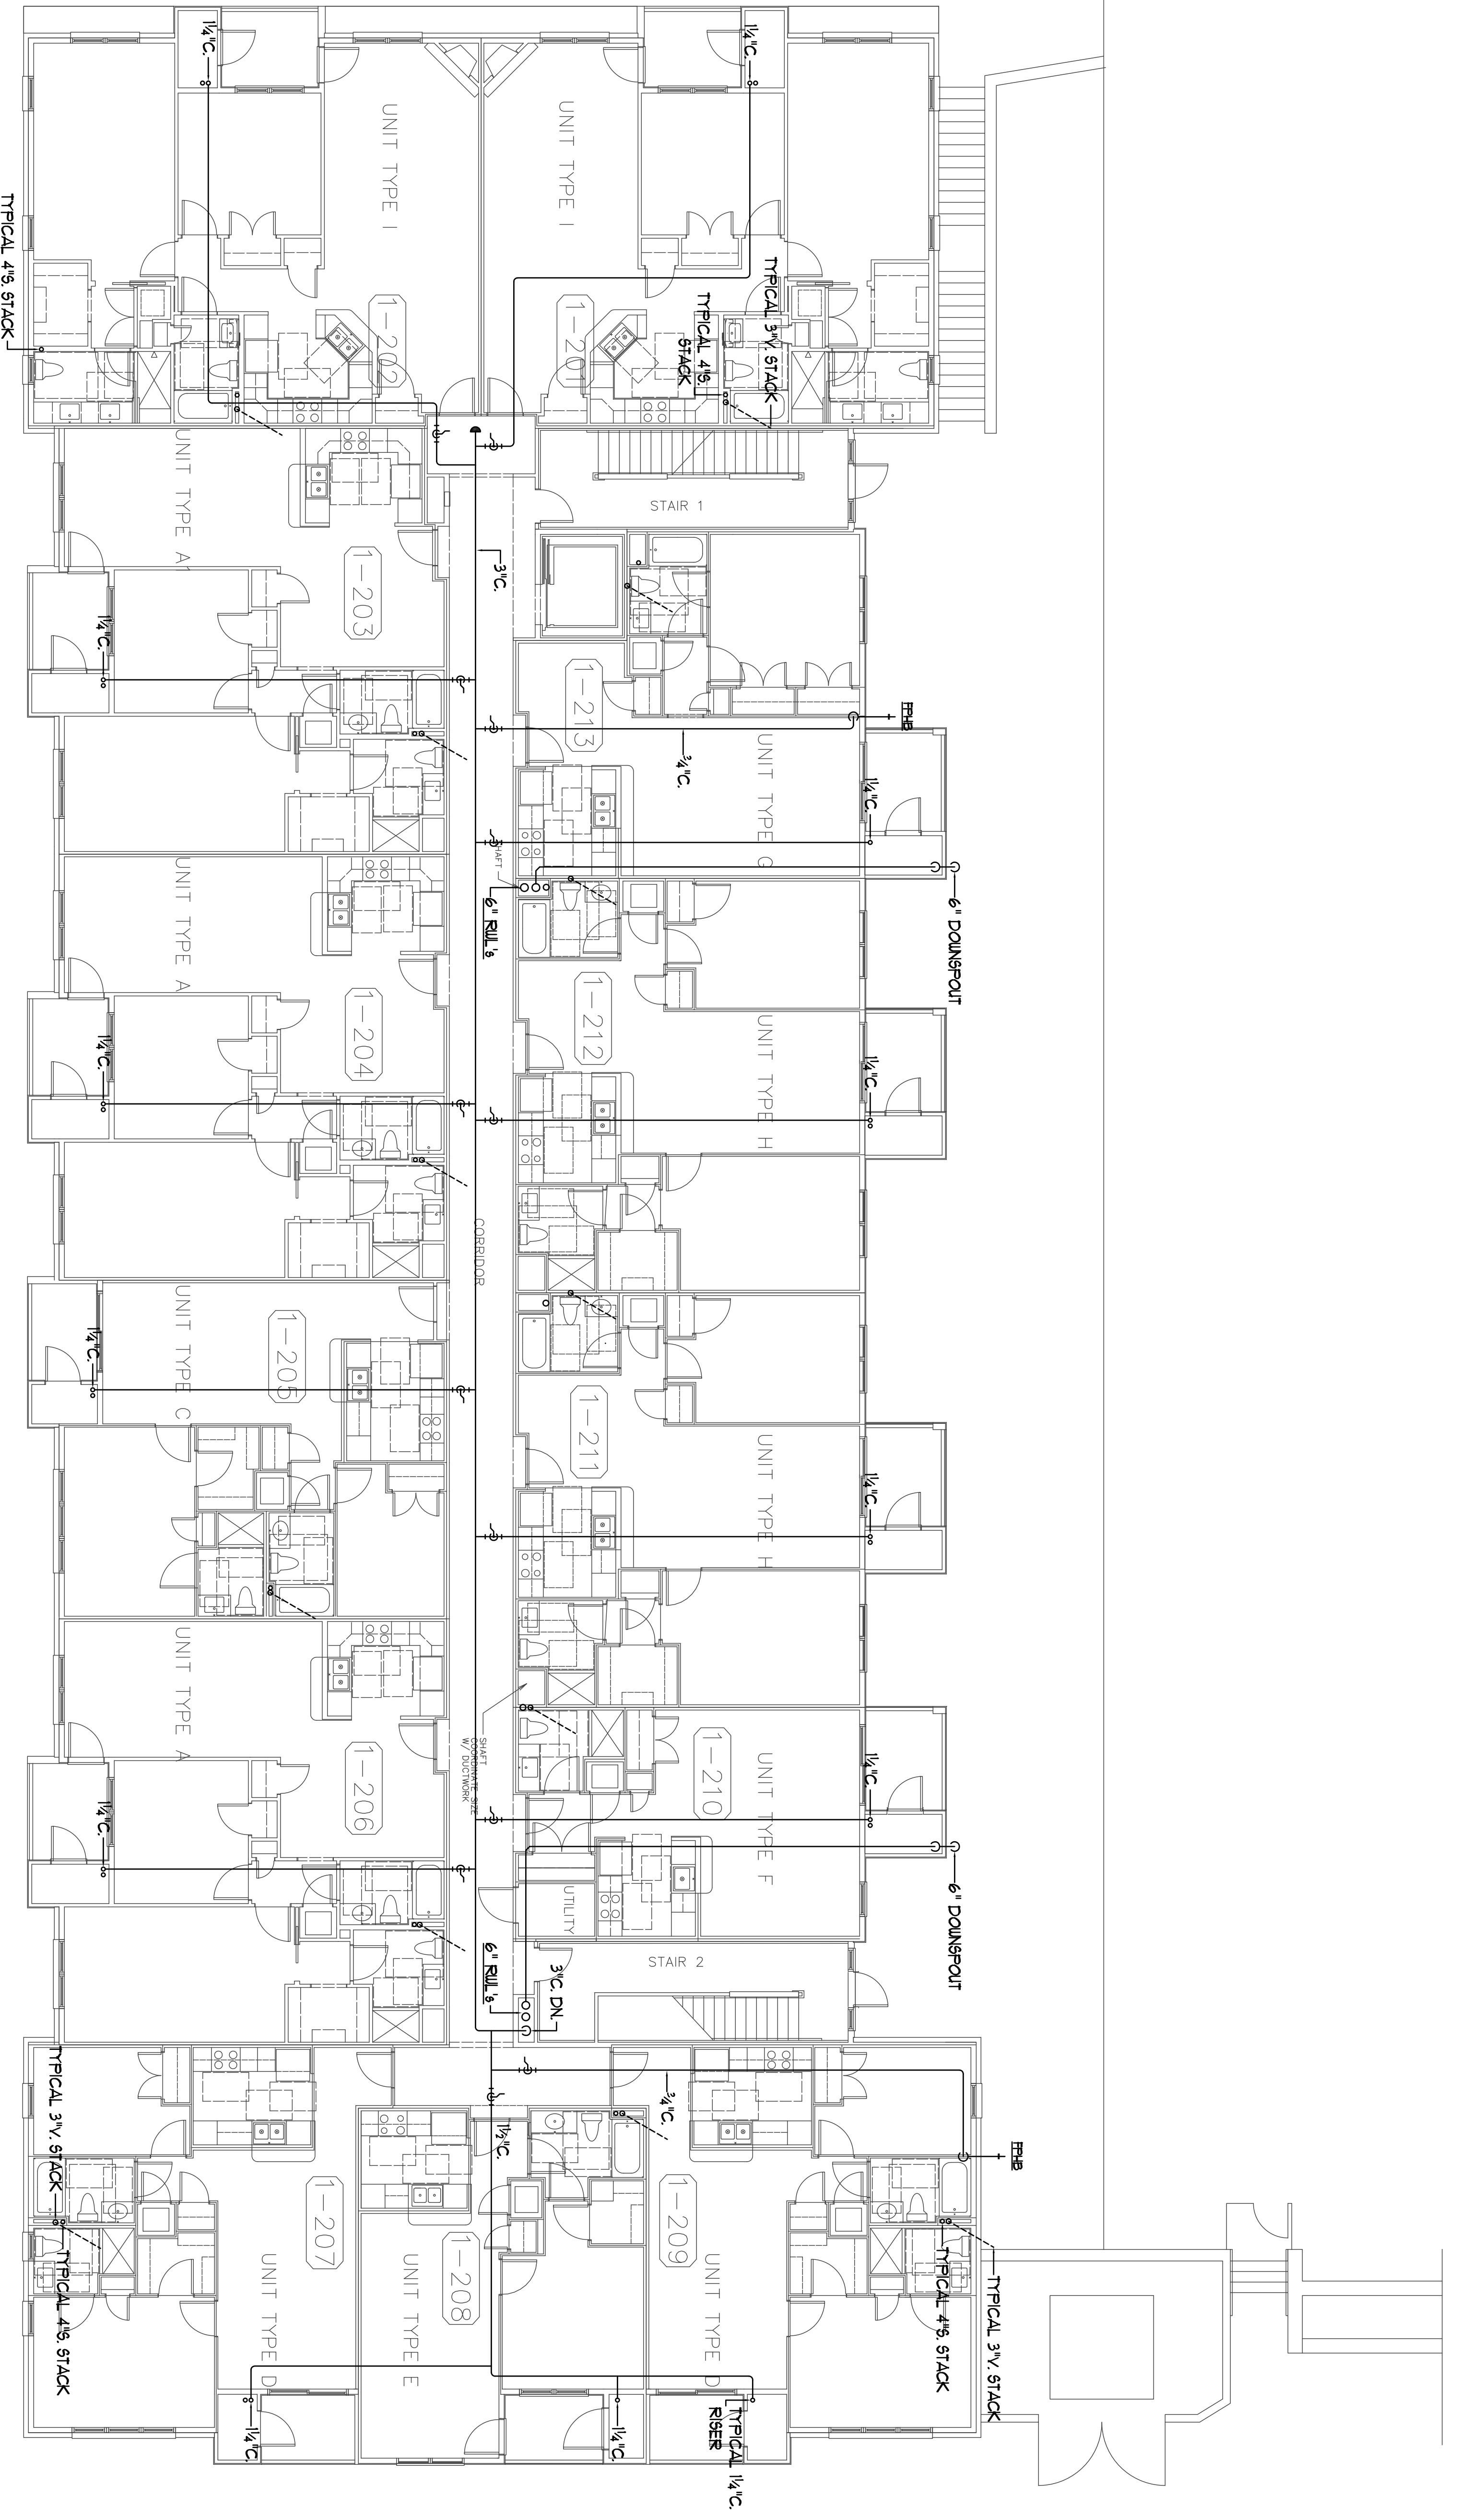

2nd FLOOR PLAN
BUILDING 1
SCALE: 1/8" = 1'-0"

**Atlantic Comfort
Systems, Inc.**
Mechanical Contractor • 207-284-4390
882 Hill Street, Biddeford, ME 04005
www.atlanticcomfort.com