


Revisions:  
11/29/2012 - UNDER LAB PIPING FOR  
CONSTRUCTION - FOR PERMIT.  
12/14/2012 - FOR PERMIT.

Bay House  
Portland, ME




**BENNETT  
ENGINEERING**  
MECHANICAL • ELECTRICAL  
(207) 865-9475

Job No.: 3346  
Date: 12/4/12  
Scale: 1/8" = 1'-0" or A.N.  
Drawn by: SF Doel  
Checked by: SF Doel

Drawing Title:  
Plumbing Third Floor  
Plan Building "1"

**P.3**

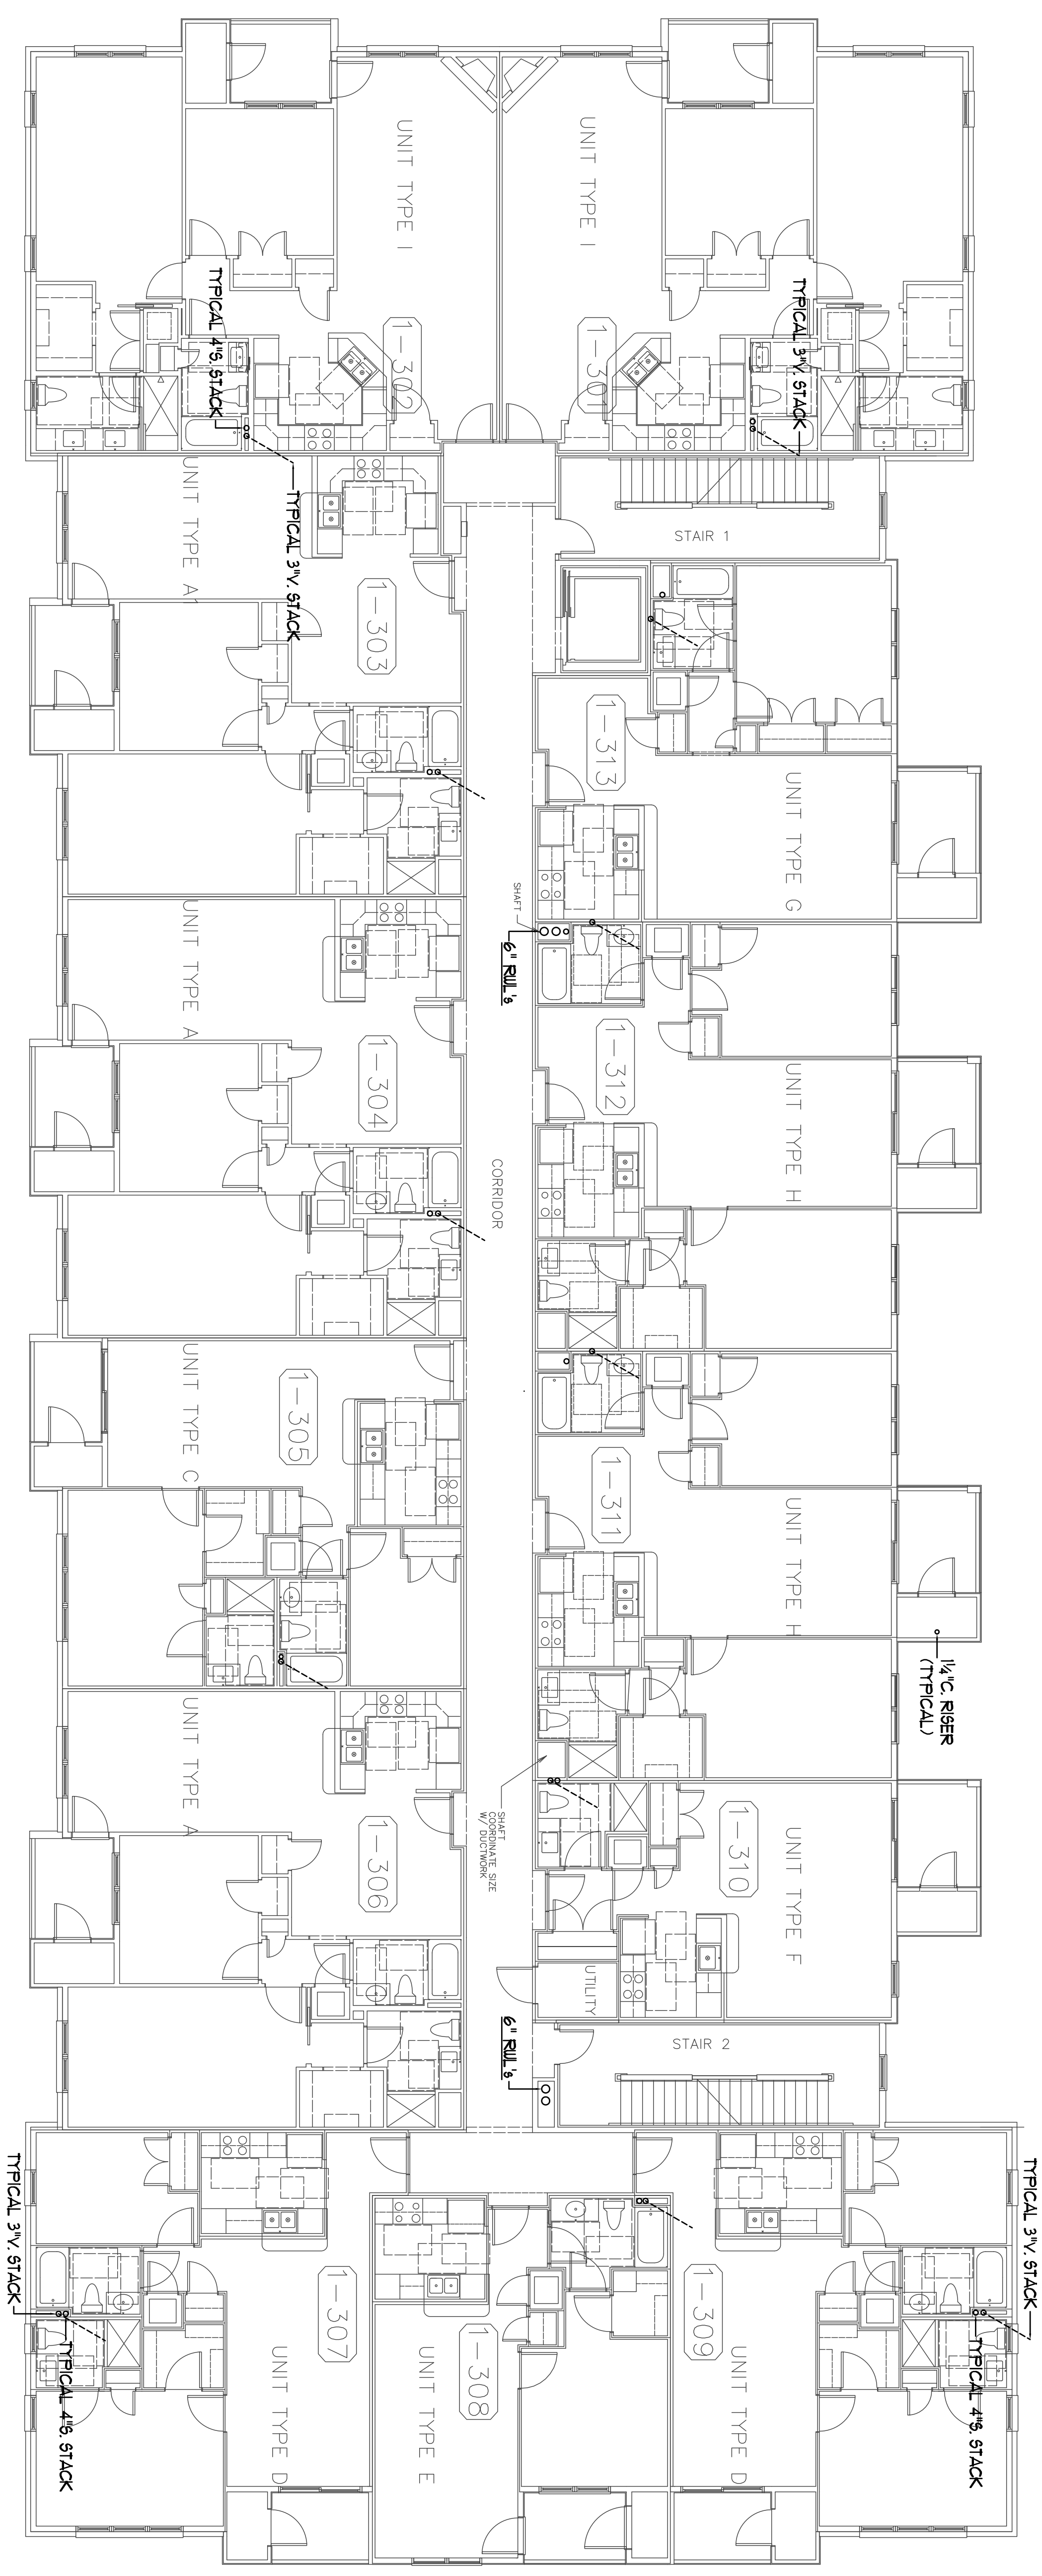

3rd FLOOR PLAN  
BUILDING 1  
SCALE: 1/8" = 1'-0"