


Revisions:  
11/29/2012-INDERS LAB PIPING FOR  
CONSTRUCTION FOR PERMIT.  
12/14/2012- FOR PERMIT.

Bay House  
Portland, ME

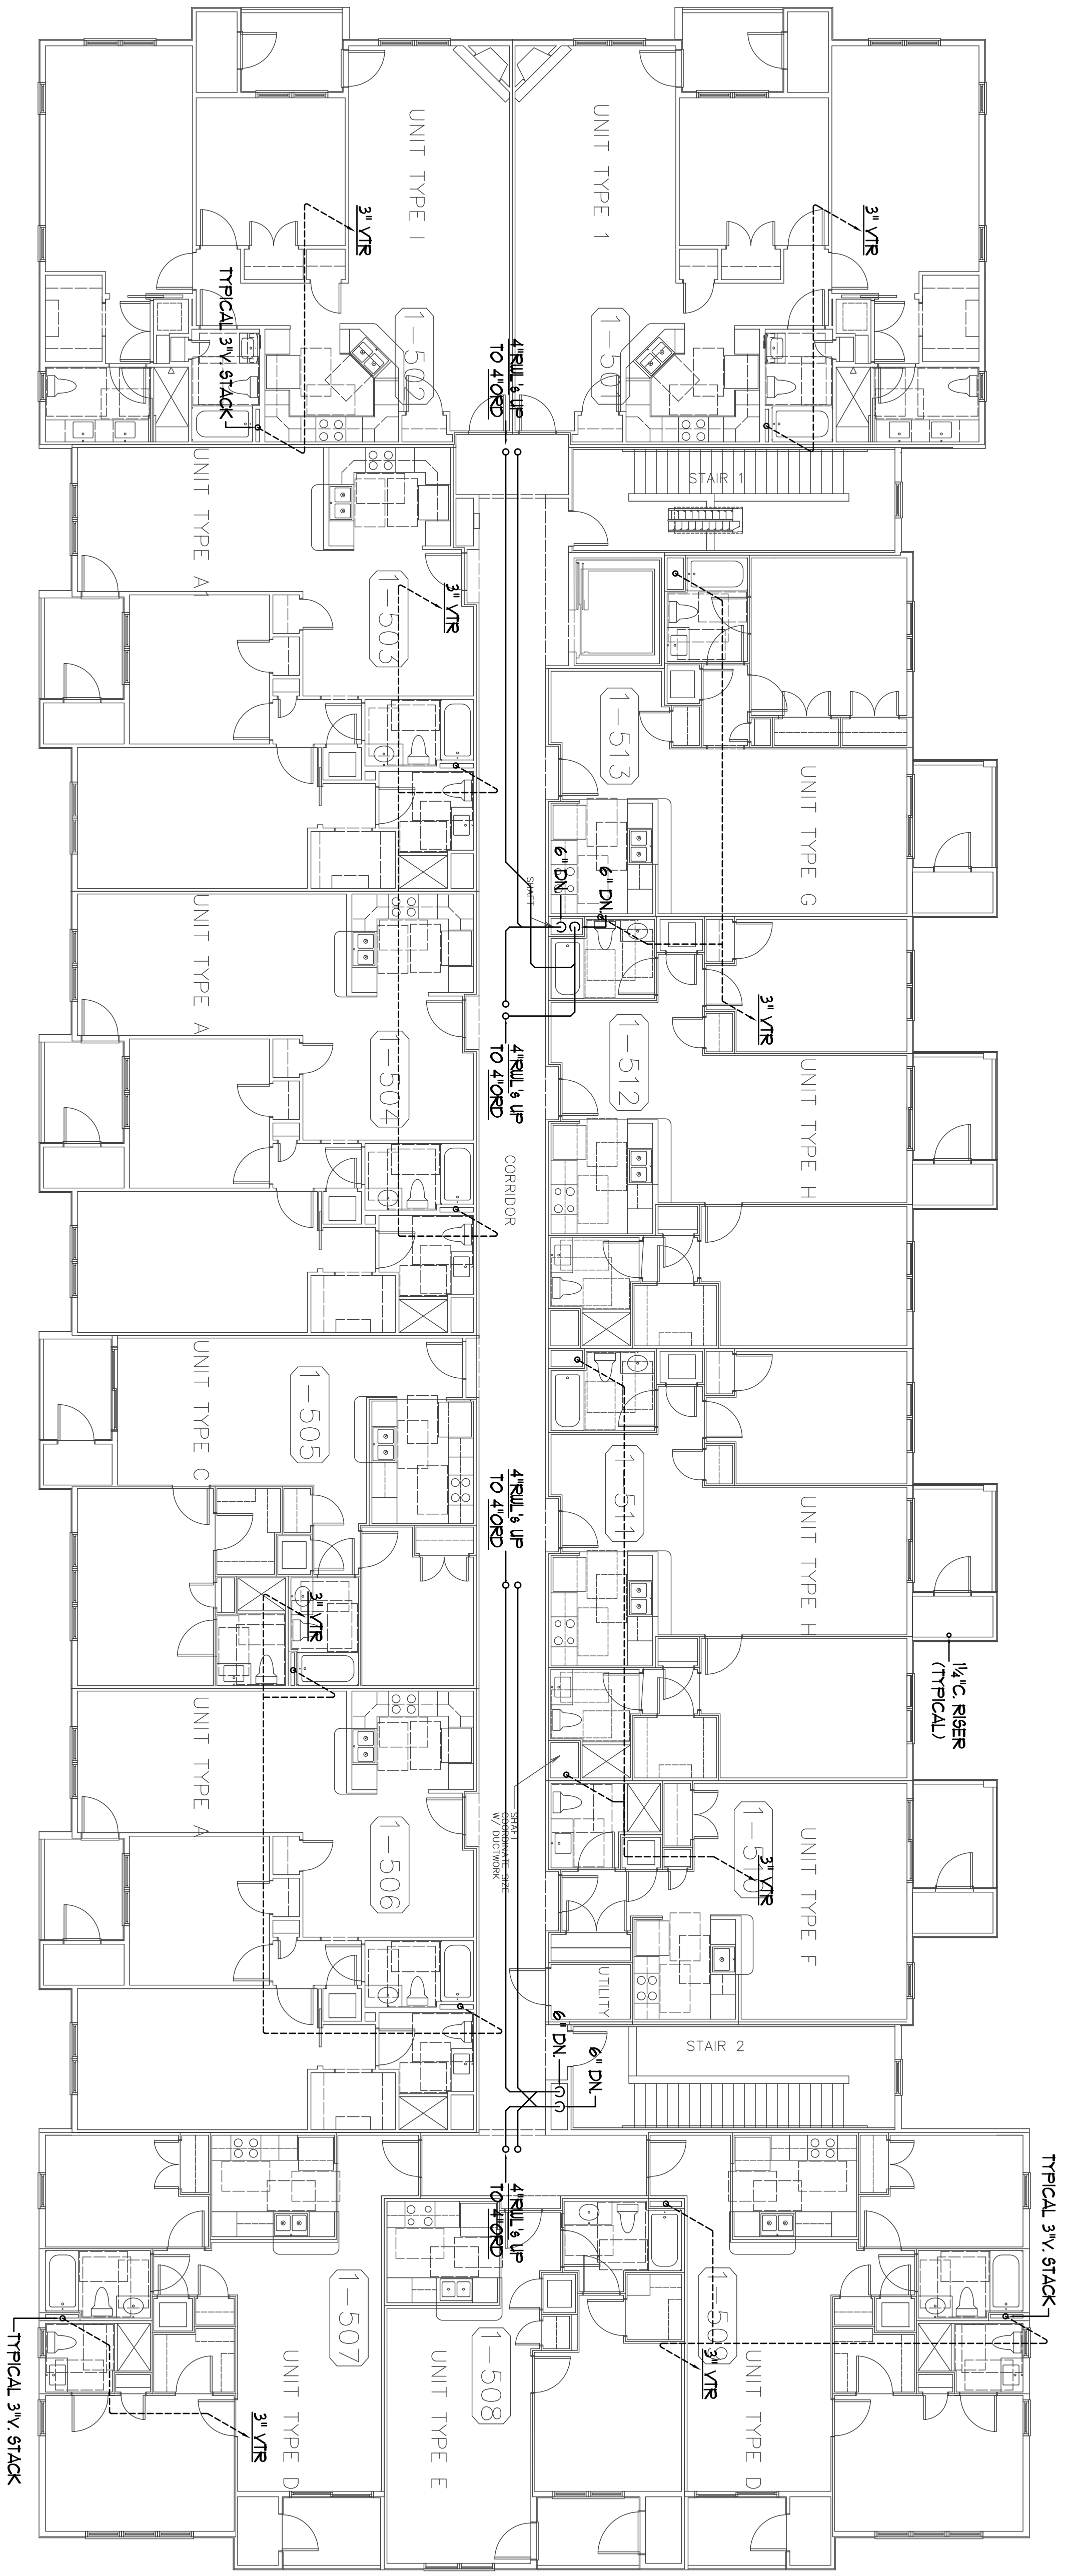

5th FLOOR PLAN  
BUILDING 1  
SCALE: 1/8" = 1' 0"

**Atlantic Comfort  
Systems, Inc.**  
Mechanical Contractor • 207-284-4390  
882 Hill Street, Biddeford, ME 04005  
www.atlanticcomfort.com

**BENNETT  
ENGINEERING**  
MECHANICAL • ELECTRICAL  
(207) 865-9475

Job No.: 3346  
Date: 12/4/12  
Scale: 1/8" = 1'-0" or A.N.  
Drawn by: SF Doel  
Checked by: SF Doel

Drawing Title:  
Plumbing Fifth Floor  
Plan Building "1"

**P.5**