

Corey Electric
609 Main Street #3
Westbrook, ME 04092

Bartlett Design
LIGHTING & ELECTRICAL ENGINEERING
342 WASHINGTON STREET, PORTLAND, ME 04103
TEL: (207) 443-3447 FAX: (207) 443-3586

THE VILLAGE AT OCEANGATE, LLC
c/o Atlas Investments Group
35 Fay Street Suite 5-2
Boston, MA 02118

THE BAY HOUSE
Middle Street
Portland, Maine


Electrical Site Plan
Scale: As Noted
Commission No: 11-013
Date: November 29, 2012

REVISIONS:

DRG. NO.

E0.3


- DRAWING E0.3 NOTES:**
- WHERE INDICATED, EXISTING UTILITY POLE SHALL REMAIN.
 - WHERE INDICATED, EXISTING OVERHEAD AND/OR UNDERGROUND UTILITY LINES SHALL REMAIN.
 - WHERE INDICATED, EXISTING UTILITY POLE SHALL BE REMOVED.
 - WHERE INDICATED, EXISTING OVERHEAD AND/OR UNDERGROUND UTILITY LINES SHALL BE REMOVED.
 - WHERE INDICATED, COORDINATE WITH CMP TO MODIFY EXISTING UTILITY POLE AS NEEDED.
 - WHERE INDICATED, PROVIDE NEW MANHOLE STRUCTURES AS REQUIRED. SEE DETAIL SHEET E0.4.
 - WHERE INDICATED, PROVIDE NEW UNDERGROUND ELECTRICAL PRIMARY, TELEPHONE, AND CABLE TV SERVICES.
 - WHERE INDICATED, PROVIDE NEW UNDERGROUND ELECTRICAL SECONDARY SERVICE.
 - WHERE INDICATED, PROVIDE NEW UNDERGROUND TELEPHONE AND CABLE TV SERVICES.
 - WHERE INDICATED, ARRANGE WITH UTILITY COMPANY TO PROVIDE NEW PRIMARY SERVICE RISER POLE.
 - WHERE INDICATED, PROVIDE NEW UNDERGROUND 120V, 1PH, 2W, PLUS GROUND SERVICE TO EXISTING UTILITY POLE TO NEW STREET LIGHTING SERVICE.
 - WHERE INDICATED, PROVIDE NEW UNDERGROUND STREET LIGHTING CIRCUIT CONSISTING OF 2 #2, 1 #8GND, IN A 1-1/2" CDT.
 - TYPICAL FOR TYPE MS2 LIGHTING POLES. PROVIDE NEW STREET LIGHT PER CITY OF PORTLANDS 'BAYSIDE' MEDIUM SCALE LIGHTING POLE. RUN SERVICE CONDUIT BEHIND TREE WELLS. COORDINATE WITH CITY OF PORTLAND PUBLIC SERVICES.

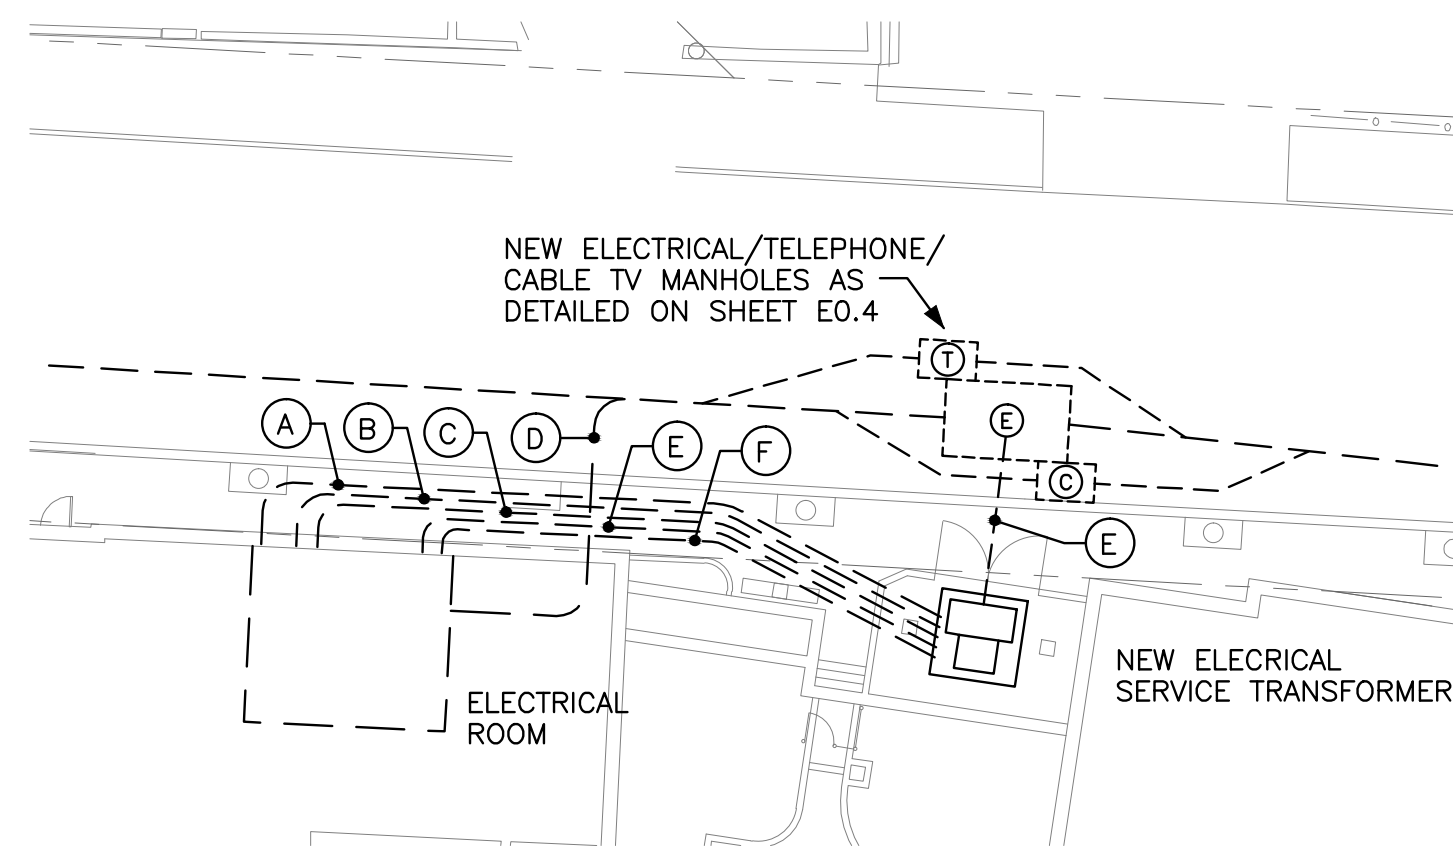


SERVICE ENTRANCE CONDUIT SCHEDULE

A.	(2) 4" CDTs	- ELEC SECONDARY RETAIL 4/5/6
B.	(2) 4" CDTs	- ELEC SECONDARY RETAIL 1/2/3
C.	(5) 4" CDTs	- ELEC SECONDARY PARKING GARAGE & BUILDING #1
D.	(3) 4" CDTs	- ELEC SECONDARY BUILDING #2
E.	(2) 5" CDTs	- ELEC PRIMARY
F.	(2) 4" CDTs	- TELEPHONE SERVICE, FAIRPOINT
	(2) 4" CDTs	- CABLE TV SERVICE, TIME WARNER

ELECTRICAL SERVICE ENTRANCE DETAIL PLAN
1" = 10'-0"

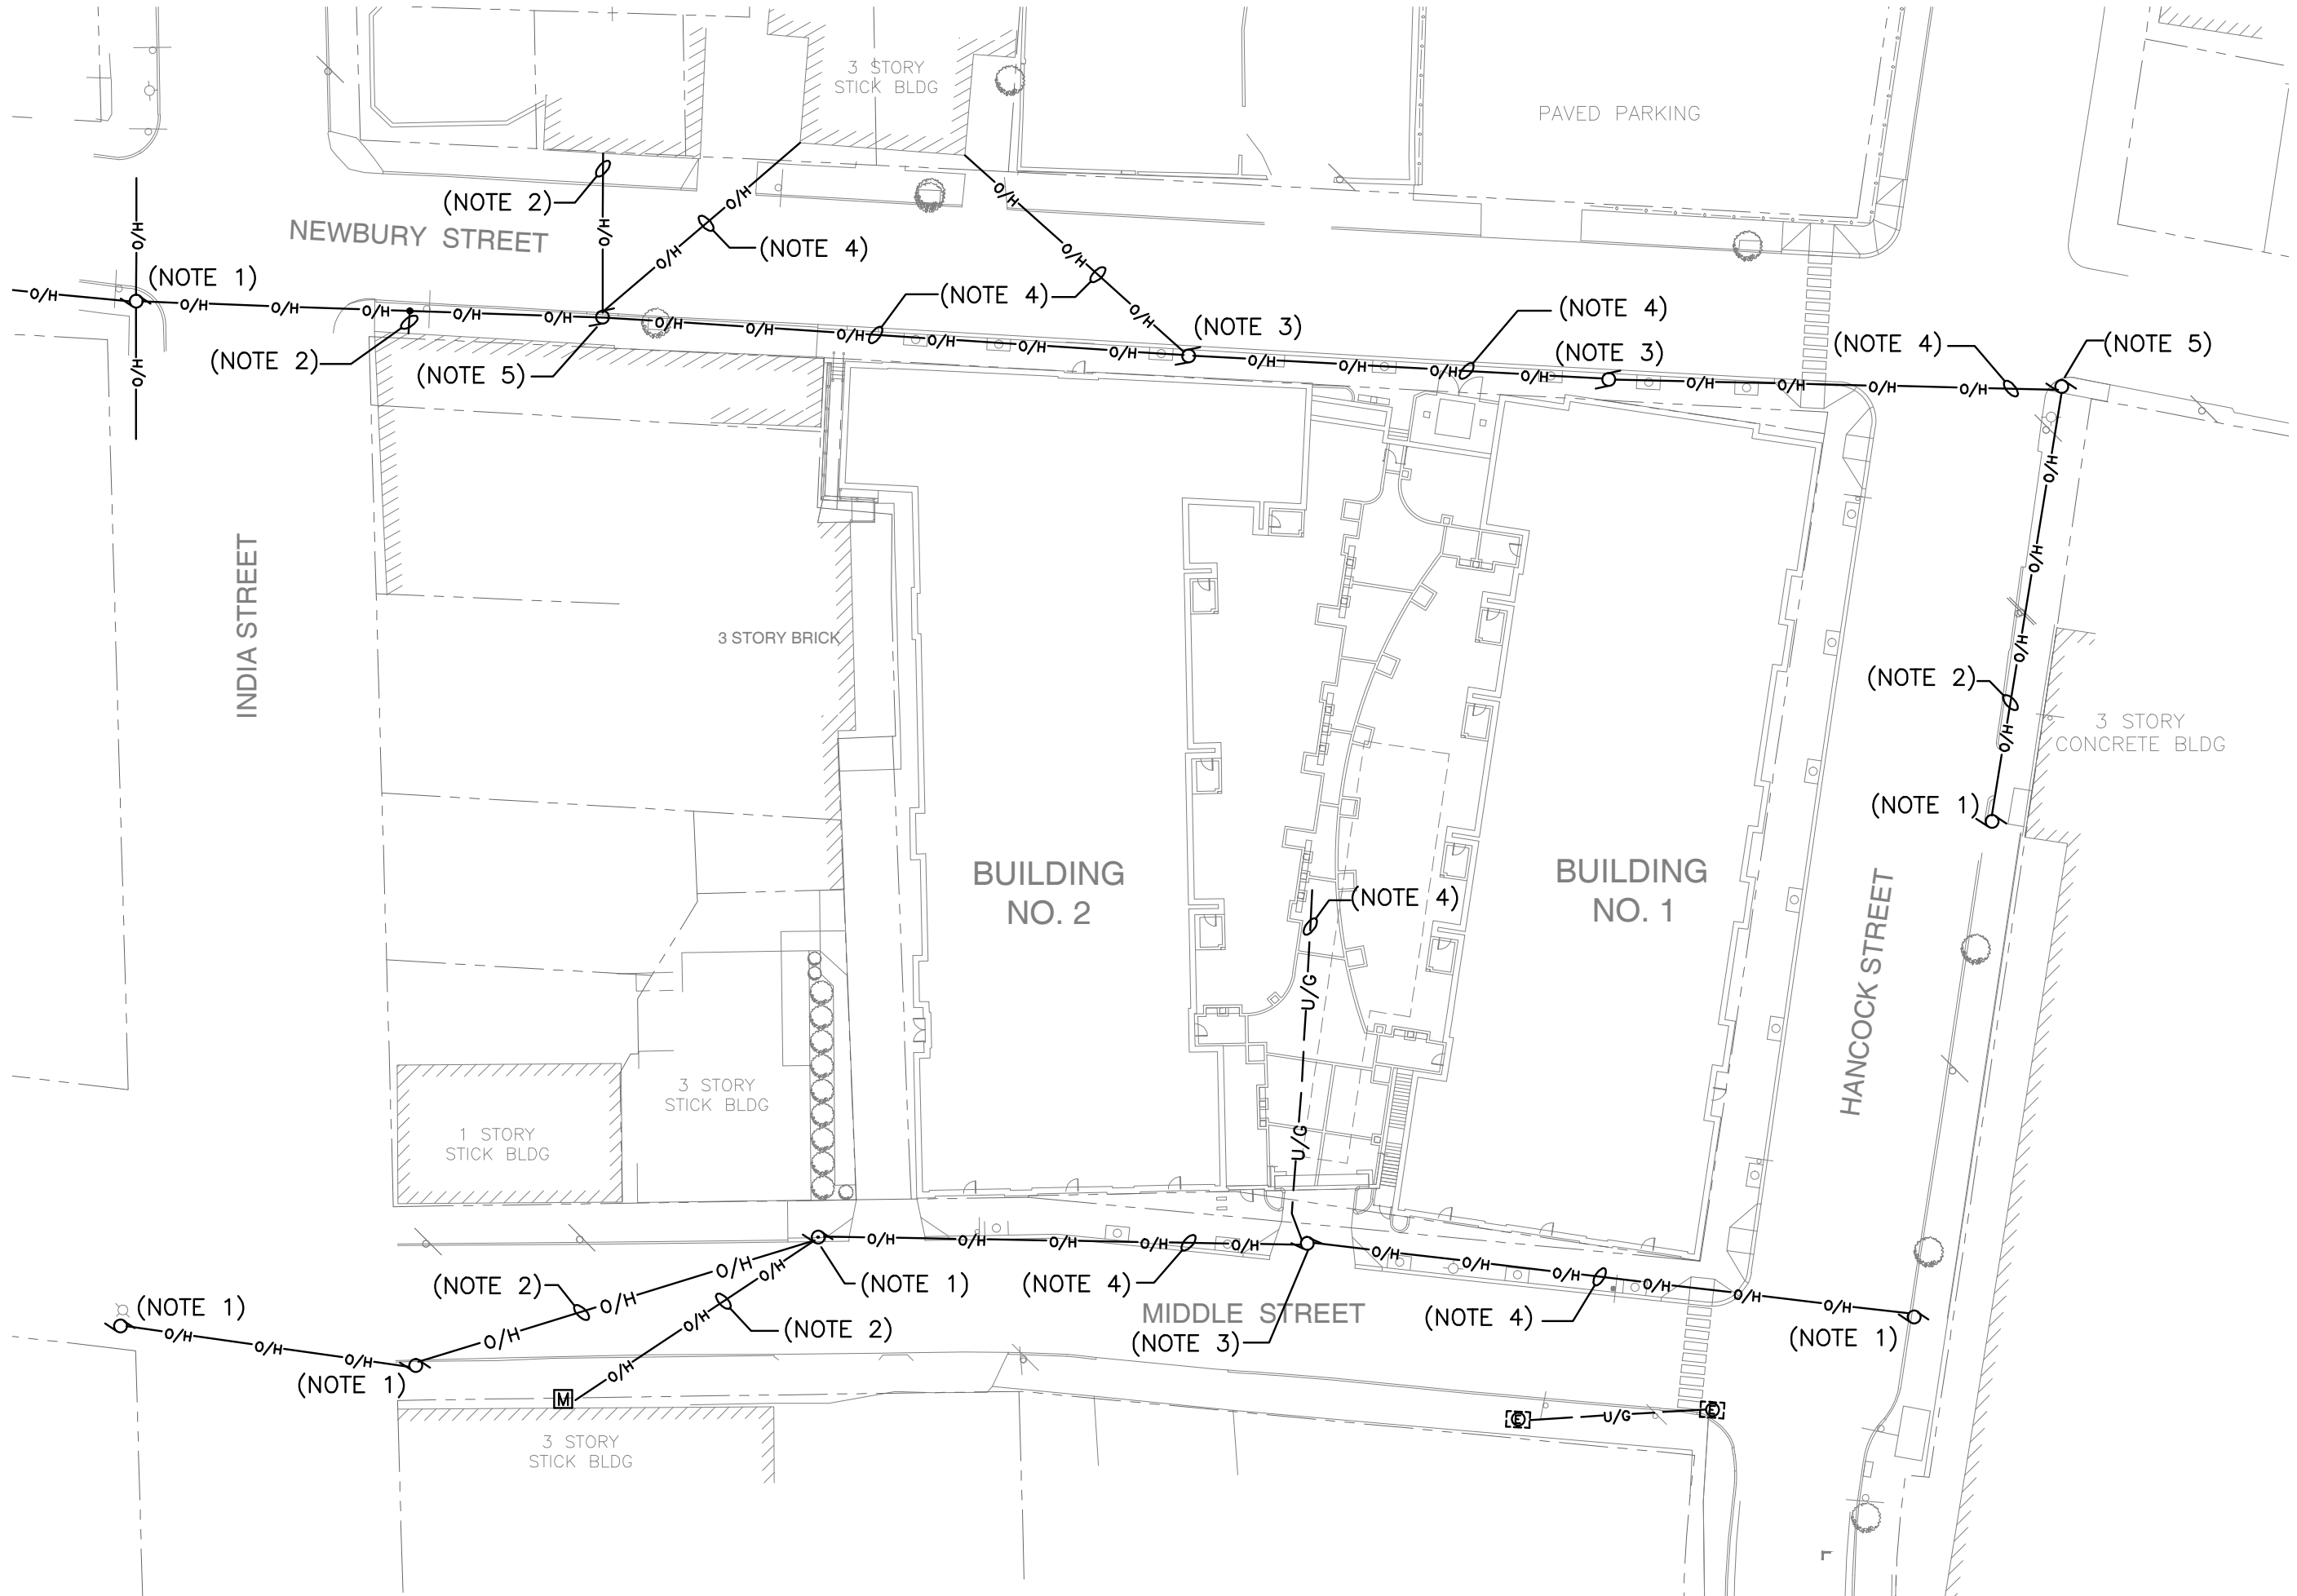

ELECTRICAL REMOVALS PLAN
1" = 40'-0"

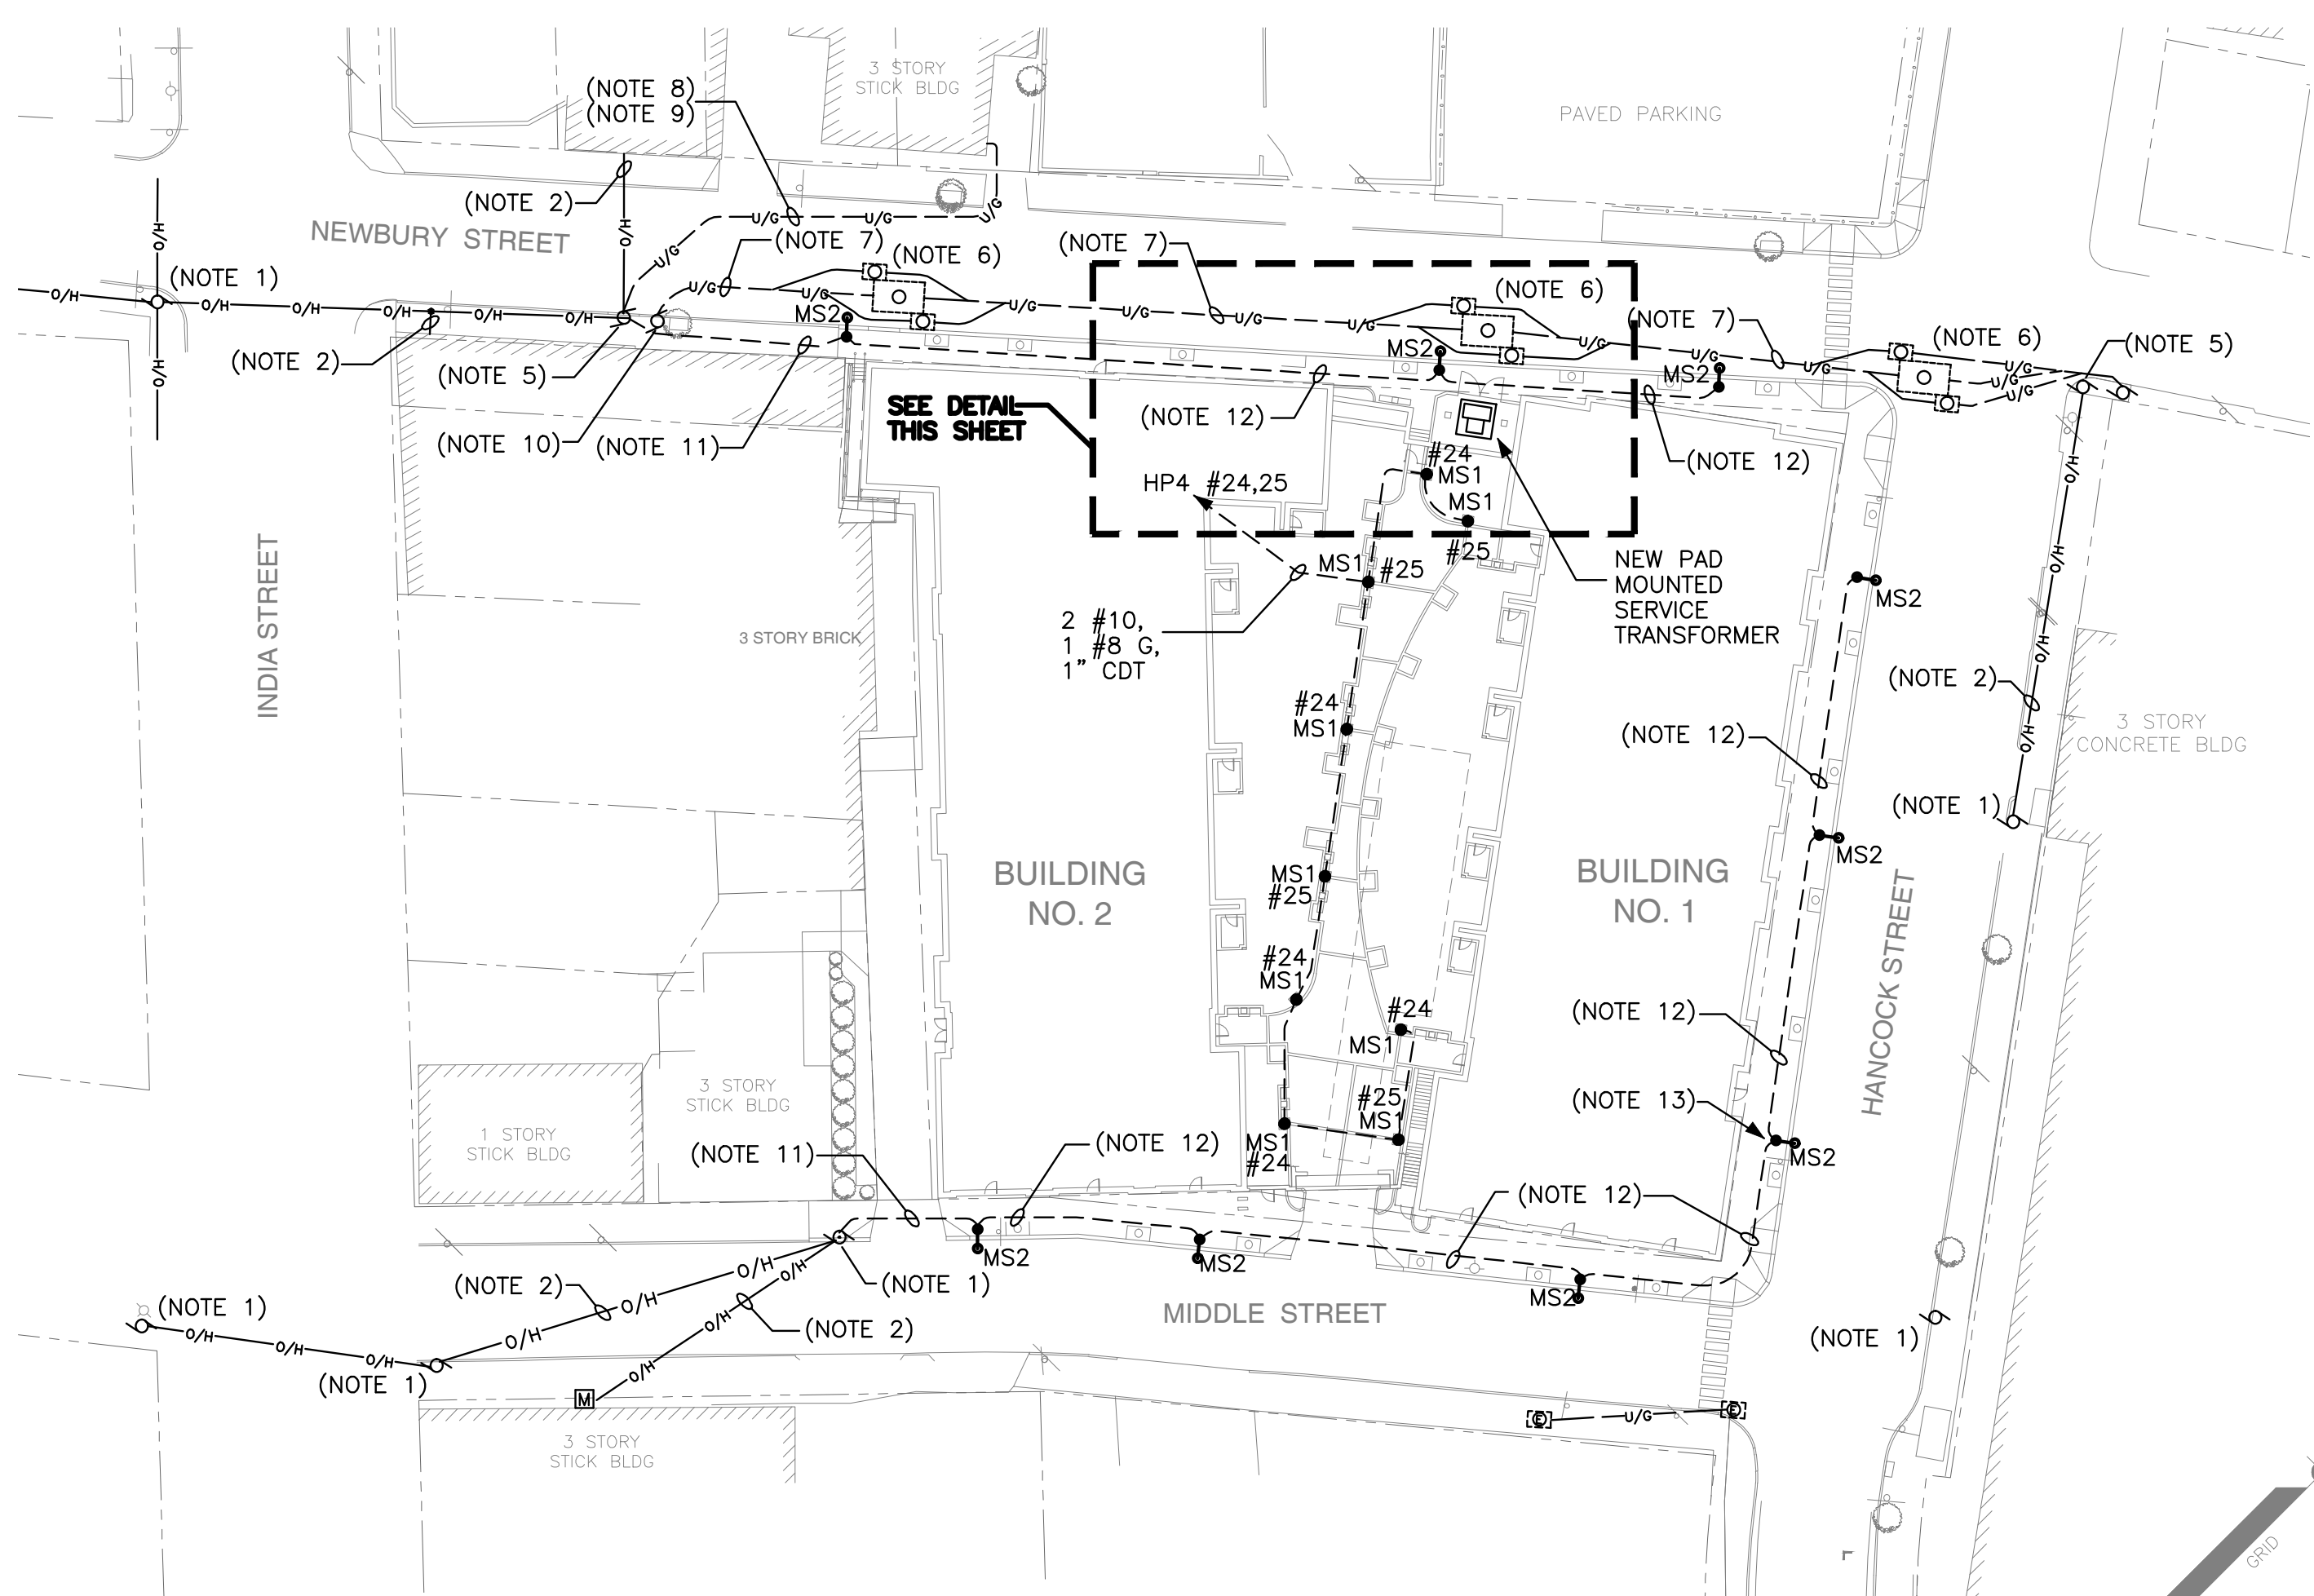

PROPOSED ELECTRICAL SITE PLAN
1" = 40'-0"

