



ROOF PLAN BUILDING 2

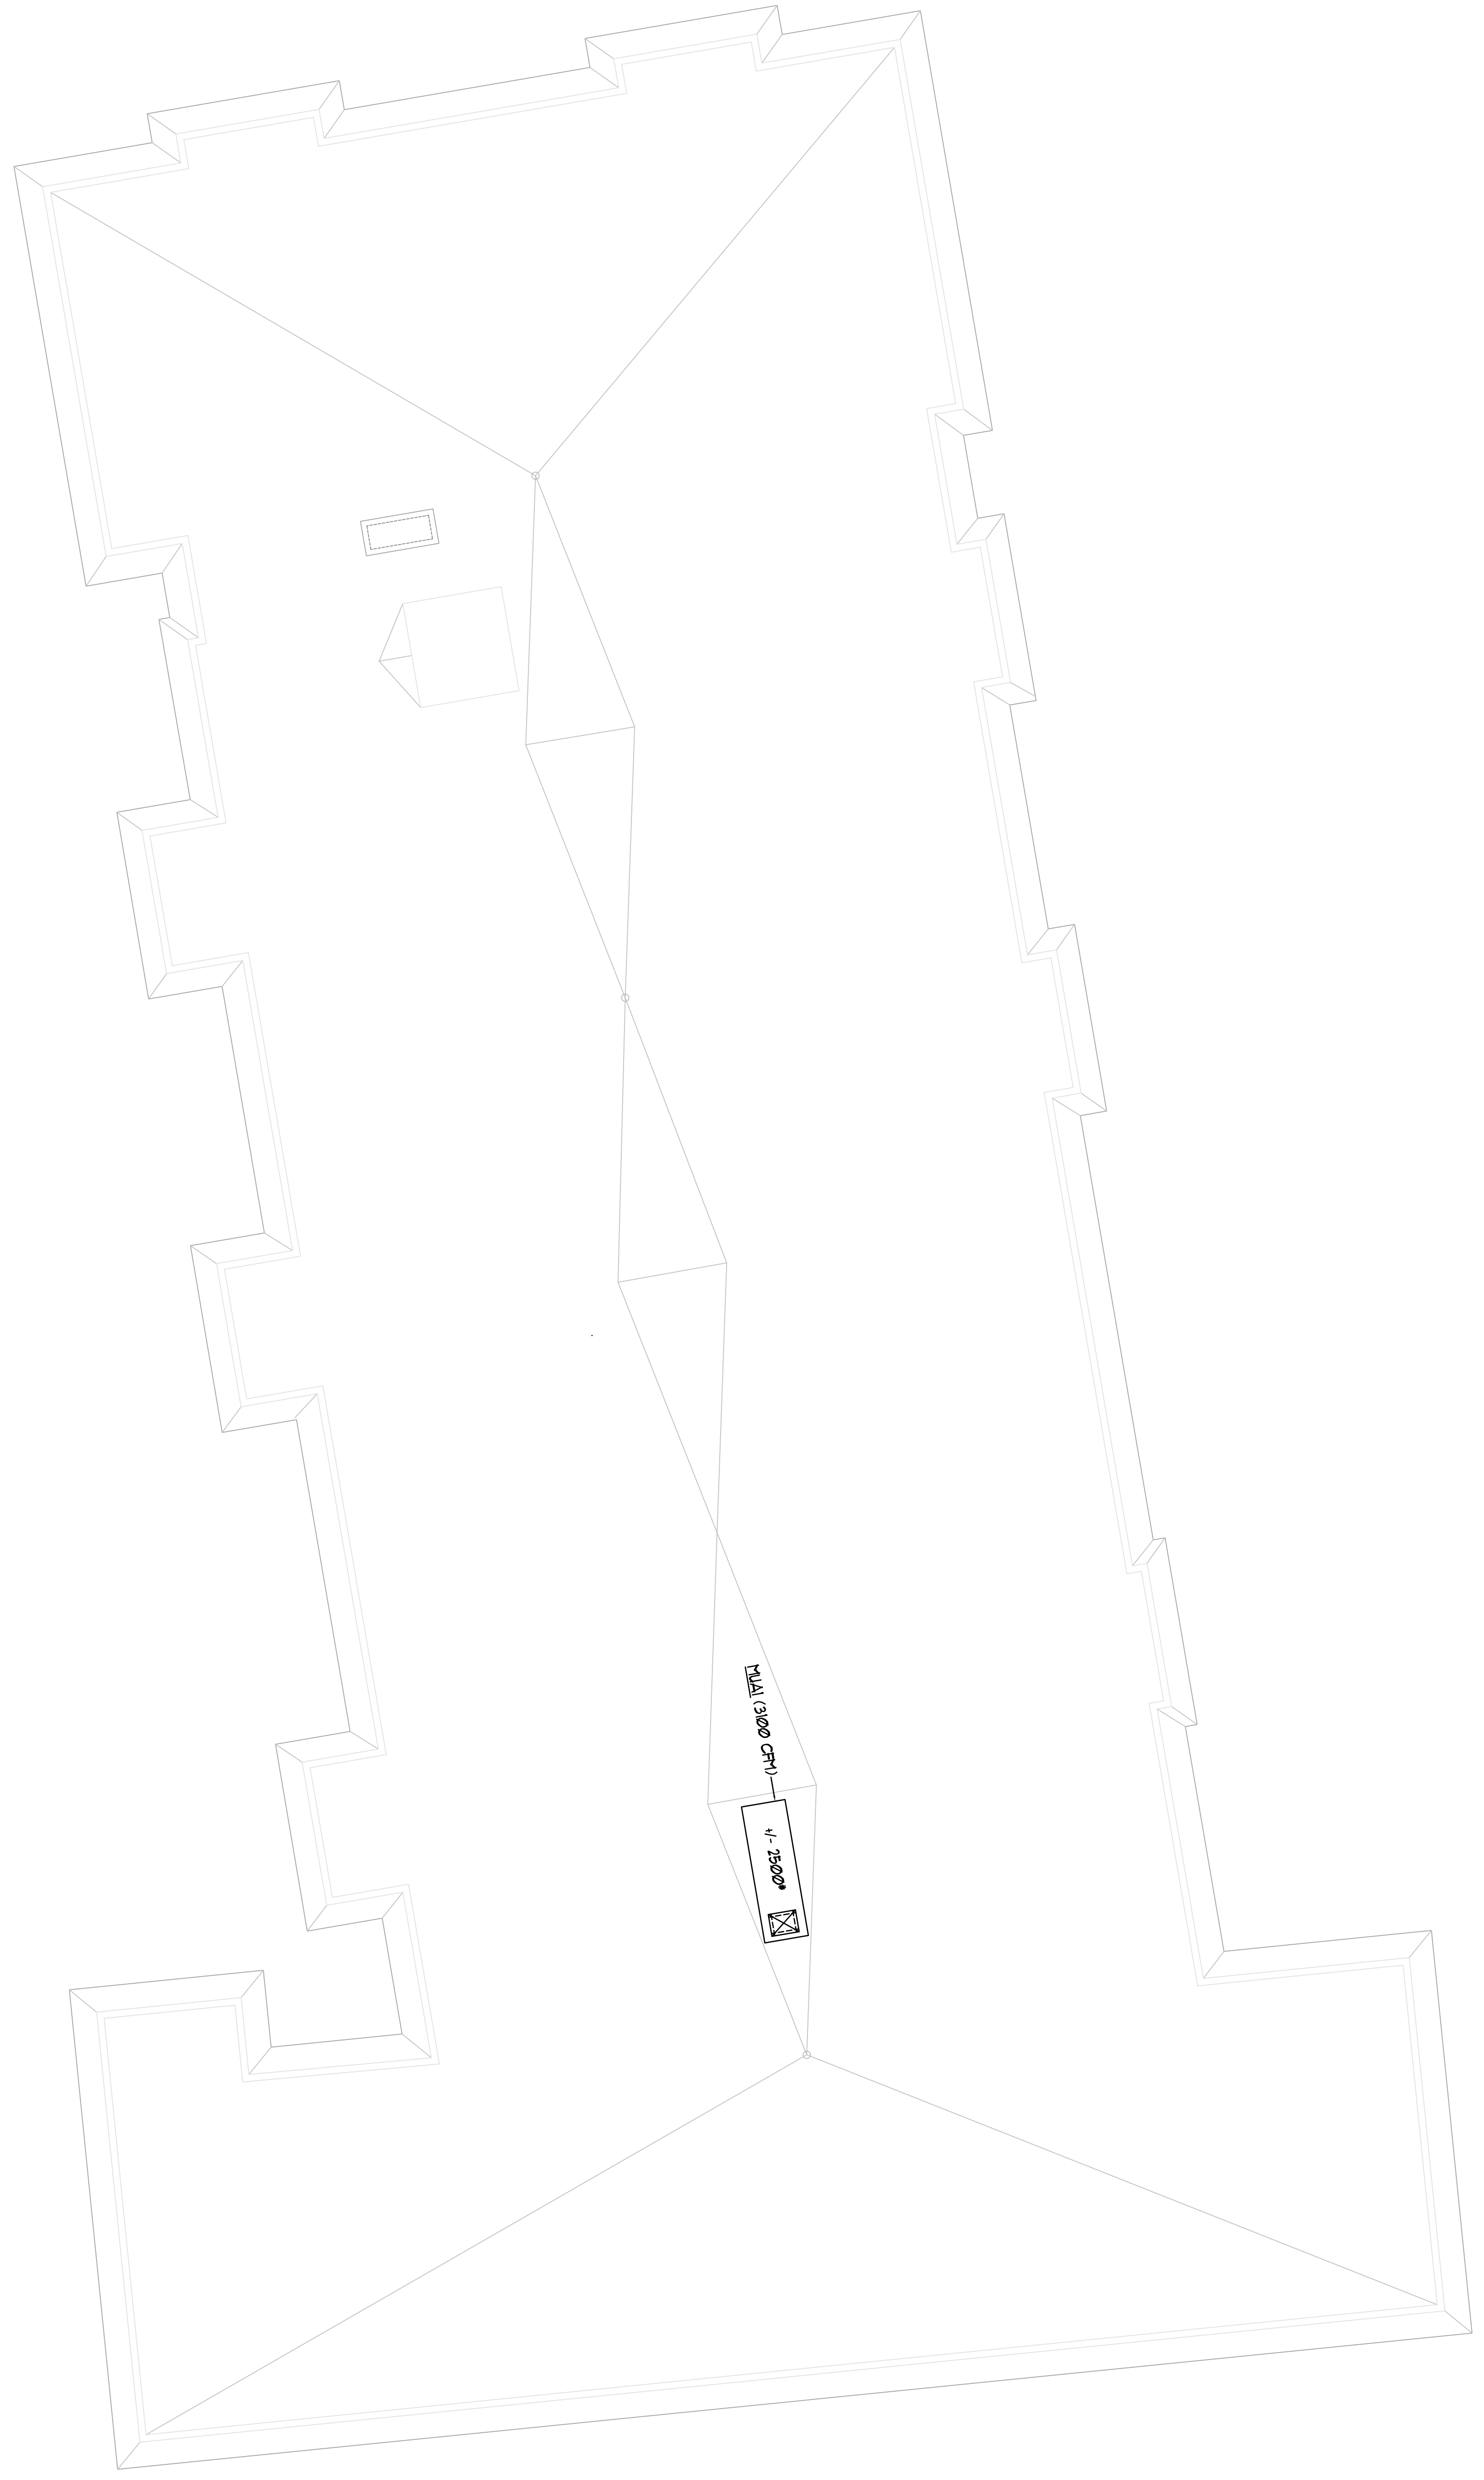

Revisions
 11/29/2012 - UNDER LAB PIPING FOR
 CONSTRUCTION
 12/14/2012 - FOR PERMIT
 1/14/2013 - PLUMBING REVISIONS
 2/6/2013 - 100% FOR REVIEW
 and Comment

 
Bay House
 Portland, ME



**BENNETT
 ENGINEERING**
 MECHANICAL • ELECTRICAL
 (207) 865-9475

Job No.: 3346
 Date: 12/14/12
 Scale: 1/8" = 1'-0" or A.N.
 Drawn by: SF Deel
 Checked by: SF Deel

Drawing Title:
 HVAC Roof Plan
 Building "2"



Atlantic Comfort
 Systems, Inc.
 Mechanical Contractor • 207-894-4390
 892 Hill Street, Portland, ME 04105
 www.atlanticcomfort.com

M.12